
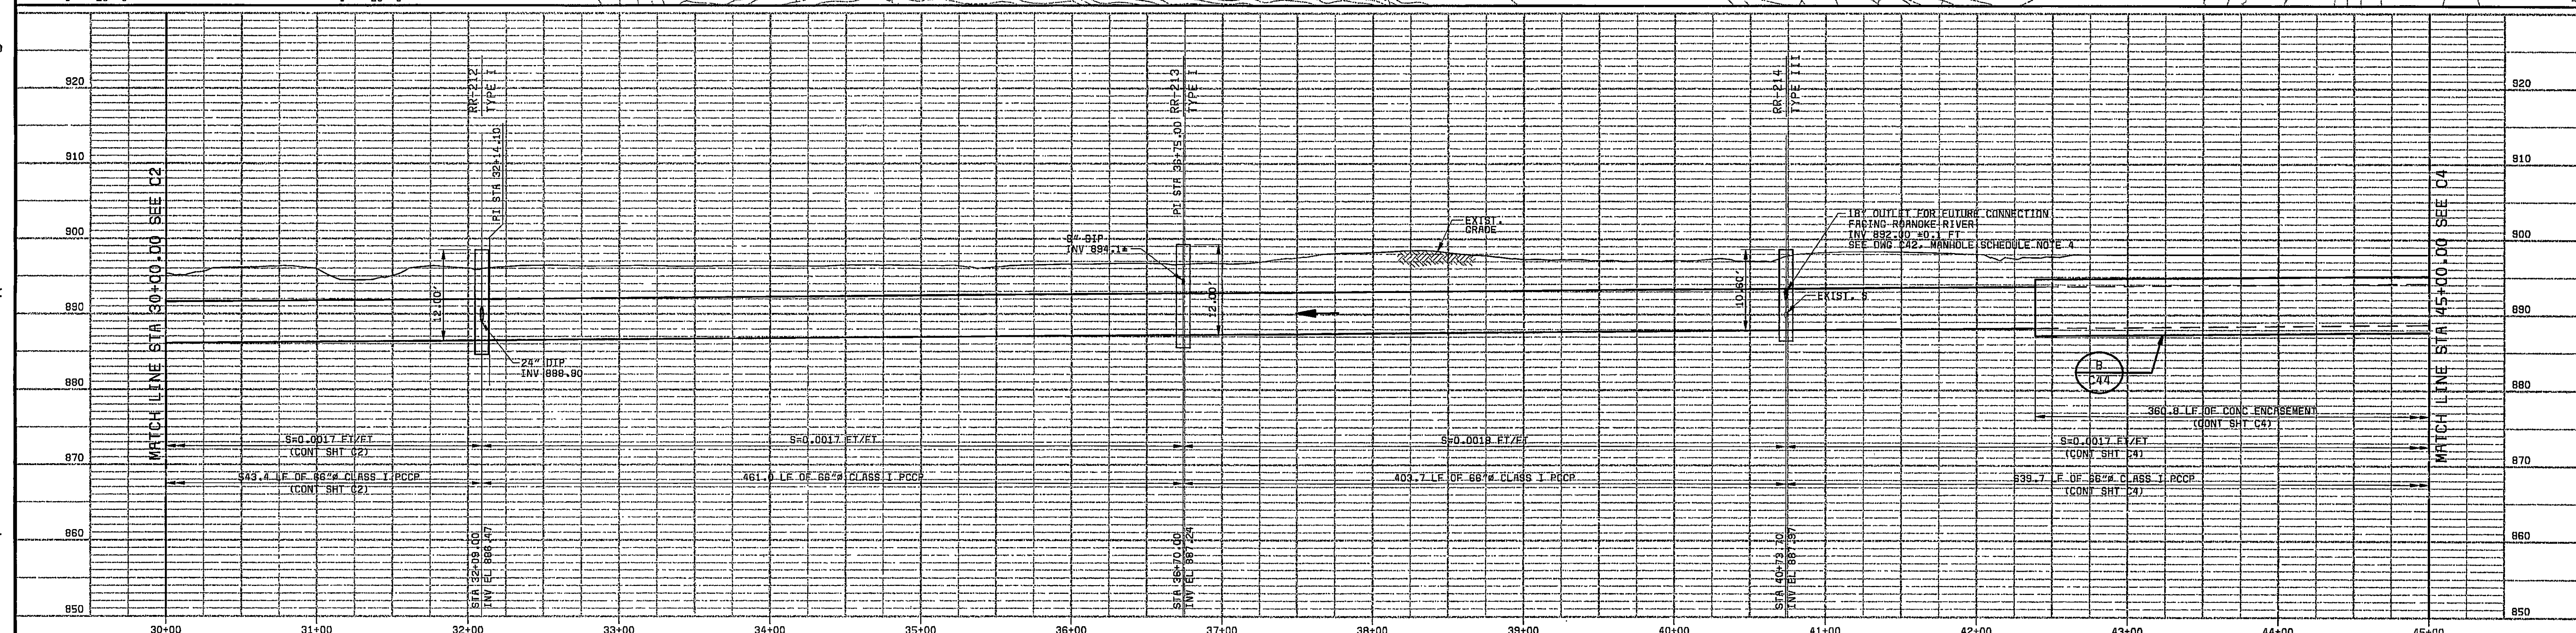


26444-300-WK03-C-90000001.D
G1031
F000000

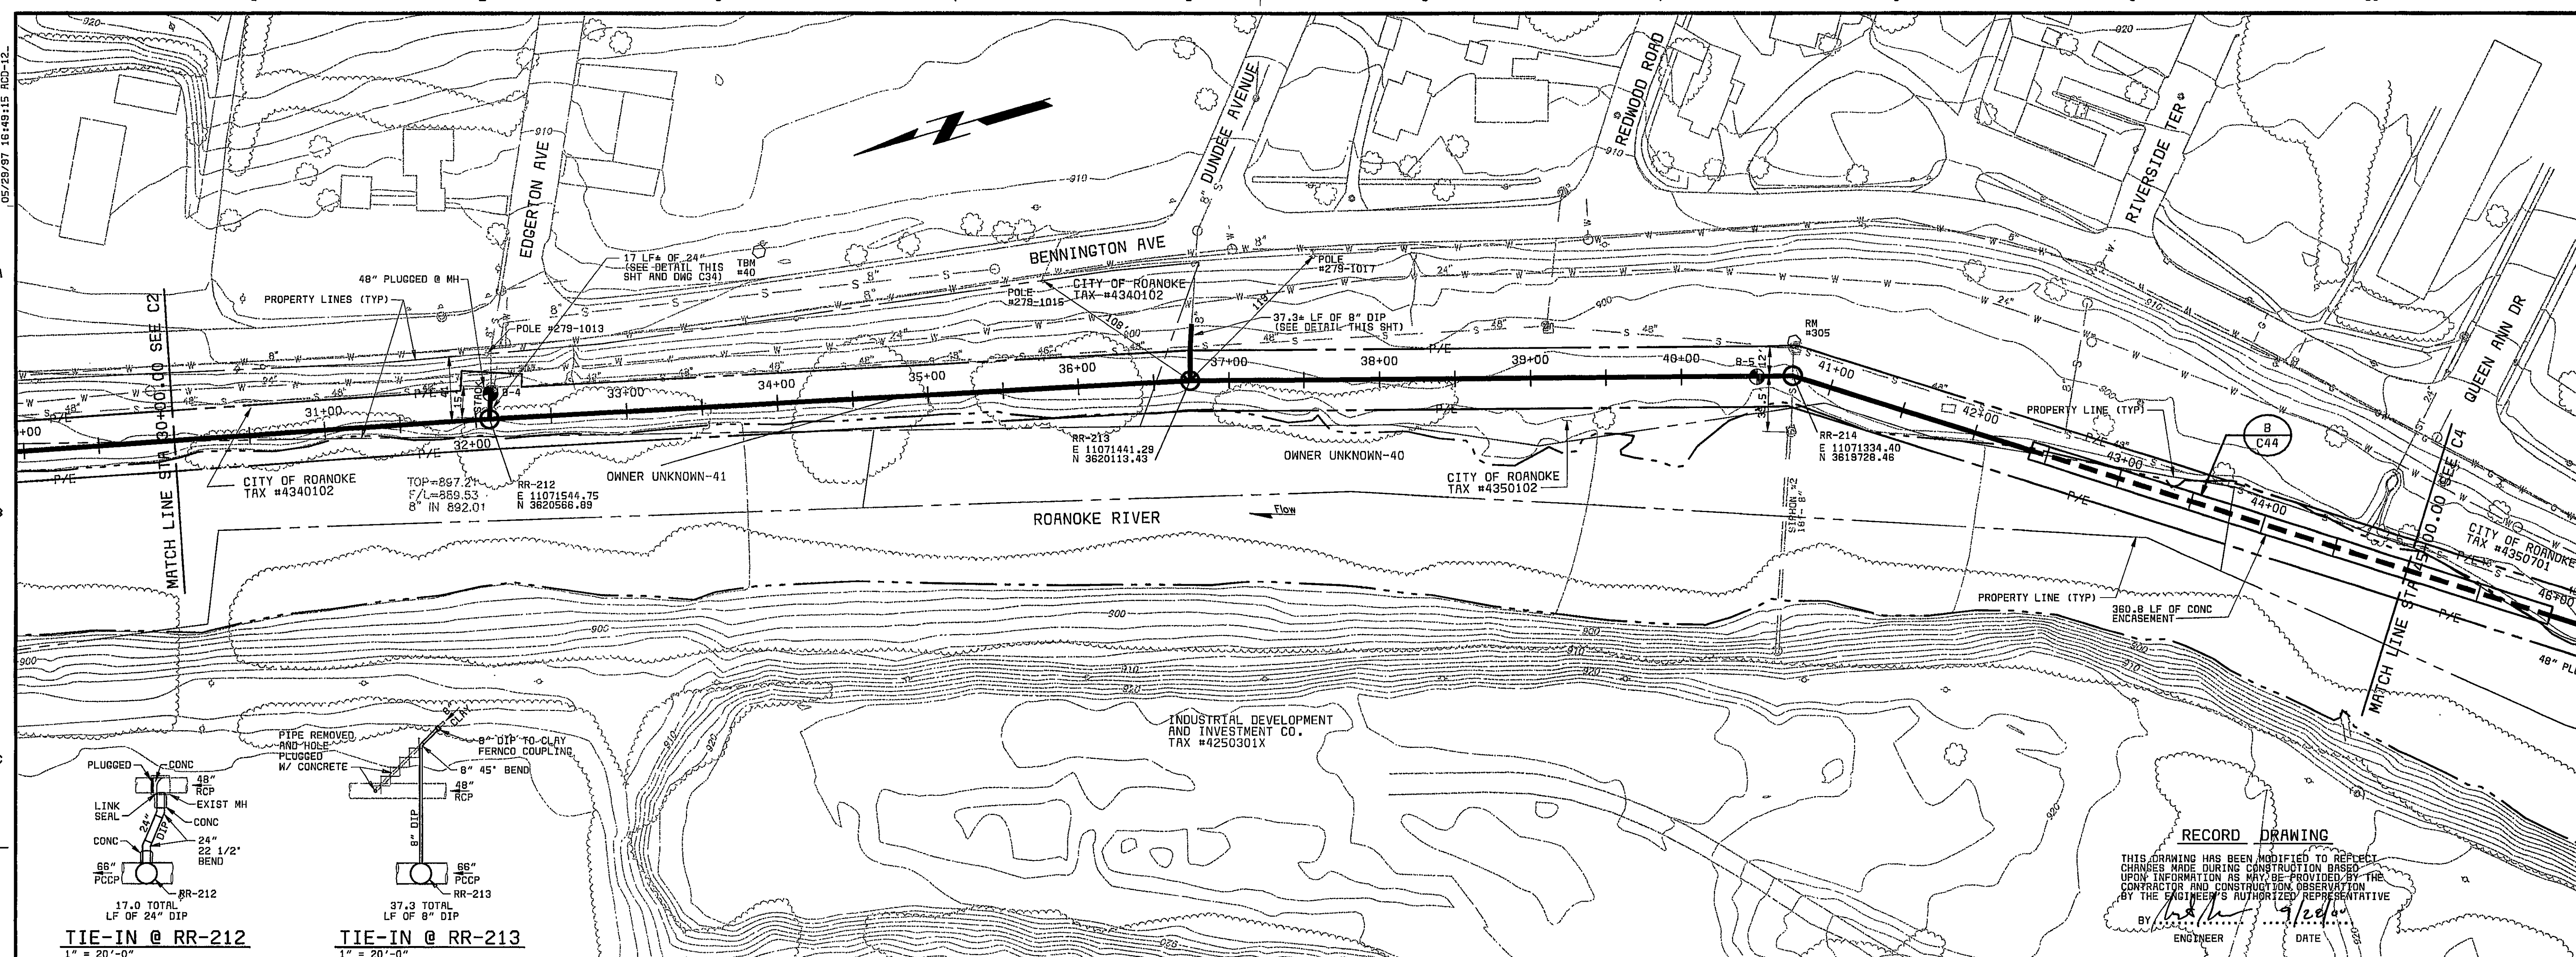

MANHOLE STATIONING AND PIPE LENGTHS: SEE GENERAL NOTE 16		PCCP PIPE CLASS INFORMATION: SEE DRAWING C43		SCALE: 1" = 50' HORIZ 1" = 10' VERT		CITY OF ROANOKE, VIRGINIA ROANOKE RIVER INTERCEPTOR		CONTRACT A1 C3	
DESIGNED JBB, SLF		DETAILED RLC, RBW		PROJECT NO. 26444		PLAN AND PROFILE STA 30+00 TO STA 45+00		THIS DOCUMENT ORIGINALLY ISSUED AND SEALED BY BRENT M. REUSS PROFESSIONAL ENGINEER, COMMONWEALTH OF VIRGINIA REGISTRATION NO. 026345 ON 5-30-97	
CHECKED RAF		APPROVED		DATE		SHEET 6 OF 30			
DATE		REVISIONS AND RECORD OF ISSUE		NO. BY CK APP					