

26444-300-WICC-C-0000011F
01031
2600000

A

B



C

D

E

F

26444-300-WICC-C-0000011F
01031
2600000

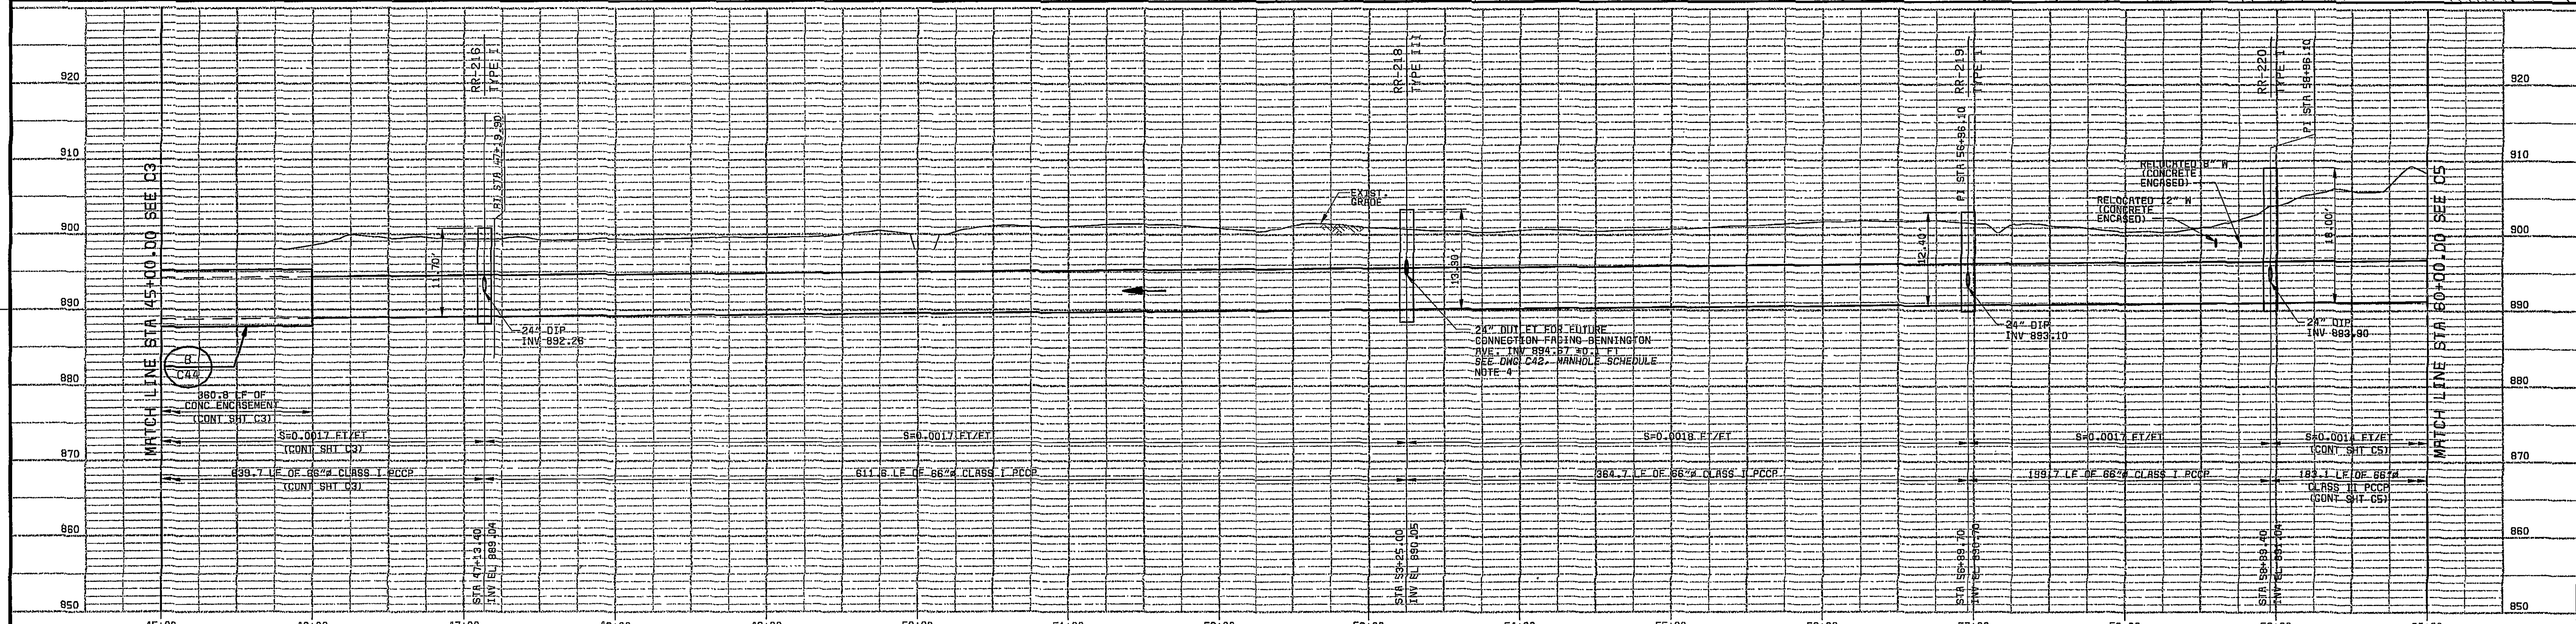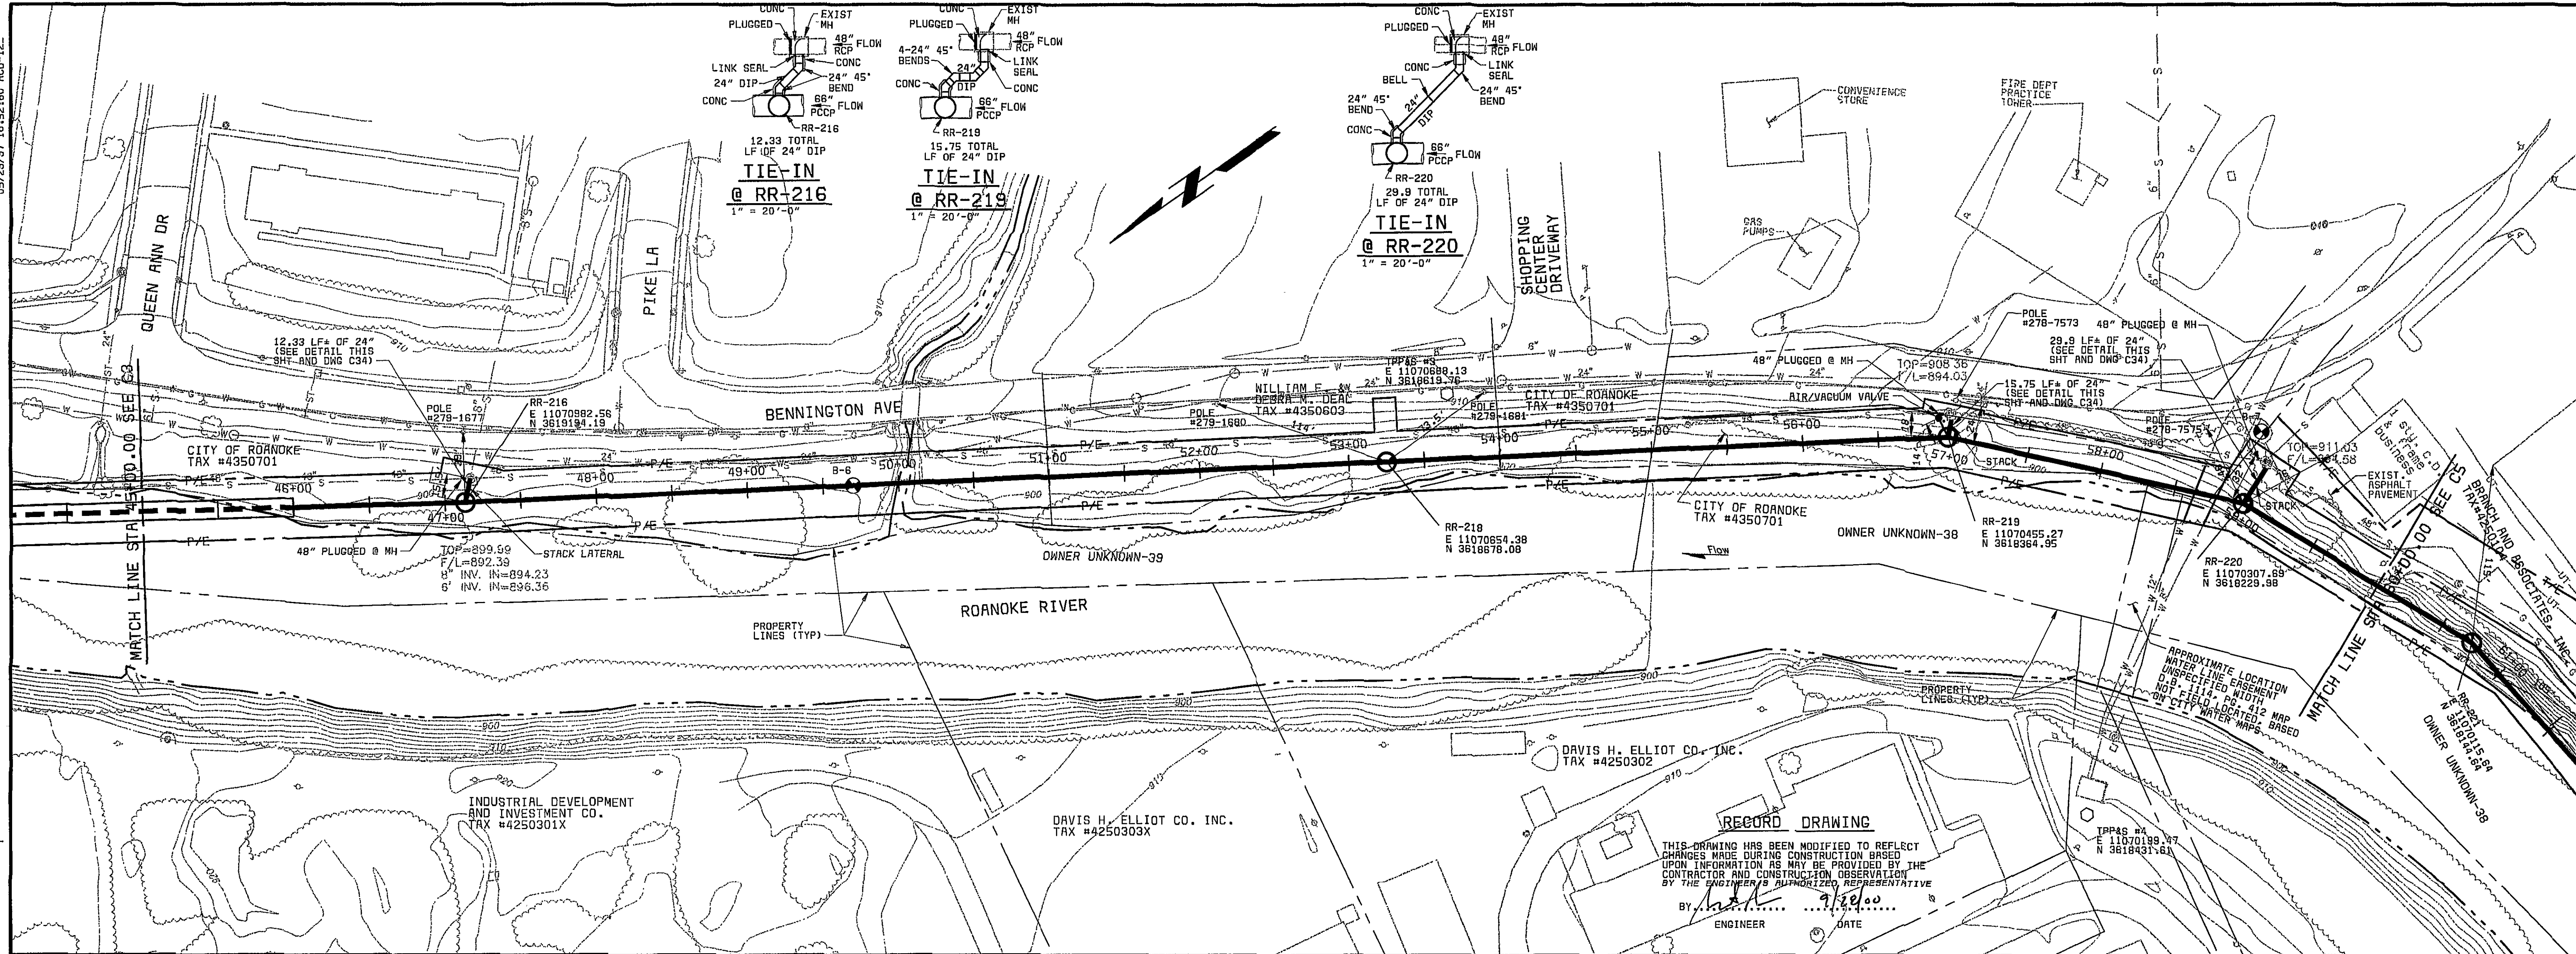

MANHOLE STATIONING AND PIPE LENGTHS:
SEE GENERAL NOTE 16

PCCP PIPE CLASS INFORMATION:
SEE DRAWING C43

SCALE: 1" = 50' HORIZ
1" = 10' VERT

CITY OF ROANOKE, VIRGINIA
ROANOKE RIVER INTERCEPTOR

PLAN AND PROFILE
STA 45+00 TO STA 60+00

CONTRACT A1
C4

SHEET
7 OF 30

DESIGNED JBB, SLF
DETAILED RLC, ABW
CHECKED RAF
APPROVED
DATE



PROJECT NO.
26444

THIS DOCUMENT
ORIGINALLY ISSUED
AND SEALED BY
BRENT A. REUSS
PROFESSIONAL ENGINEER,
COMMONWEALTH OF VIRGINIA
REGISTRATION NO. 028345
ON
5/30/97

DATE REVISIONS AND RECORD OF ISSUE NO. BY CK APP