



26444-300-WKCC-C-80000011J
01031
F000000

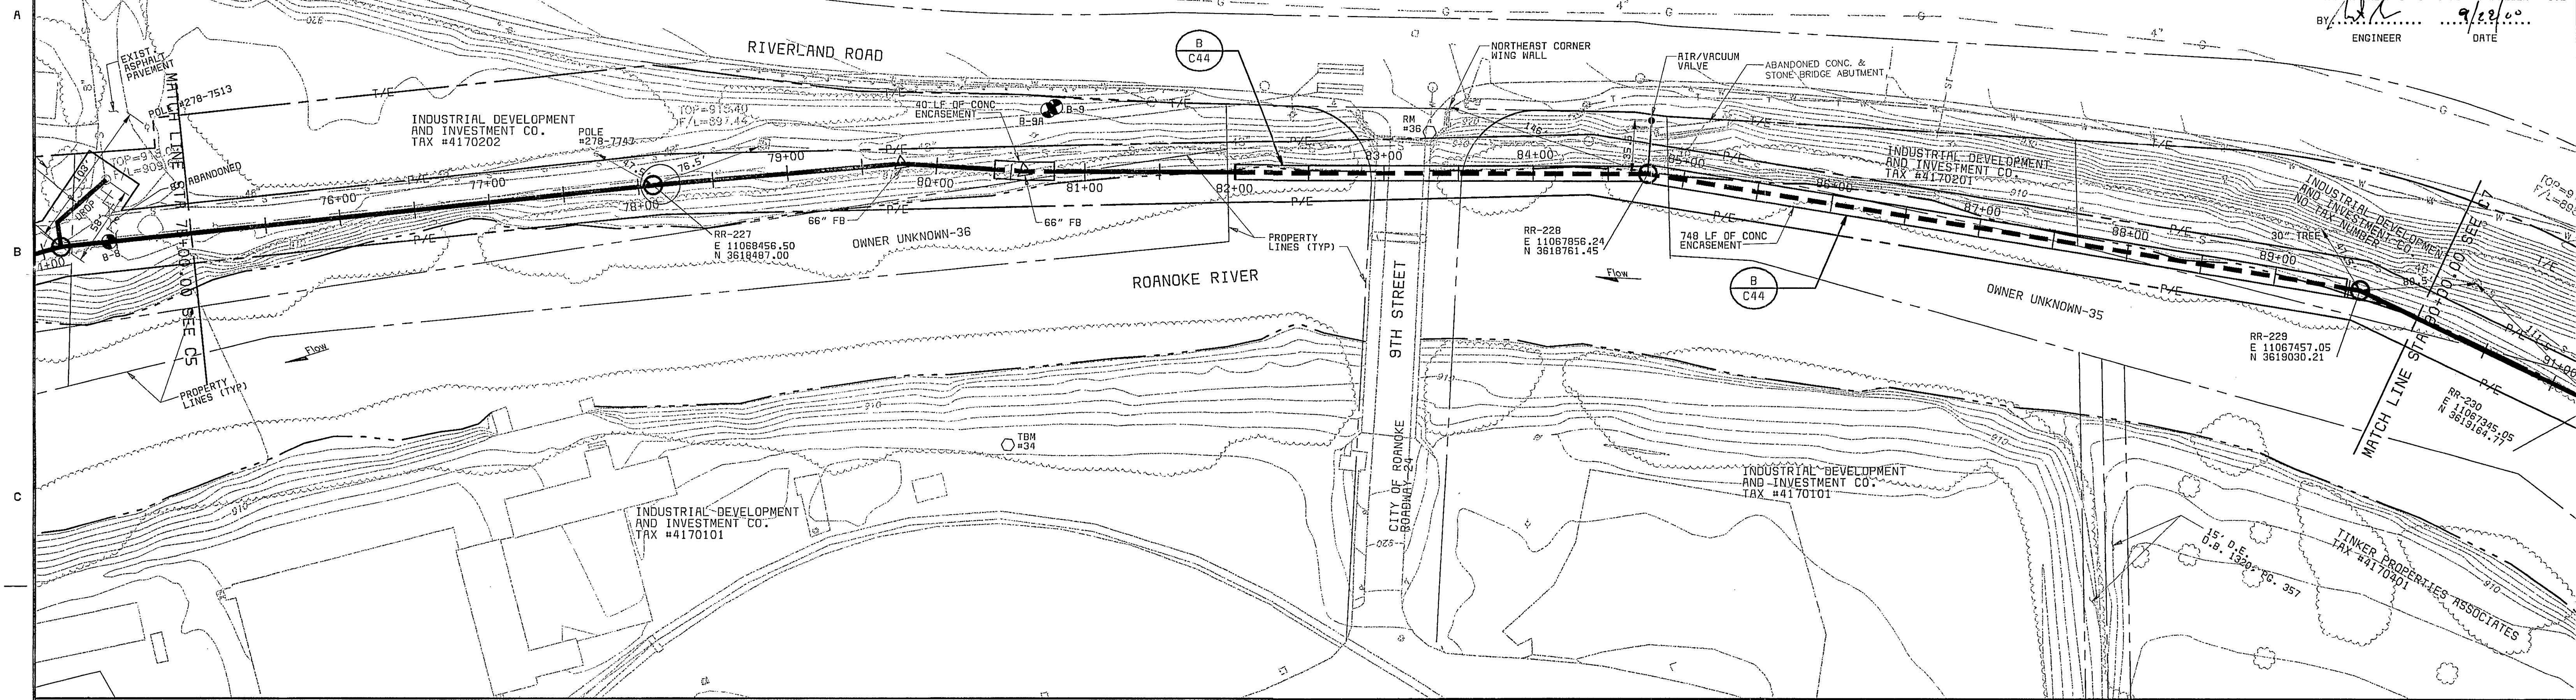

RECORD DRAWING
THIS DRAWING HAS BEEN MODIFIED TO REFLECT CHANGES MADE DURING CONSTRUCTION BASED UPON INFORMATION AS MAY BE PROVIDED BY THE CONTRACTOR AND CONSTRUCTION OBSERVATION BY THE ENGINEER'S AUTHORIZED REPRESENTATIVE.
BY: *[Signature]* DATE: 9/2/00
ENGINEER

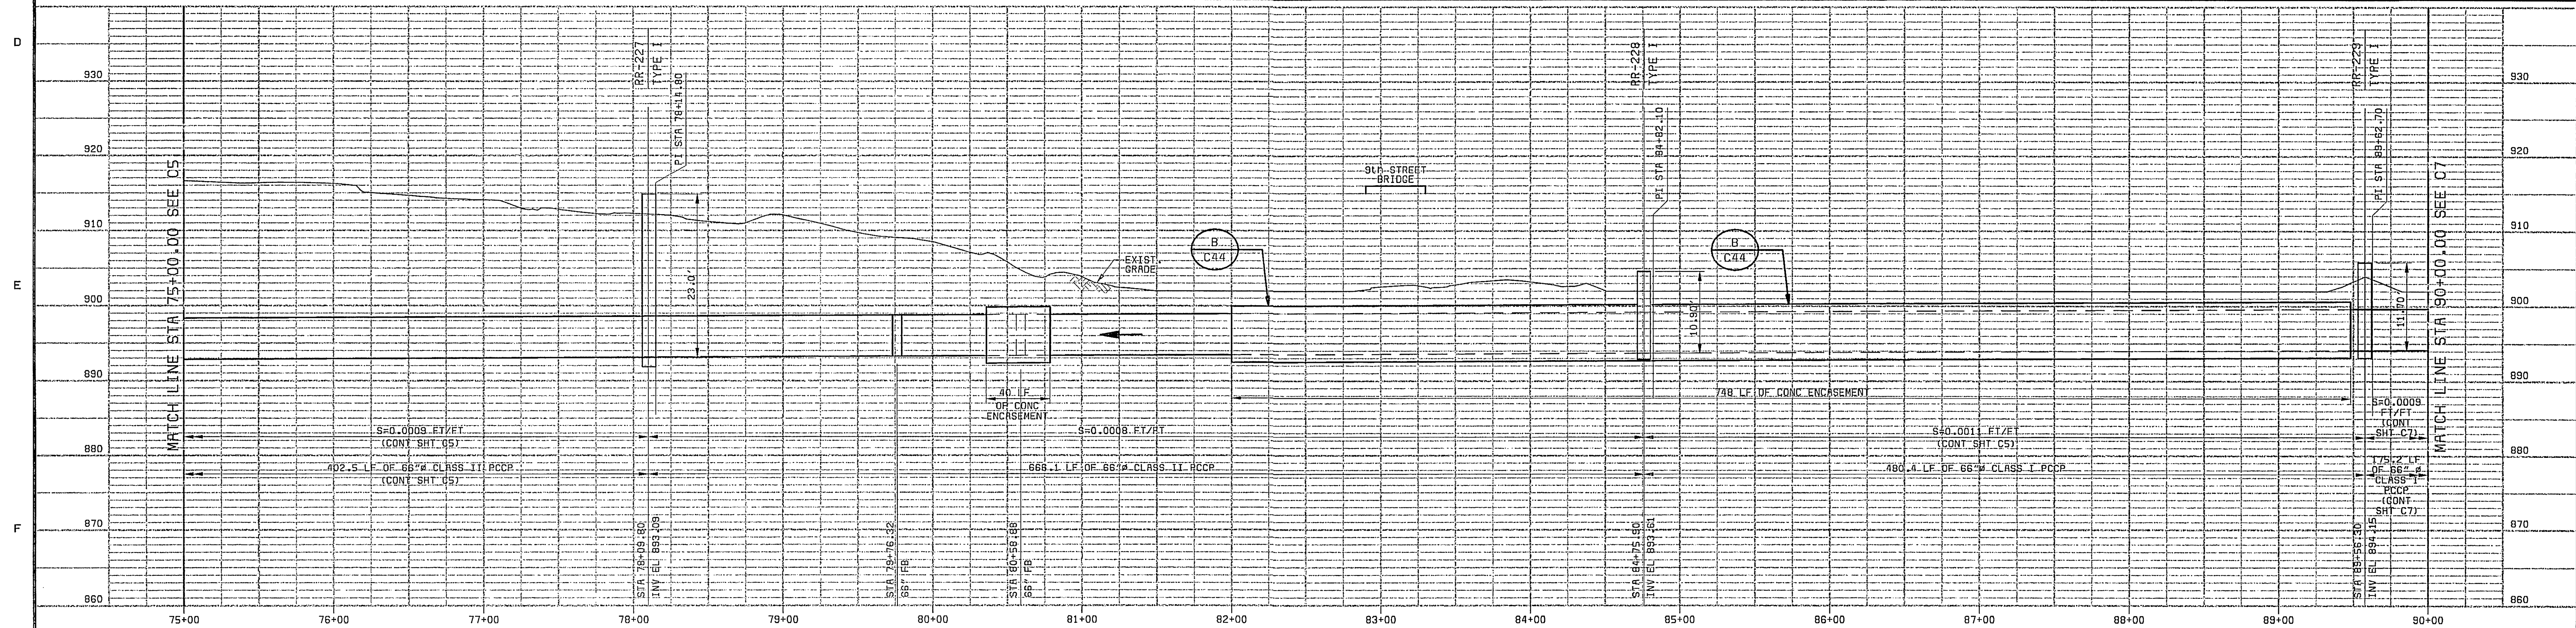

MANHOLE STATIONING AND PIPE LENGTHS:
SEE GENERAL NOTE 16

PCCP PIPE CLASS INFORMATION:
SEE DRAWING C43

SCALE: 1" = 50' HORIZ
1" = 10' VERT

CITY OF ROANOKE, VIRGINIA
ROANOKE RIVER INTERCEPTOR

PLAN AND PROFILE
STA 75+00 TO STA 90+00

CONTRACT A2
C6

THIS DOCUMENT
ORIGINALLY ISSUED
AND SEALED BY
BRENT M. REUSS
PROFESSIONAL ENGINEER,
COMMONWEALTH OF VIRGINIA
REGISTRATION NO. 026345
ON
5/30/97

SHEET
9 OF 30

DESIGNED JBB, SLF
DETAILED RLC, ABM
CHECKED RAF
APPROVED
DATE



PROJECT NO.

26444

DATE	REVISIONS AND RECORD OF ISSUE	NO.	BY	CK	APP