
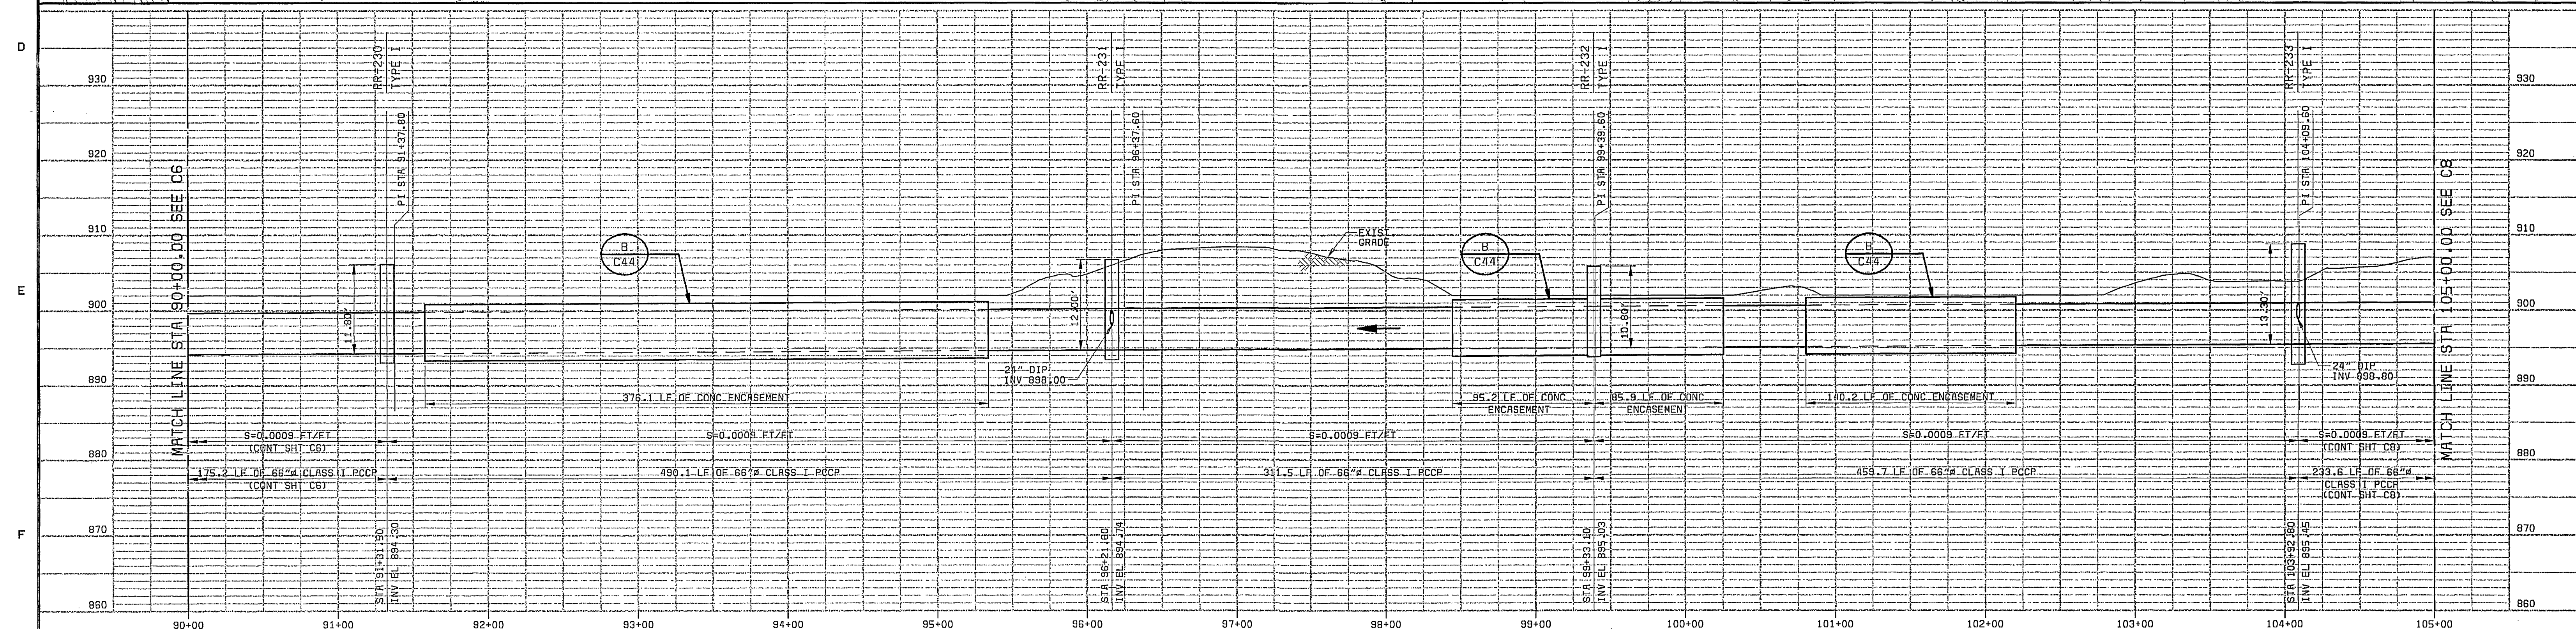


26444-300-WHGS-C-80000011N
01091
F0000C0

REF: DRAWING 26444-300-305-UT1
02/23/97 BY 11068980.15

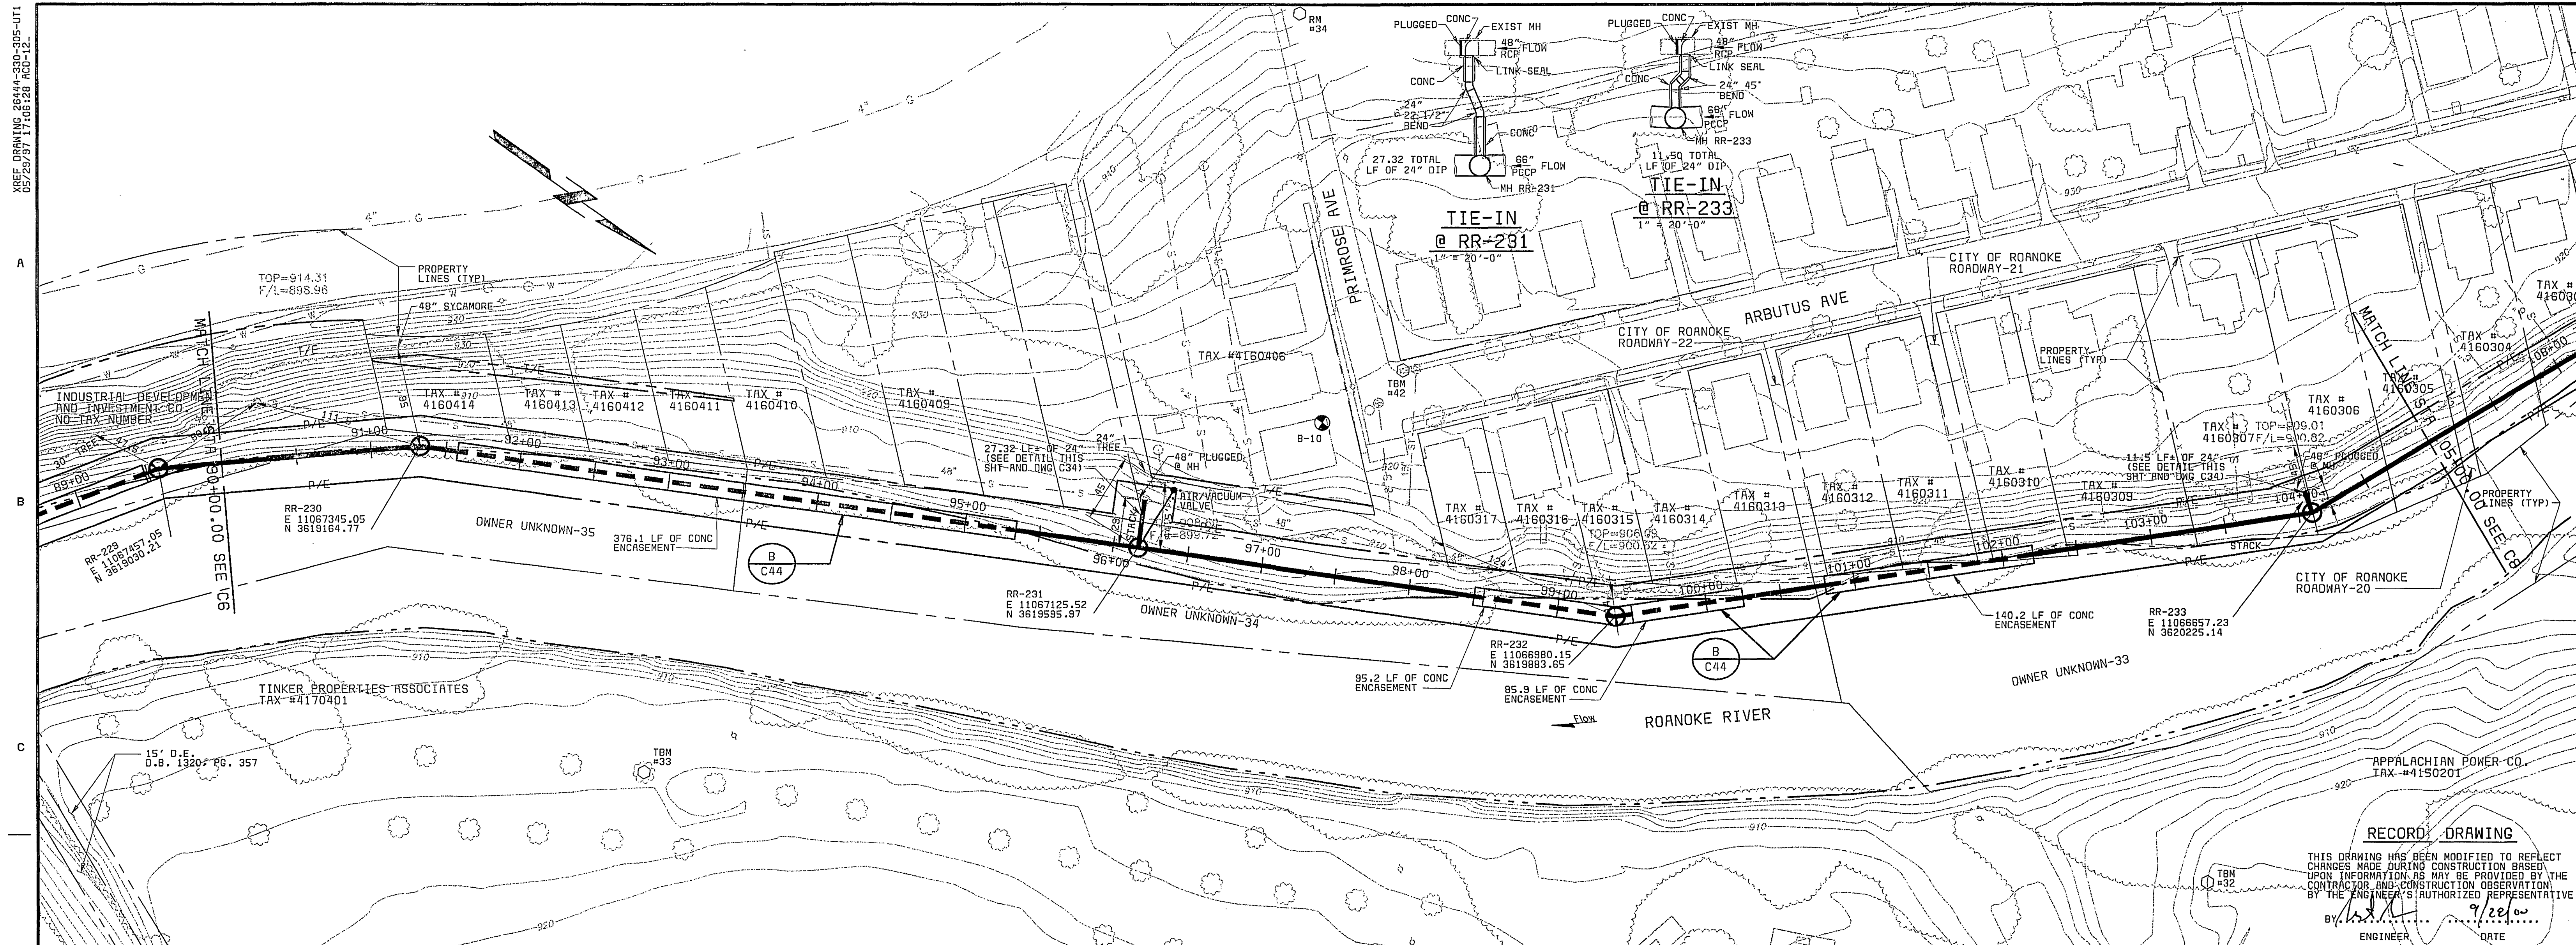

MANHOLE STATIONING AND PIPE LENGTHS:
SEE GENERAL NOTE 16

PCCP PIPE CLASS INFORMATION:
SEE DRAWING C43

SCALE: 1" = 50' HORIZ
1" = 10' VERT

CITY OF ROANOKE, VIRGINIA
ROANOKE RIVER INTERCEPTOR

PLAN AND PROFILE
STA 90+00 TO STA 105+00

CONTRACT A2
C7

SHEET
10 OF 30

DESIGNED JBB, SLF
DETAILED RLC, ARW
CHECKED RAF
APPROVED
DATE



PROJECT NO.
26444

THIS DOCUMENT
ORIGINALLY ISSUED
AND SEALED BY
BRENT M. REUSS
PROFESSIONAL ENGINEER,
COMMONWEALTH OF VIRGINIA
REGISTRATION NO. 026345
ON
5/30/97

DATE REVISIONS AND RECORD OF ISSUE NO. BY CK APP