
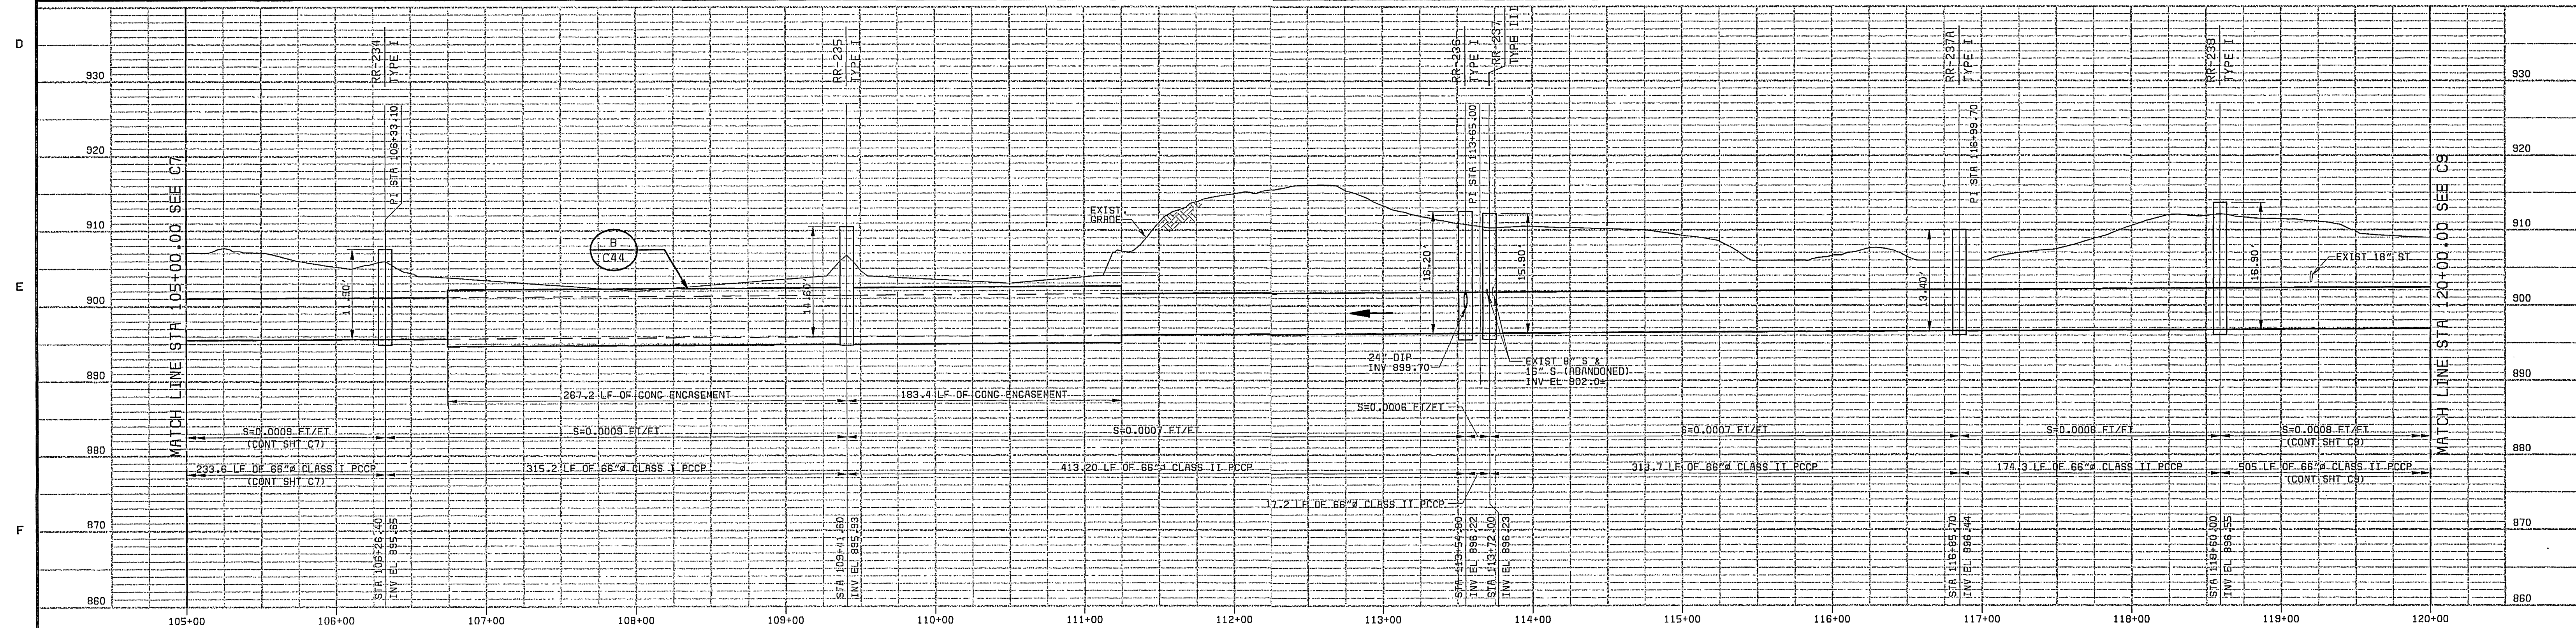


REF. DRAWING 26444-300-305-UT1
05/29/97 BY JTB/038 RCP-12

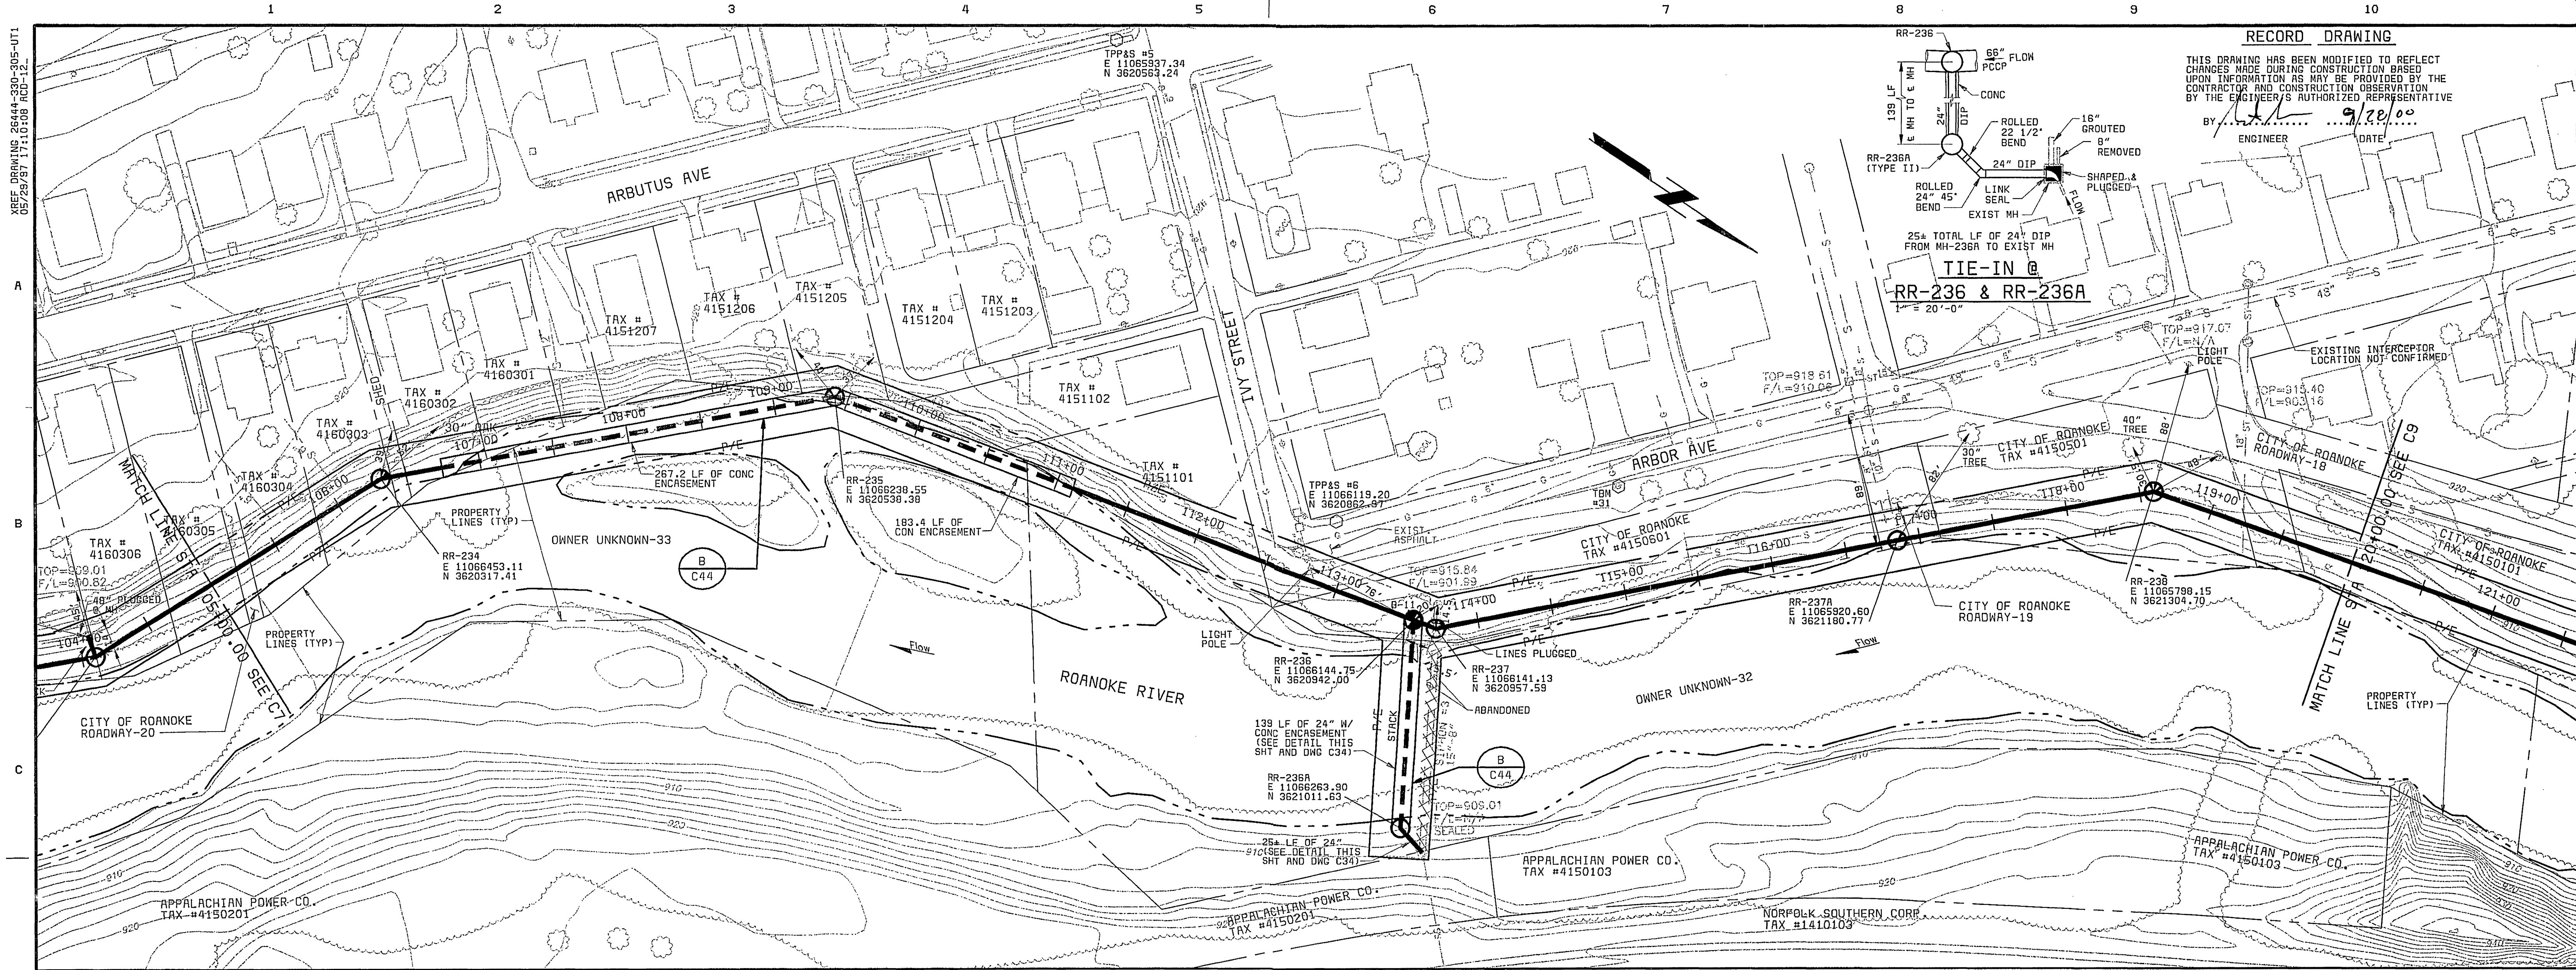

MANHOLE STATIONING AND PIPE LENGTHS:
SEE GENERAL NOTE 16

PCP PIPE CLASS INFORMATION:
SEE DRAWING C43

SCALE: 1" = 50' HORIZ
1" = 10' VERT

CITY OF ROANOKE, VIRGINIA
ROANOKE RIVER INTERCEPTOR

PLAN AND PROFILE
STA 105+00 TO STA 120+00

CONTRACT R2
C8

SHEET
11 OF 30

DESIGNED: JBB, SLF
DETAILED: RLC, ABN
CHECKED: RAF
APPROVED: _____
DATE: _____



PROJECT NO.
26444

THIS DOCUMENT
ORIGINALLY ISSUED
AND SEALED BY
BRENT M. REUSS
PROFESSIONAL ENGINEER
COMMONWEALTH OF VIRGINIA
REGISTRATION NO. 026345
ON
5/30/97

DATE REVISIONS AND RECORD OF ISSUE NO. BY CK APP