


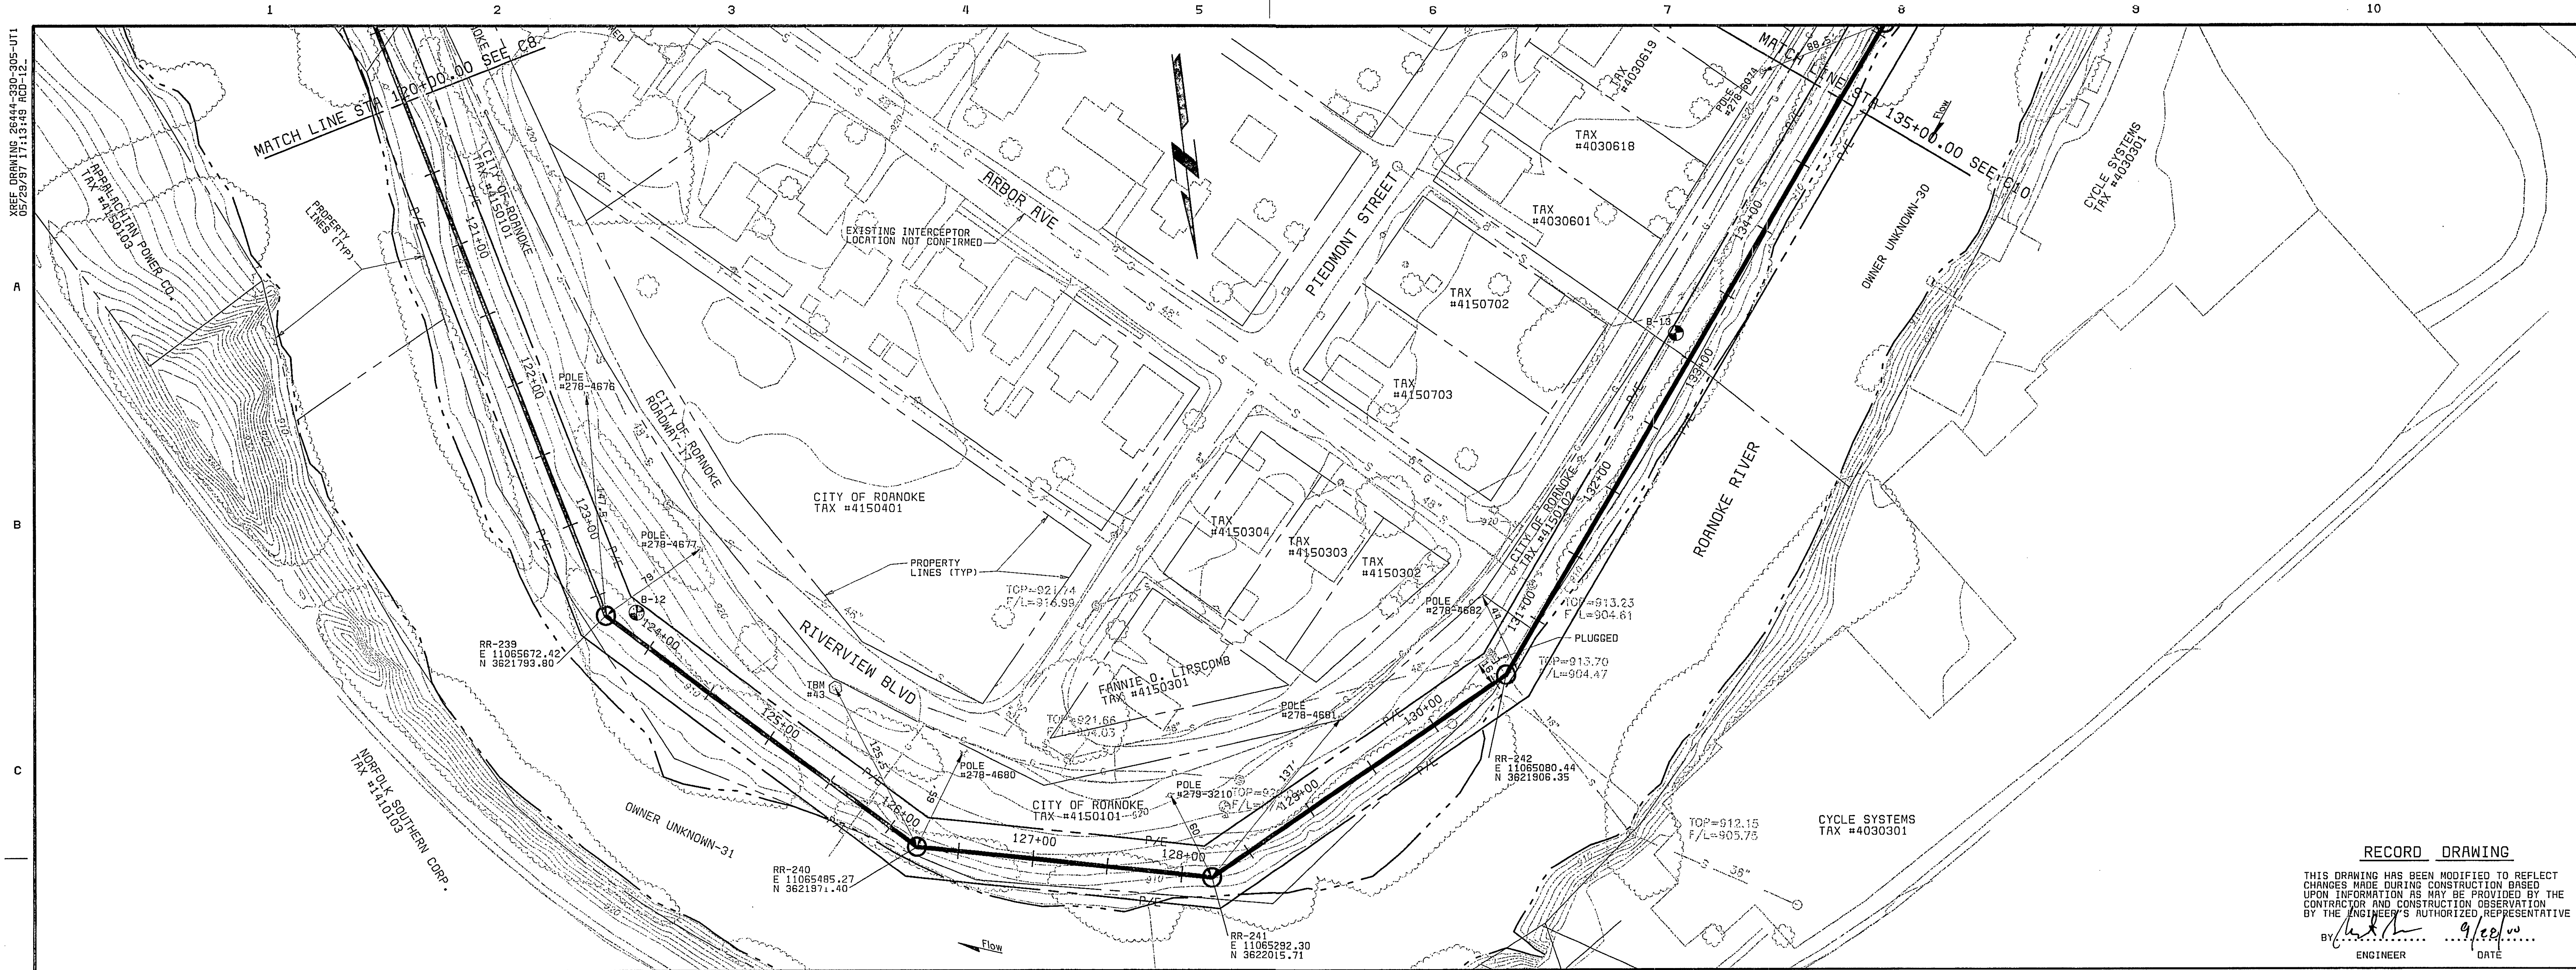


RECORD DRAWING

THIS DRAWING HAS BEEN MODIFIED TO REFLECT CHANGES MADE DURING CONSTRUCTION BASED UPON INFORMATION AS MAY BE PROVIDED BY THE CONTRACTOR AND CONSTRUCTION OBSERVATION BY THE ENGINEER'S AUTHORIZED REPRESENTATIVE

BY: *[Signature]* DATE: 9/22/00

ENGINEER

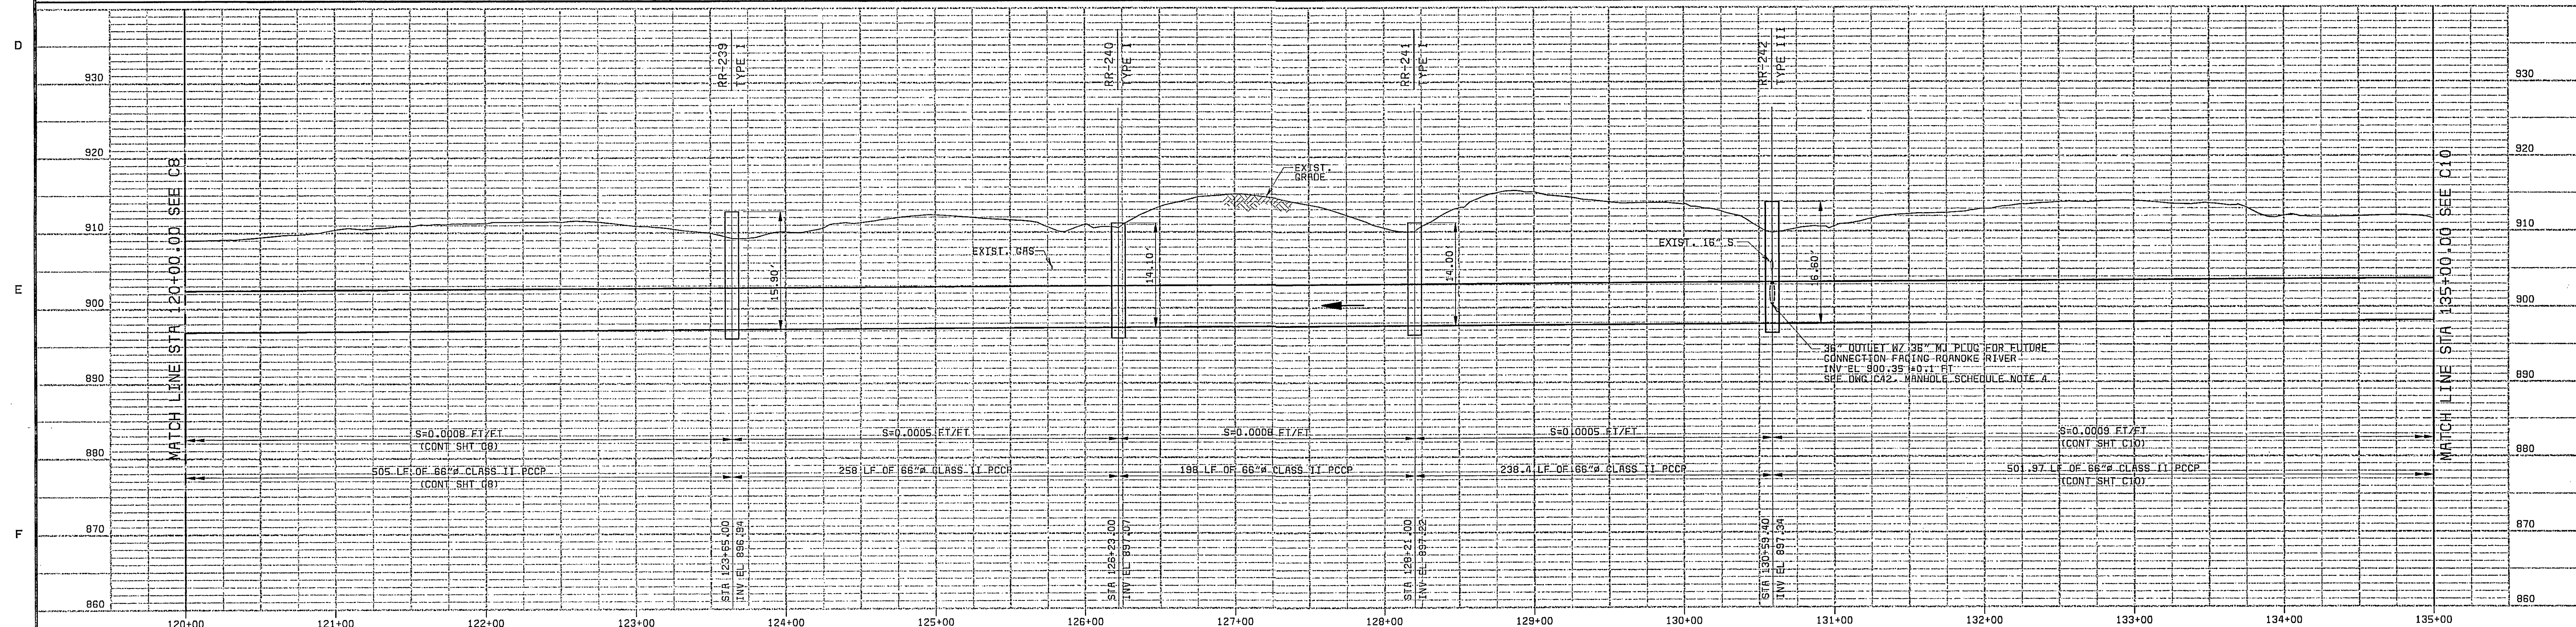

MANHOLE STATIONING AND PIPE LENGTHS:
SEE GENERAL NOTE 16

PCCP PIPE CLASS INFORMATION:
SEE DRAWING C43

SCALE: 1" = 50' HORIZ
1" = 10' VERT

CITY OF ROANOKE, VIRGINIA
ROANOKE RIVER INTERCEPTOR

PLAN AND PROFILE
STA 120+00 TO STA 135+00

CONTRACT #2

C9

SHEET
12 OF 30

THIS DOCUMENT
ORIGINALLY ISSUED
AND SEALED BY
BRENT M. REISS
PROFESSIONAL ENGINEER
COMMONWEALTH OF VIRGINIA
REGISTRATION NO. 026345
ON
5/30/97



DESIGNED: JBB, SLF
DETAILED: RLC, ABM
CHECKED: RAF
APPROVED: _____
DATE: _____

PROJECT NO.
26444

DATE: _____ REVISIONS AND RECORD OF ISSUE: _____ NO. BY CK APP

26444-300-WHCS-C-8000001.R

CG01
F000000