
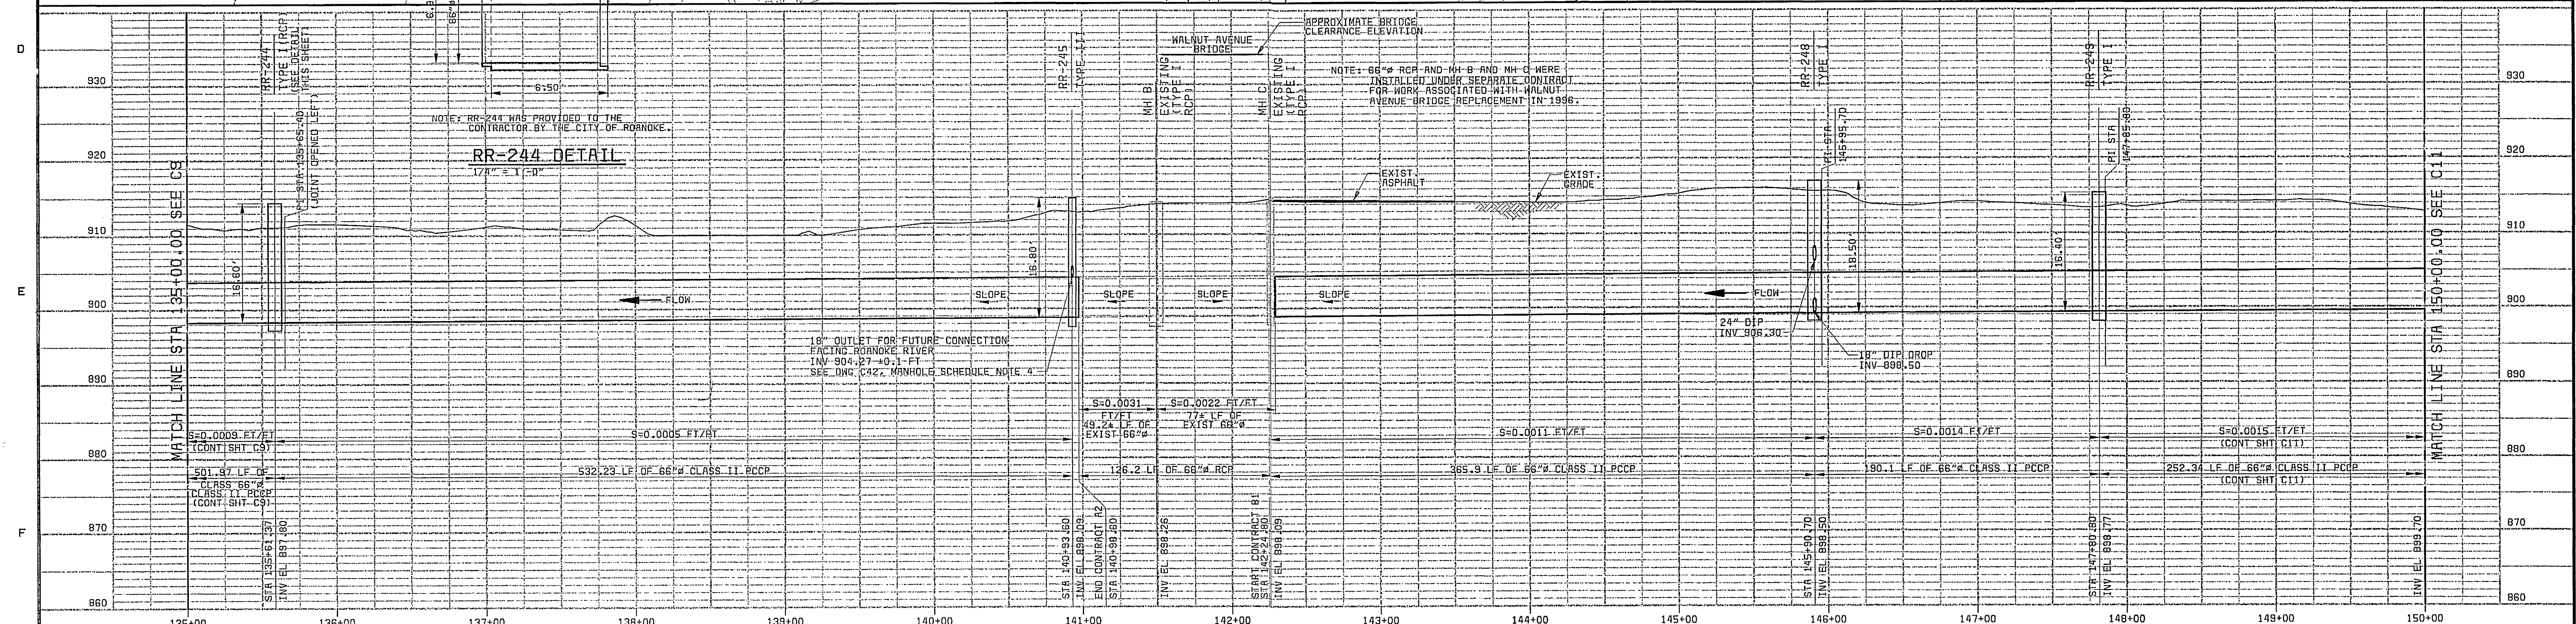


SEE DRAWING 2644-300-205-UT1  
02/26/97 171728 RCP-12

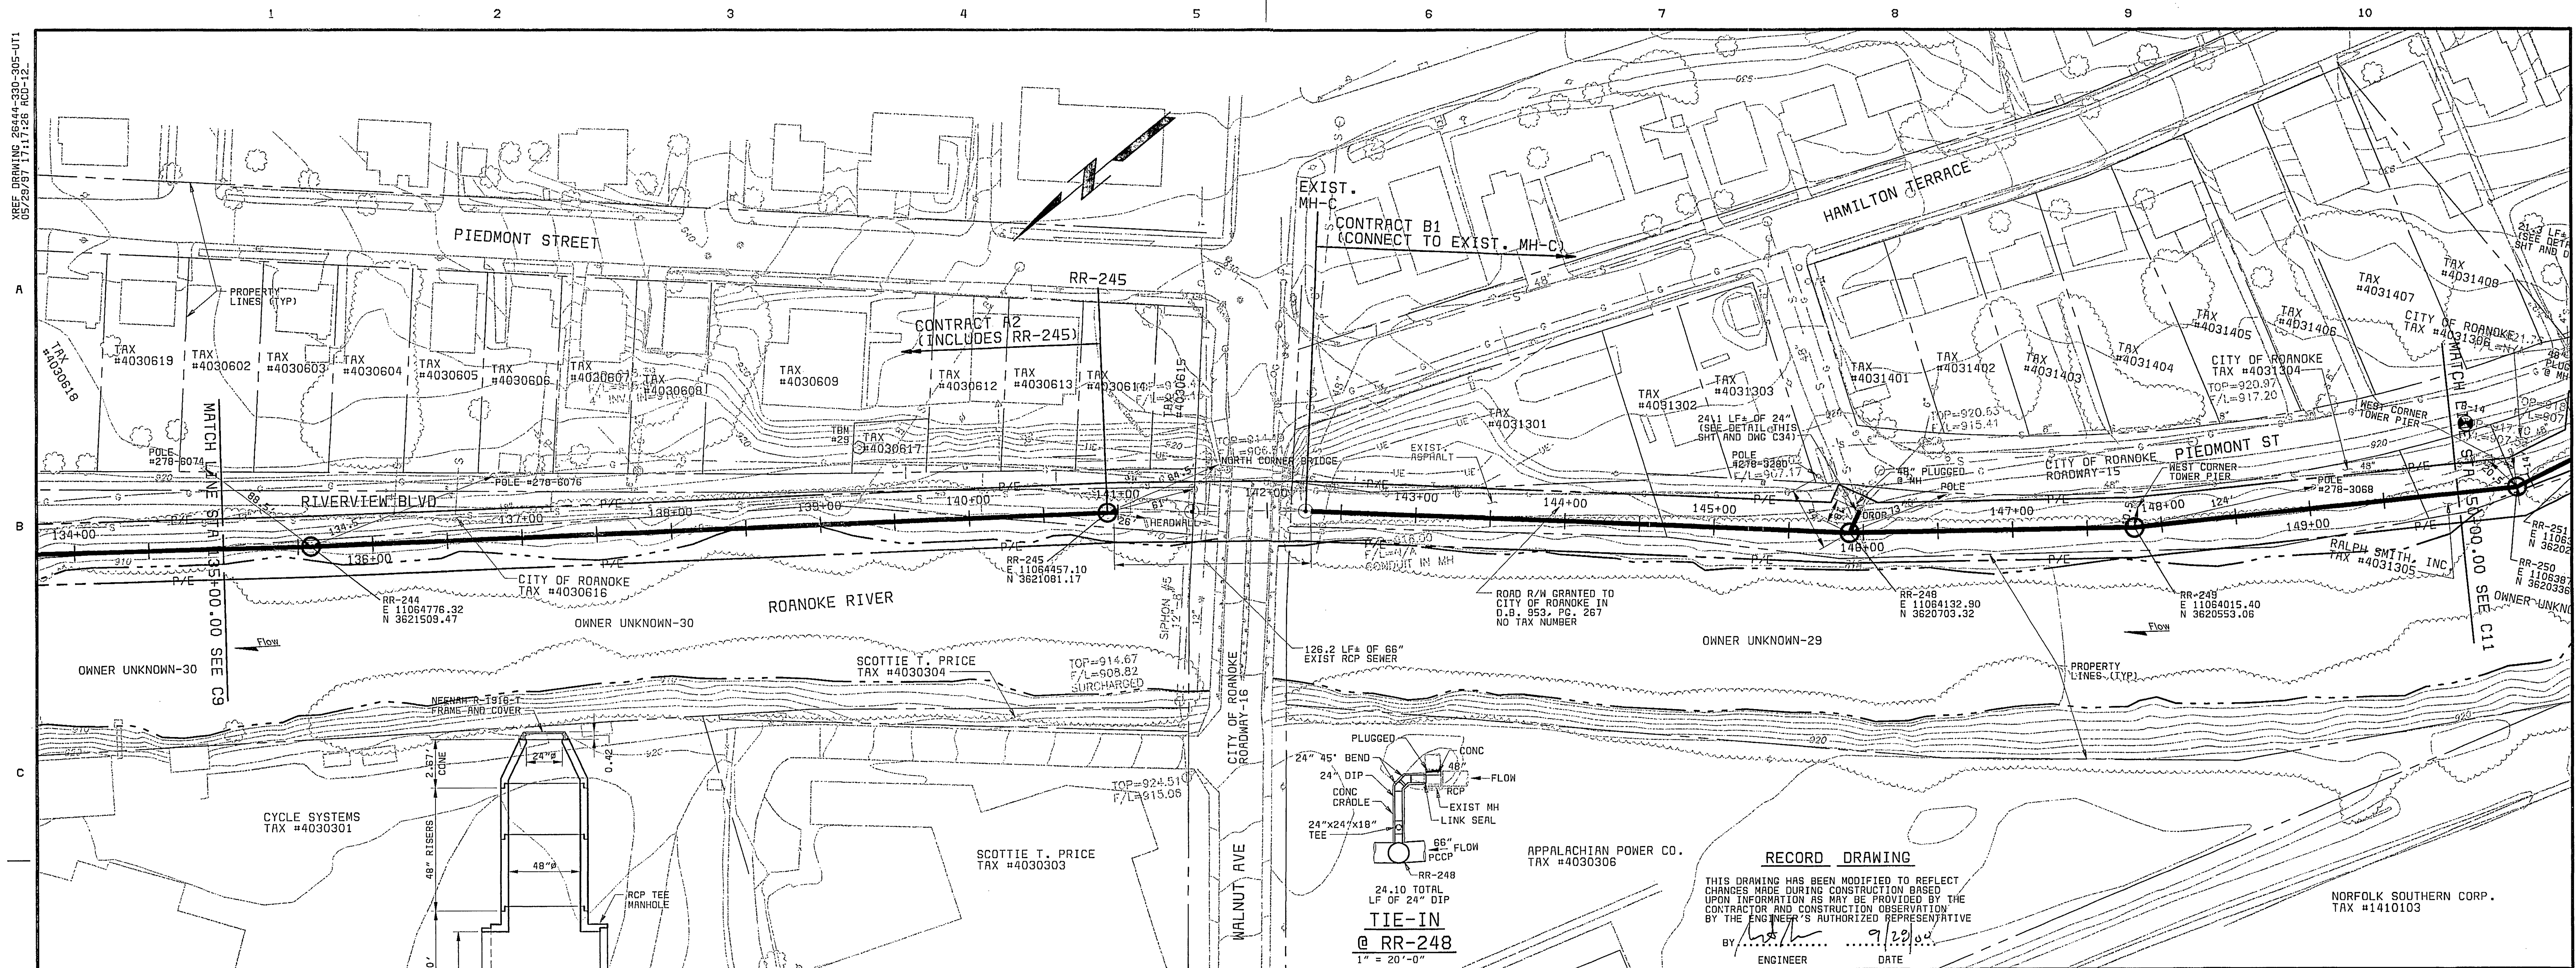

MANHOLE STATIONING AND PIPE LENGTHS:  
SEE GENERAL NOTE 16

PCCP PIPE CLASS INFORMATION:  
SEE DRAWING C43

SCALE: 1" = 50' HORIZ  
1" = 10' VERT

CITY OF ROANOKE, VIRGINIA  
ROANOKE RIVER INTERCEPTOR

CONTRACT  
A2,B1  
C10

PLAN AND PROFILE  
STA 135+00 TO STA 150+00

THIS DOCUMENT  
ORIGINALLY ISSUED  
AND SEALED BY  
BRENT M. REUSS  
PROFESSIONAL ENGINEER  
COMMONWEALTH OF VIRGINIA  
REGISTRATION NO. 026345  
ON  
5/30/97

SHEET  
13 OF 30

2644-300-WK3-C-800000111

61031  
FG00000

DATE REVISIONS AND RECORD OF ISSUE NO. BY CK APP

DESIGNED JBB, SLF  
DETAILED RLC, ABW  
CHECKED RAF  
APPROVED  
DATE



PROJECT NO.  
26444