
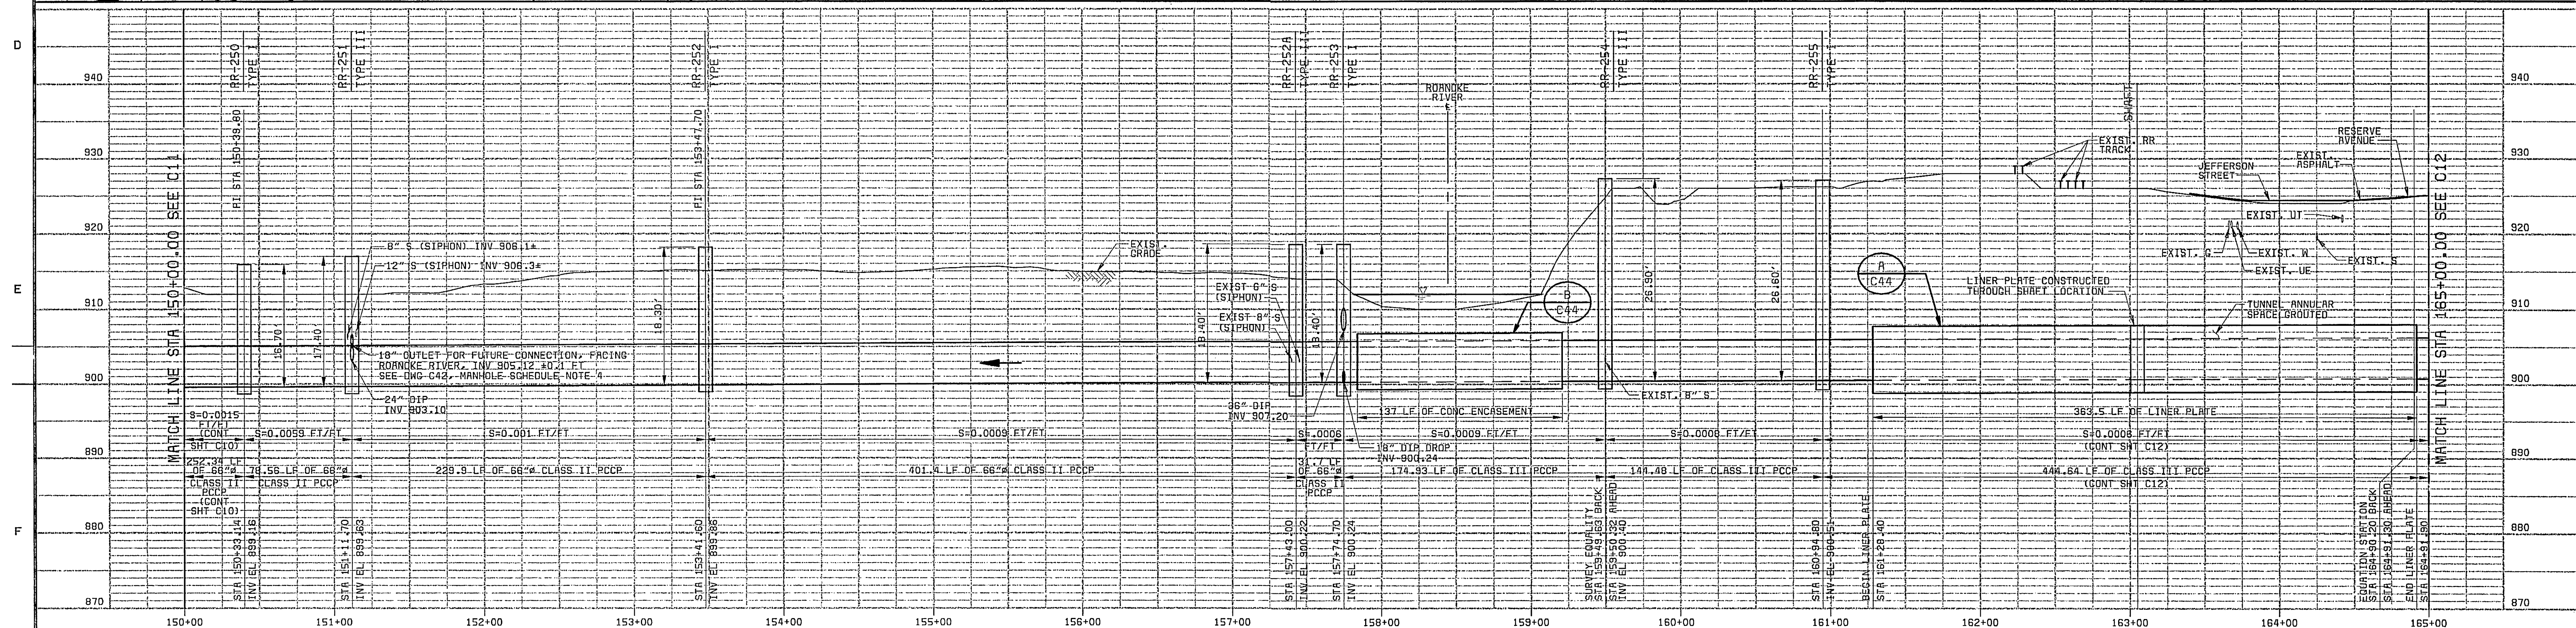


26444-300-WC-C-90000001V
01031
F000000

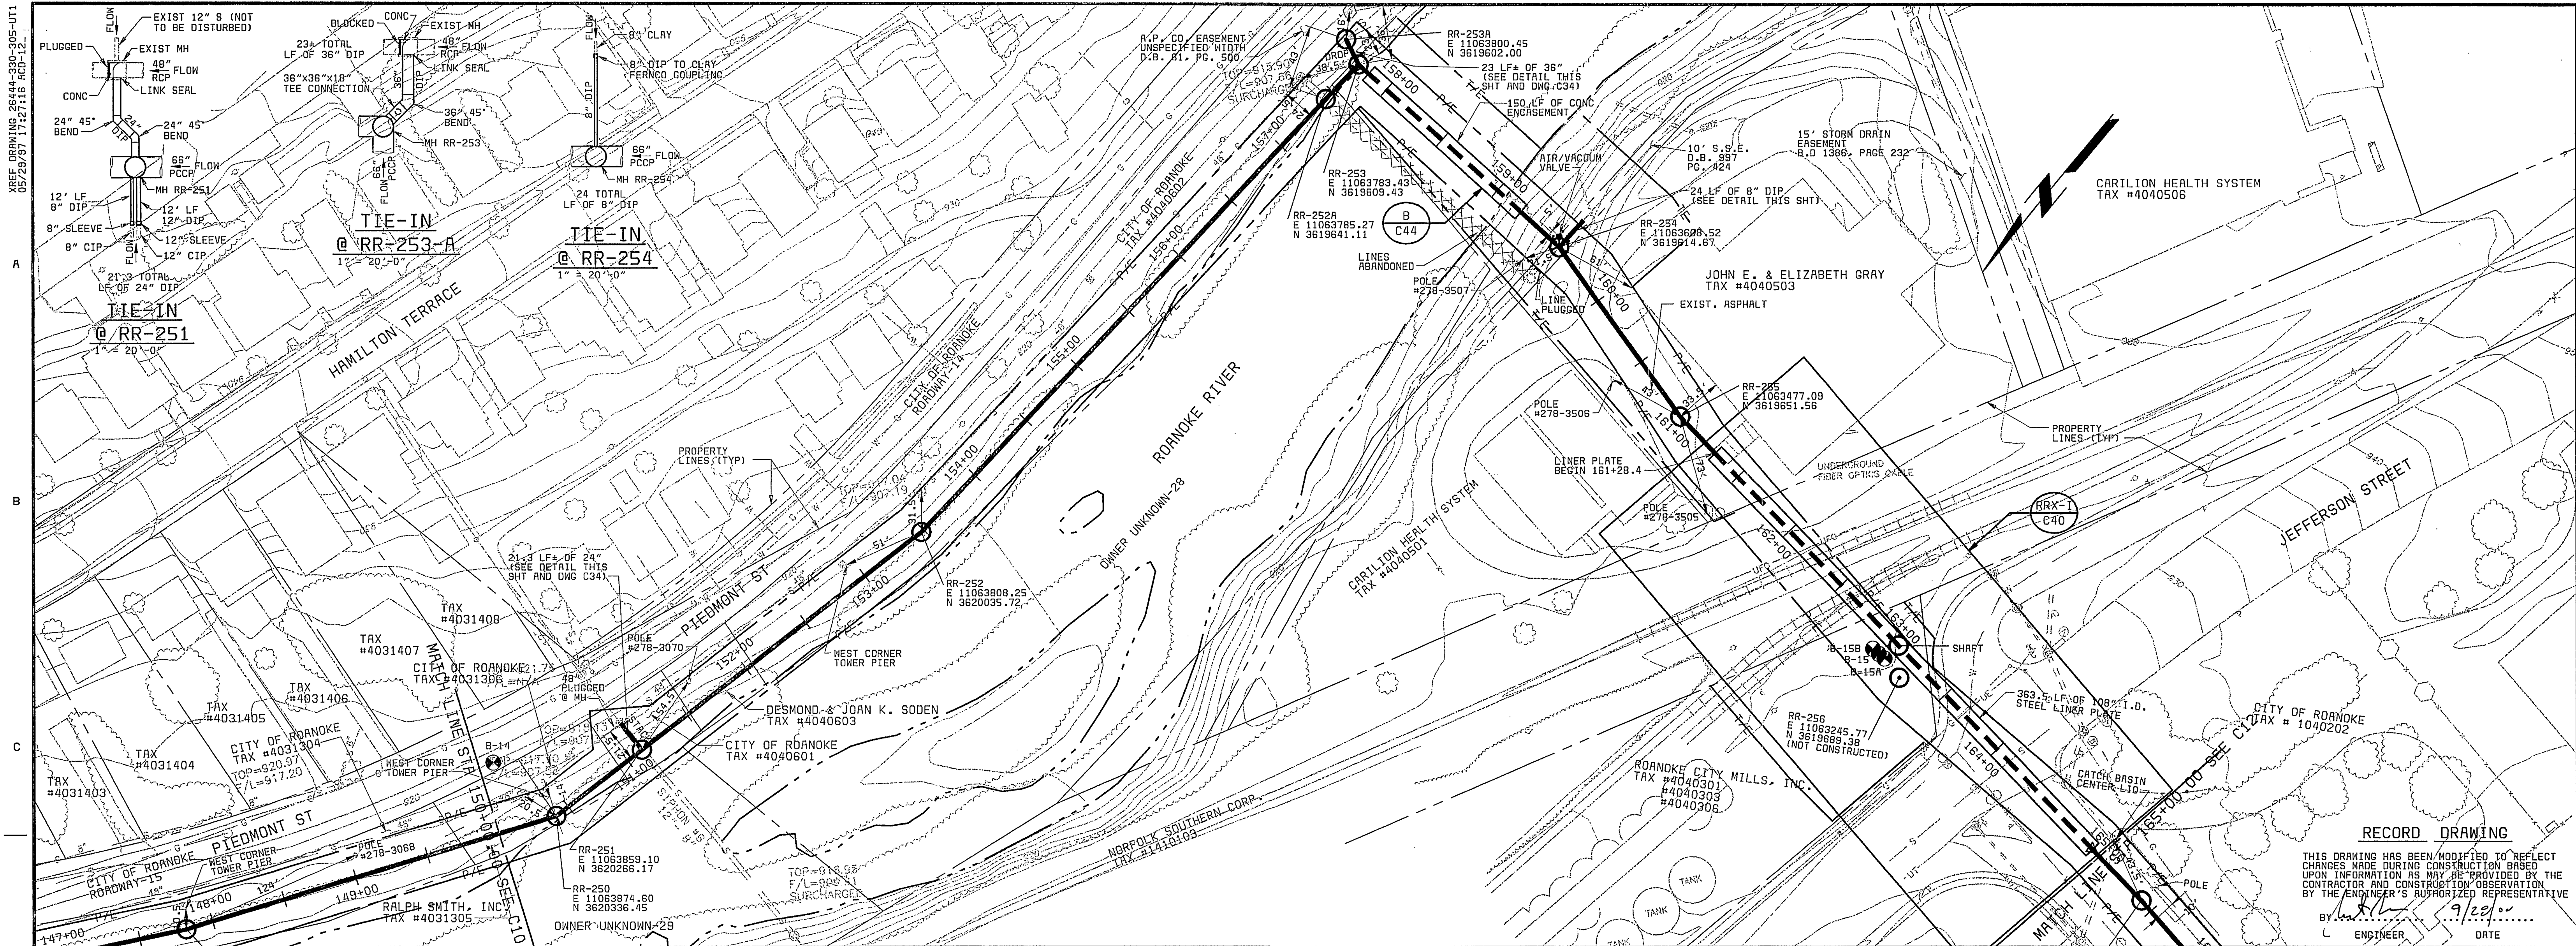

MANHOLE STATIONING AND PIPE LENGTHS:
SEE GENERAL NOTE 16

PCP PIPE CLASS INFORMATION:
SEE DRAWING C43

SCALE: 1" = 50' HORIZ
1" = 10' VERT

CITY OF ROANOKE, VIRGINIA
ROANOKE RIVER INTERCEPTOR

PLAN AND PROFILE
STA 150+00 TO STA 165+00

CONTRACT B1
C11

SHEET
14 OF 30

DESIGNED JBB, SLF
DETAILED RLC, ABW
CHECKED RAF
APPROVED
DATE



PROJECT NO.
26444

THIS DOCUMENT
ORIGINALLY ISSUED
AND SEALED BY
BRENT M. REUSS
PROFESSIONAL ENGINEER
COMMONWEALTH OF VIRGINIA
REGISTRATION NO. 026345
ON
5/30/97

DATE	REVISIONS AND RECORD OF ISSUE	NO.	BY	CK	APP