
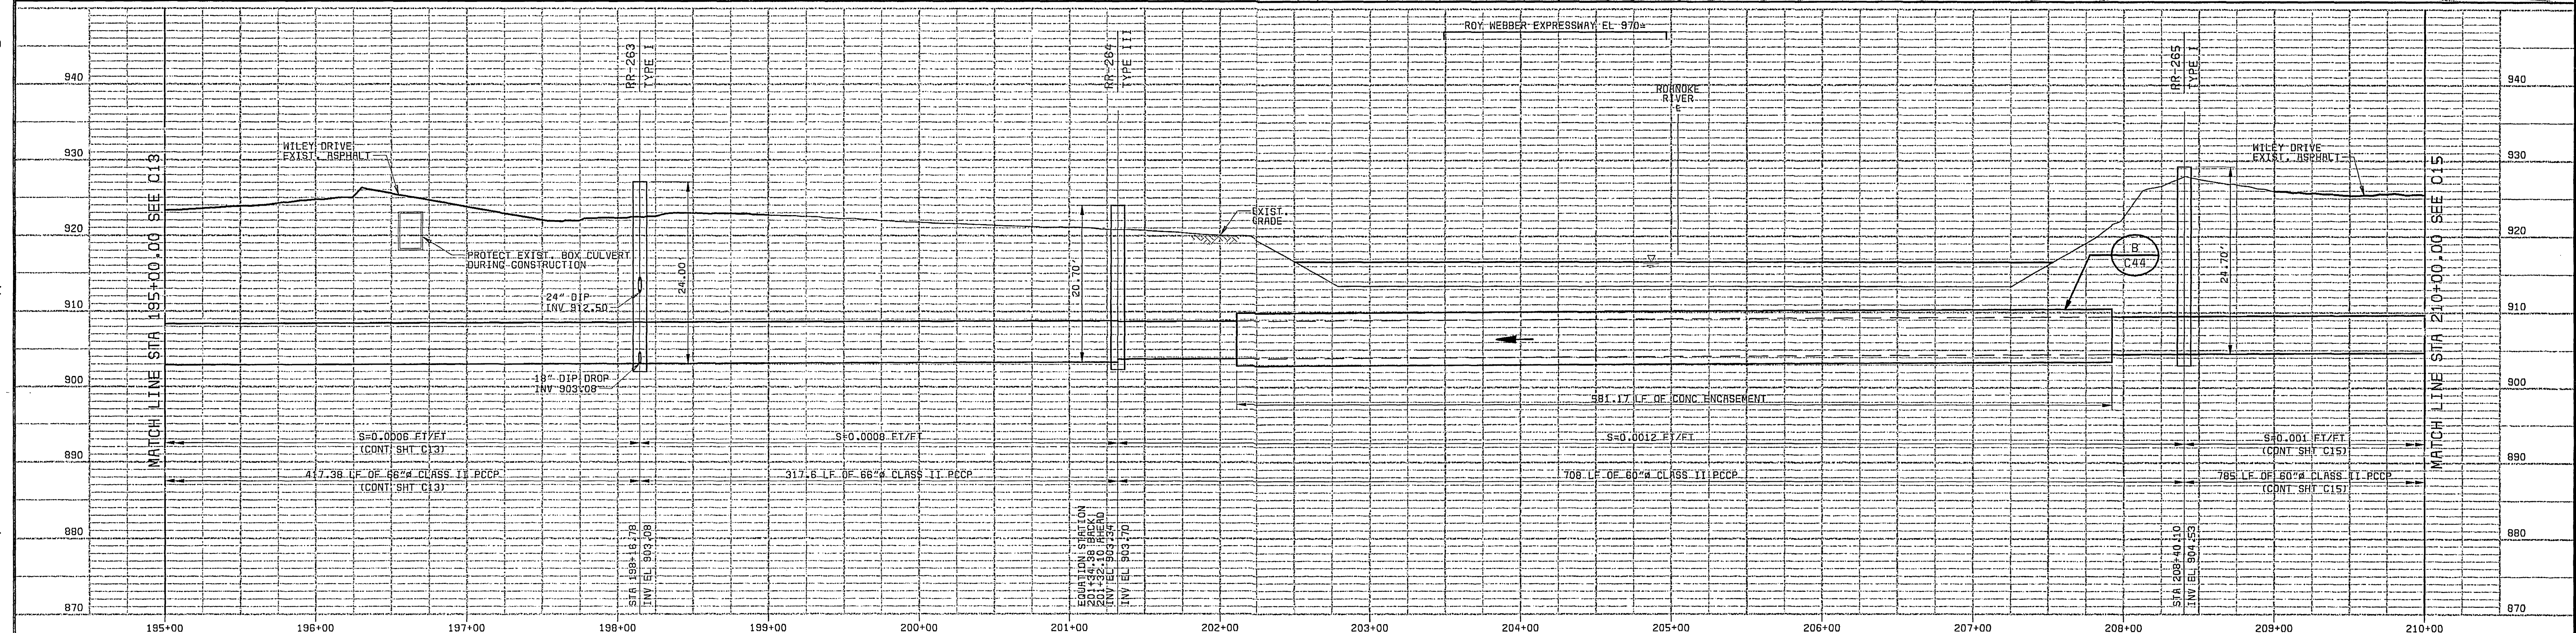


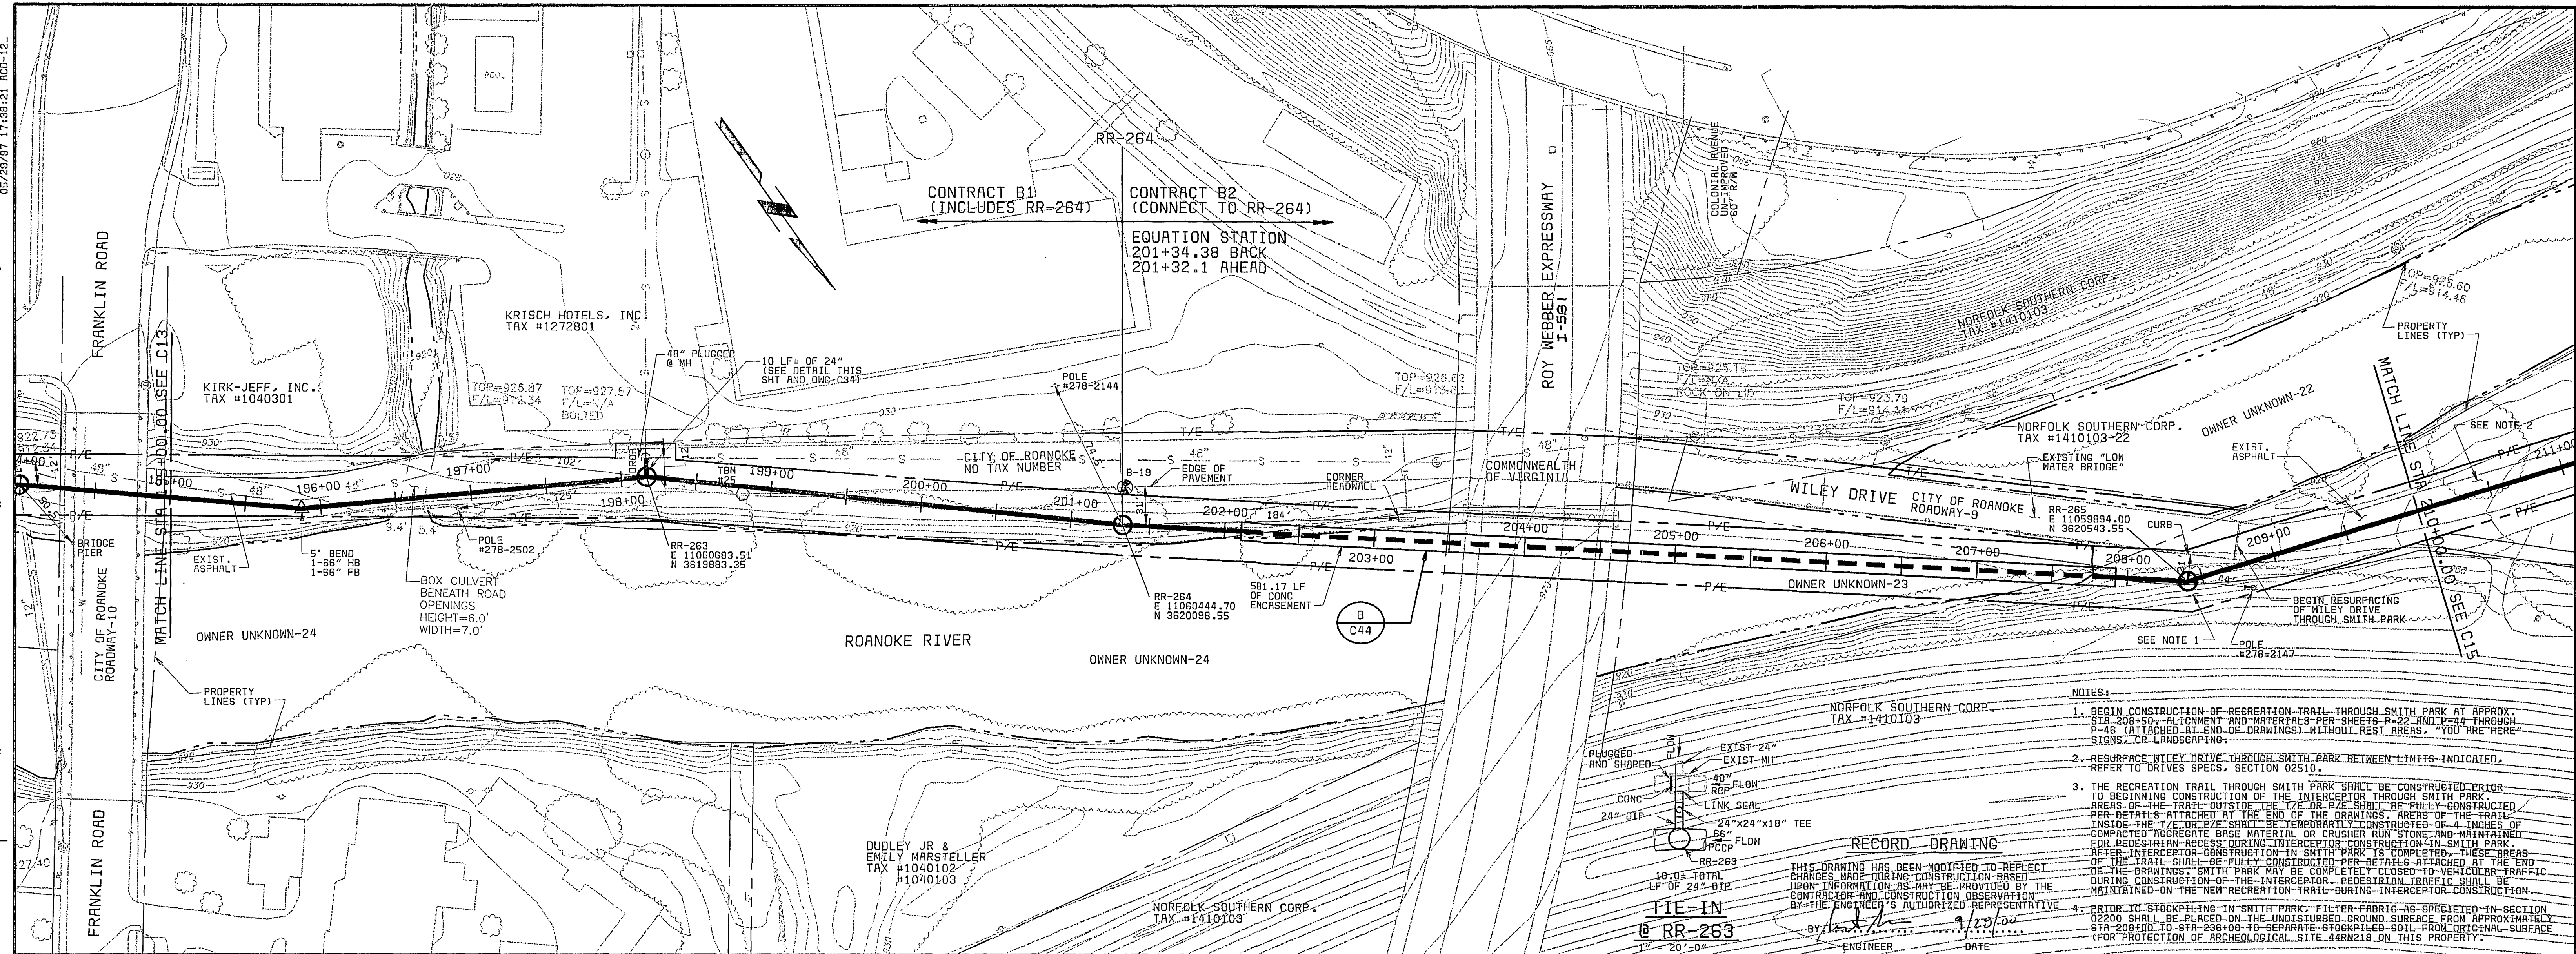

MANHOLE STATIONING AND PIPE LENGTHS:
SEE GENERAL NOTE 16

PCCP PIPE CLASS INFORMATION:
SEE DRAWING C43

SCALE: 1" = 50' HORIZ
1" = 10' VERT

CITY OF ROANOKE, VIRGINIA
ROANOKE RIVER INTERCEPTOR

CONTRACT
B1, B2
C14

PLAN AND PROFILE
STA 195+00 TO STA 210+00

THIS DOCUMENT
ORIGINALLY ISSUED
AND SEALED BY
BRENT H. REISS
PROFESSIONAL ENGINEER,
COMMONWEALTH OF VIRGINIA
REGISTRATION NO. 028345
ON
5-30-97

SHEET
17 OF 30

DESIGNED JBB, SLF
DETAILED RLC, ABW
CHECKED RAF
APPROVED
DATE



PROJECT NO.
26444