
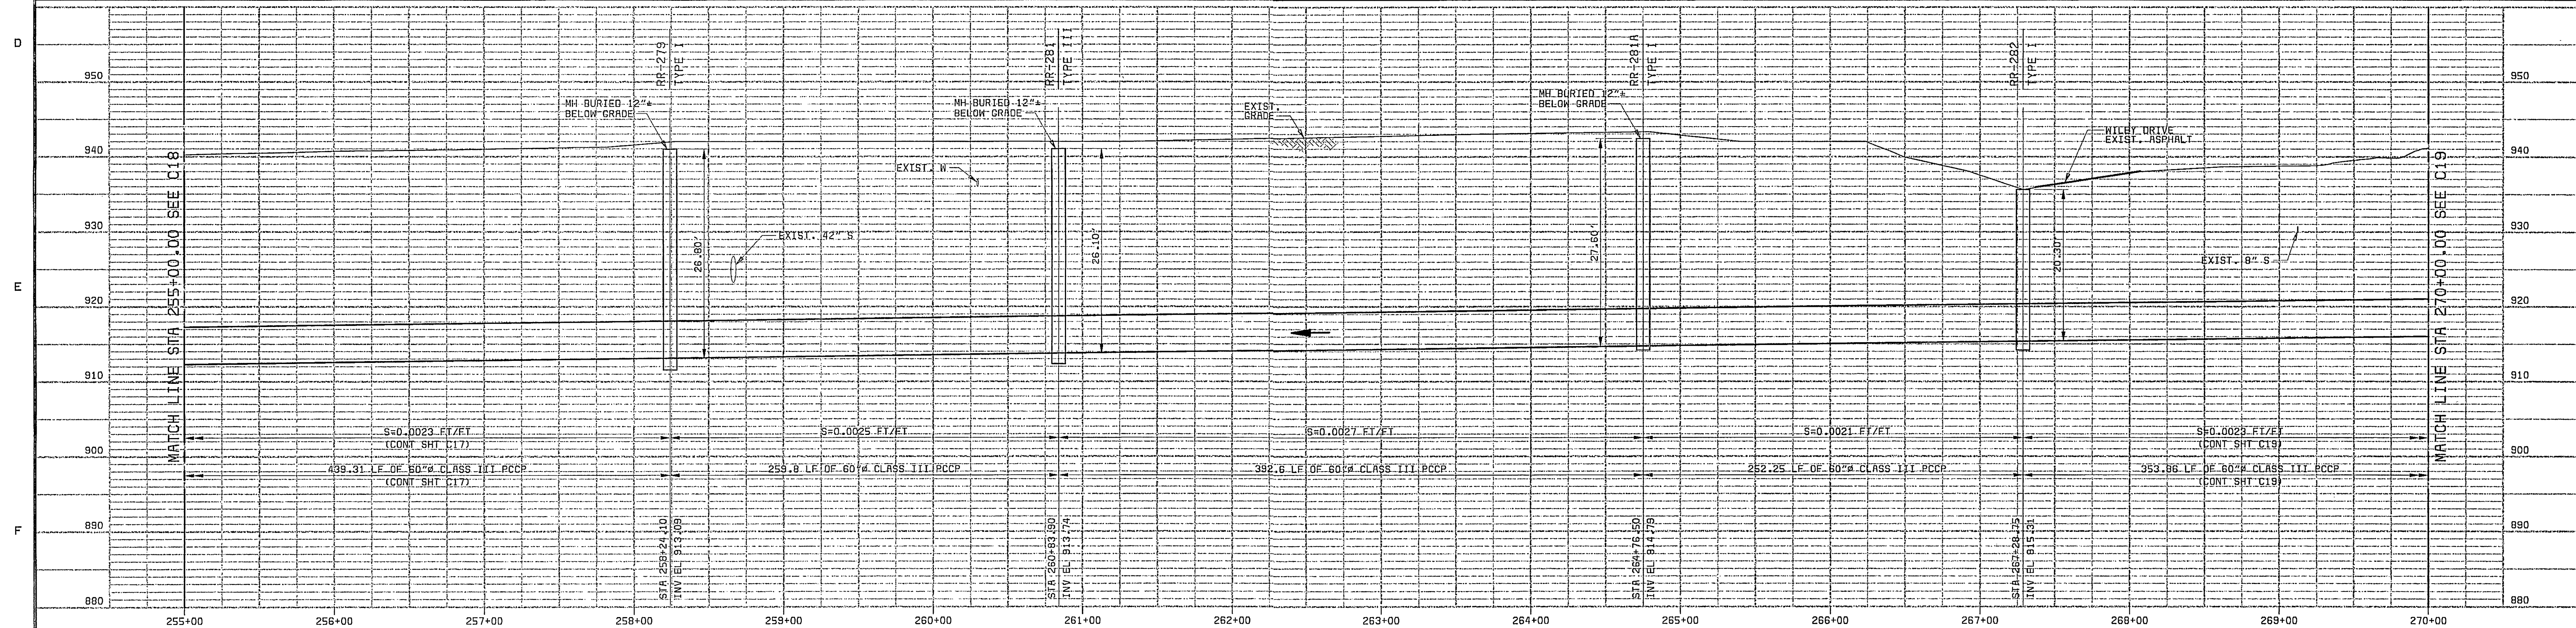


26444-300-WKCC-C-B0000011.B
C1031
F000000

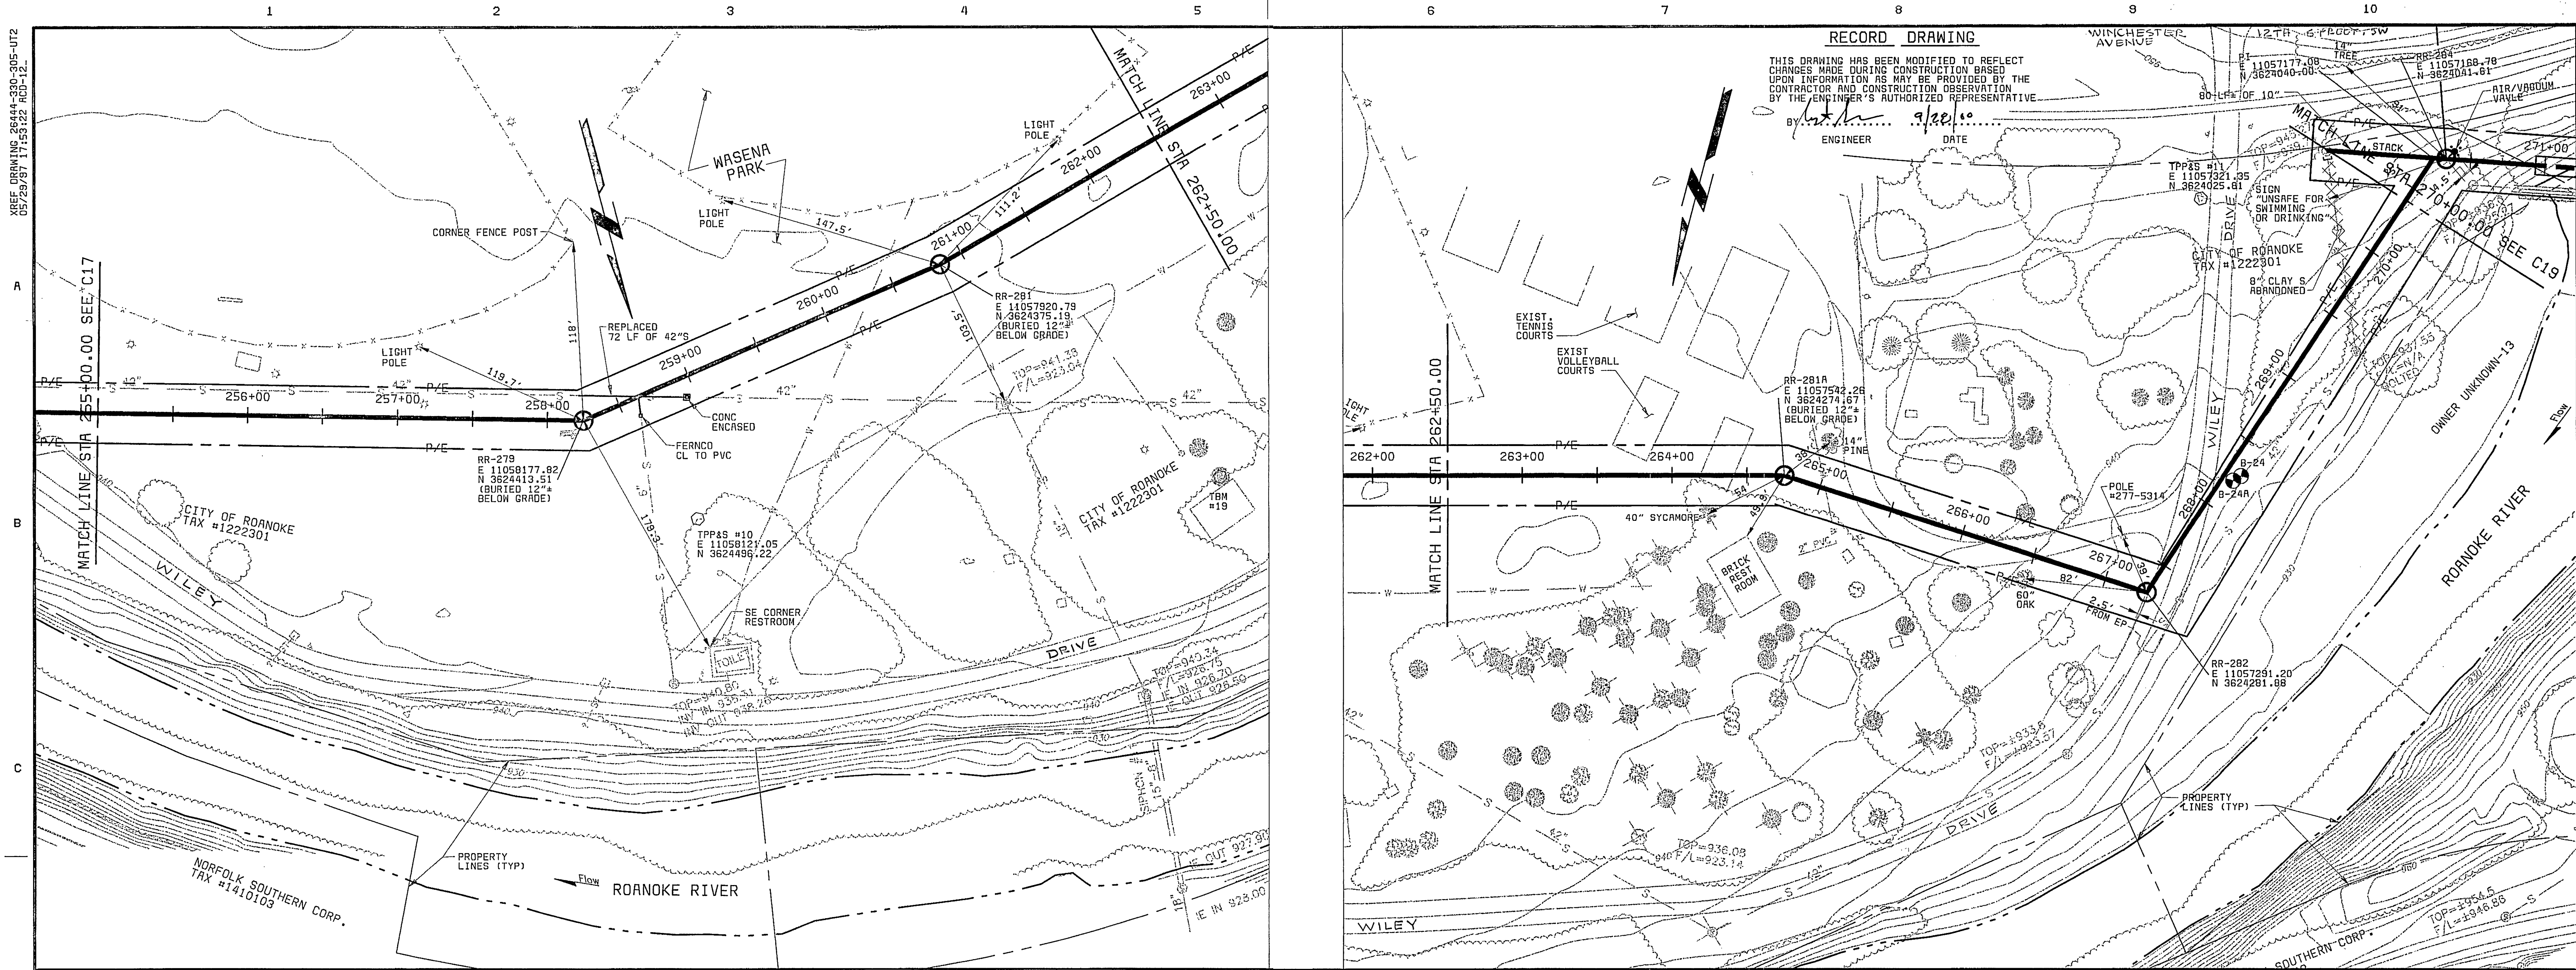

MANHOLE STATIONING AND PIPE LENGTHS:
SEE GENERAL NOTE 16

PCCP PIPE CLASS INFORMATION:
SEE DRAWING C43

SCALE: 1" = 50' HORIZ
1" = 10' VERT

CITY OF ROANOKE, VIRGINIA
ROANOKE RIVER INTERCEPTOR

CONTRACT B2
C18

PLAN AND PROFILE
STA 255+00 TO STA 270+00

THIS DOCUMENT
ORIGINALLY ISSUED
AND SEALED BY
BRENT M. REUSS
PROFESSIONAL ENGINEER,
COMMONWEALTH OF VIRGINIA
REGISTRATION NO. 026345
ON
5-30-97

SHEET
21 OF 30

DESIGNED JBB, SLF
DETAILED RLC, ABW
CHECKED RAF
APPROVED
DATE



PROJECT NO.
26444

DATE REVISIONS AND RECORD OF ISSUE NO. BY CK APP