

26444-300-WMTUP-C-900000303
12/12/2000 08:04:42 ASD

A

B

C

D

E

F

26444-300-WMTUP-C-900000303

01031

000000

DATE

REVISIONS AND RECORD OF ISSUE

NO. BY CK APP

DATE



DESIGNED JBB, SLF

DETAILED RLC, ABW

CHECKED RAF

APPROVED

DATE

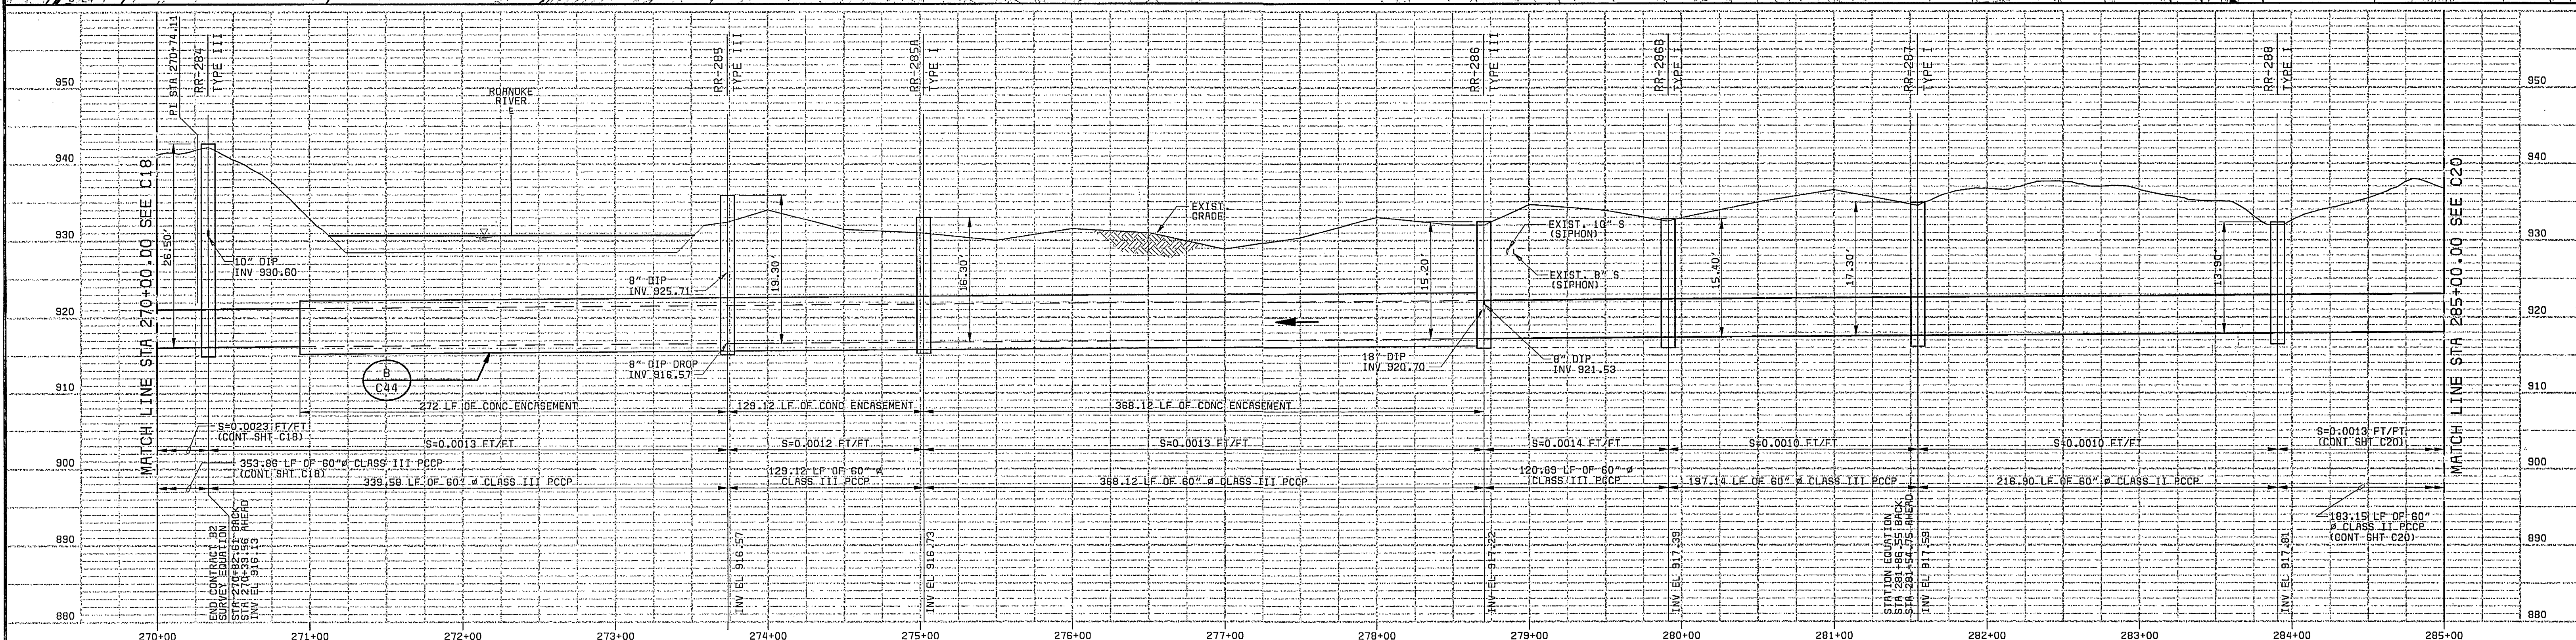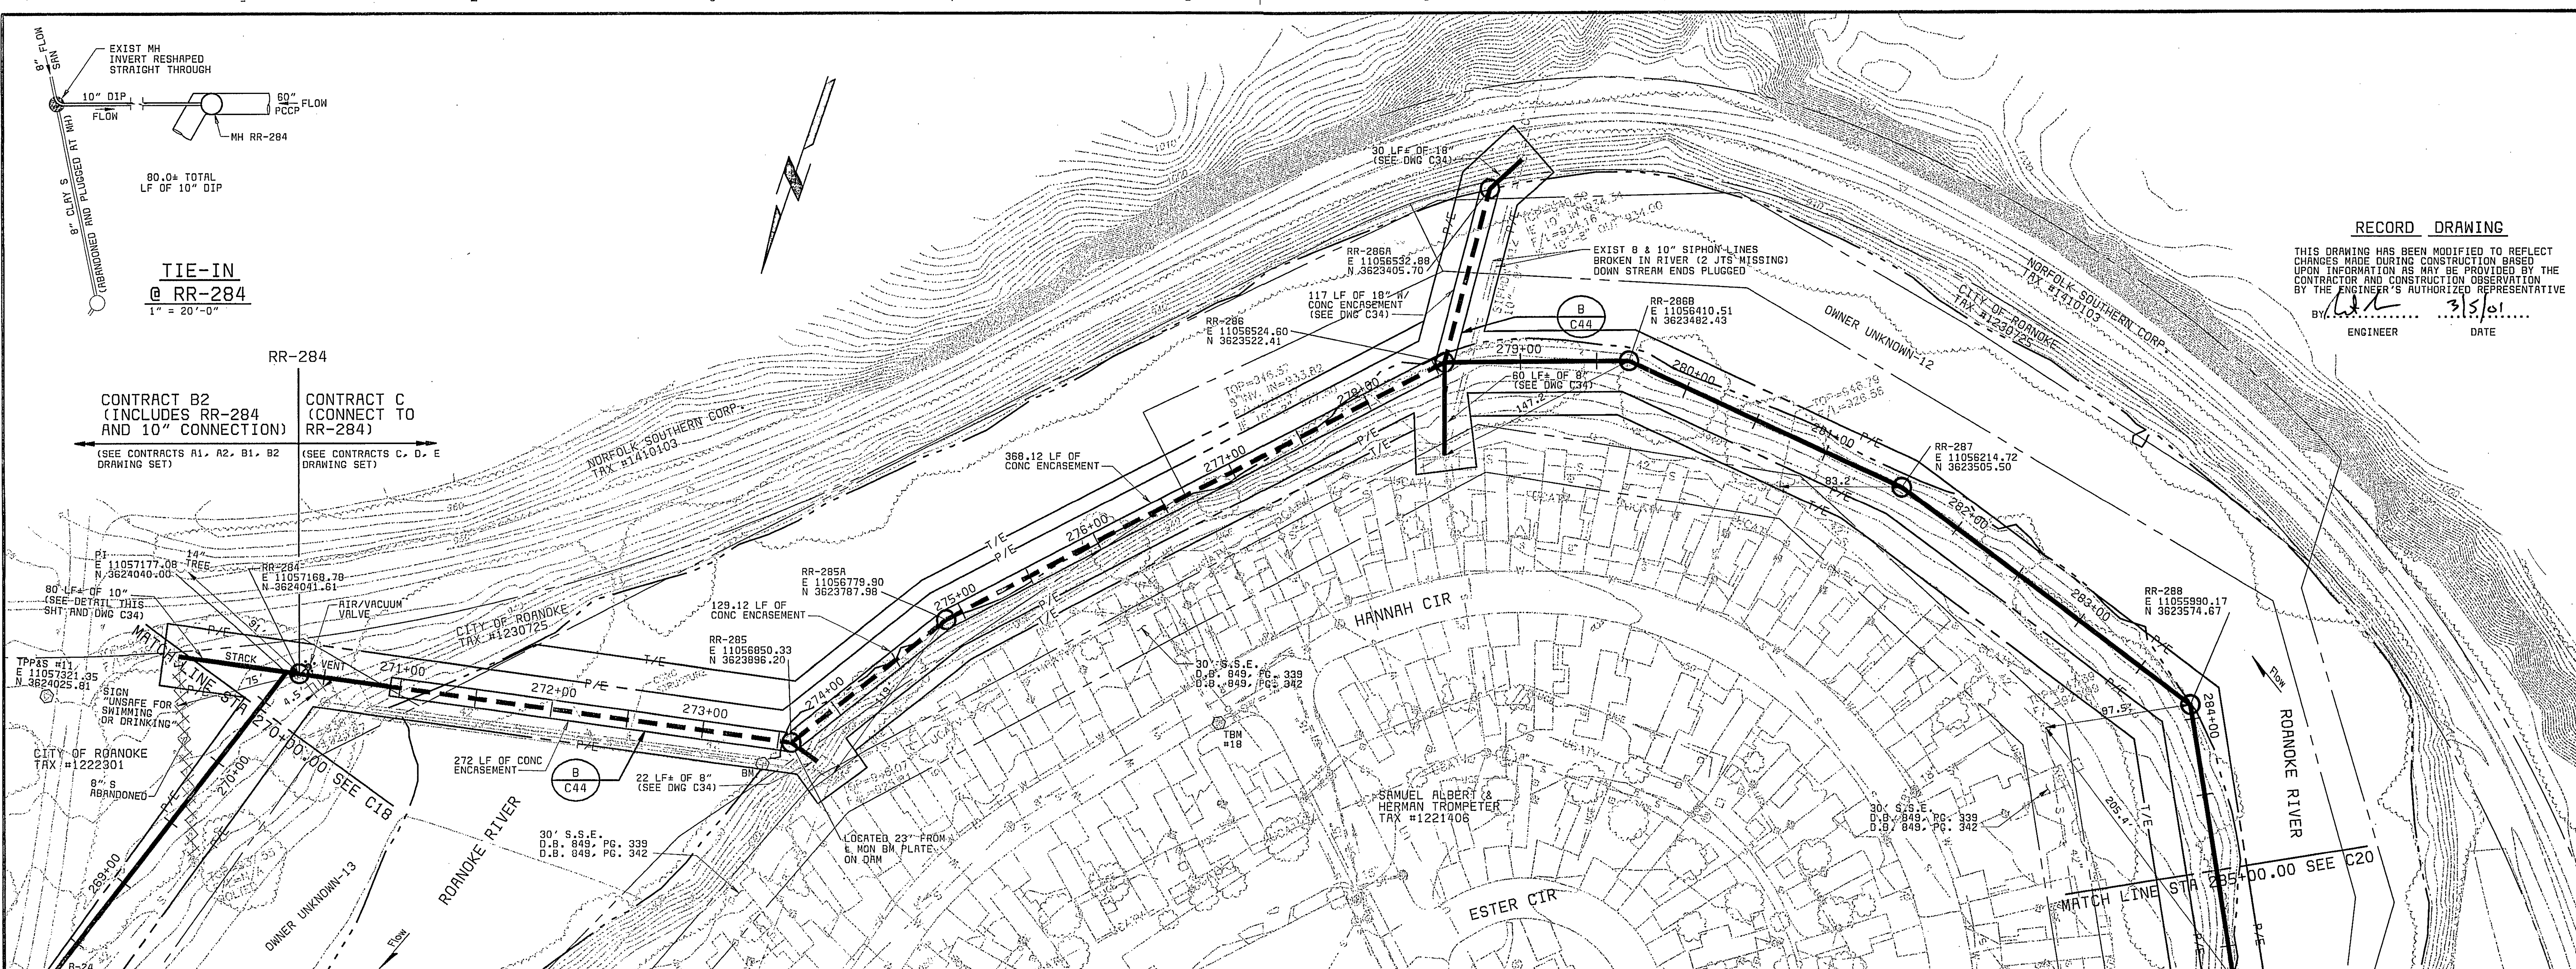

PCCP PIPE CLASS INFORMATION:
SEE DRAWING C43

SCALE: 1" = 50' HORIZ
1" = 10' VERT

CITY OF ROANOKE, VIRGINIA
ROANOKE RIVER INTERCEPTOR

PROJECT NO.

26444

PLAN AND PROFILE
STA 270+00 TO STA 285+00

CONTRACT
B2.C
C19

THIS DOCUMENT
ORIGINALLY ISSUED
AND SEALED BY
BRENT M. REUSS
PROFESSIONAL ENGINEER
COMMONWEALTH OF VIRGINIA
REGISTRATION NO. 026345
12/29/97

SHEET
4 OF 23

RECORD DRAWING
THIS DRAWING HAS BEEN MODIFIED TO REFLECT
CHANGES MADE DURING CONSTRUCTION BASED
UPON INFORMATION AS MAY BE PROVIDED BY THE
CONTRACTOR AND CONSTRUCTION OBSERVATION
BY THE ENGINEER'S AUTHORIZED REPRESENTATIVE
BY: [Signature] 3/5/01
ENGINEER DATE