
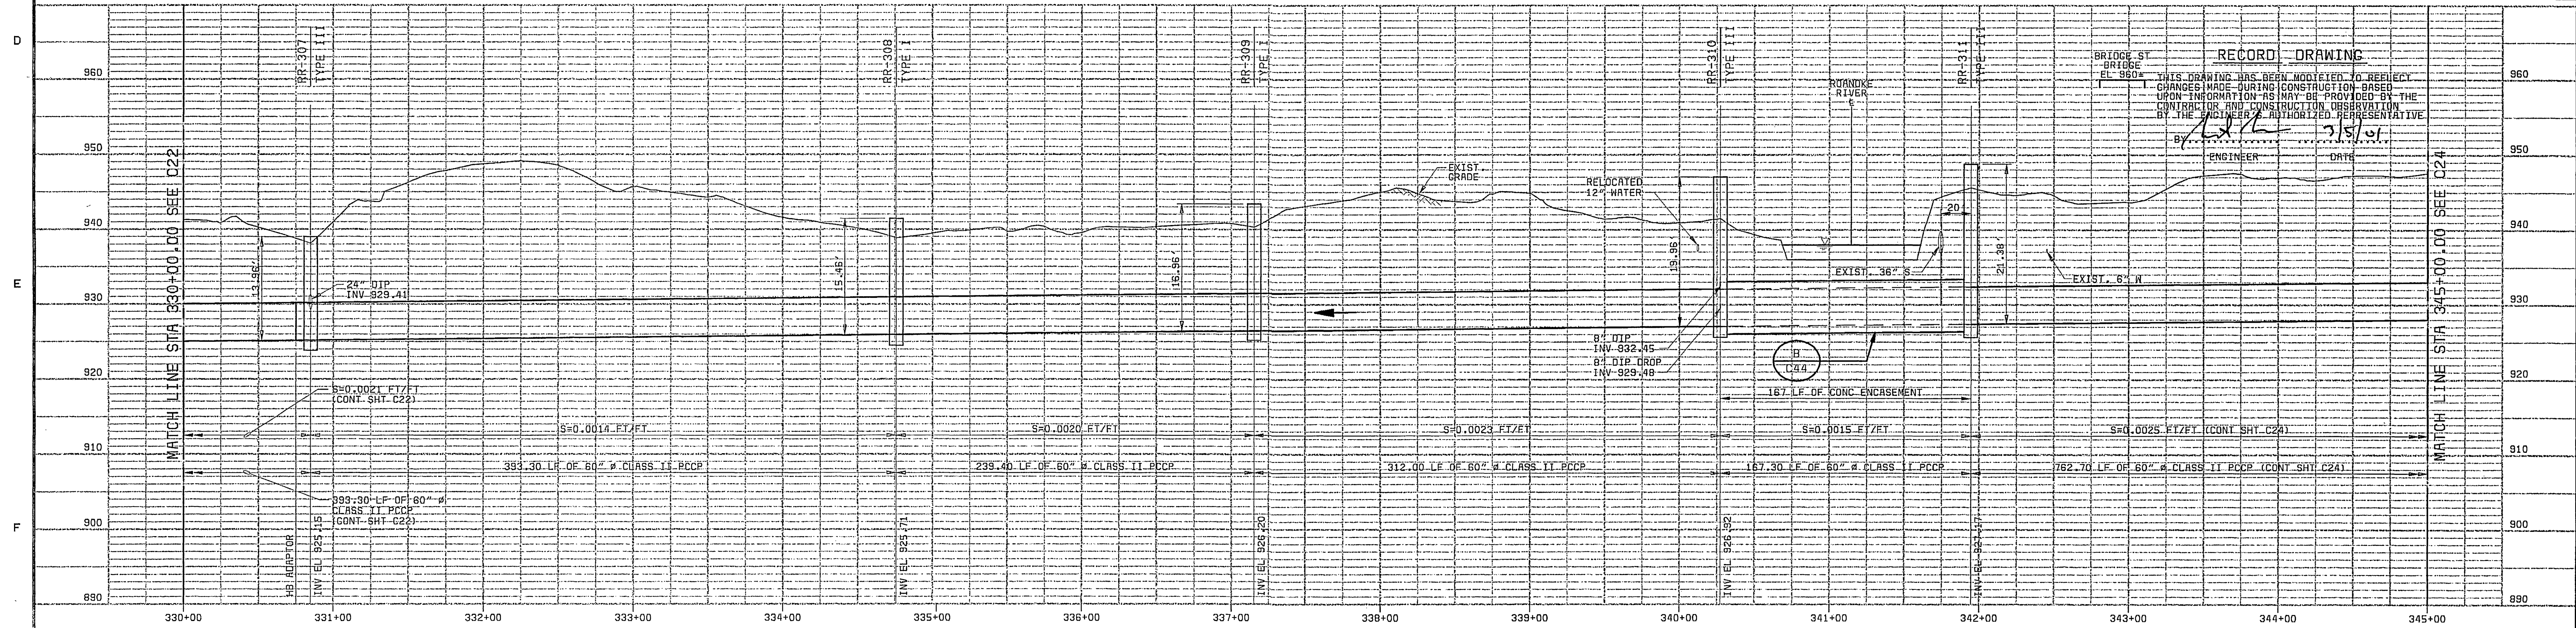


26444-300-WMTUP-C-800000313  
XREF DRAWING 26444-300-WMTUP-C-800000313  
12/12/2000 05:53:13 130 TAD

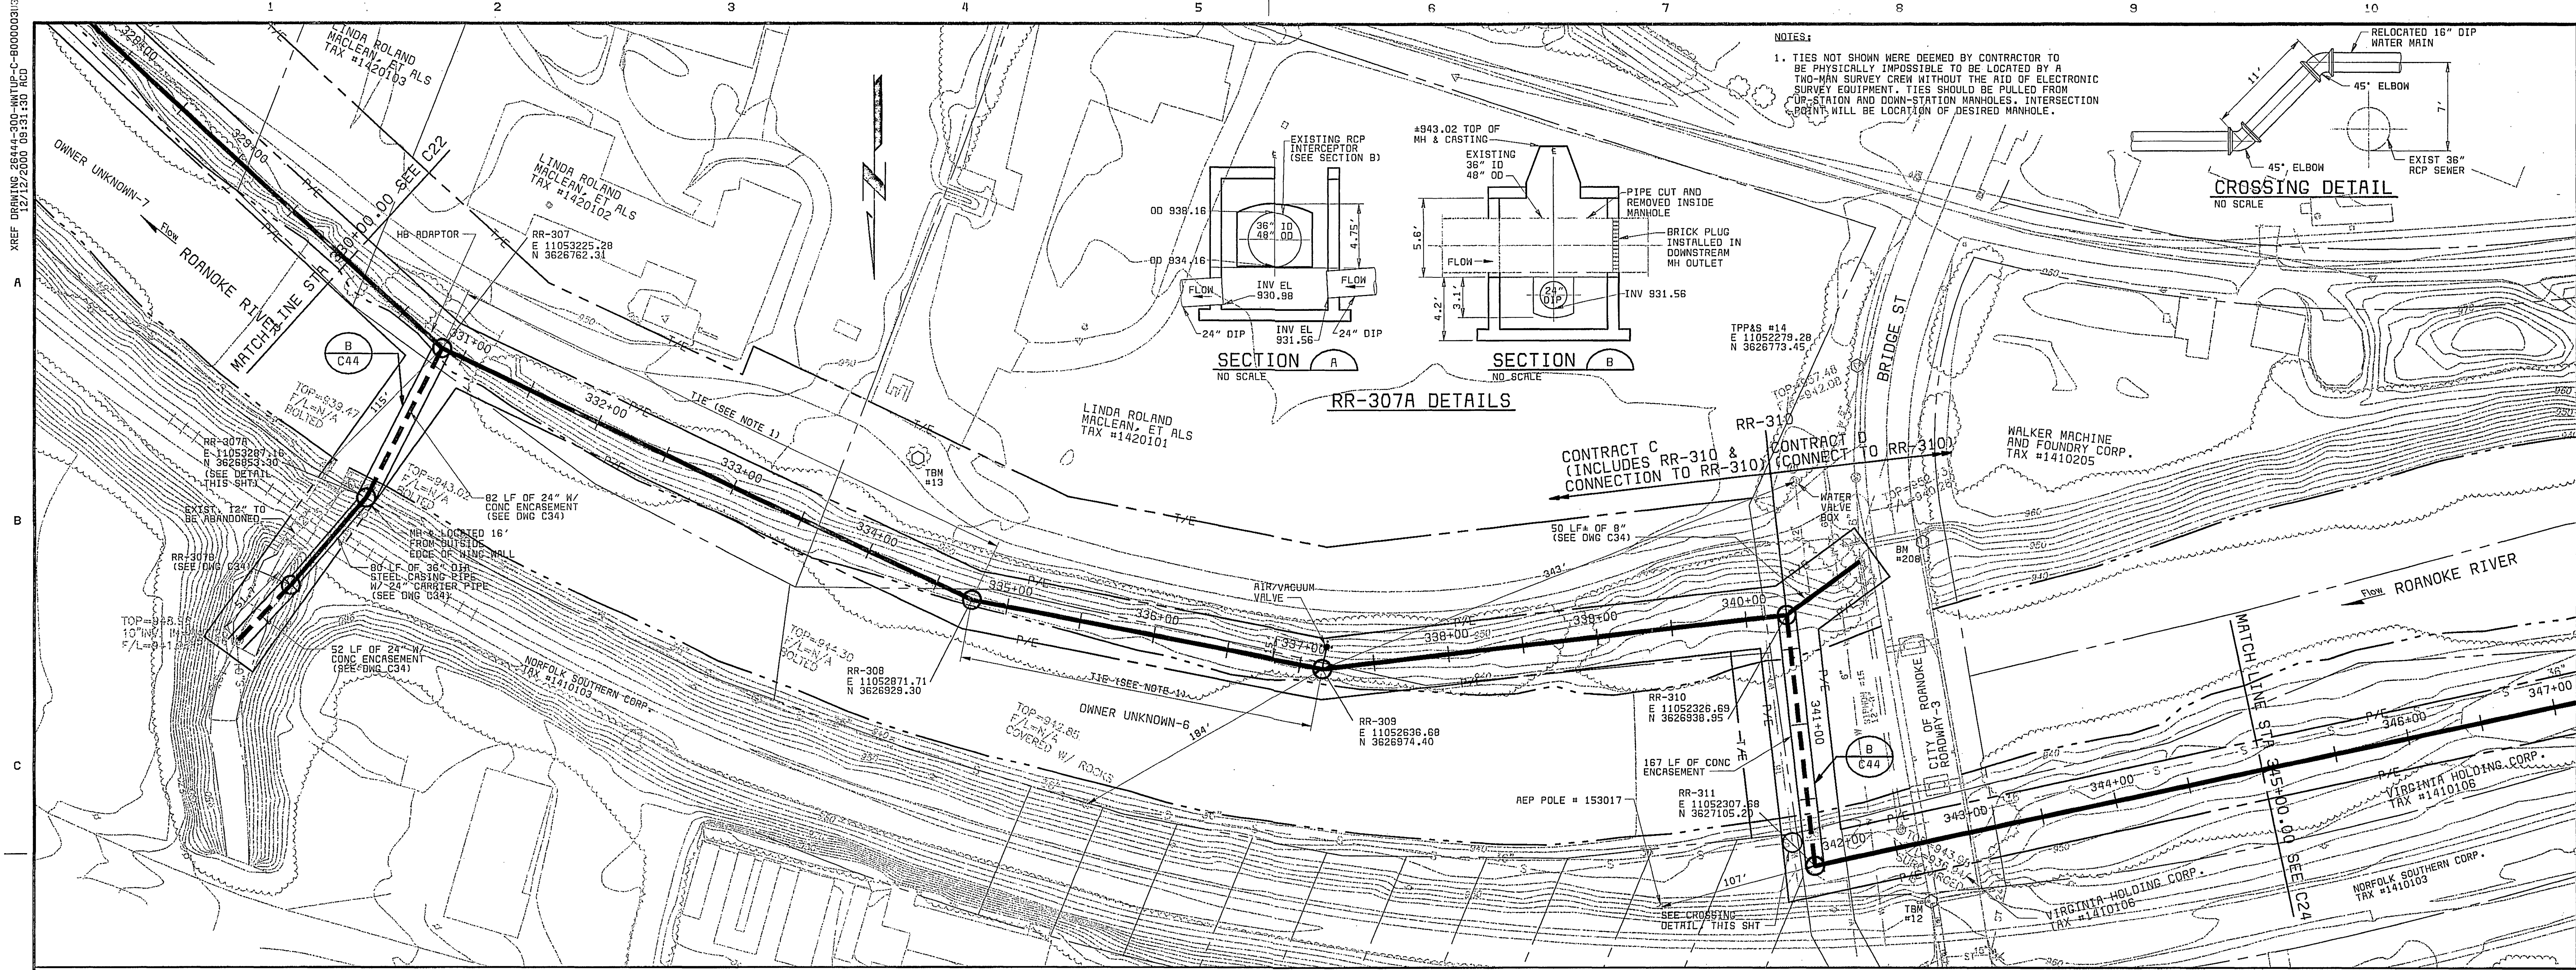

PCCP PIPE CLASS INFORMATION:  
SEE DRAWING C43

SCALE: 1" = 50' HORIZ  
1" = 10' VERT

CITY OF ROANOKE, VIRGINIA  
ROANOKE RIVER INTERCEPTOR

CONTRACT  
C-23

PLAN AND PROFILE  
STA 330+00 TO STA 345+00

THIS DOCUMENT  
ORIGINALLY ISSUED  
AND SEALED BY  
BRENT N. REUSS  
PROFESSIONAL ENGINEER,  
COMMONWEALTH OF VIRGINIA  
REGISTRATION NO. 026345  
ON  
12/29/97

SHEET  
8 OF 23

26444-300-WMTUP-C-800000313  
01/03/1  
FC00000

DESIGNED JBB, SLF  
DETAILED RLC, ABW  
CHECKED RAF  
APPROVED  
DATE



PROJECT NO.  
26444

| DATE | REVISIONS AND RECORD OF ISSUE | NO. | BY | CK | APP |
|------|-------------------------------|-----|----|----|-----|
|      |                               |     |    |    |     |