

26444-300-WMTUP-C-80000030C
01031
F000000

26444-300-WMTUP-C-80000030C
01031
F000000



26444-300-WMTUP-C-80000030C
01031
F000000

26444-300-WMTUP-C-80000030C
01031
F000000

26444-300-WMTUP-C-80000030C
01031
F000000

26444-300-WMTUP-C-80000030C
01031
F000000

26444-300-WMTUP-C-80000030C
01031
F000000

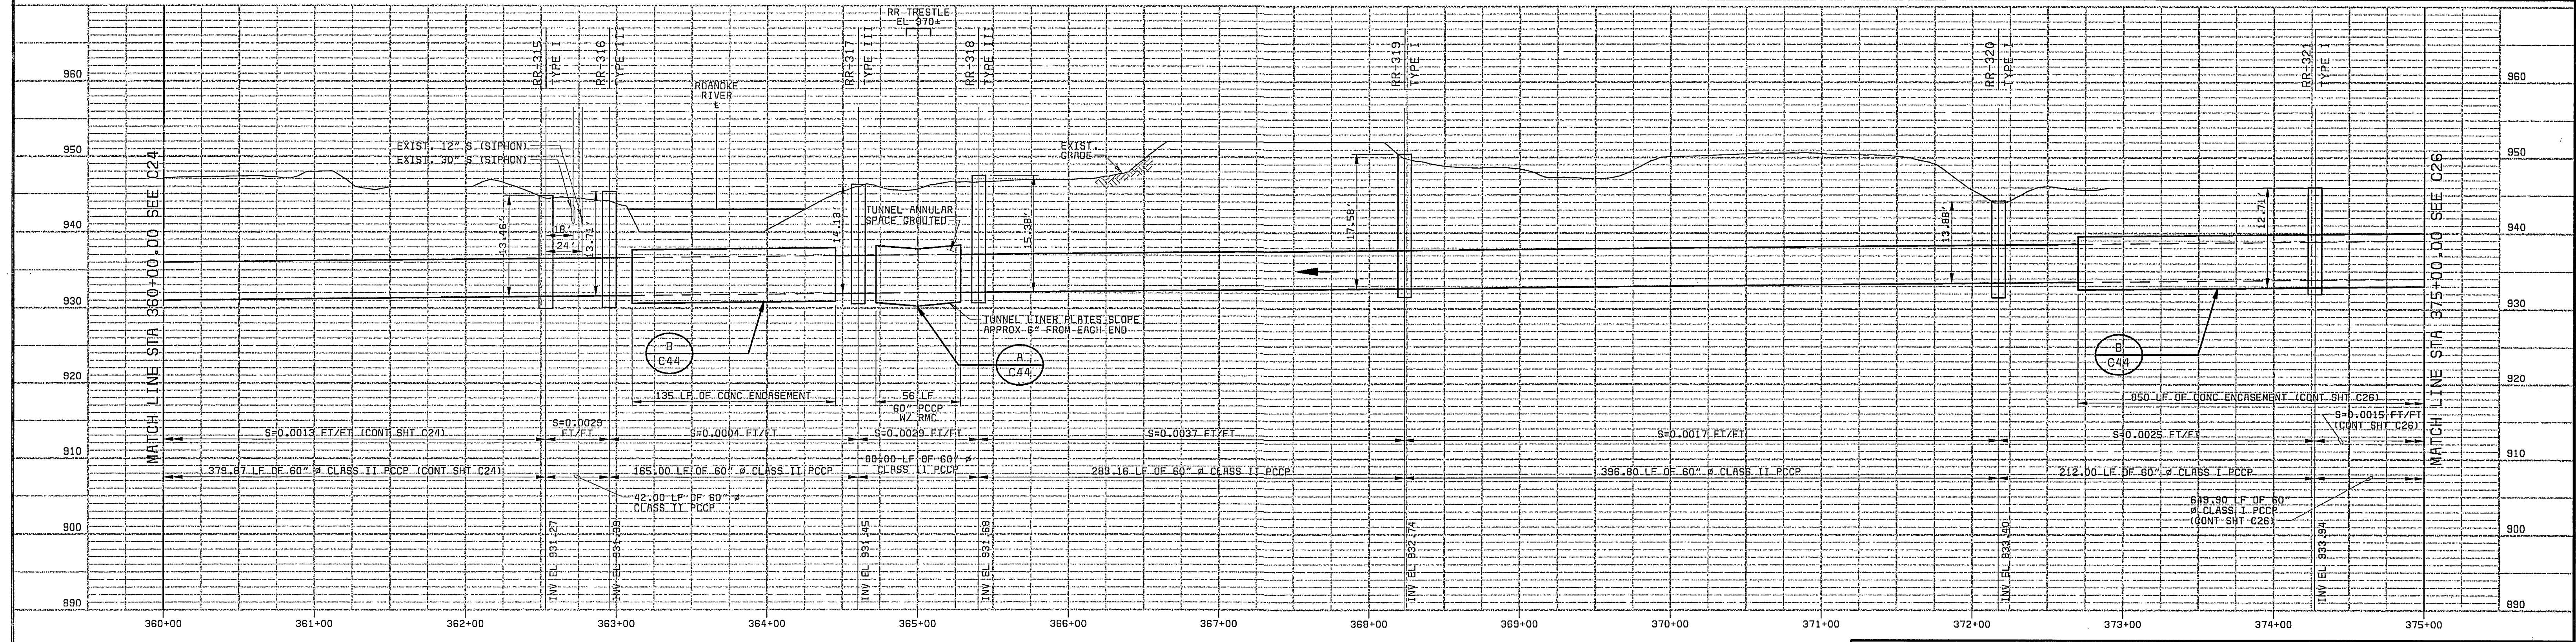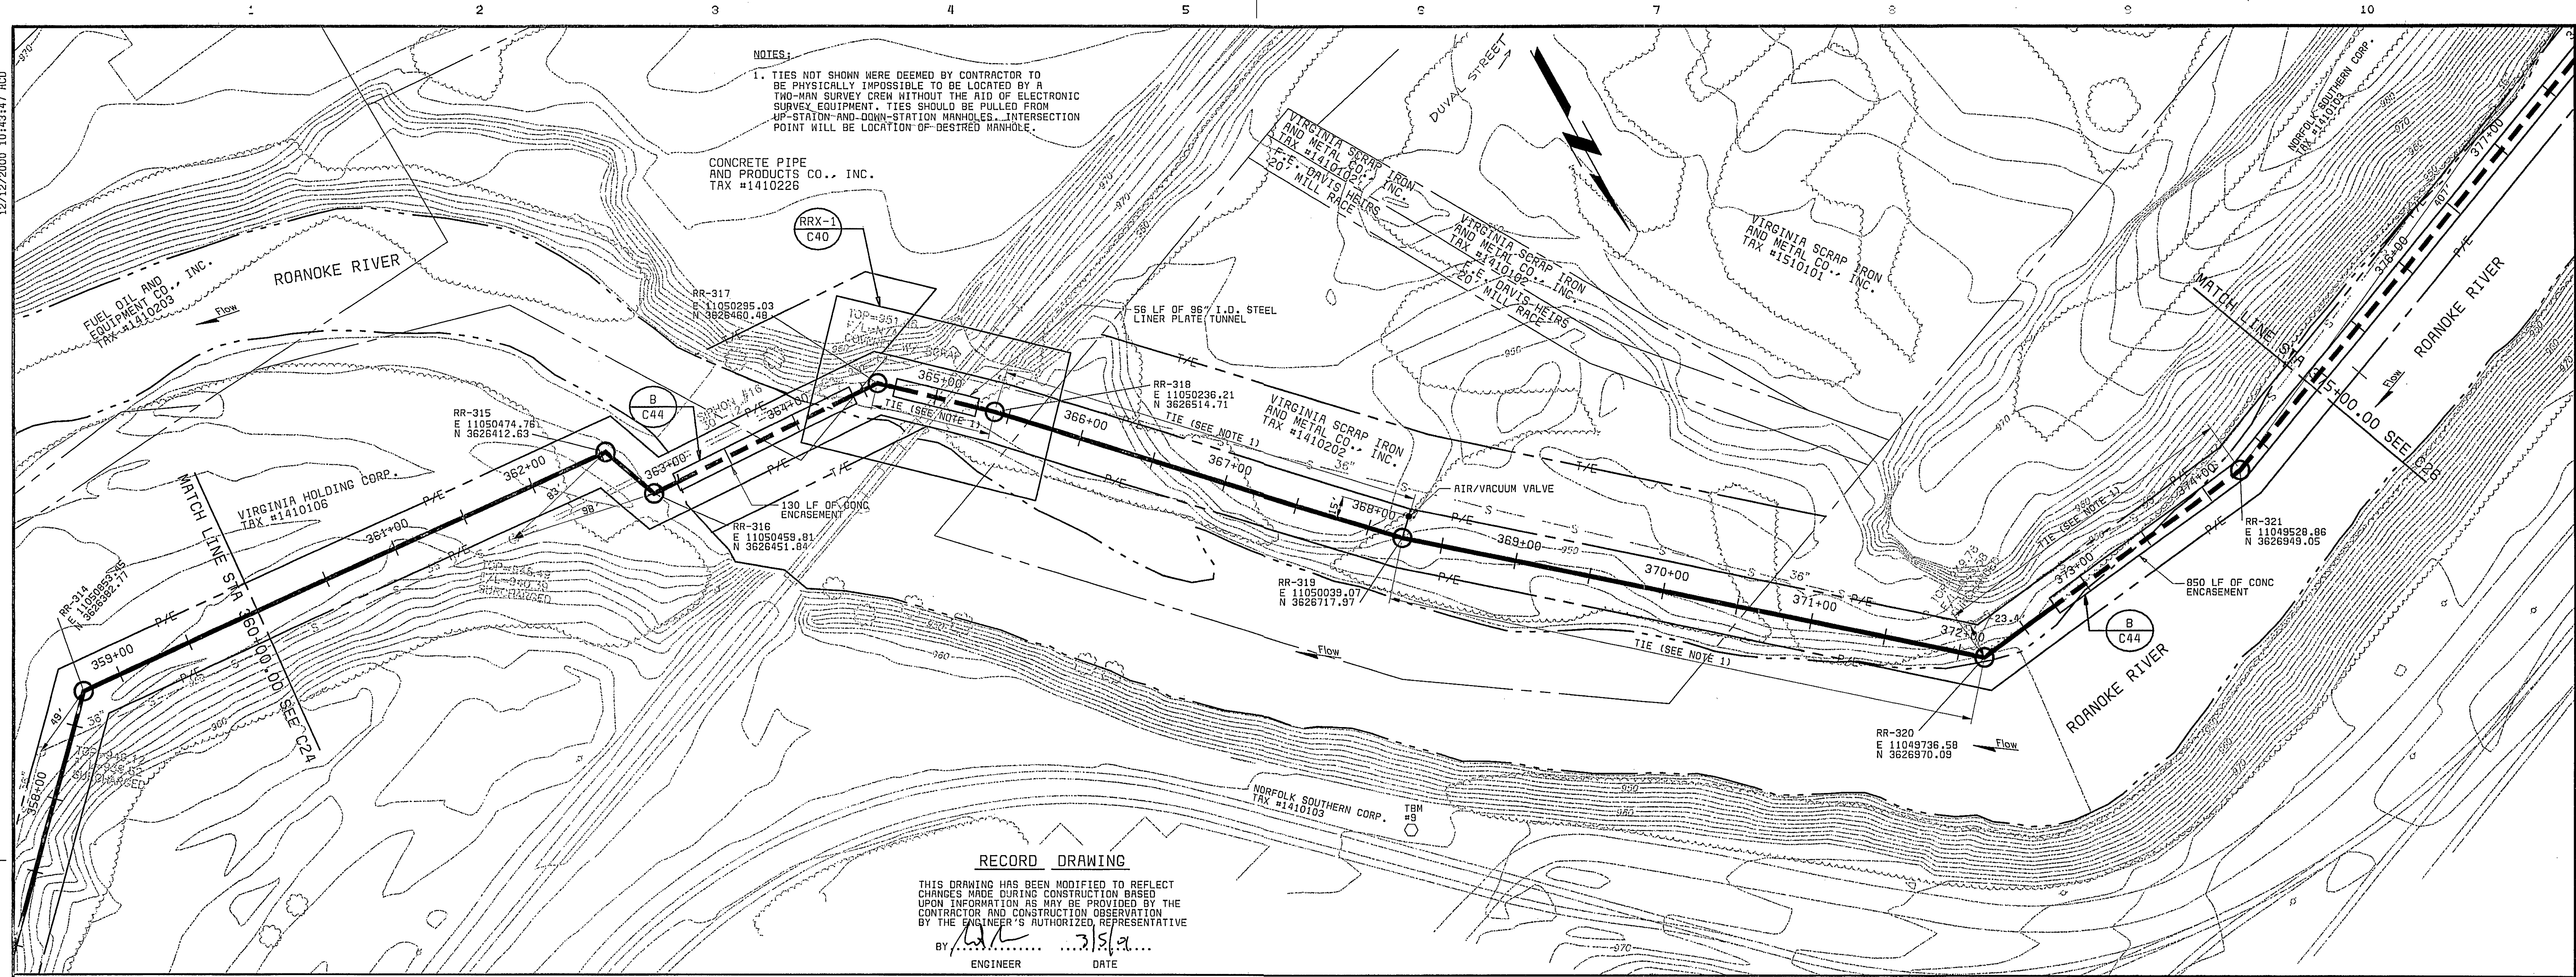

PCCP PIPE CLASS INFORMATION:
SEE DRAWING C43

SCALE: 1" = 50' HORIZ
1" = 10' VERT

CITY OF ROANOKE, VIRGINIA ROANOKE RIVER INTERCEPTOR	CONTRACT D C25	
		PLAN AND PROFILE STA 360+00 TO STA 375+00
		THIS DOCUMENT ORIGINALLY ISSUED AND SEALED BY BRENT M. REUSS PROFESSIONAL ENGINEER, COMMONWEALTH OF VIRGINIA REGISTRATION NO. 026345 ON 12/29/97
DESIGNED: JBB, SLF DETAILED: RLC, ABW CHECKED: RAF APPROVED: _____ DATE: _____	PROJECT NO. 26444	



DATE	REVISIONS AND RECORD OF ISSUE	NO.	BY	CK	APP