
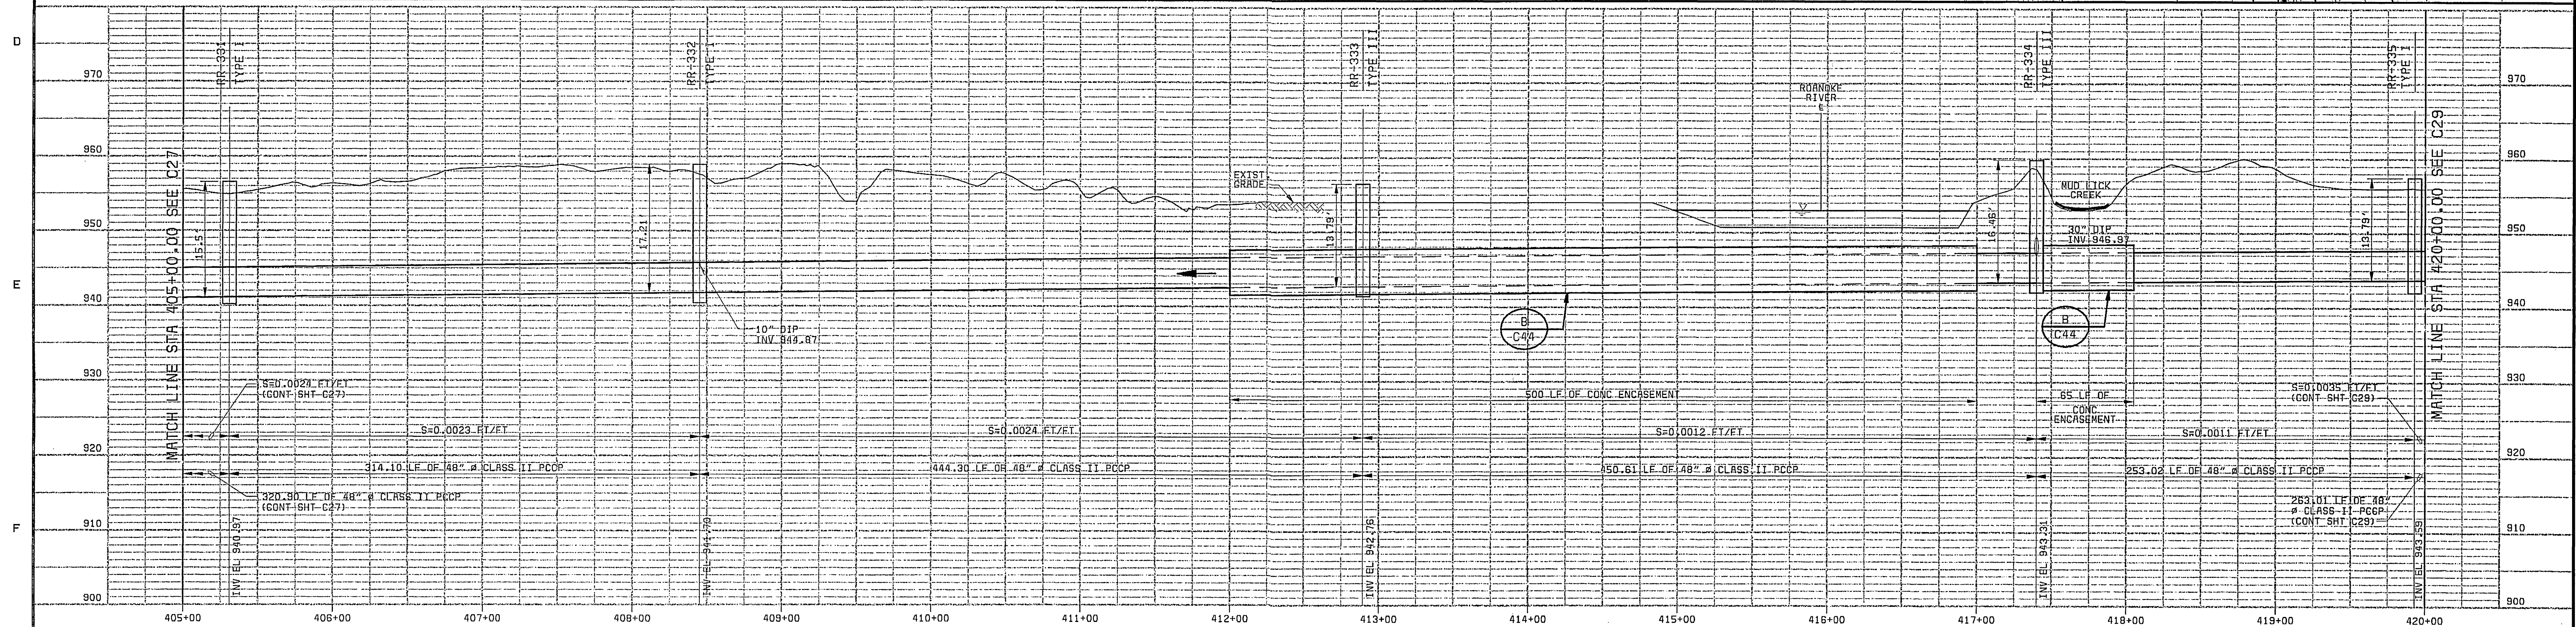


XREF DRAWING 26444-300-WMTUP-C-800000303
12/12/2000 14:25:28 RCD

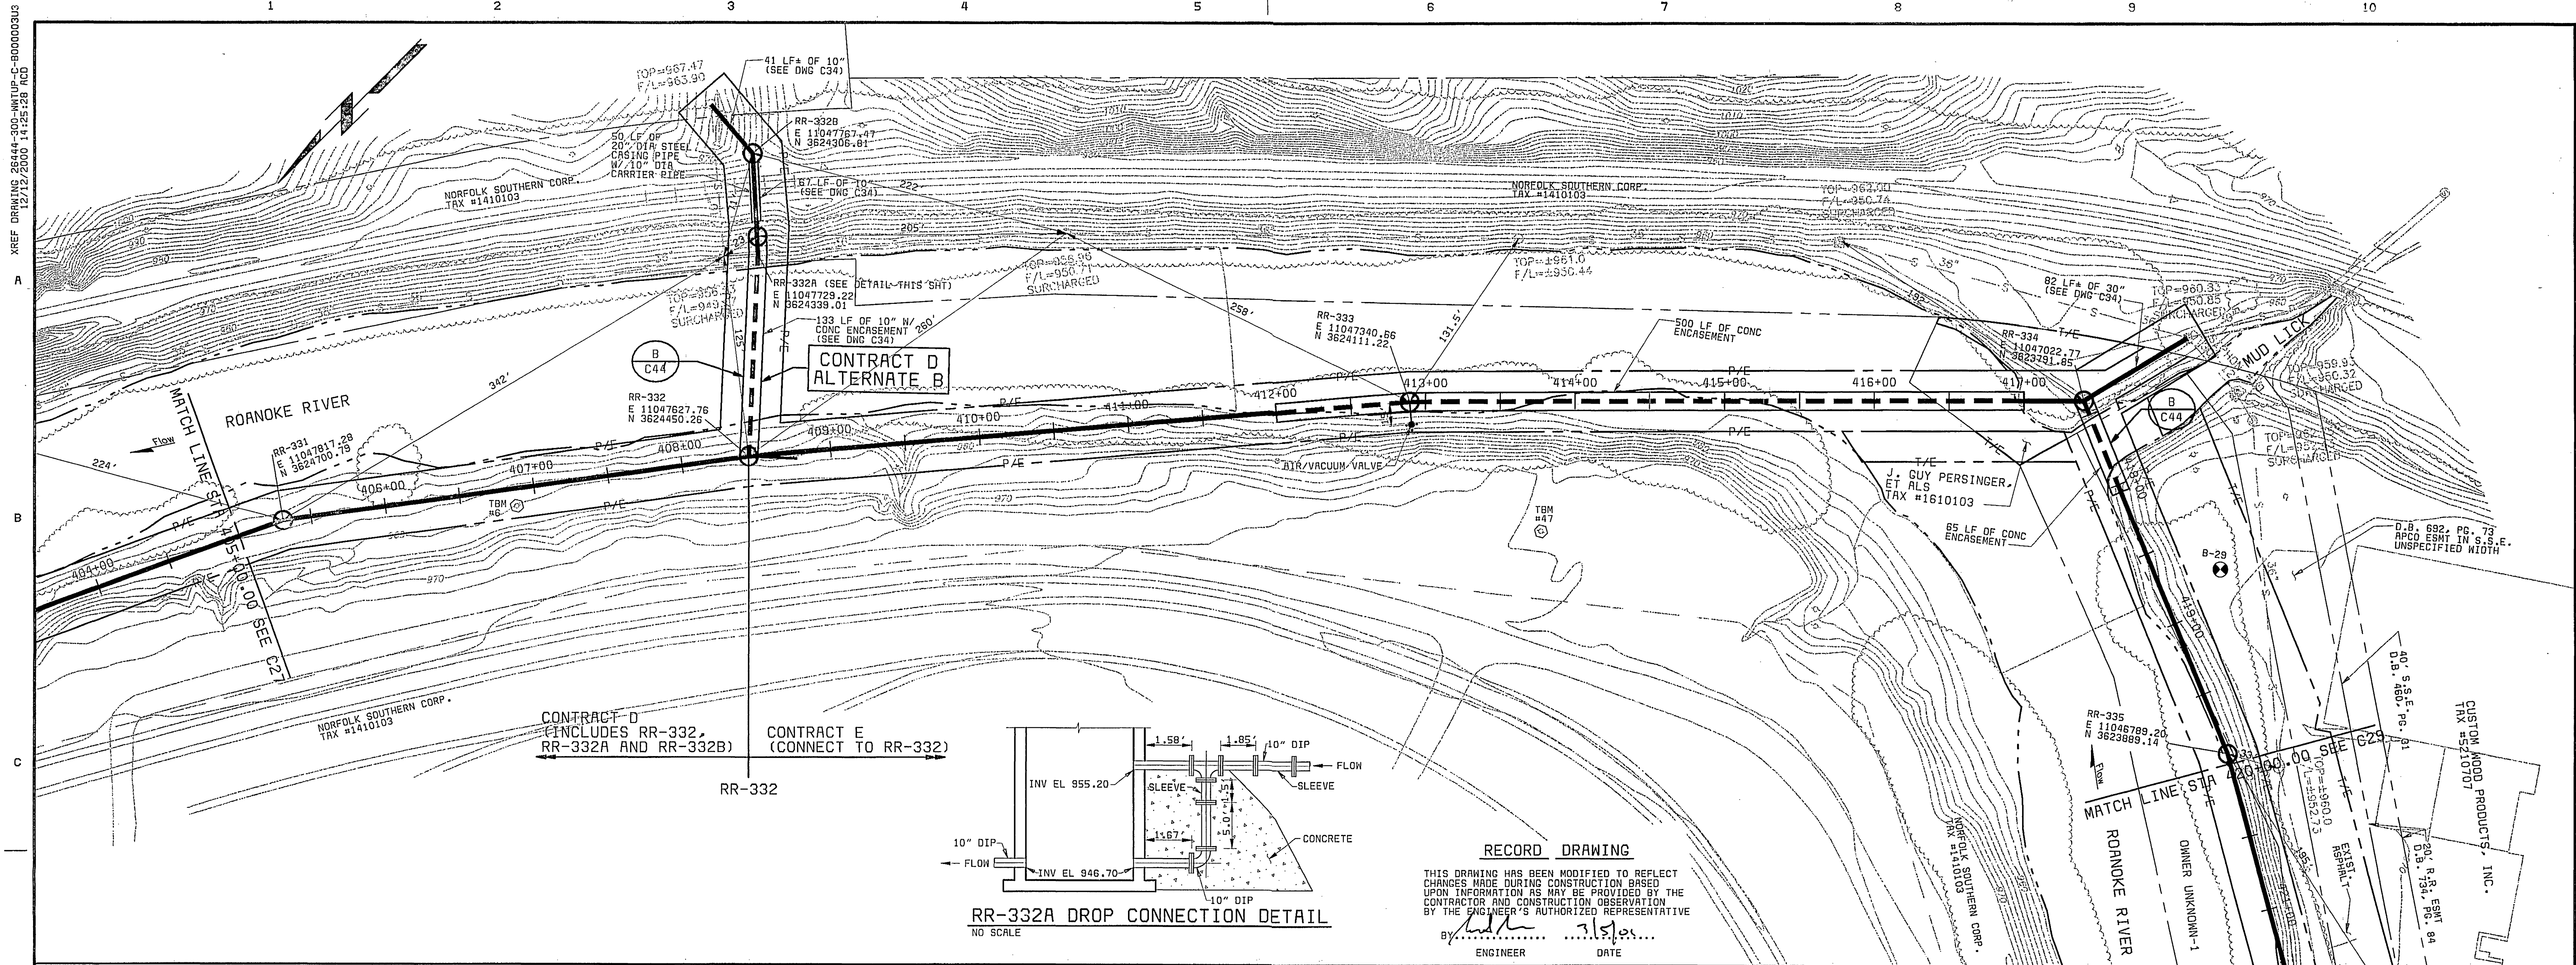

PCCP PIPE CLASS INFORMATION:
SEE DRAWING C43

SCALE: 1" = 50' HORIZ
1" = 10' VERT

CITY OF ROANOKE, VIRGINIA
ROANOKE RIVER INTERCEPTOR

CONTRACT
D.E
C28

PLAN AND PROFILE
STA 405+00 TO STA 420+00

THIS DOCUMENT
ORIGINALLY ISSUED
AND SEALED BY
BRENT W. REISS
PROFESSIONAL ENGINEER,
COMMONWEALTH OF VIRGINIA
REGISTRATION NO. 026345
ON
12/29/97

SHEET
13 OF 23

26444-300-WMTUP-C-800000303
01/03/1
FG00000

DESIGNED JBB, SLF
DETAILED RLC, ABW
CHECKED RAF
APPROVED
DATE



PROJECT NO.
26444

DATE REVISIONS AND RECORD OF ISSUE NO. BY CK APP