

26444-300-WMTUP-C-900003UH
12/19/97 1:14:50 RCD-12

1

2

3

4

5



6

7

8

9

10

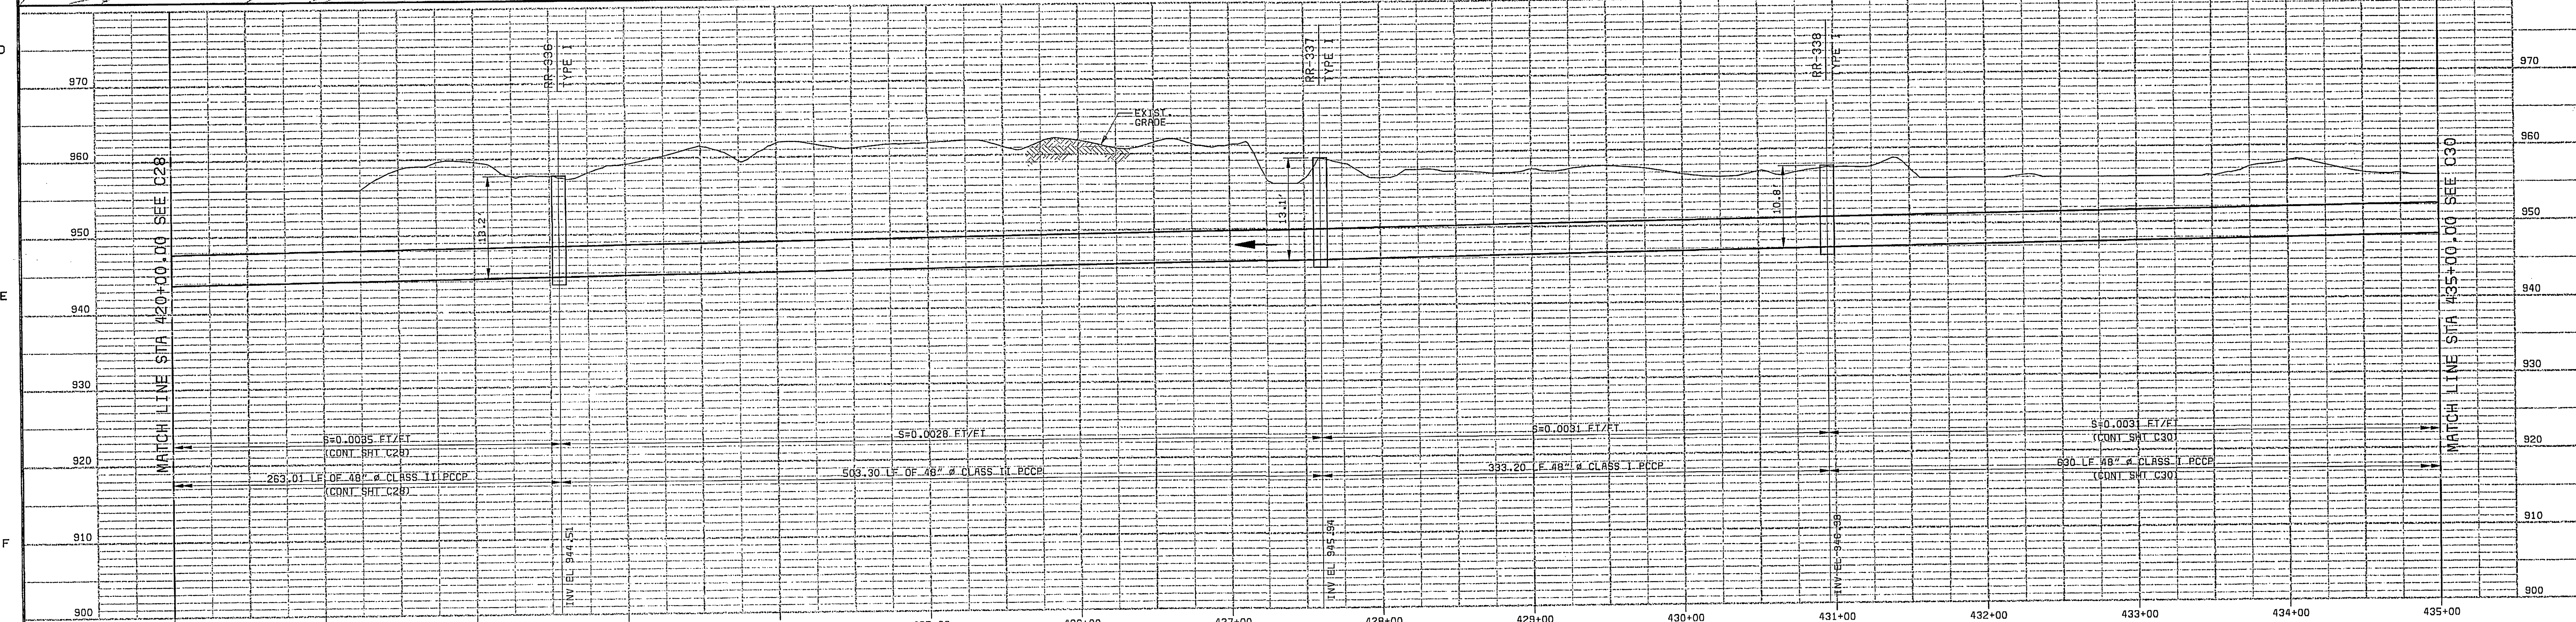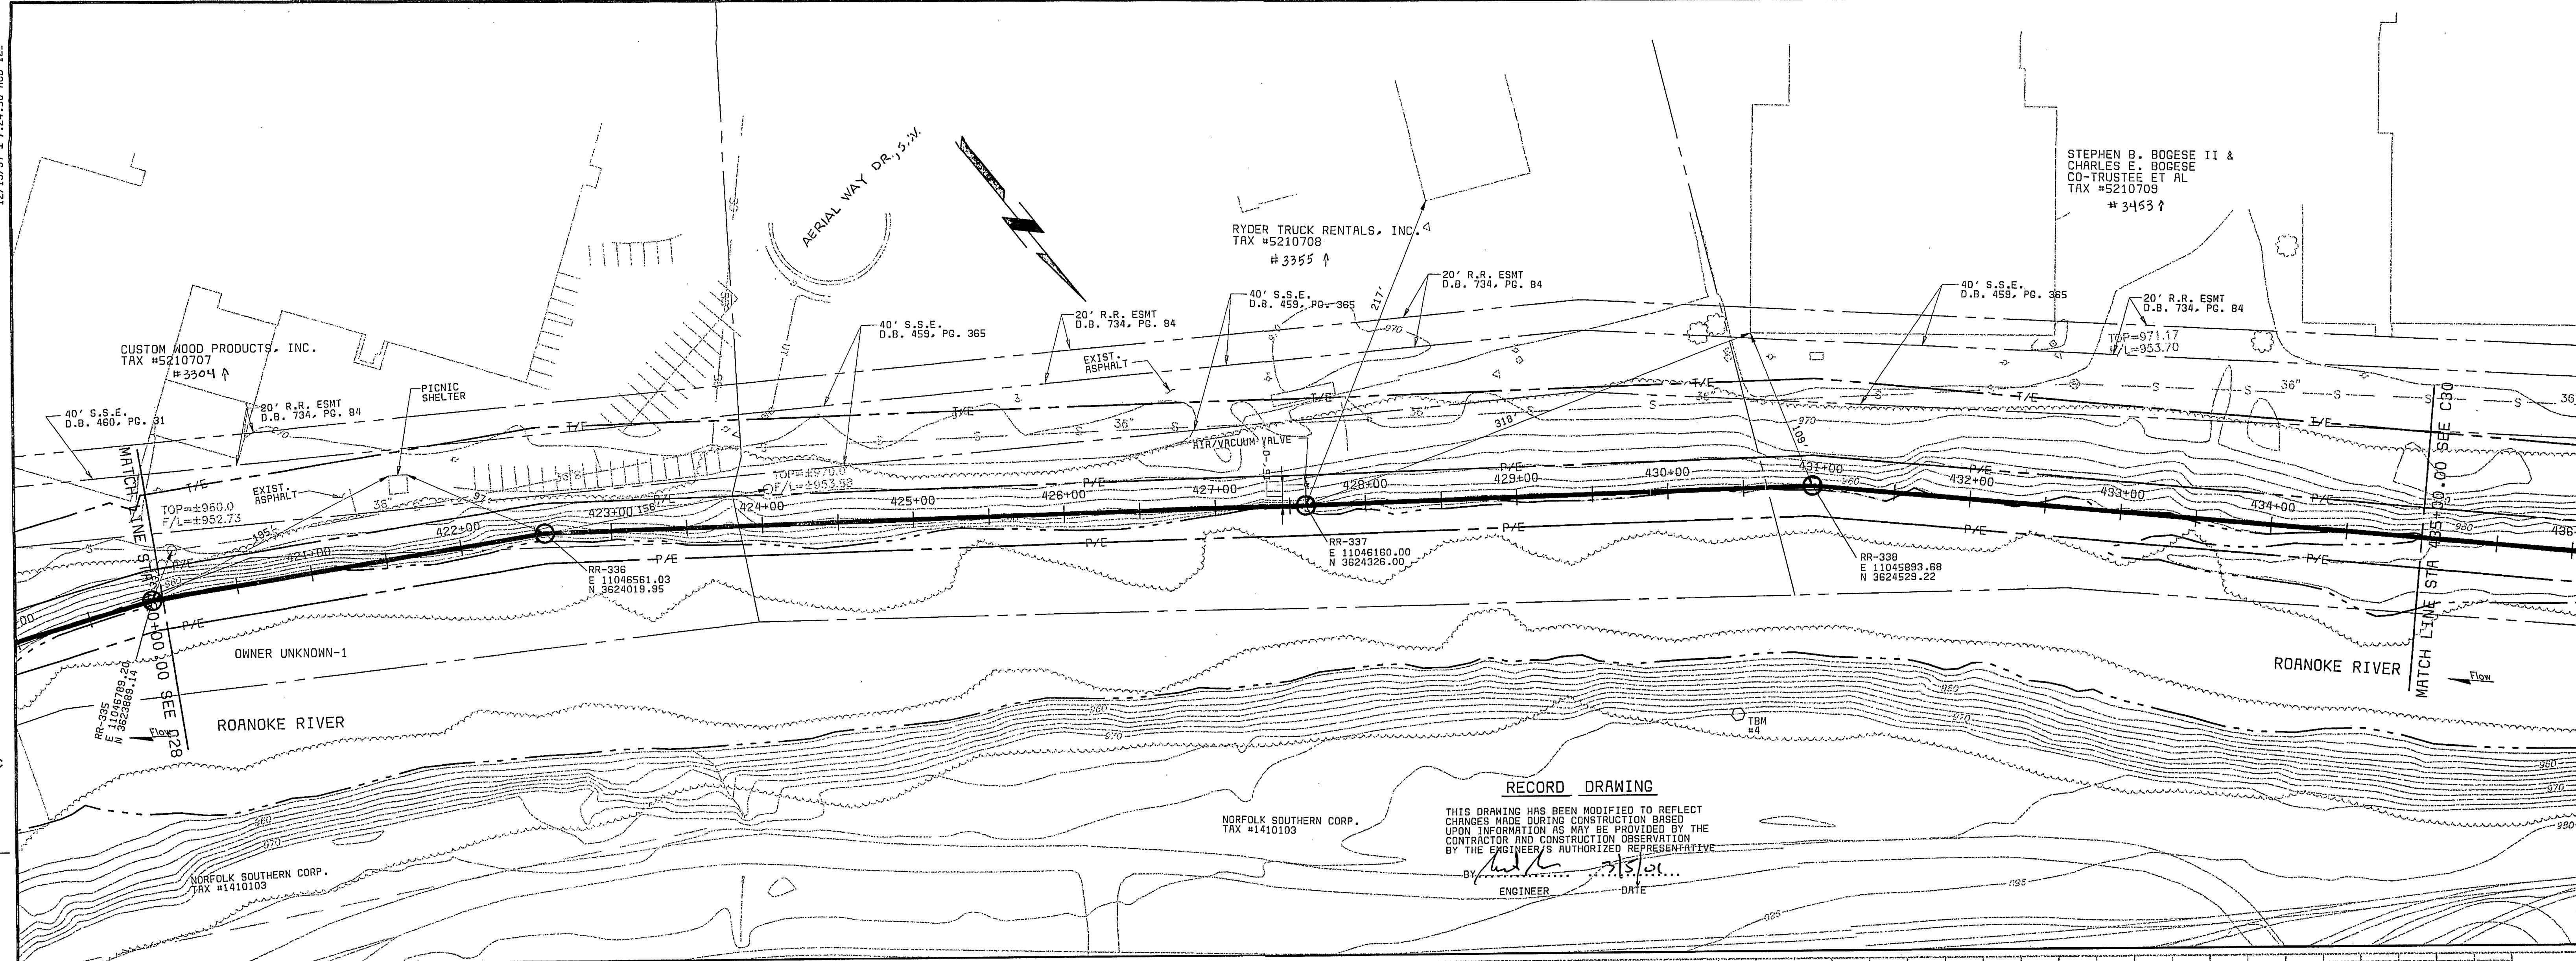

PCCP PIPE CLASS INFORMATION:
SEE DRAWING C43

SCALE: 1" = 50' HORIZ
1" = 10' VERT

CITY OF ROANOKE, VIRGINIA
ROANOKE RIVER INTERCEPTOR

PLAN AND PROFILE
STA 420+00 TO STA 435+00

CONTRACT E
C29

THIS DOCUMENT
ORIGINALLY ISSUED
AND SEALED BY
BRENT M. REUSS
PROFESSIONAL ENGINEER,
COMMONWEALTH OF VIRGINIA
REGISTRATION NO. 026345
ON
12/29/97

SHEET
14 OF 23

26444-300-WMTUP-C-900003UH
01/03/1998

DATE	REVISIONS AND RECORD OF ISSUE	NO.	BY	CK	APP

DESIGNED JBB, SLF
DETAILED RLC, ABW
CHECKED RAF
APPROVED
DATE



PROJECT NO.
26444