

DATE: 12-30-92
BY: [Signature]
CHECKED: [Signature]
NOTED: [Signature]
NO. 1


DATE: 12-30-92
BY: [Signature]
CHECKED: [Signature]
NOTED: [Signature]
NO. 1

SANITARY PIPE DESIGN SCHEDULE			
MANHOLE TO MANHOLE	LENGTH EDGE MANHOLE TO EDGE MANHOLE	GRADE %	PIPE SIZE
EXIST MH - MH1	133.0'	3.44	8"
MH1 - MH2	164.2'	14.00	8"
MH2 - MH4	199.8'	2.26	8"
MH4 - MH5	101.1'	2.24	8"
MH5 - CLEANOUT	46.3'	6.88	8"
MH2 - MH3	161.0'	3.51	8"

THE SEWER DESIGN AS INDICATED IN THE SCHEDULE ABOVE HAS BEEN PERFORMED UNDER THE DIRECTION OF AND IN THE OFFICE OF THE UNDERSIGNED. THE UNDERSIGNED HAS ALSO VERIFIED THAT THE PLAN AND PROFILE OF THE ROBERT J. MILLER SEWER SYSTEM AS SHOWN ON THE DRAWING, DATED DECEMBER 30, 1992, PREPARED BY JACK G. BESS, C.L.S. CONFORMS TO THE ABOVE DESIGN.

RICHARD L. WILLIAMS
CONSULTING ENGINEERS, INC.
ROANOKE, VIRGINIA
DATE 1-20-93
COUNT NO. 92-291

NOTE: TAP TO EXISTING MANHOLE BY ROANOKE COUNTY AFTER EXCAVATION BY CONTRACTOR

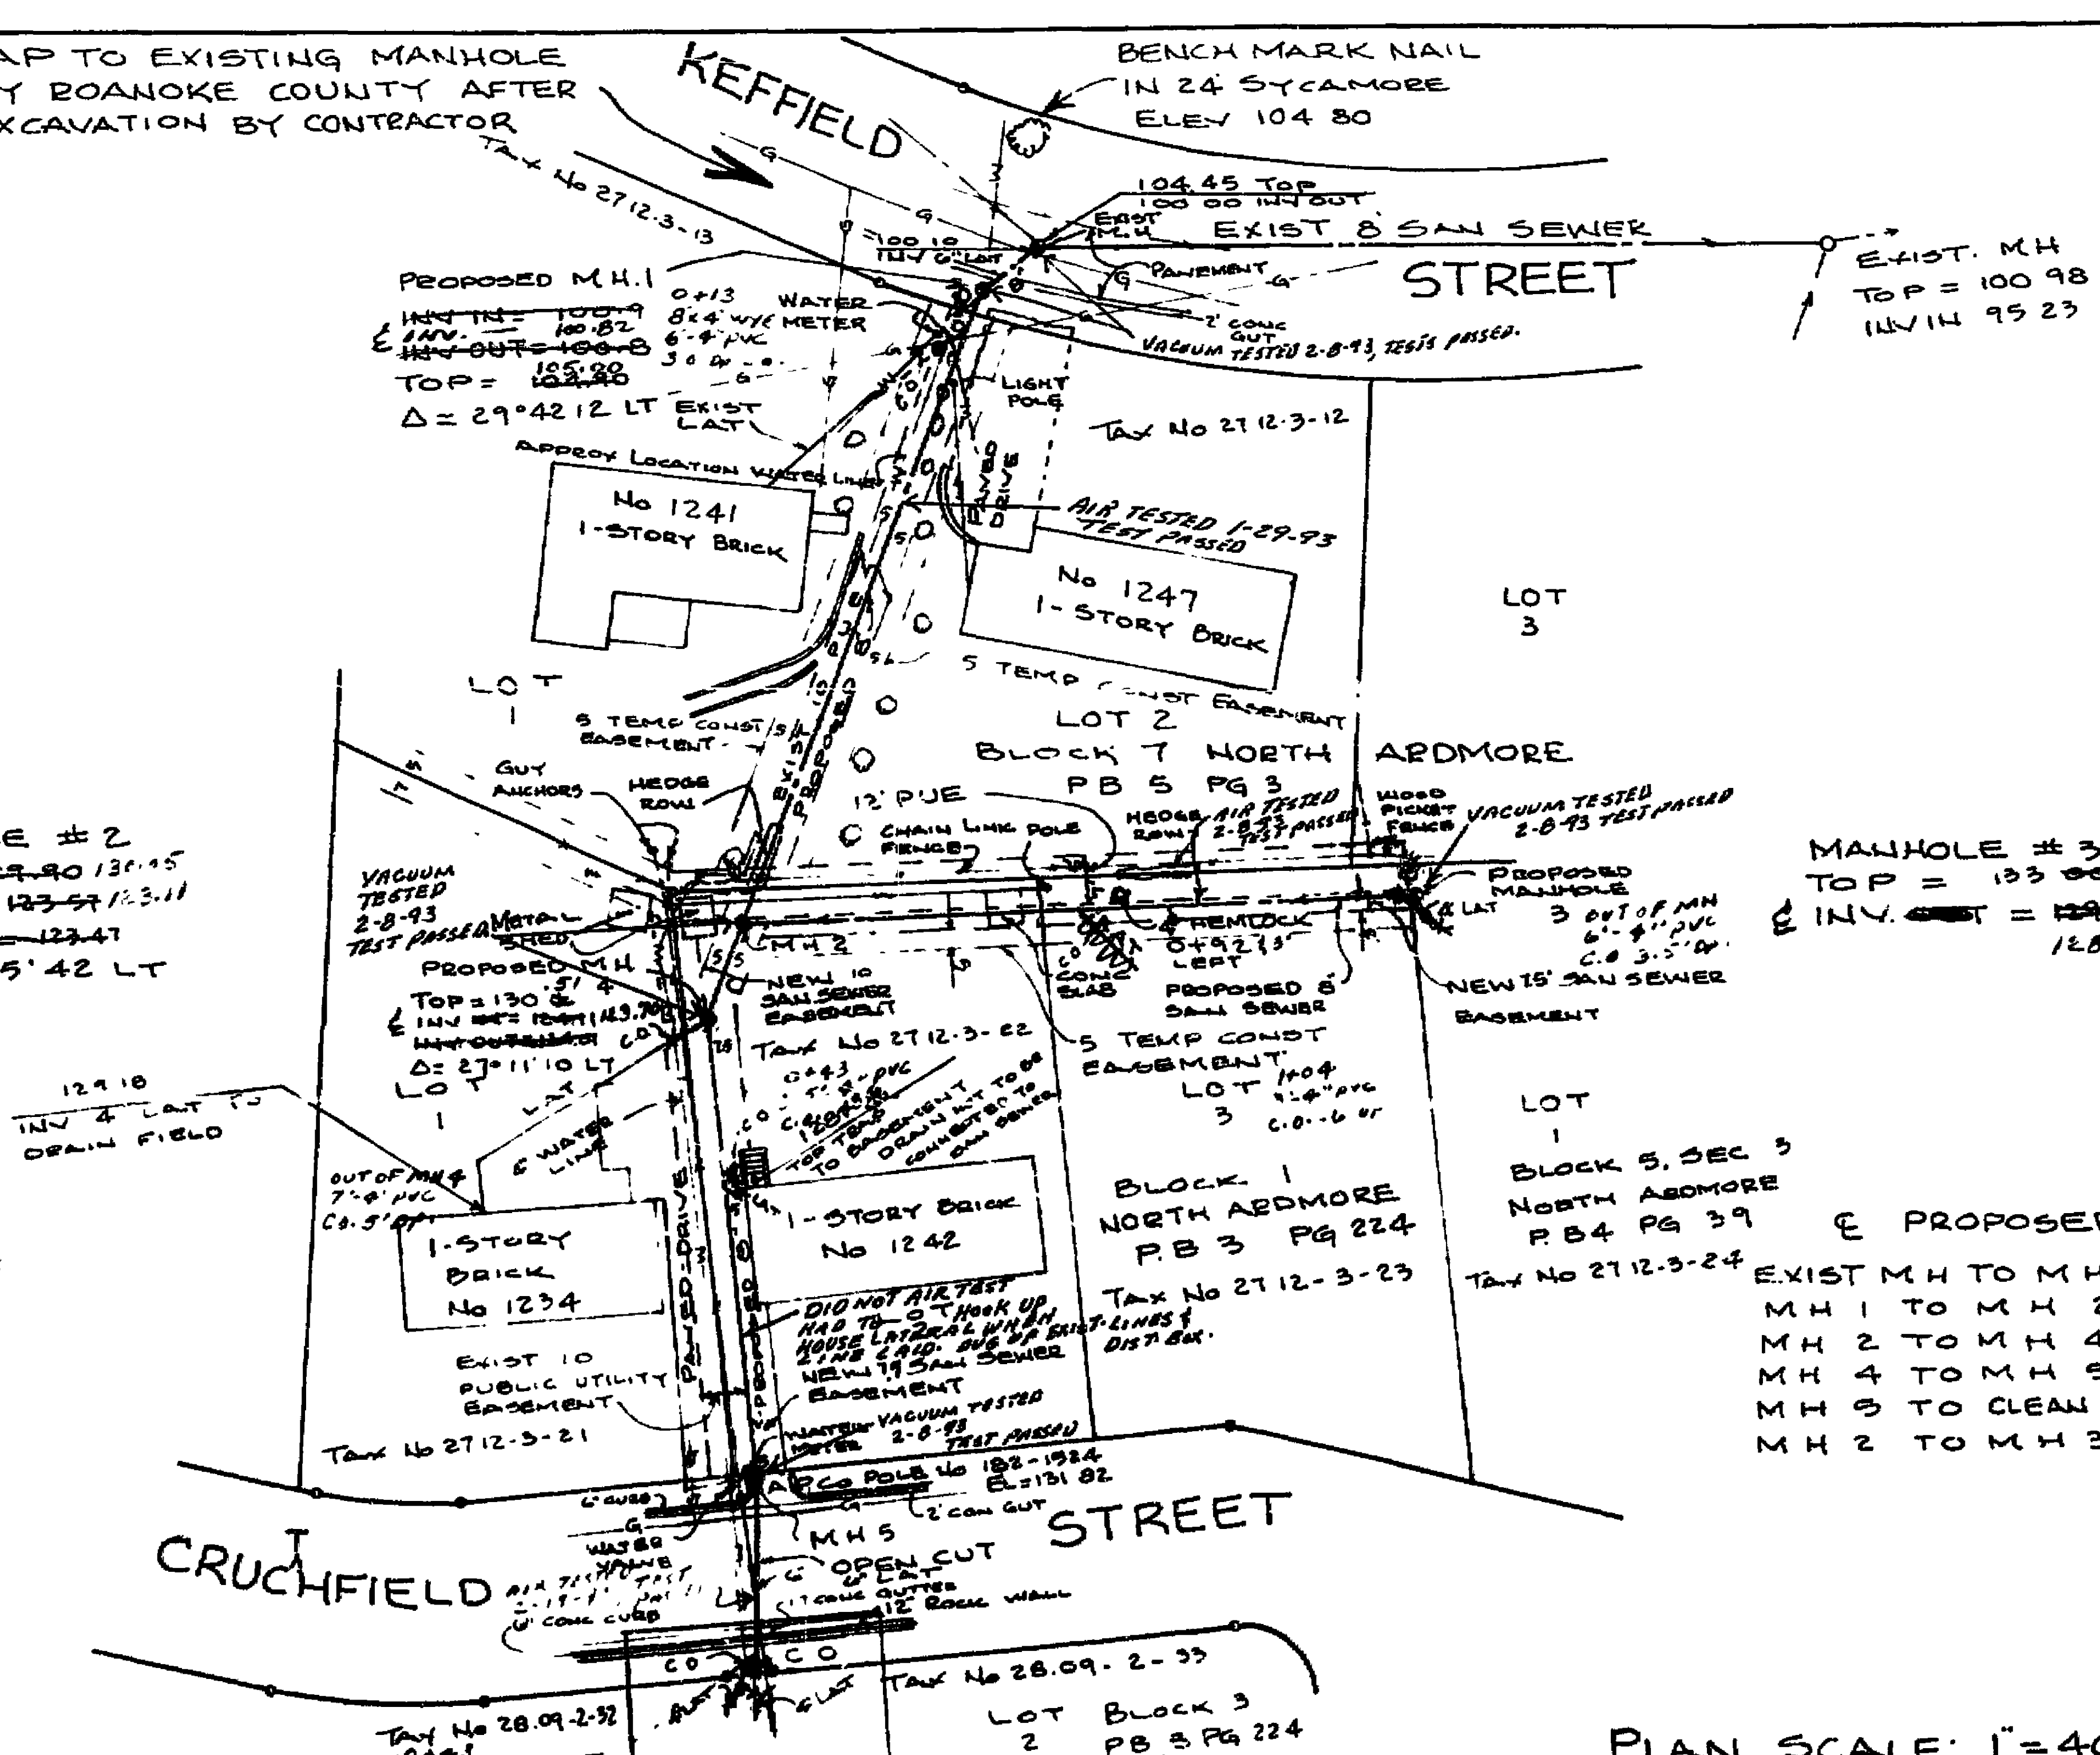

PLAN AND PROFILE MADE FOR
ROBERT J. MILLER
SHOWING PROPOSED SAN SEWER
HOLLIS MAG DISTRICT
ROANOKE COUNTY, VIRGINIA
BY: JACK G. BESS
CERTIFIED LAND SURVEYOR
DEC 30, 1992
SCALE: AS NOTED

