
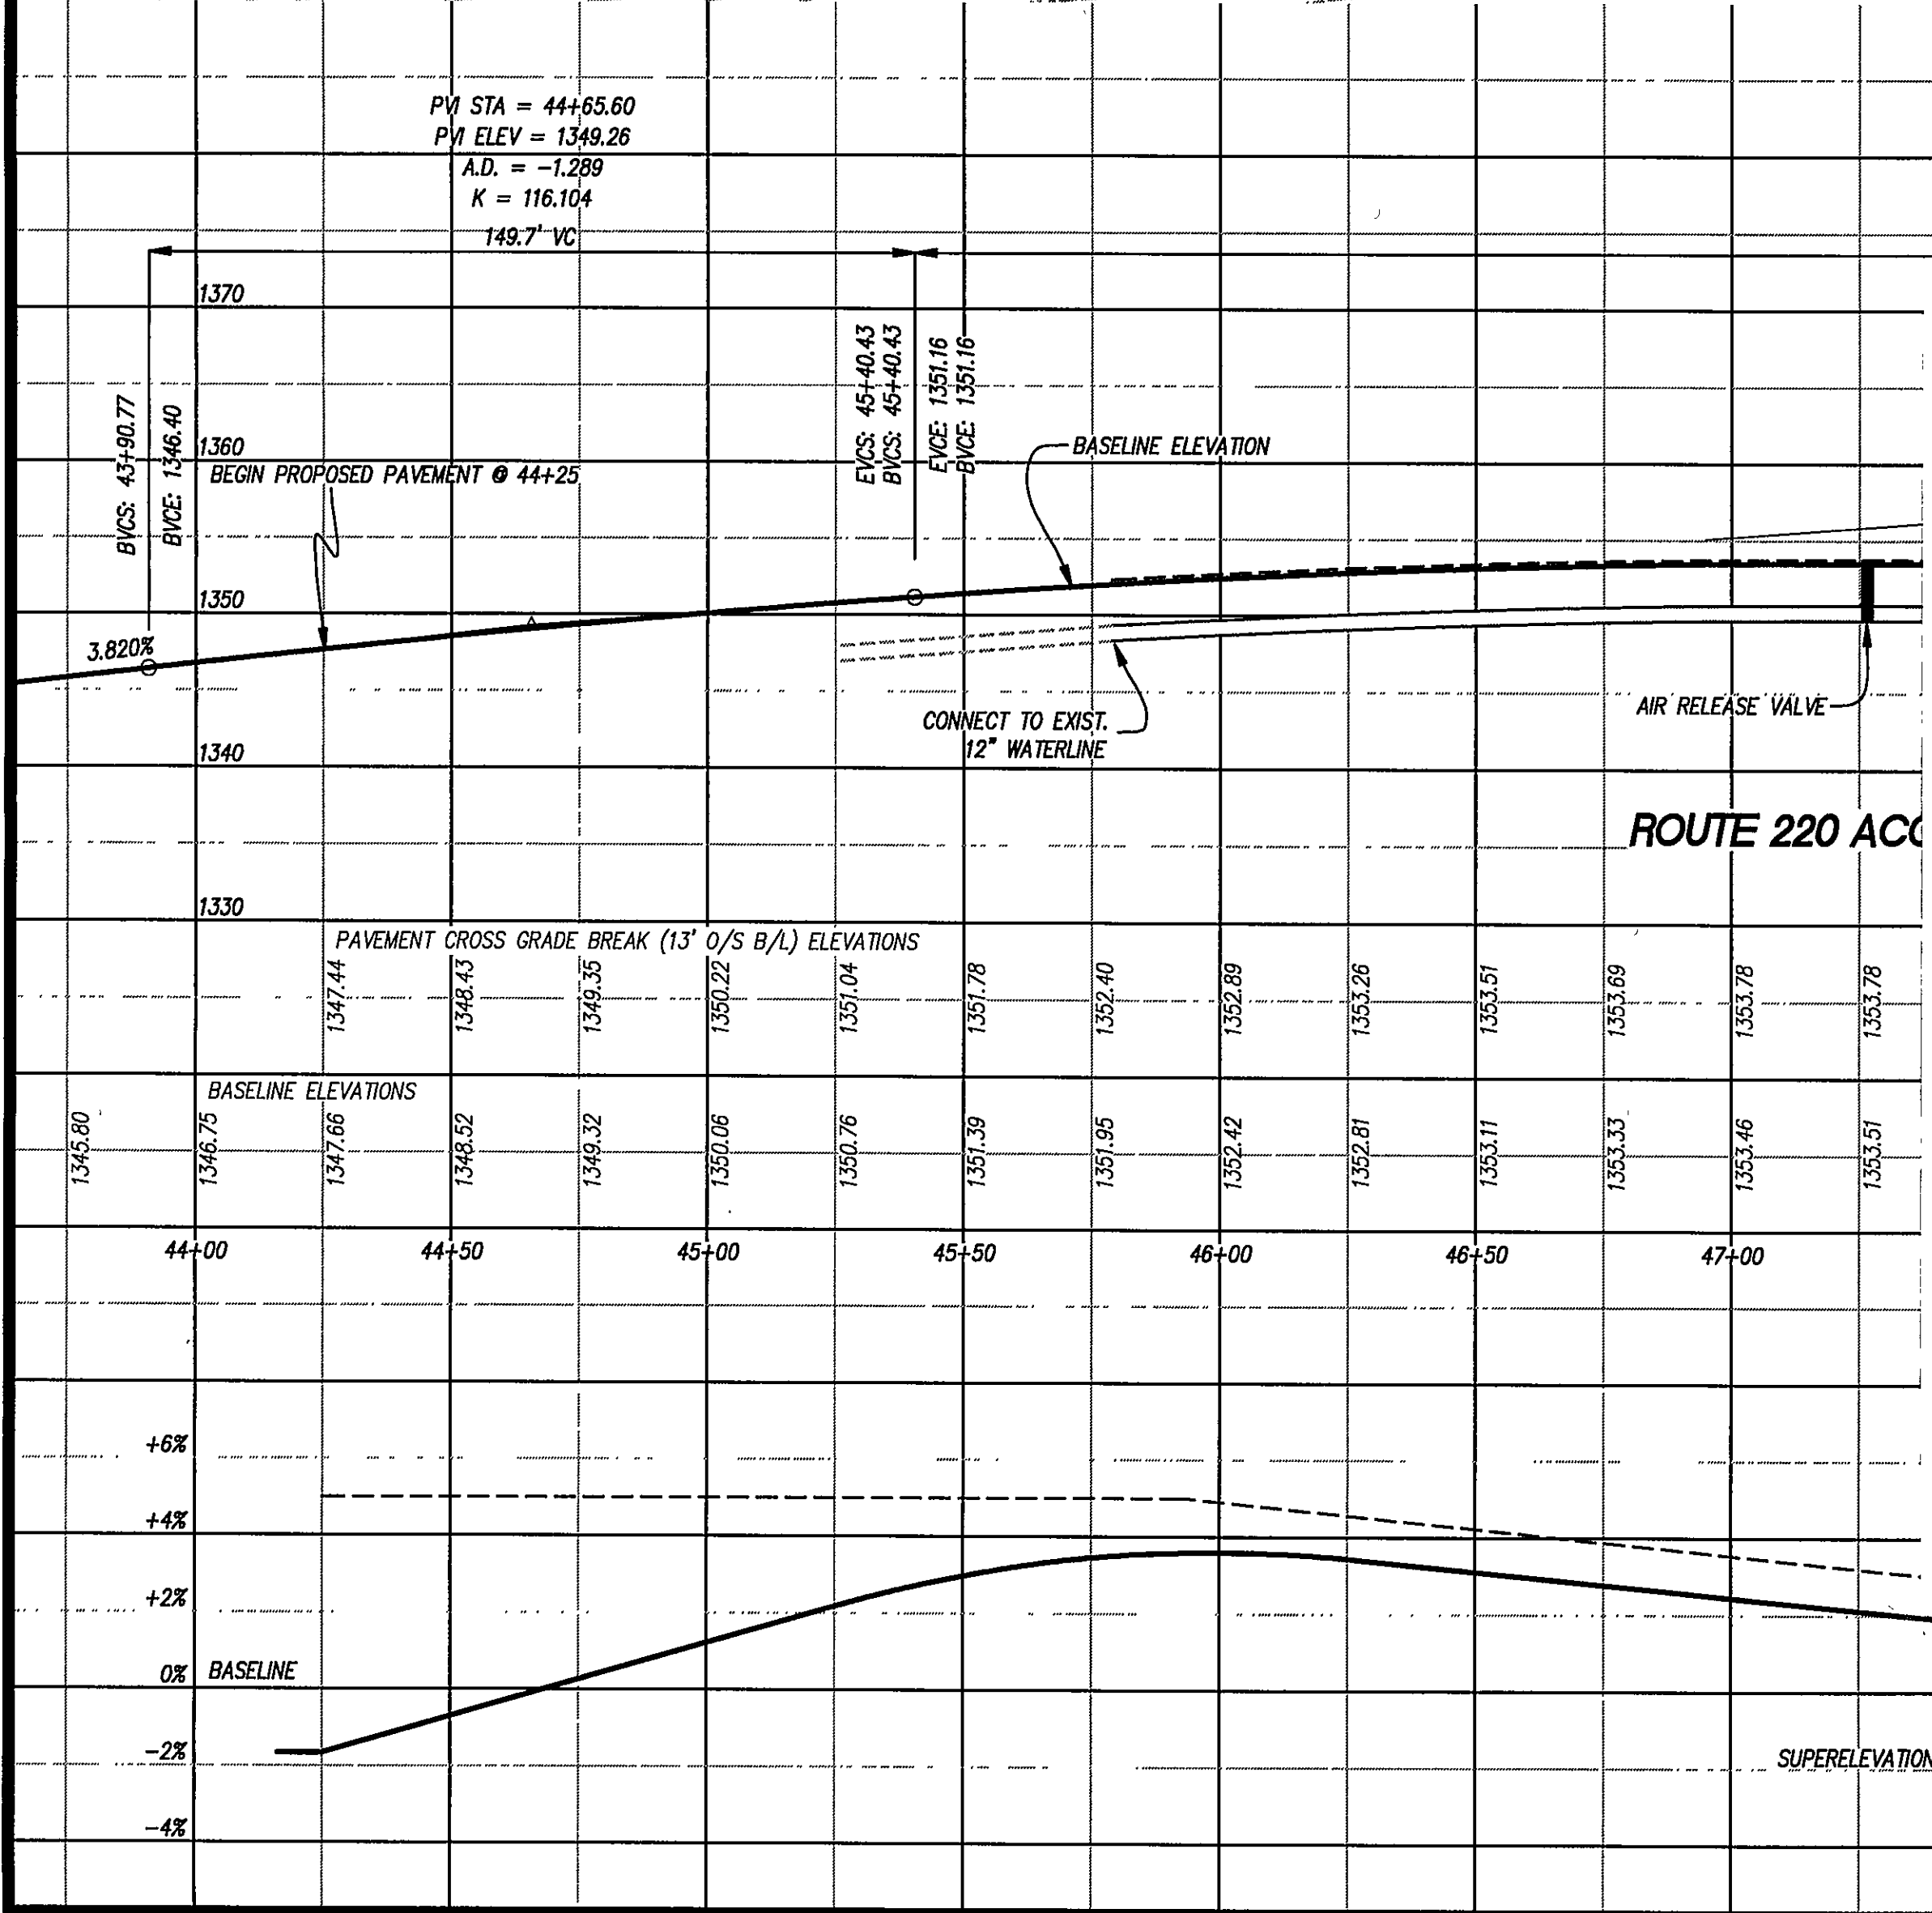
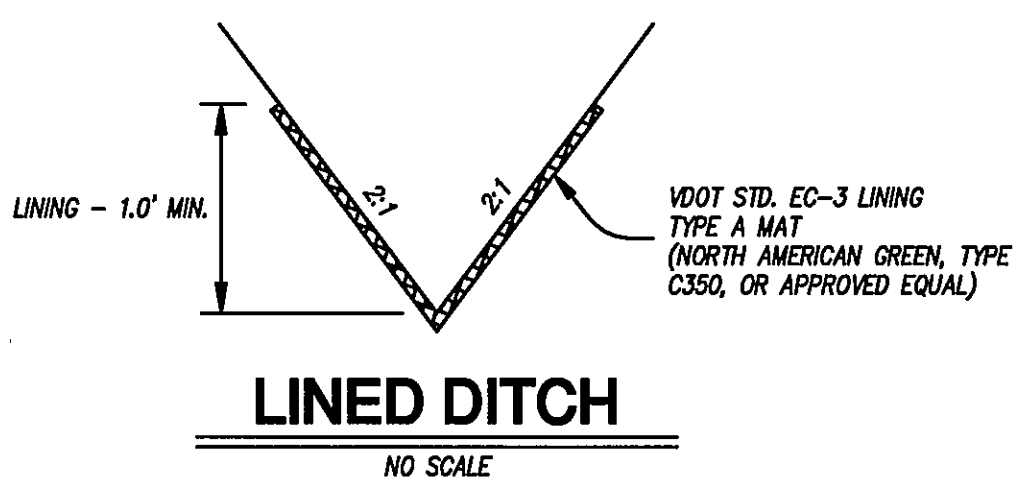




0603comp aecel-03.grd1.plt

w:\drawings\2006\0603\eng\acel\lane\0603comp aecel.dwg

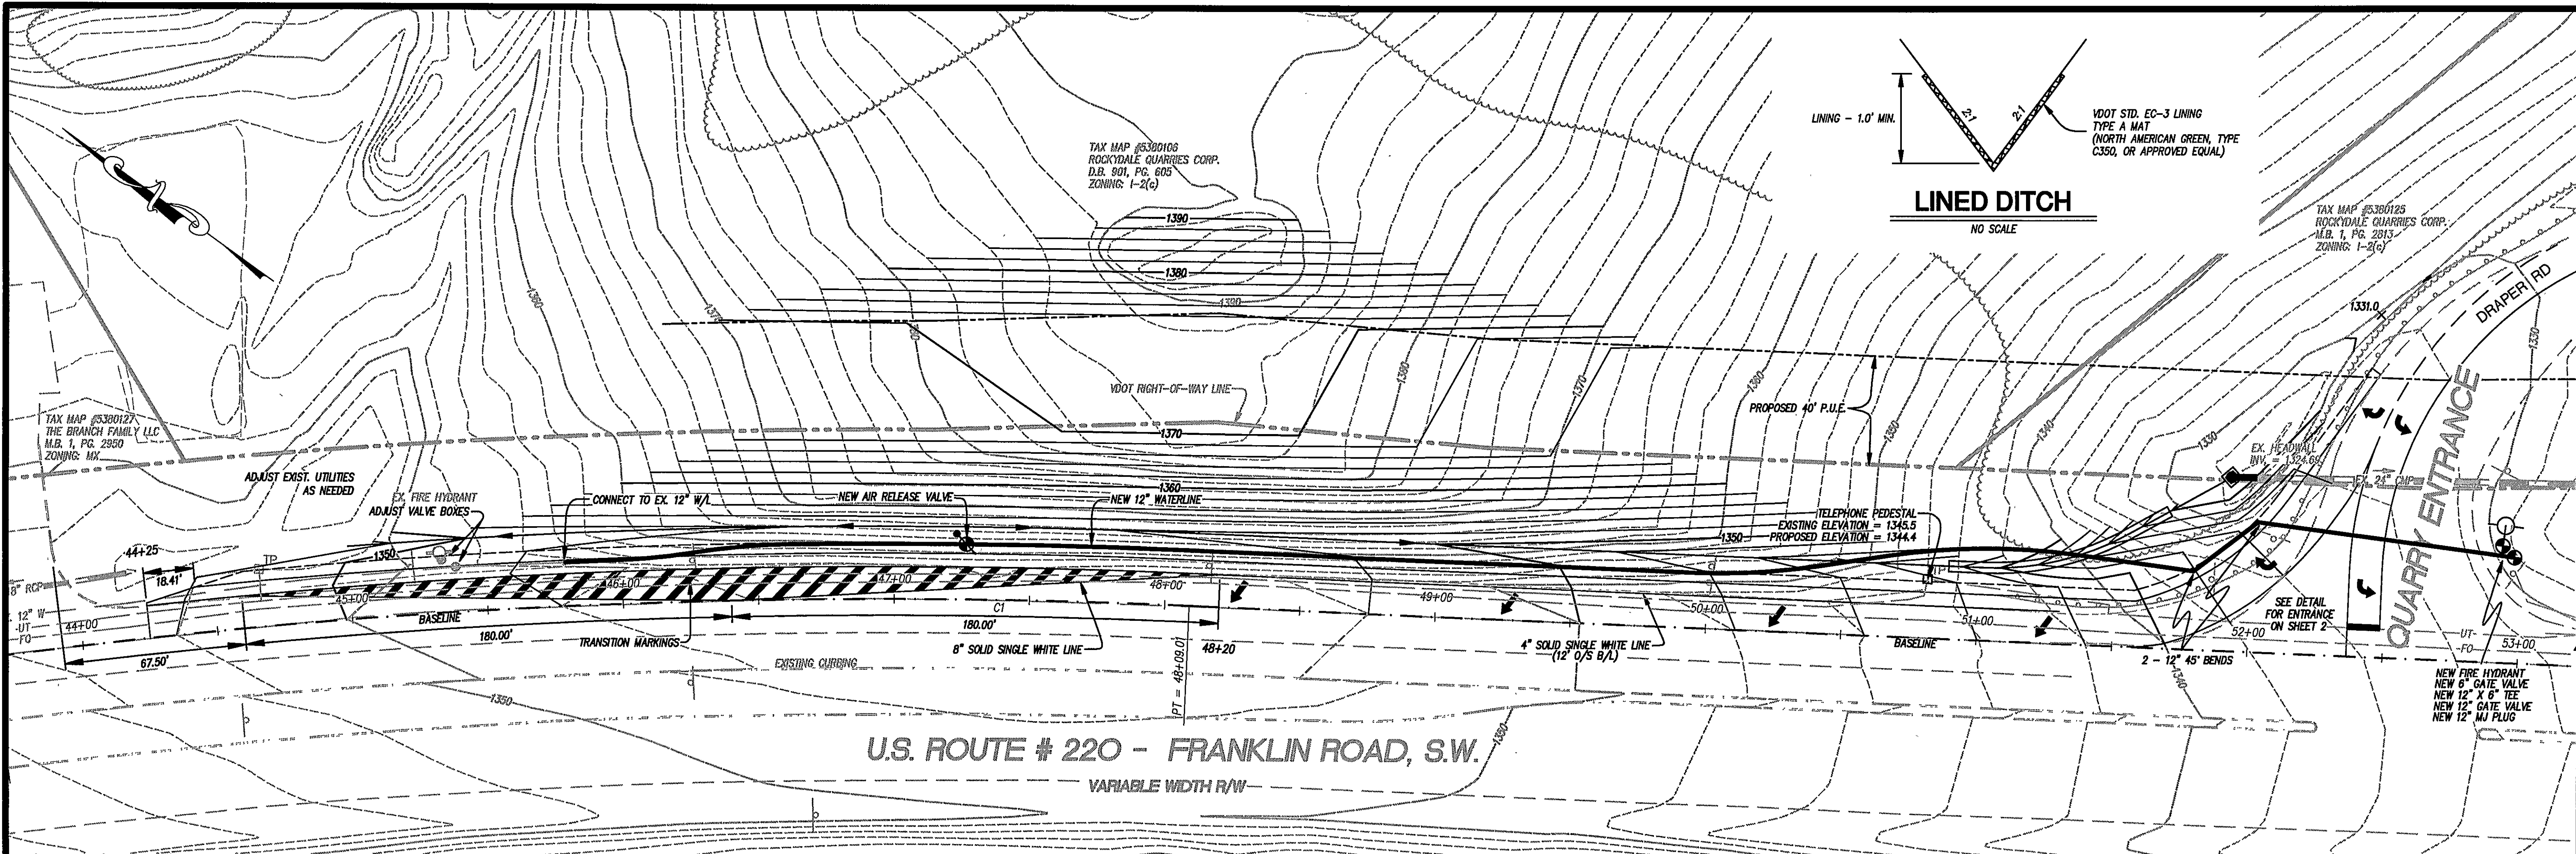

ROCKYDALE 12" WATER-LINE EXTENSION ASBUILTS

MATERIALS: ATLANTIC STATES 12" CLASS 350 P.I.
12"x6" CLOW RESILIENT SEAT VALVES
CLOW 5/4 HYDRANT 2009 - ID# 10264 95 PSI
697'-TOTAL 12"
FIELD LOCK GASKETS - LAST 8 JOINTS

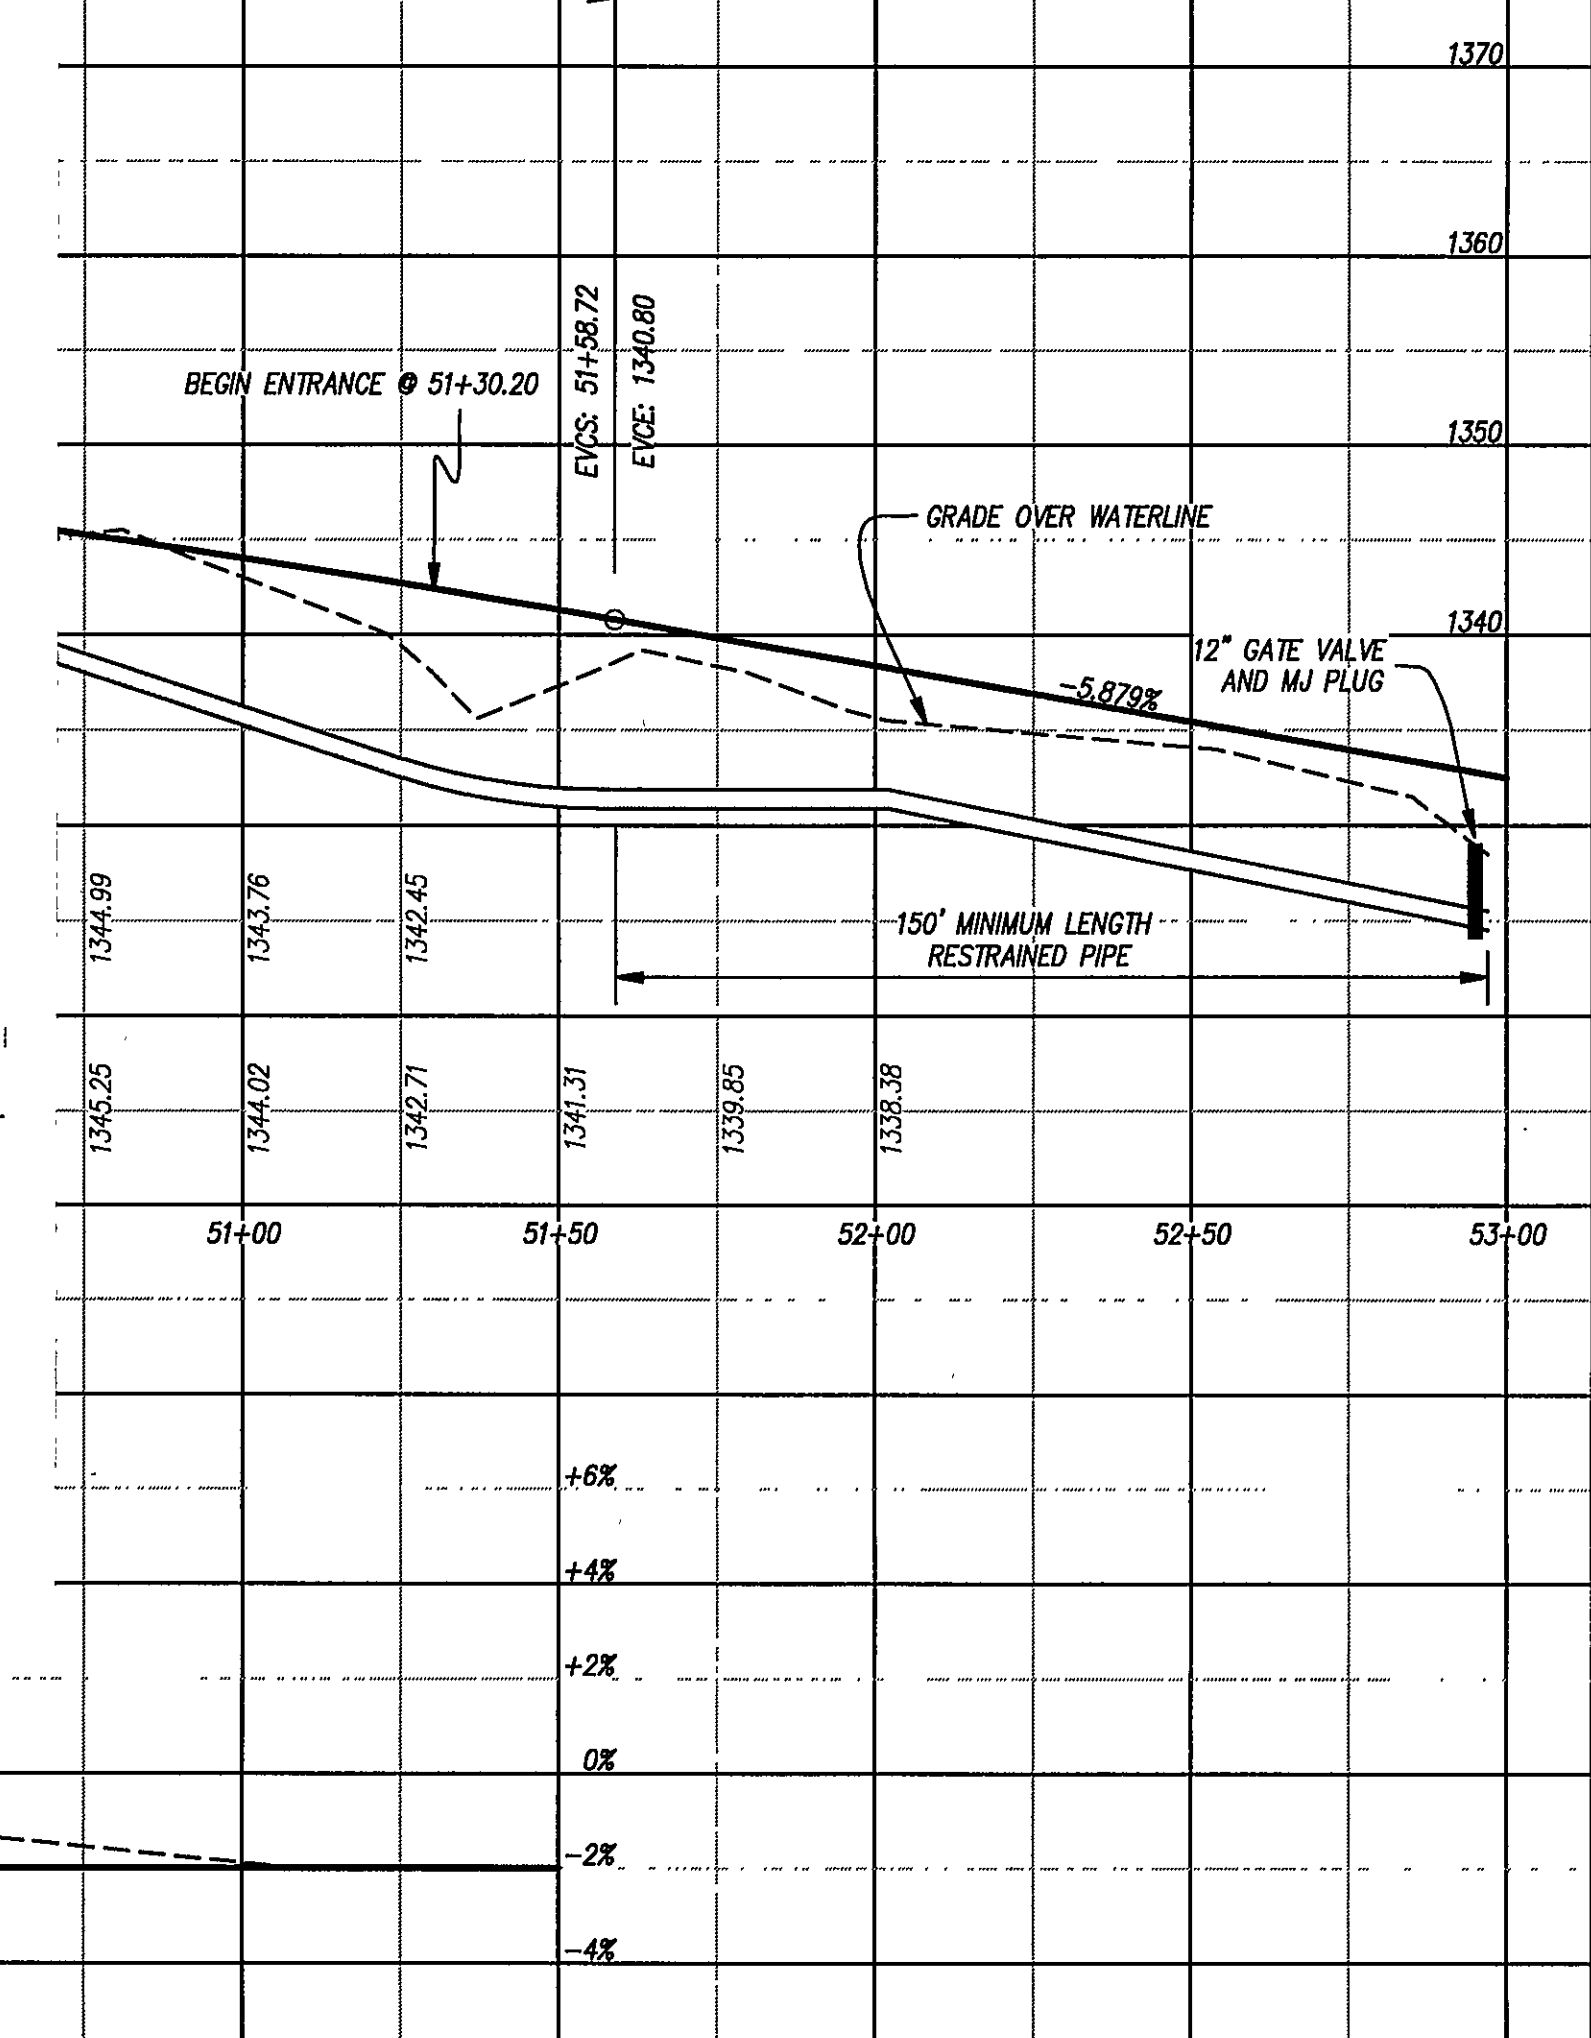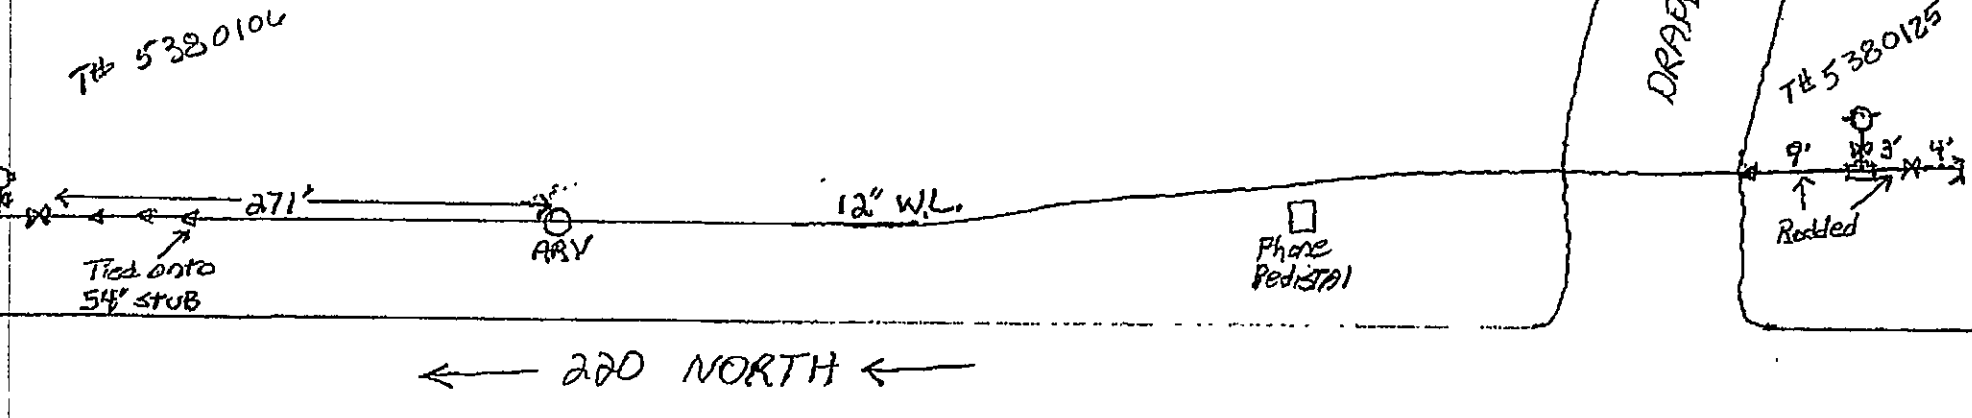

LUMSDEN ASSOCIATES, P.C.
ENGINEERS-SURVEYORS-PLANNERS
ROANOKE, VIRGINIA

4660 BRANFLETTON AVENUE
PO BOX 20869
ROANOKE, VIRGINIA 24018

PHONE: (540) 774-4411
FAX: (540) 772-9445
EMAIL: HAL@LUMSDENPC.COM

COMMONWEALTH OF VIRGINIA
DOUGLAS E. BURTON
Lic. No. 033740
PROFESSIONAL ENGINEER

PLAN AND PROFILE

**ACCELERATION LANE AT
ROCKYDALE QUARRIES**

PREPARED FOR
ROCKYDALE QUARRIES CORP.
SITUATED AT FRANKLIN ROAD & DRAPER ROAD, S.W.
THE CITY OF ROANOKE, VIRGINIA

REVISIONS	
NO.	DESCRIPTION
1	
2	
3	
4	
5	

DATE: **August 20, 2009**

SCALE: **(H) 1" = 30', (V) 1" = 10'**

COMMISSION NO.: **06-031**

SHEET 3 OF 6

Rockydale Water, Inc.