

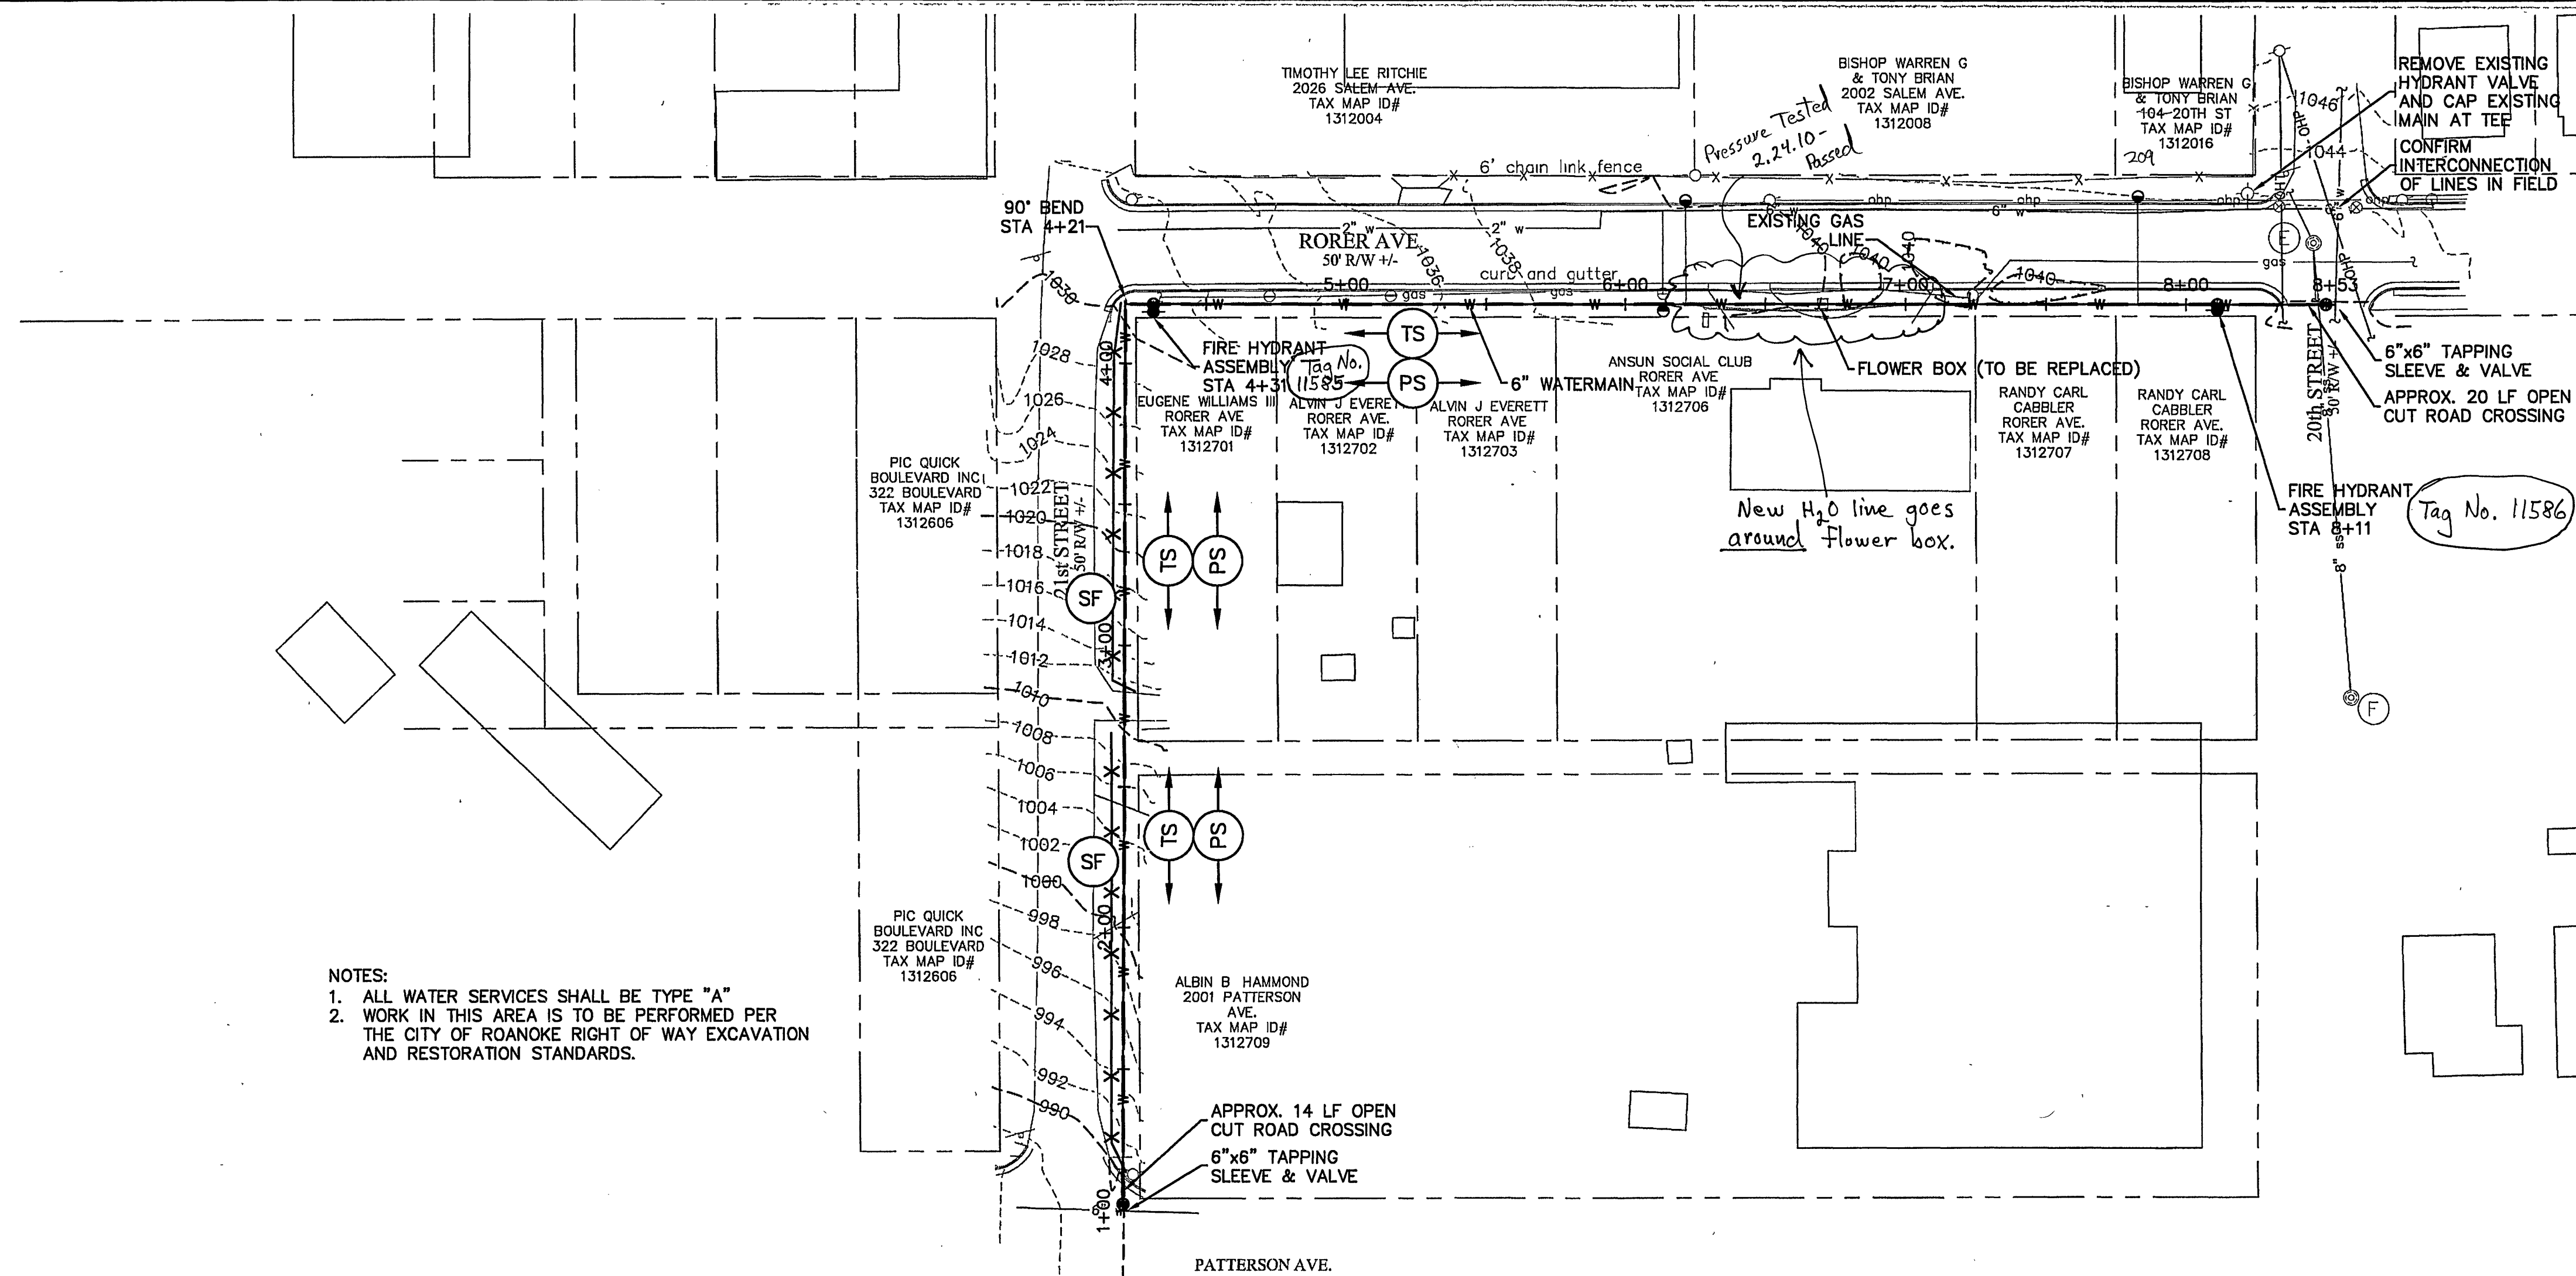
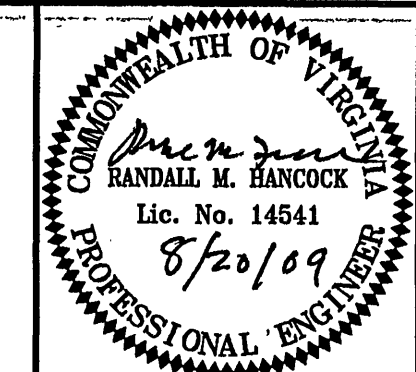


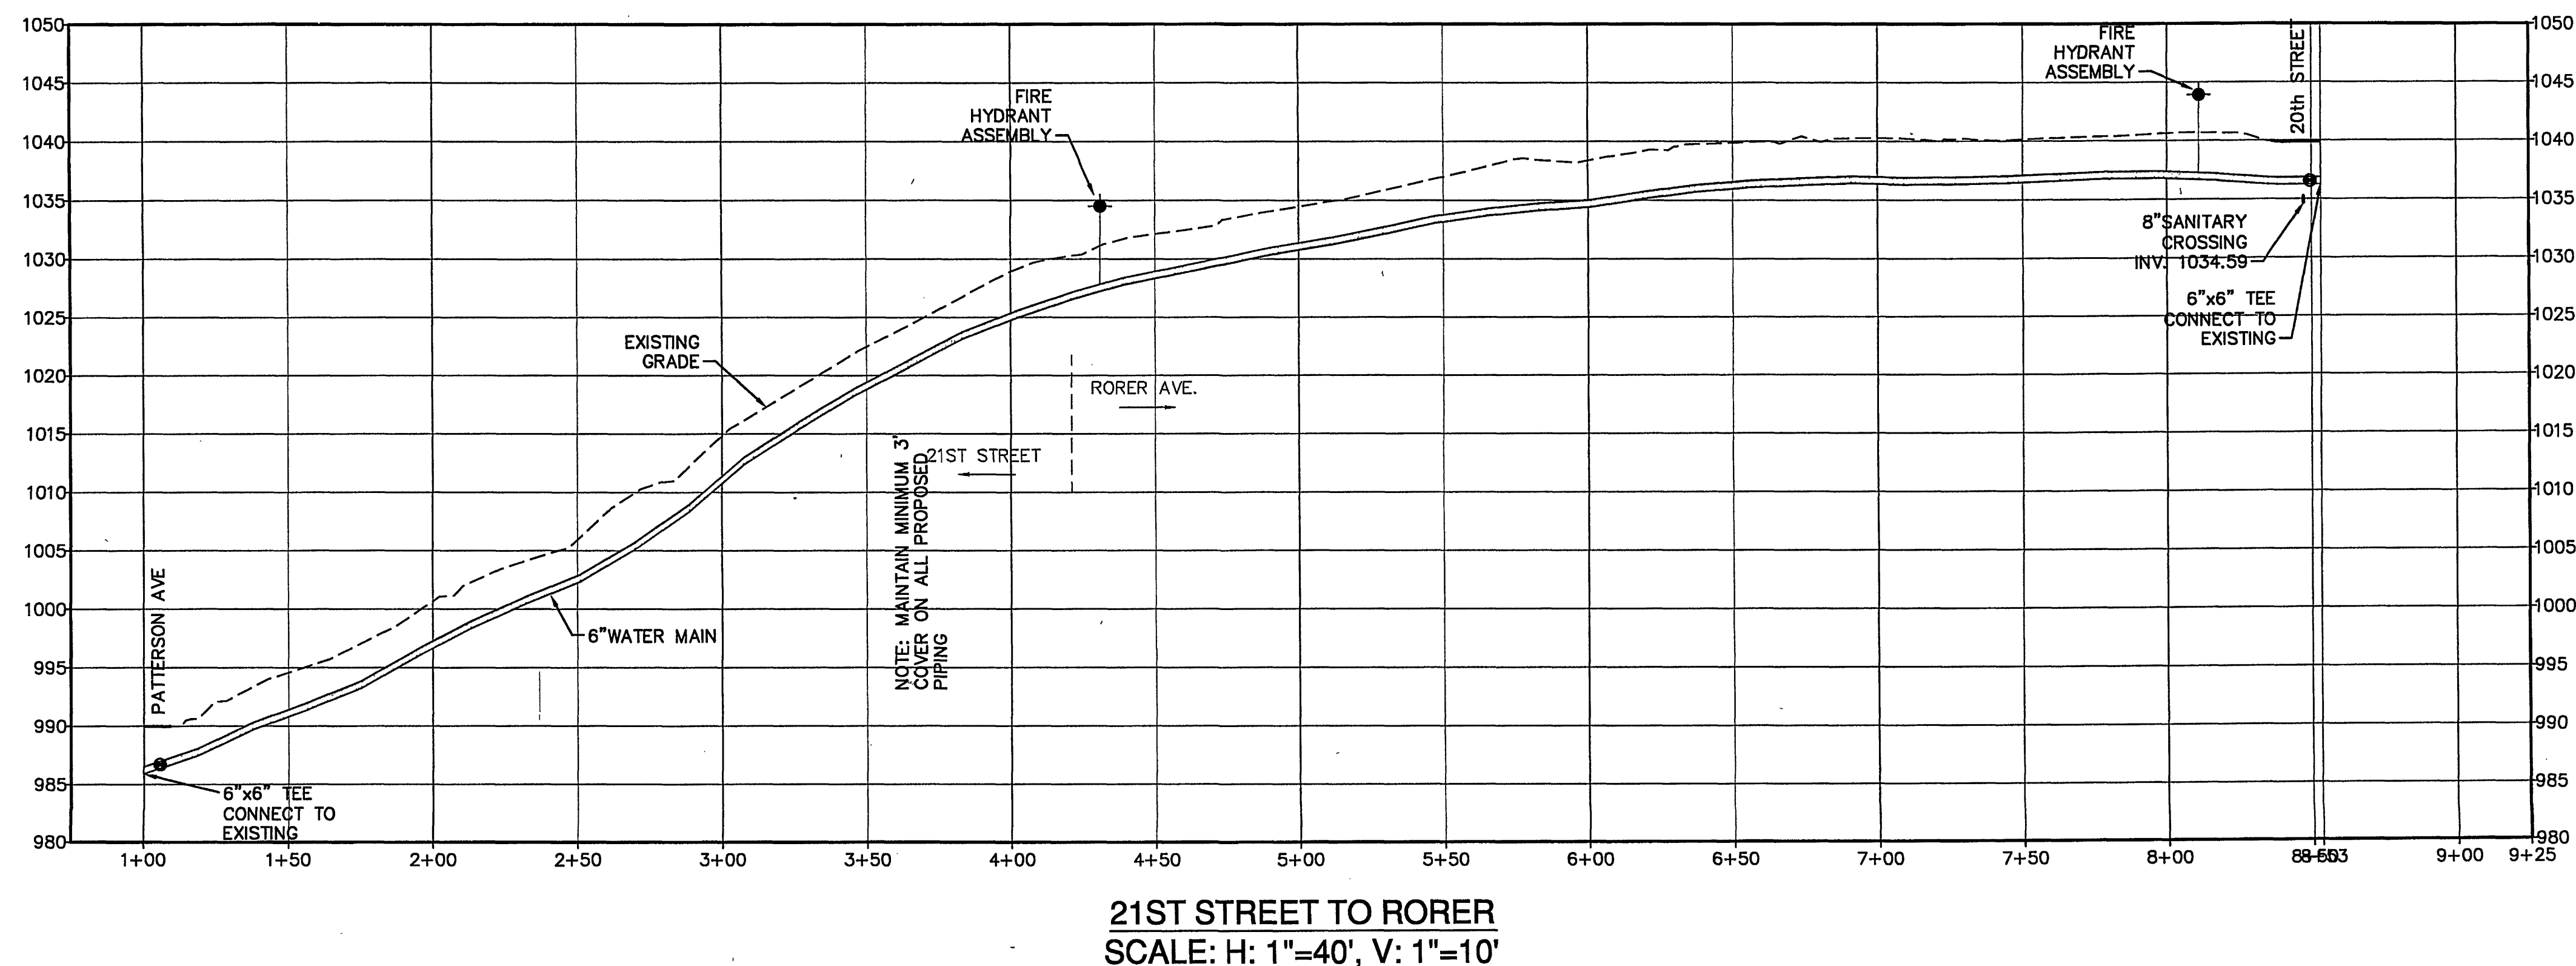

SANITARY STRUCTURES TABLE

- (E) sanitary manhole
top 1041.73
4" inv in 1037.63 N
8" inv out 1037.23 S
- (F) sanitary manhole
top 1020.20
8" inv in 1012.40 W
8" inv in 1015.15 N
6" inv in 1015.15 E
8" inv in 1012.40 SE
8" inv. out 1012.20 S

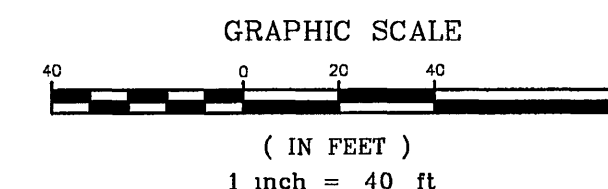

Draper Aden Associates
Engineering • Surveying • Environmental Services
Richmond, VA
Charlottesville, VA
Hampton Roads, VA
Blacksburg, VA
2200
Blacksburg, VA 24060
540-552-0444 Fax: 540-552-0291
www.daa.com

PLAN AND PROFILE
RORER AVENUE WATERLINE
REPLACEMENTS
CITY OF ROANOKE, VIRGINIA

REVISIONS
AUGUST 20, 2009
PER CITY OF ROANOKE

APPROVED
OCT 15 2009

DESIGNED BY: RMH
DRAWN BY: GAB
CHECKED BY: TOM
SCALE: NO SCALE
DATE: July 29, 2009
PROJECT NUMBER: B09134B-03

U-1