



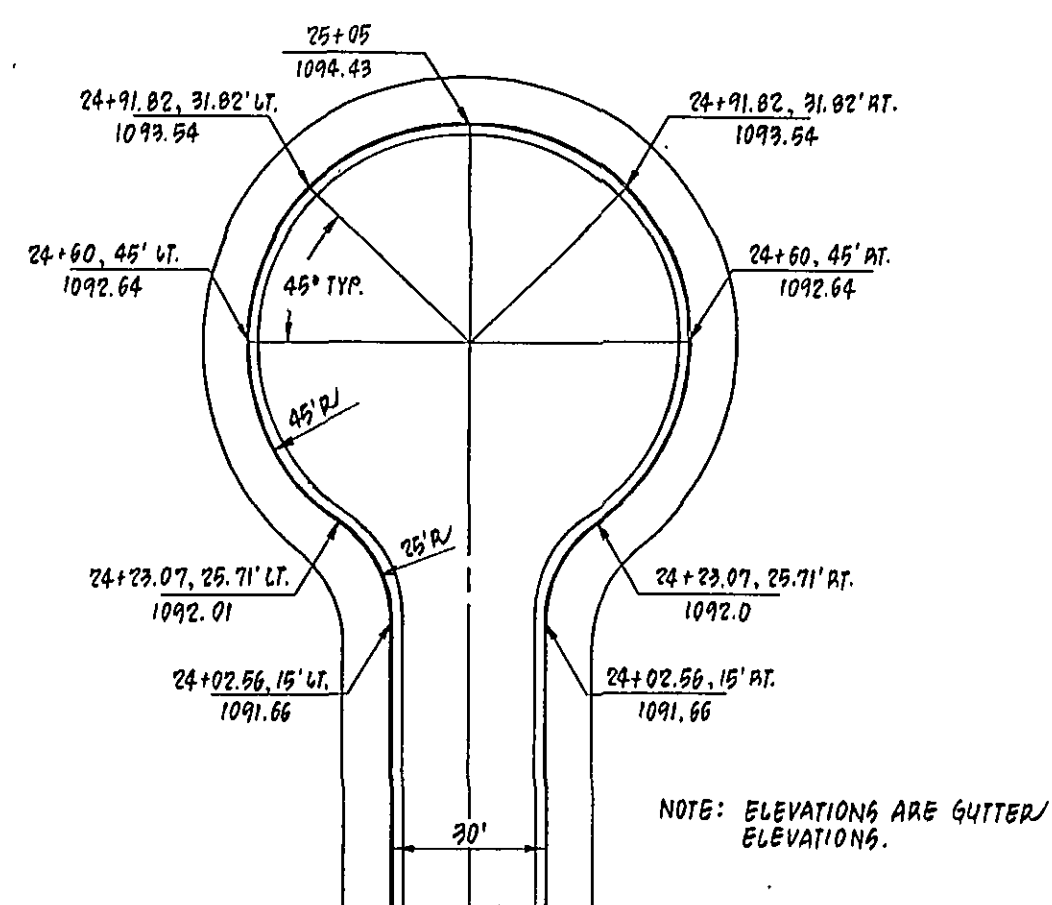

ROSEWALK LANE
NO SCALE

REVISION	DATE	DESCRIPTION
DESIGNED	HLA, WAS	GRADING & STORM DRAINAGE PLAN FOR "ROSEWALK"
DRAWN	PVR, VWB	PREPARED FOR DOMINION DEVELOPERS, INC. ROANOKE, VIRGINIA
CHECKED	MFW	
LUMSDEN ASSOCIATES, P.C. ENGINEERS-SURVEYORS-PLANNERS ROANOKE, VIRGINIA		SCALE: 1"=50' DATE: 4 APRIL 1994 COMM: 93-577 SHEET 5 of 9

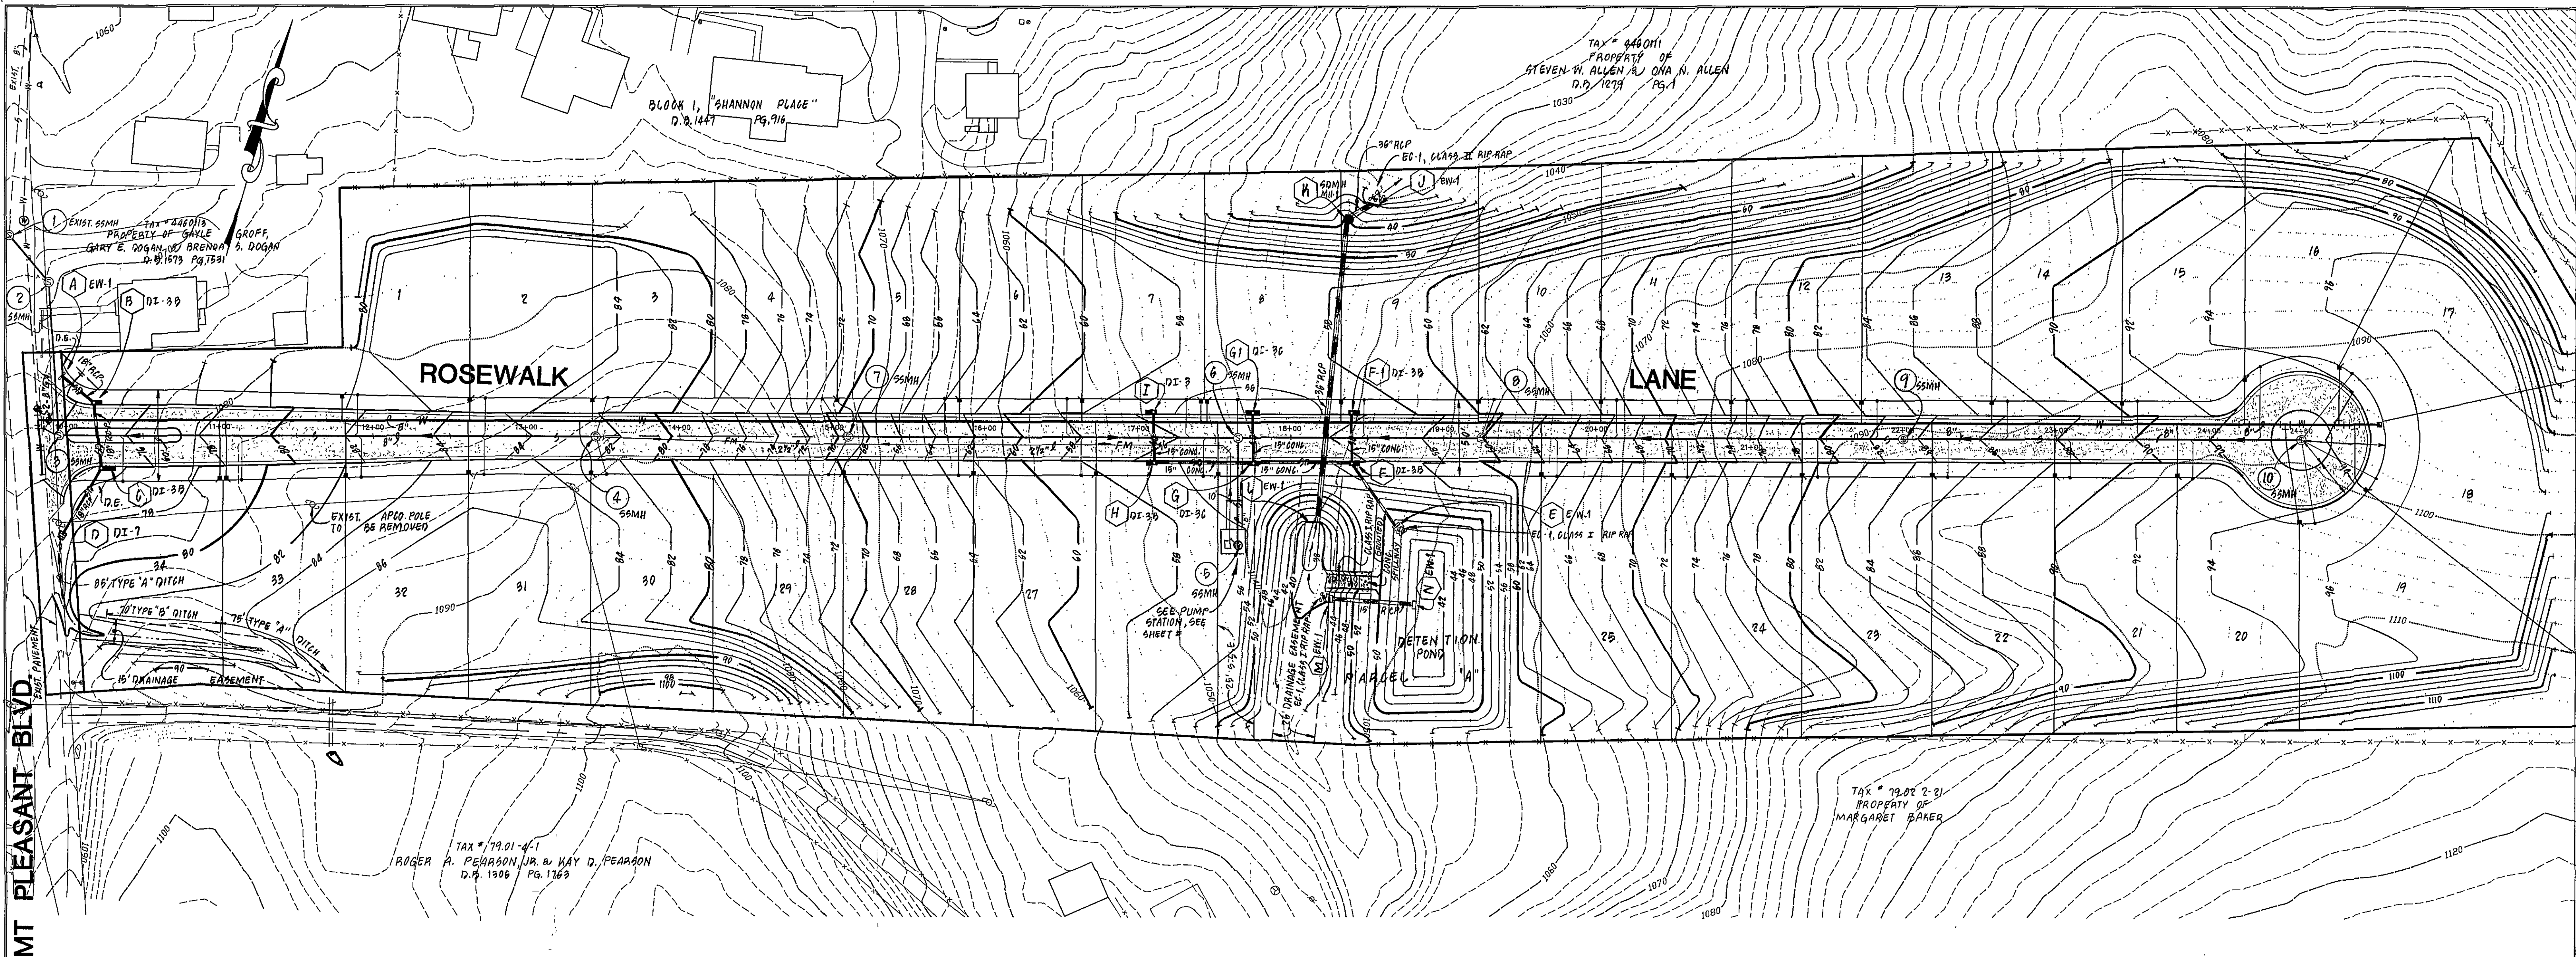