


DESIGN OF A TRAFFIC ROUNDABOUT  
FOR MERRIMAN ROAD  
FOR  
NEW SOUTH COUNTY LIBRARY  
SITUATED IN

CAVE SPRING MAGISTERIAL DISTRICT  
ROANOKE COUNTY, VIRGINIA

DATE: JANUARY, 2010

PREPARED FOR  
ROANOKE COUNTY

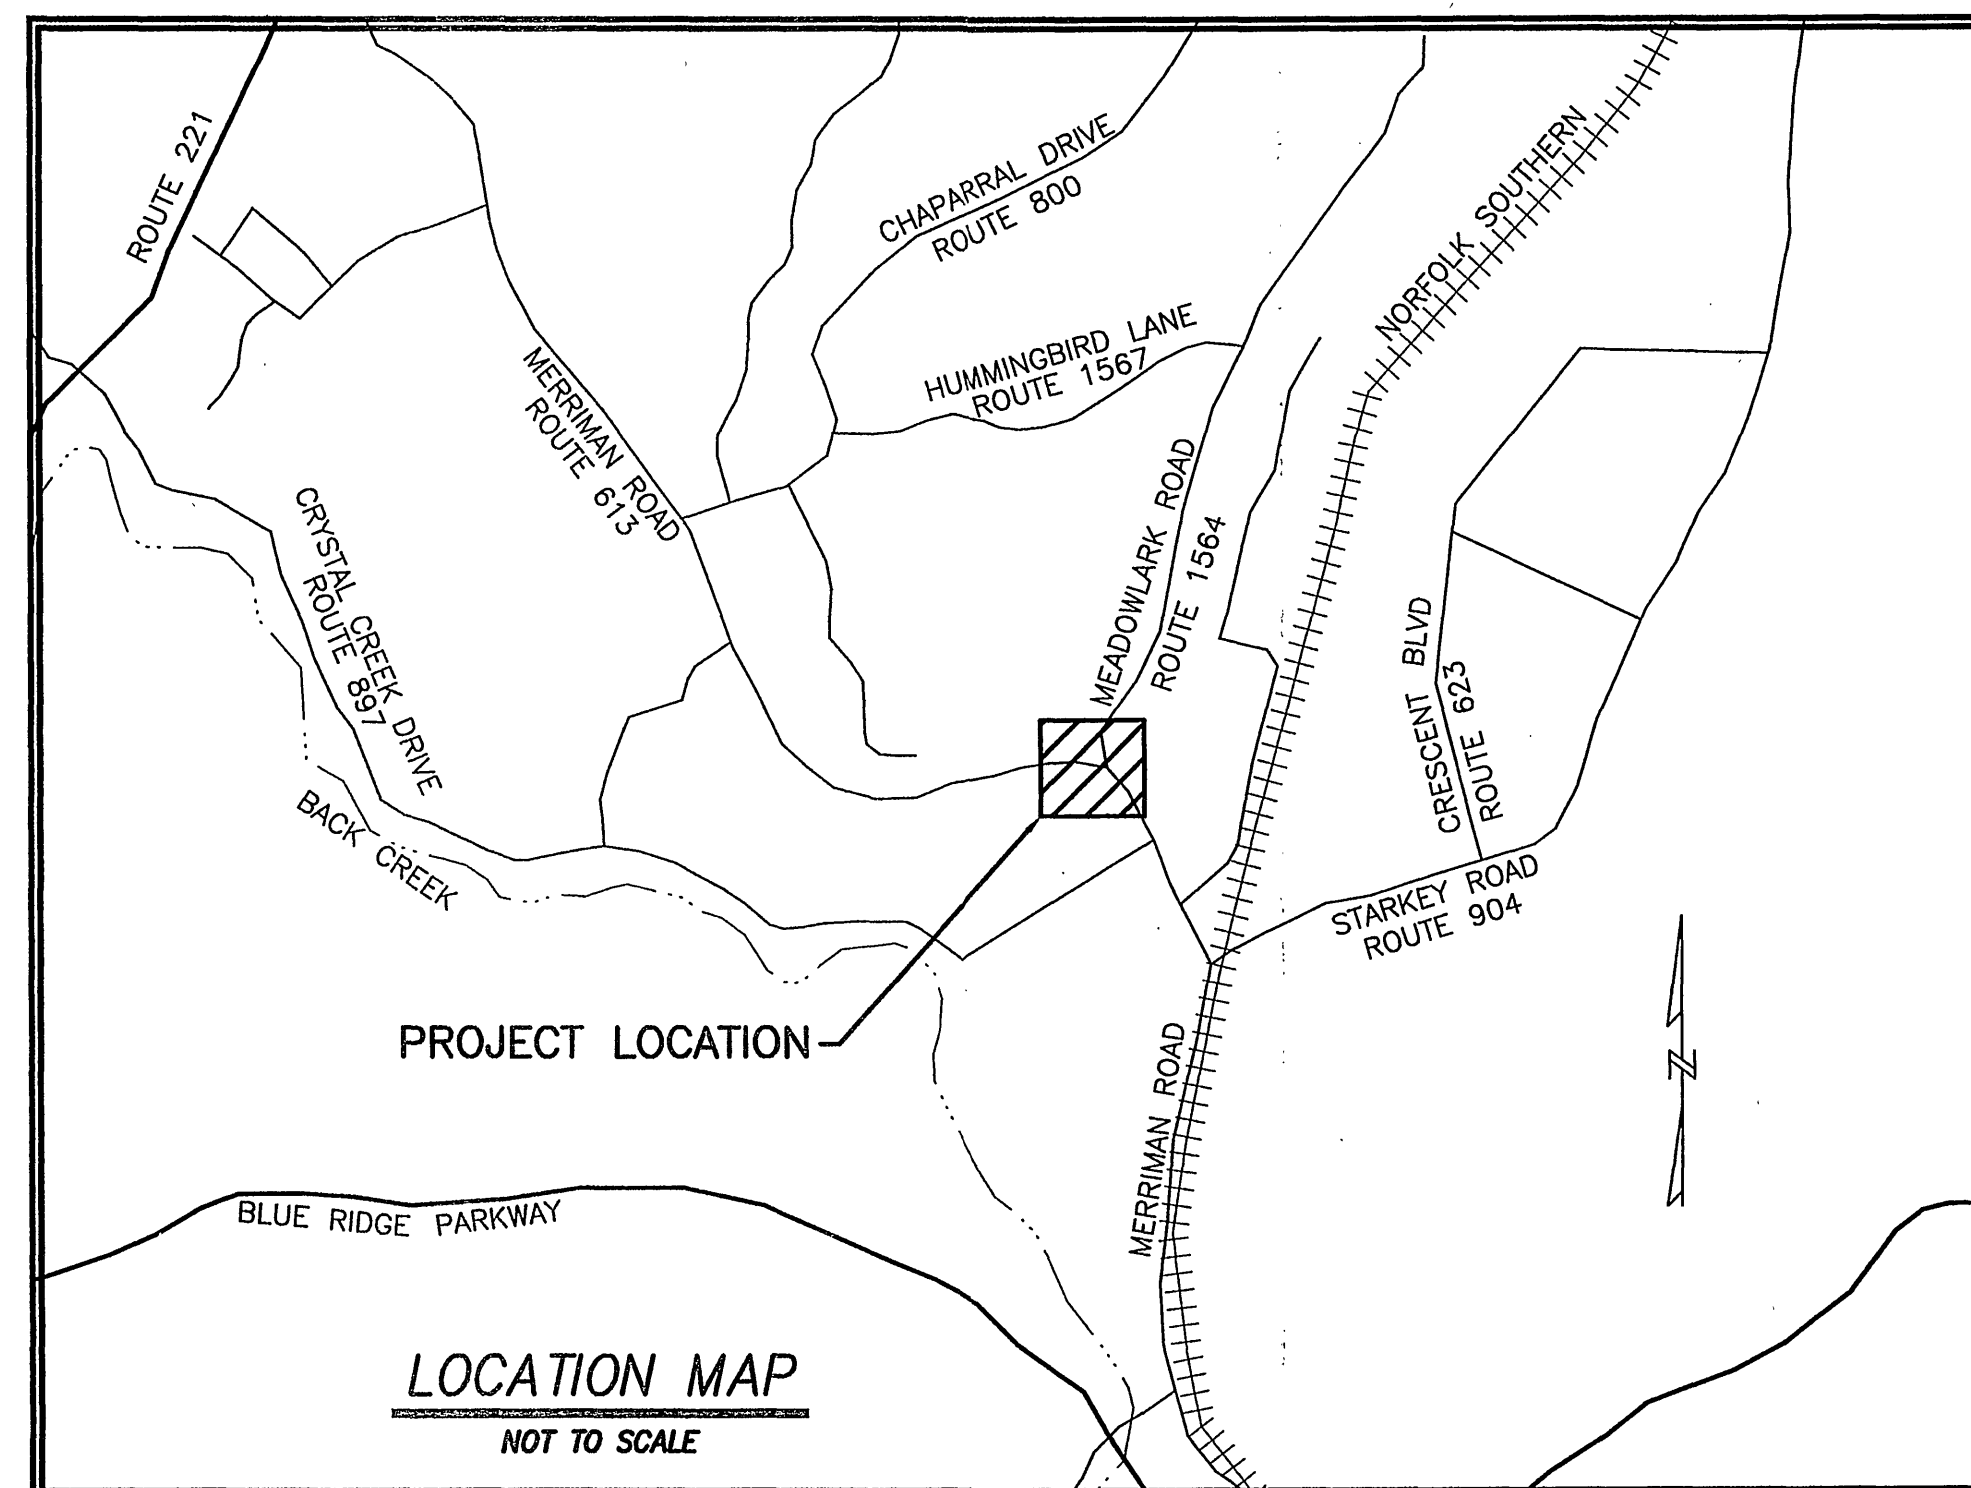

I AM CERTIFIED BY THE STATE OF VIRGINIA AS A "RESPONSIBLE LAND DISTURBER". I SHALL BE RESPONSIBLE FOR THE IMPLEMENTATION OF THE EROSION AND SEDIMENT CONTROL PLAN AS SHOWN.

SIGNATURE: \_\_\_\_\_  
PRINTED NAME: \_\_\_\_\_  
CERTIFICATE No.: \_\_\_\_\_  
EXPIRATION DATE: \_\_\_\_\_  
TELEPHONE No.: \_\_\_\_\_  
ADDRESS: \_\_\_\_\_

**AECOM**

1315 FRANKLIN ROAD  
ROANOKE, VA 24016

(540) 857-3100

www.aecom.com

PROJECT NO. 0613-080-773  
UPC#94796

--INDEX OF DRAWINGS--  
AECOM

SHEET No.	DESCRIPTION
CT001	TITLE SHEET
CT002	ROANOKE COUNTY COVER SHEET
CT003	GENERAL NOTES AND TYPICAL SECTIONS
CT004	DRAINAGE DESCRIPTIONS & SURVEY CONTROL POINTS
CT005	CONSTRUCTION PHASING PLAN
CT006	CONSTRUCTION PHASING PLAN
CT007	DETOUR AND SIGNAGE PLAN
CT008	ROADSIDE DEVELOPMENT SHEET
CT009	HORIZONTAL ALIGNMENT DATA SHEET
CT101	DEMOLITION PLAN
CT102	ROADWAY PLAN
CT102A	ROADWAY AND DRAINAGE PROFILES
CT102B	ROADWAY AND DRAINAGE PROFILES
CT103	ROADWAY PLAN
CT104	ROADWAY PLAN
CT104A	ROADWAY AND DRAINAGE PROFILES
CT105	EROSION AND SEDIMENT CONTROL PLAN
CT106	EROSION AND SEDIMENT CONTROL PLAN
CT107	EROSION AND SEDIMENT CONTROL PLAN
CT108	SIGNAGE AND PAVEMENT MARKING PLAN
CT109	STORMWATER MANAGEMENT PLAN AND DETAILS
CT110	LIGHTING PLAN
CT111	ROUNDABOUT GRADING PLAN
CT301-CT320	ROADWAY CROSS SECTIONS
CT501	EROSION AND SEDIMENT CONTROL DETAILS
CT502	SIGHT DISTANCE TRIANGLES
CT503	SPLITTER MEDIAN DETAILS
CT504	LIGHTING POLE DETAILS
CU101	UTILITY PLAN LINES 100W, 101W & 200W
CU201	UTILITY PROFILES LINES 100W, 101W & 200W
CU501	STANDARD DETAILS - WATER

ROANOKE COUNTY  
LANDSCAPING PLAN

LA1

- THIS PROJECT IS TO BE CONSTRUCTED IN ACCORDANCE WITH THE VIRGINIA DEPARTMENT OF TRANSPORTATION'S 2007 ROAD AND BRIDGE SPECIFICATIONS, 2008 ROAD AND BRIDGE STANDARDS, 2005 WORK AREA PROTECTION MANUAL AND AS AMENDED BY CONTRACT PROVISIONS.
- ALL CURVES ARE TO BE SUPERELEVATED, TRANSITIONED AND WIDENED IN ACCORDANCE WITH STANDARD TC-5.04ULS EXCEPT WHERE OTHERWISE NOTED.

SEALS	
14	
PROJECT NO: 30233	
SHEET 1 OF 51	

APPROVED  
As-Built  
01/16/2011

Merriman Road Roundabout (South Rte. Library)  
- Approved Plan -