


# NOTES THIS SHEET

- EXISTING PIPES TO REMAIN UNLESS OTHERWISE NOTED.

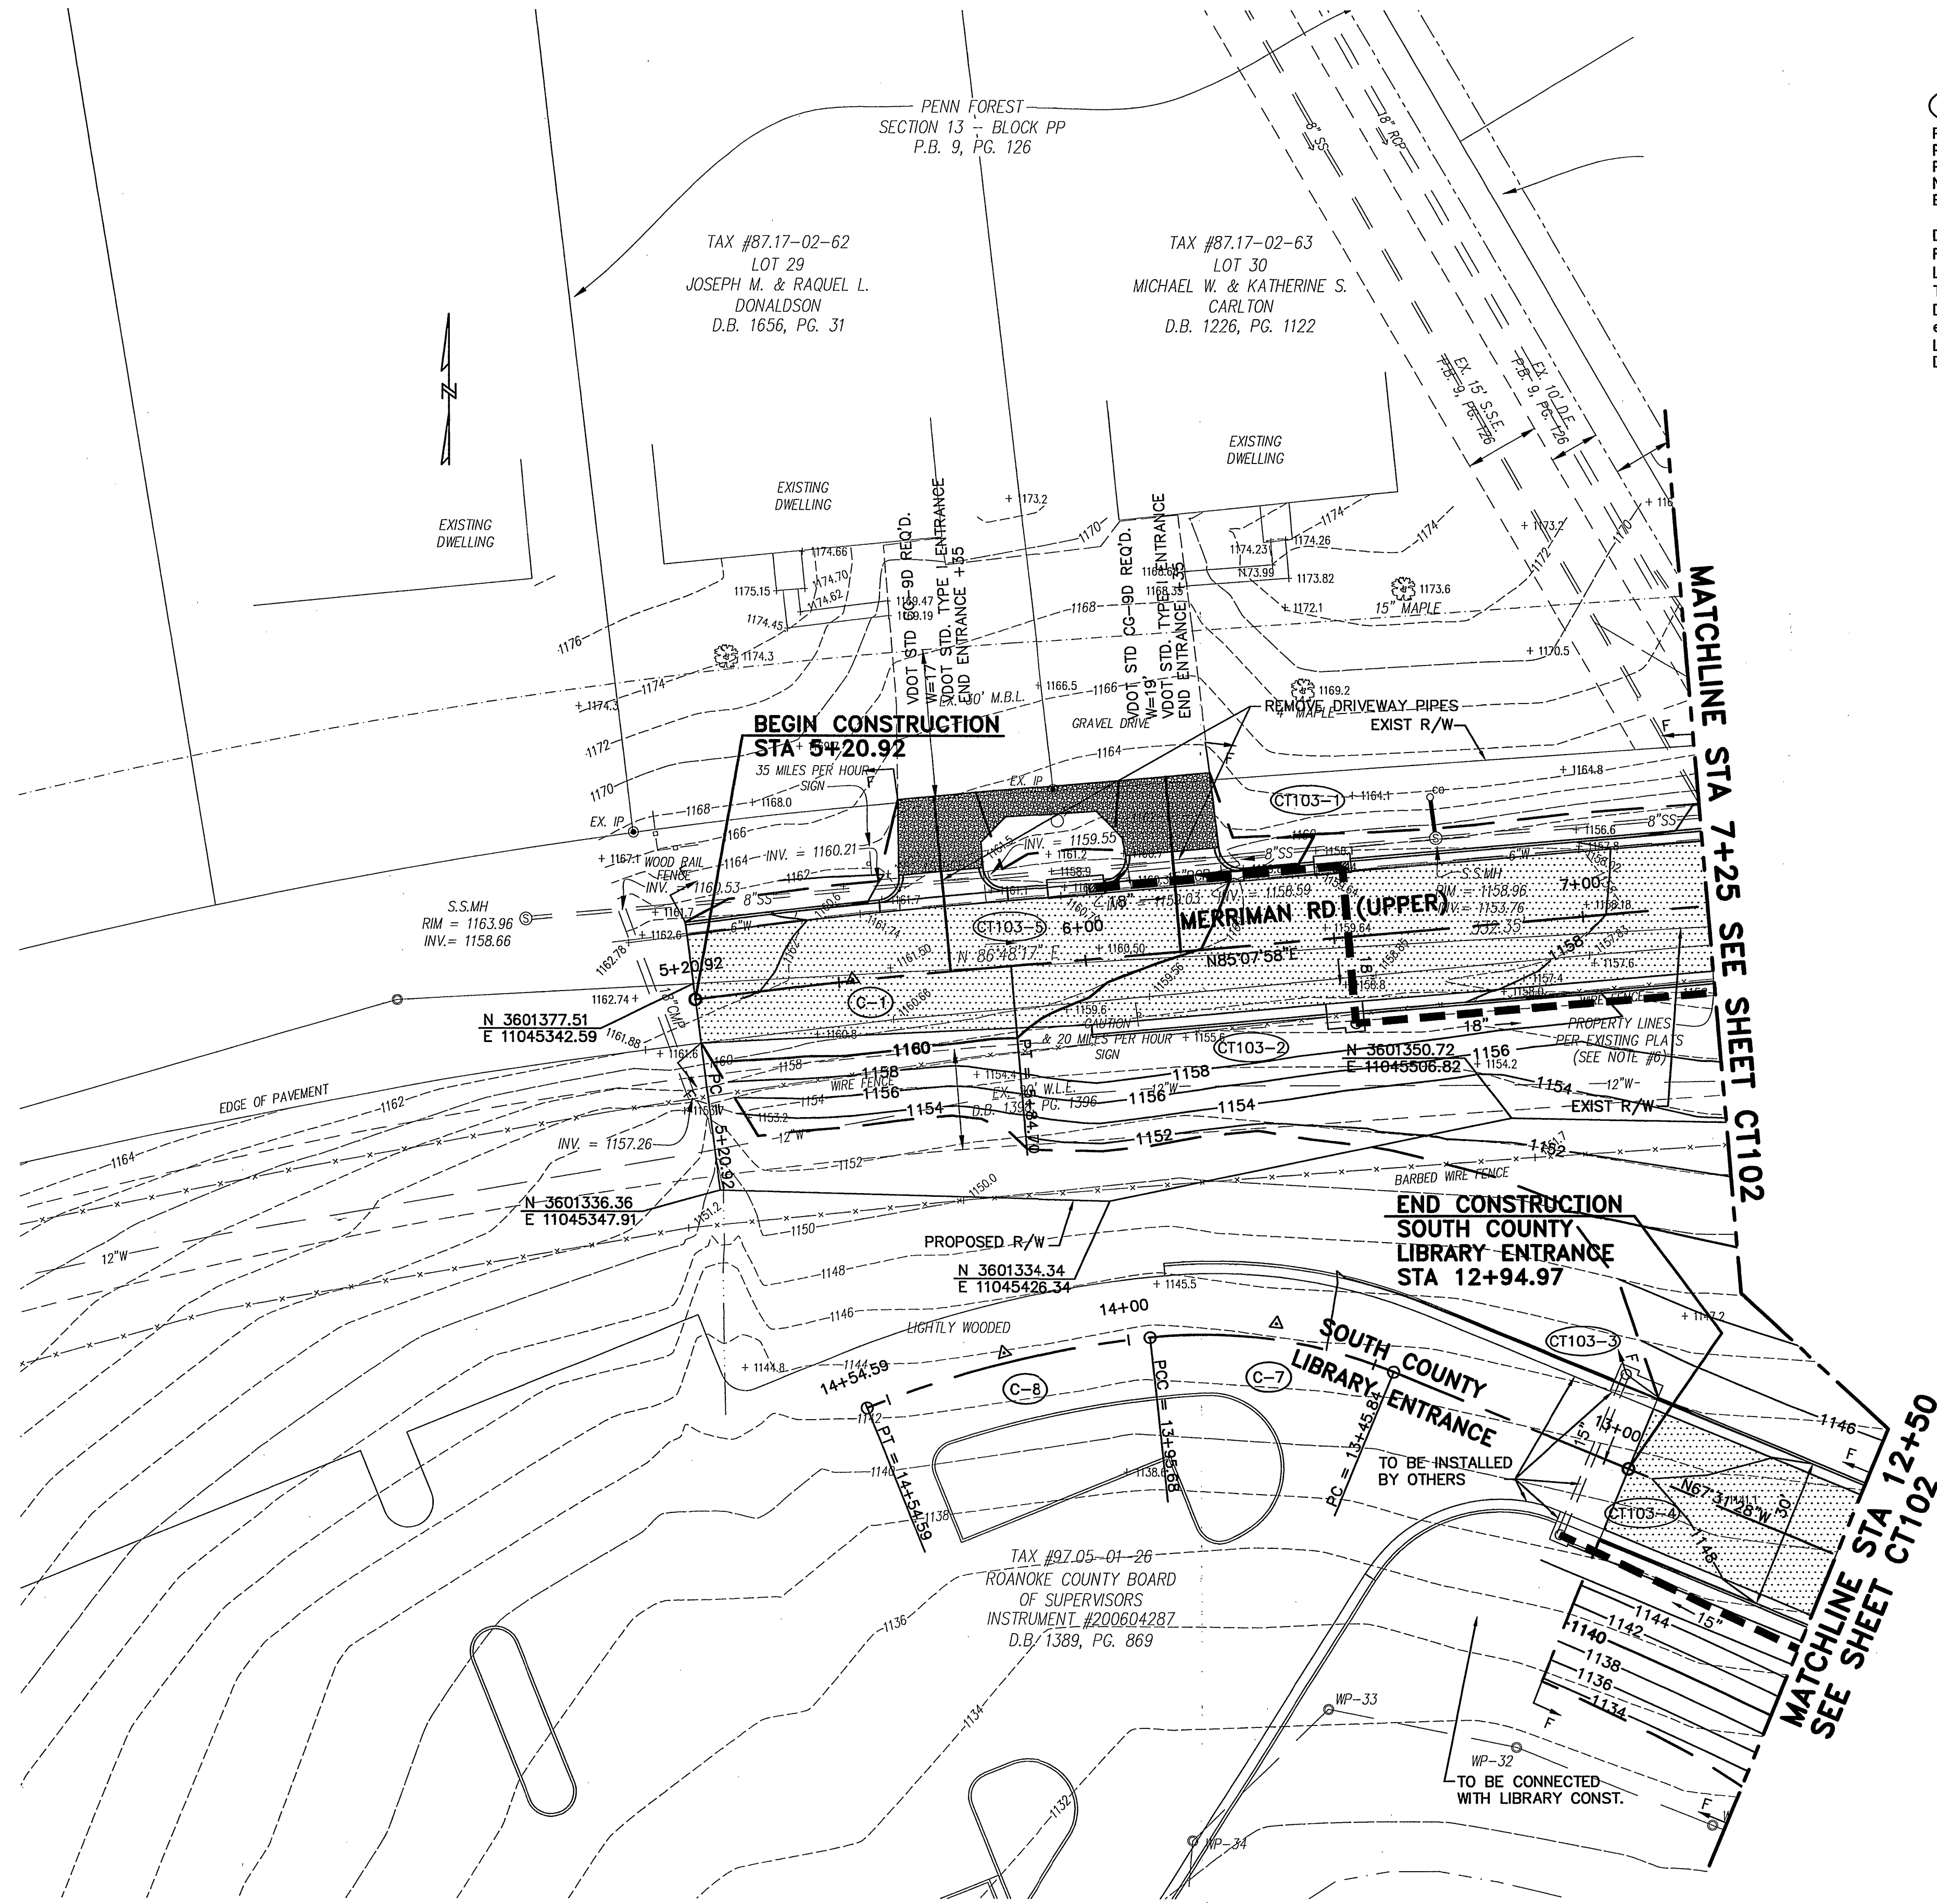

|                       |                       |                       |
|-----------------------|-----------------------|-----------------------|
| <b>C-1</b>            | <b>C-7</b>            | <b>C-8</b>            |
| PC = 5+20.92          | PC = 13+45.84         | PC = 13+95.68         |
| PT = 5+84.70          | PT = 13+95.68         | PT = 14+54.59         |
| PI = 5+52.81          | PI = 13+71.29         | PI = 14+25.33         |
| N = 3601378.38        | N = 3601309.74        | N = 3601303.90        |
| E = 11045374.63       | E = 11045459.62       | E = 11045404.84       |
| DELTA = 02°30'13" RT  | DELTA = 28°33'18" LT  | DELTA = 15°55'14" LT  |
| R = 1459.60'          | R = 100.00'           | R = 212.00'           |
| L = 63.78'            | L = 49.84'            | L = 58.91'            |
| T = 31.89'            | T = 25.45'            | T = 29.64'            |
| D = 03°55'32"         | D = 57°17'45"         | D = 27°01'35"         |
| e = MATCH EXISTING    | e = NA                | e = NA                |
| LS = 46.00'           | LS = NA               | LS = NA               |
| DESIGN SPEED = 30 MPH | DESIGN SPEED = 20 MPH | DESIGN SPEED = 20 MPH |


| REFERENCES                         |               |
|------------------------------------|---------------|
| TYPICAL SECTIONS                   | CT003         |
| DRAINAGE DESCRIPTIONS              | CT004         |
| DEMOLITION PLAN                    | CT101         |
| ROADWAY PROFILES                   | CT102A,CT102B |
| EROSION AND SEDIMENT CONTROL PLANS | CT106         |
| PAVEMENT MARKING AND SIGNAGE PLAN  | CT108         |
| SWM PLAN                           | CT109         |
| LIGHTING PLAN                      | CT110         |

| LEGEND |                              |
|--------|------------------------------|
|        | DENOTES AREA OF NEW PAVEMENT |
|        | DENOTES AREAS OF CUT         |
|        | DENOTES AREAS OF FILL        |
|        | DENOTES TEMPORARY EASEMENT   |
|        | DENOTES PERMANENT EASEMENT   |



## GRAPHIC SCALES

SEALS

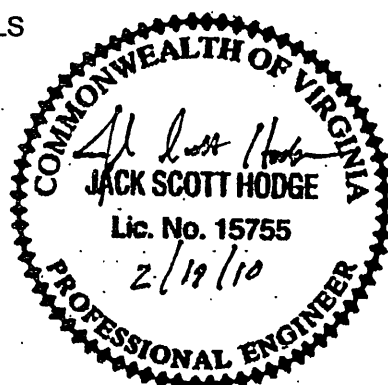

CONSULTANT

## TRAFFIC ROUNDABOUT FOR MERRIMAN ROAD AND SOUTH COUNTY LIBRARY

ROANOKE COUNTY  
ROANOKE COUNTY, VIRGINIA

**AECOM**

1315 FRANKLIN ROAD  
ROANOKE, VA 24016  
(540) 857-3100 www.aecom.com

| REV | DATE | DESCRIPTION | APP |
|-----|------|-------------|-----|
|     |      |             |     |
|     |      |             |     |
|                |                   |
|----------------|-------------------|
| PROJECT NO:    | 30233             |
| PROJECT PHASE: |                   |
| ISSUE DATE:    | FEBRUARY 19, 2010 |
| DESIGNED BY:   | AEB               |
| DRAWN BY:      | MGS               |
| CHECKED BY:    | JSH               |
| SUBMITTED BY:  | JSH               |

CIVIL

ROADWAY PLAN

CT103