
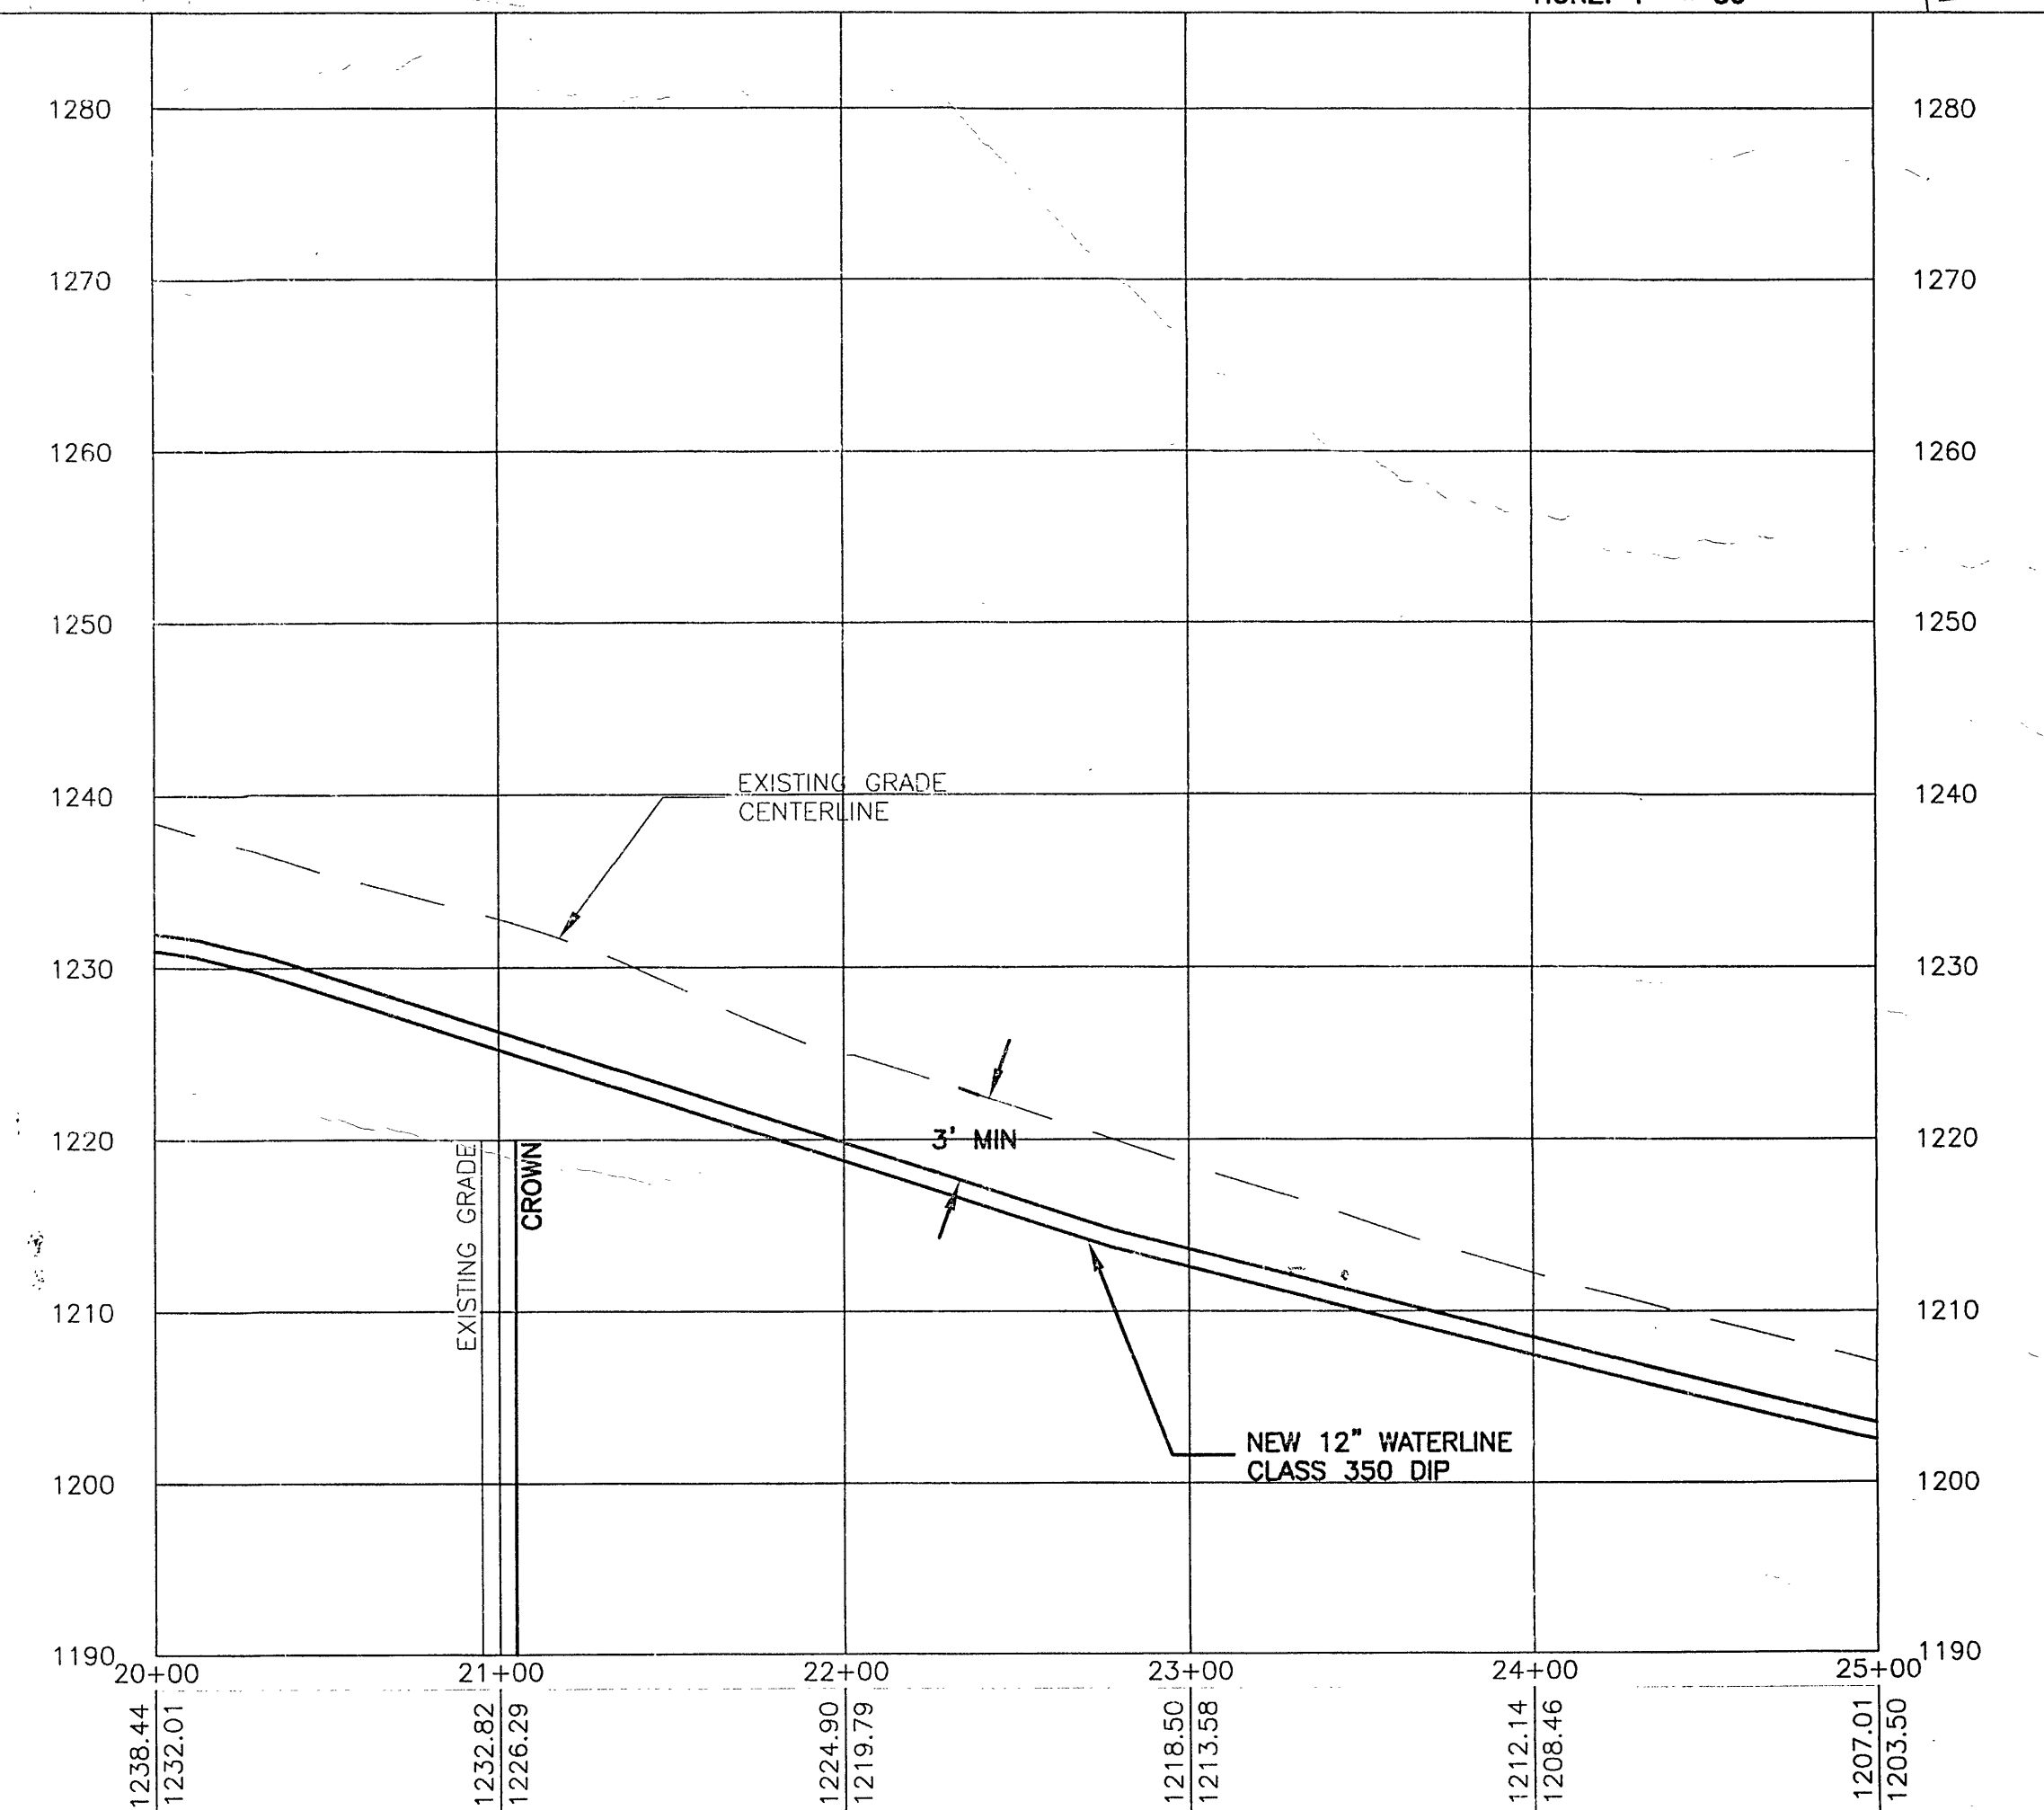


P:\FC - Plateau Plaza\FCP1004\EEC.dwg Sheets\Phase II\STA - 10+00.00 to 25+00.00.dwg

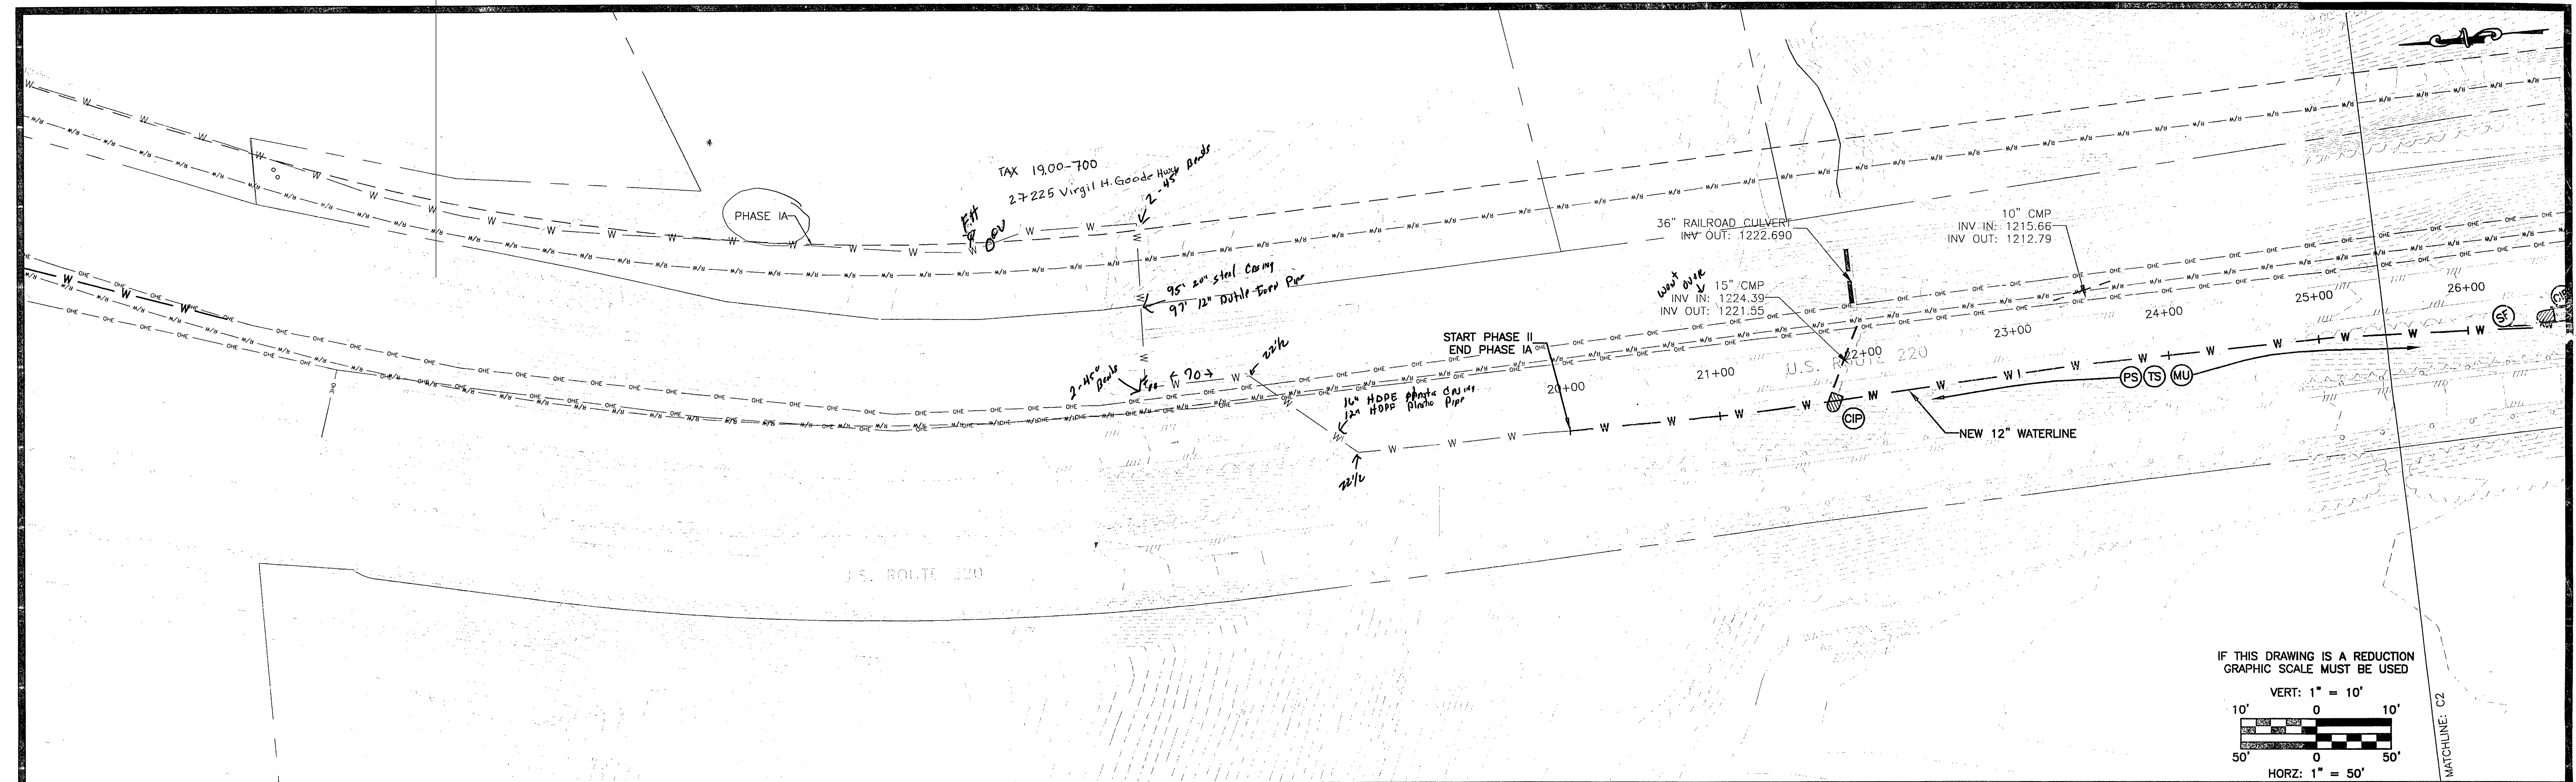


No:	Revisions:	Date:
1	FRANKLIN COUNTY COMMENTS	02/27/09

 **EARTH
ENVIRONMENTAL
CONSULTANTS, INC.**

235 Claiborne Ave.,
Rocky Mount, VA 24151
www.eorthernv.com

Phone: (540) 483-5975
Fax: (540) 483-2221

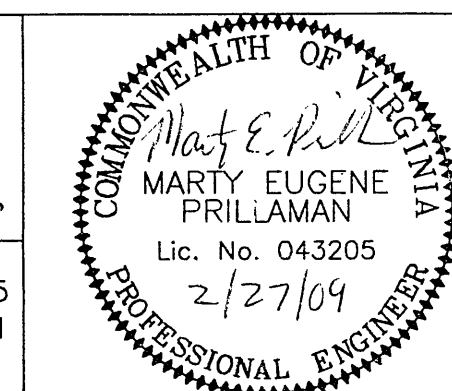

 **WATER AUTHORITY**

 **Franklin County**

DESIGN BY: BKS/MEP	PROJECT: ROANOKE/FRANKLIN COUNTY WATERLINE EXTENSION PHASE II U.S. ROUTE 220 FRANKLIN COUNTY, VA	DATE: 01/14/09
DRAWN BY: BKS	TITLE: Plan and Profile STA - 20+00.00 to 25+00.00	DRAWING NUMBER: C1
REVIEWED BY: MEP	DRAWING NAME: STA - 10+00.00 to 25+00.00.dwg	SHEET NUMBER: 3 of 28
PROJECT NUMBER: FCPP1004	SCALE: H: 1" = 50' V: 1" = 10'	