
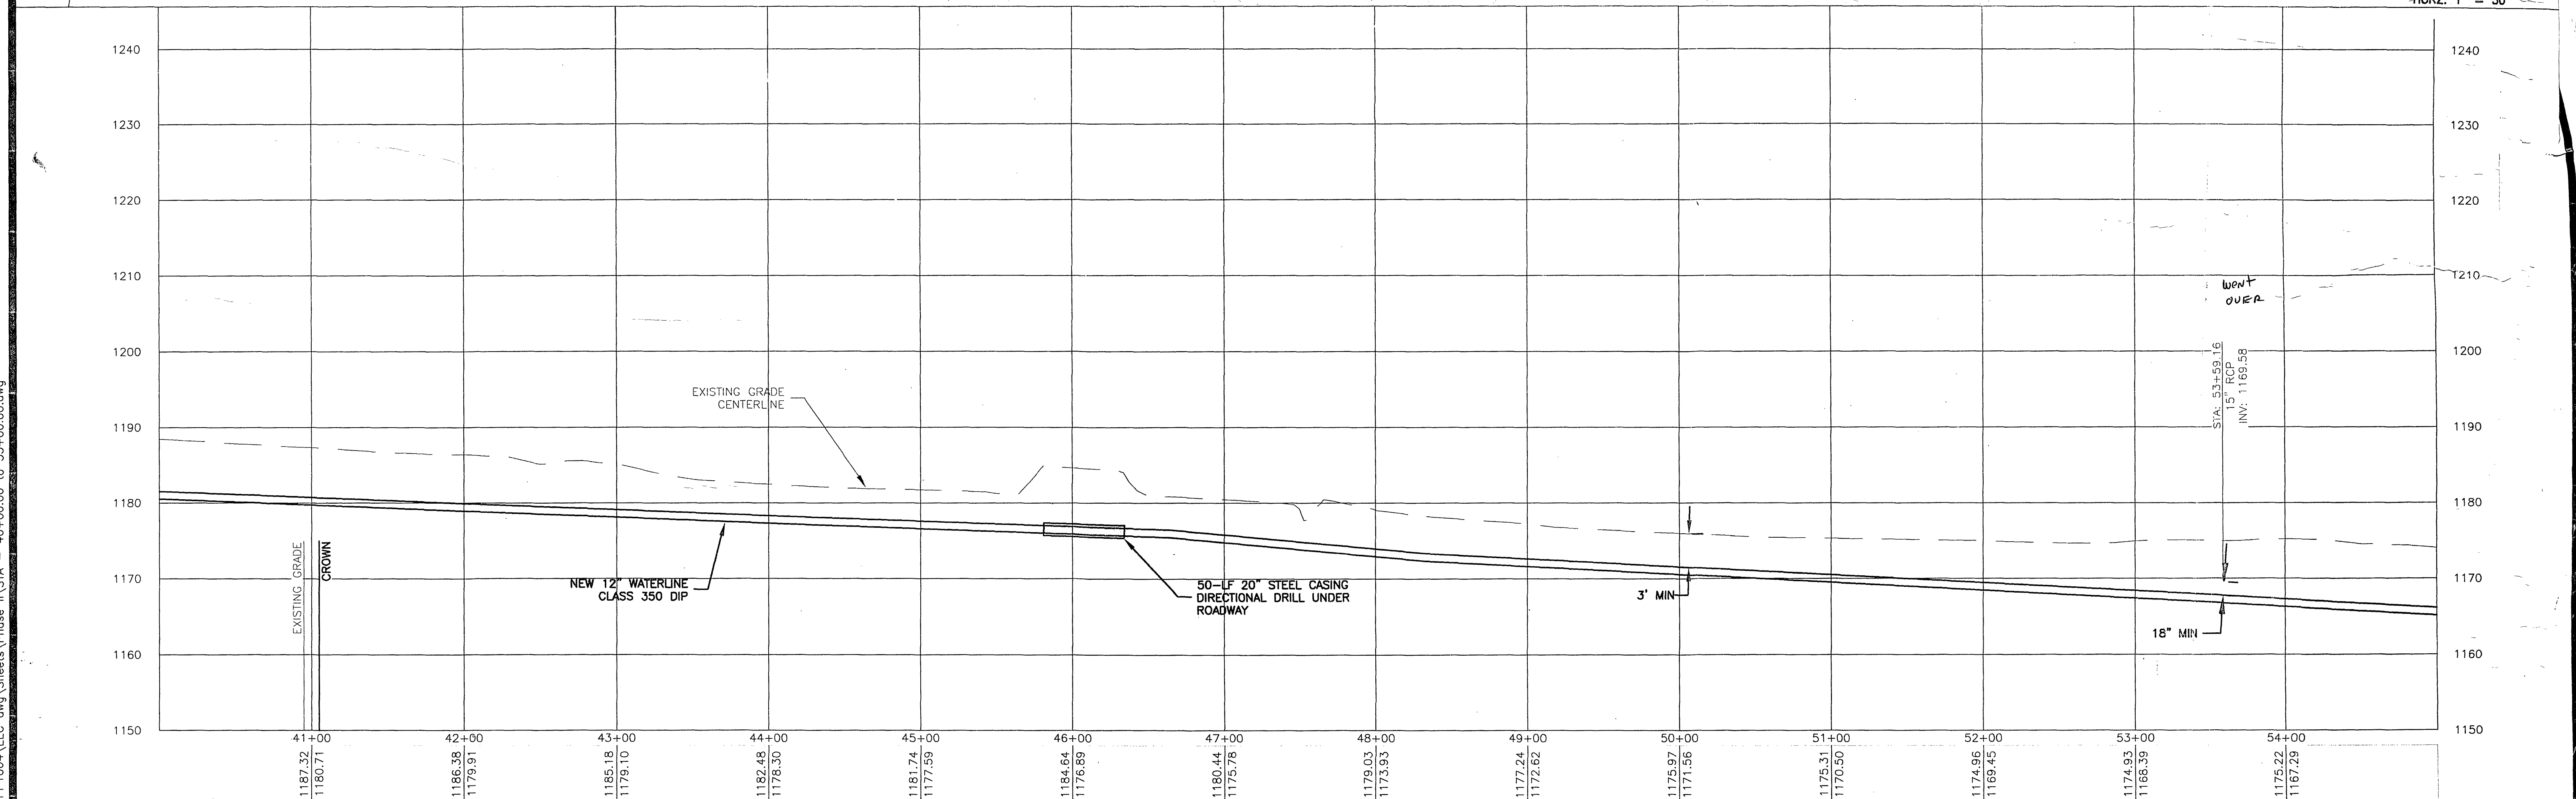
 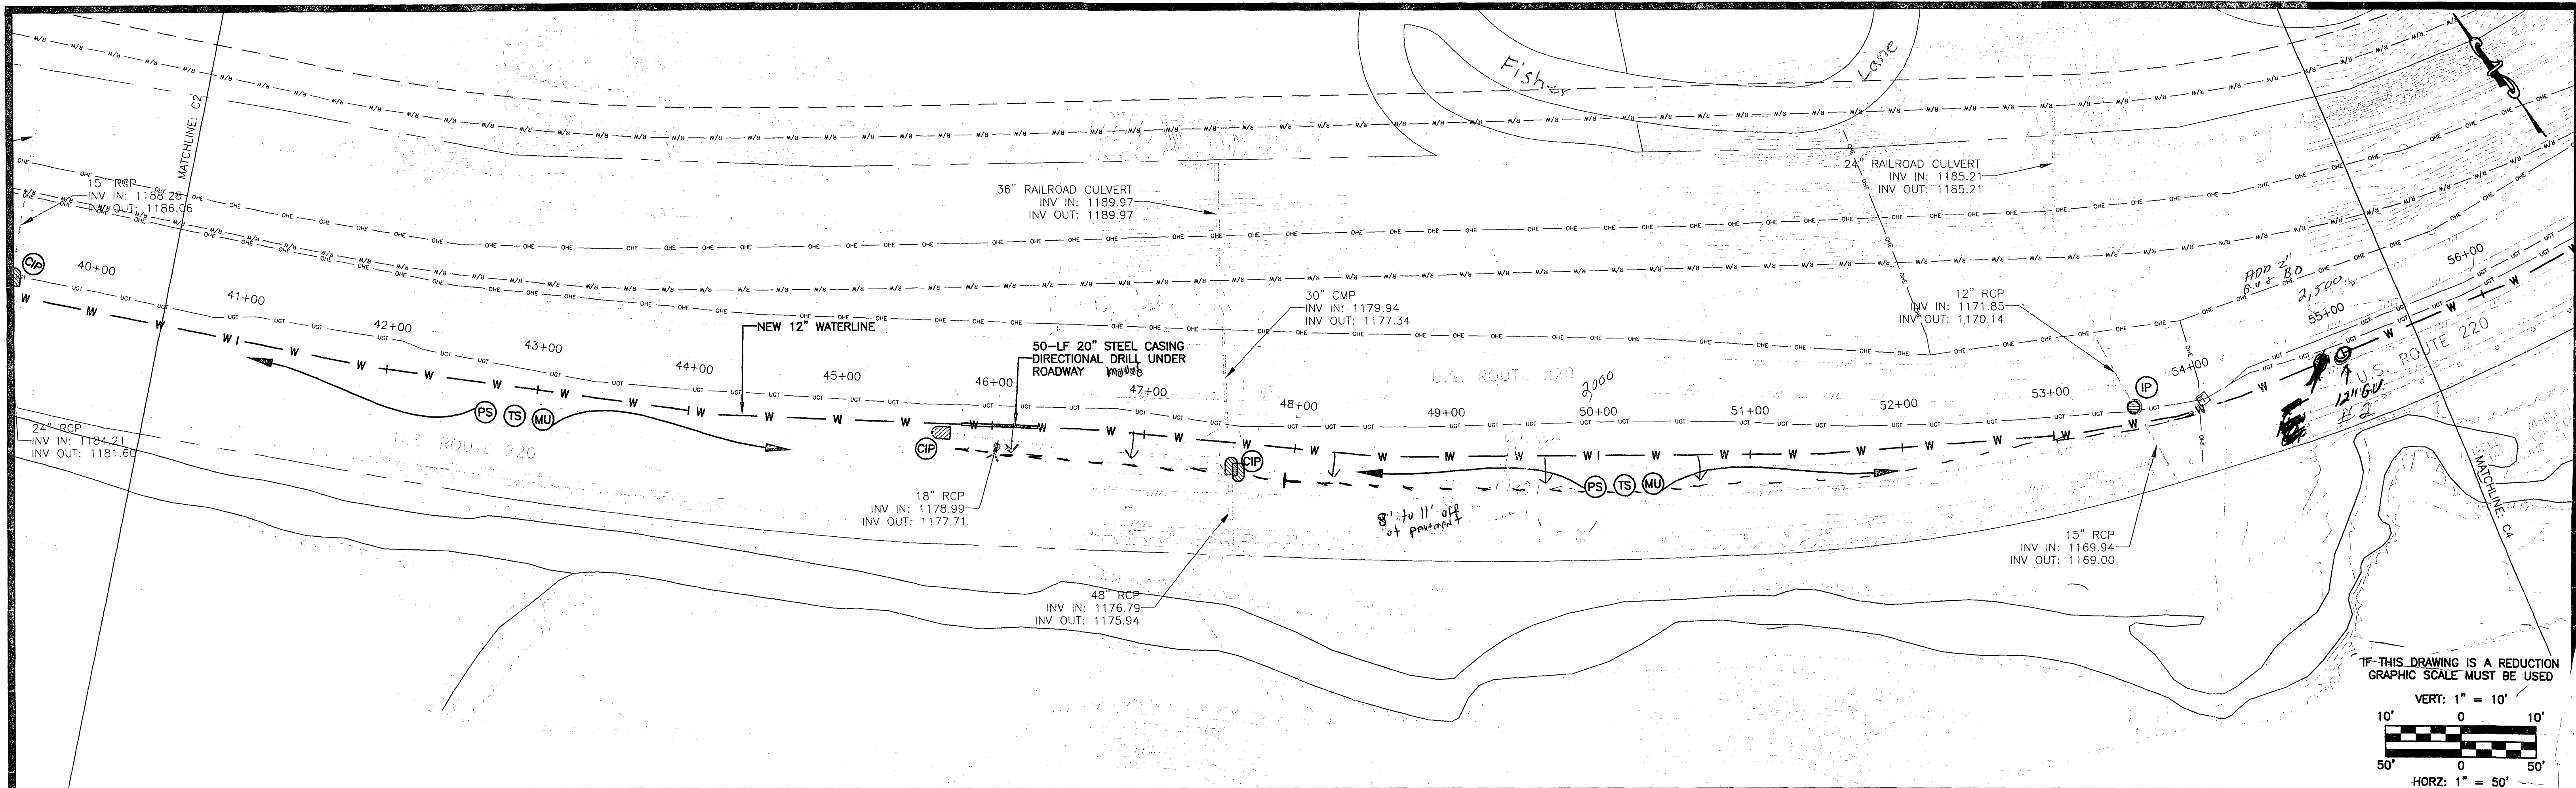
 


P:\FC - Plateau Plaza\FCPP1004\FEC.dwg Sheets\Phase II\STA - 40+00.00 to 55+00.00.dwg



No:		Revisions:		Date:	
1		FRANKLIN COUNTY COMMENTS		02/27/09	

 EARTH ENVIRONMENTAL CONSULTANTS, INC.					
235 Claiborne Ave., Rocky Mount, VA 24151 www.earthenv.com		Phone: (540) 483-5975 Fax: (540) 483-2221			

DESIGN BY: BKS/MEP	PROJECT: ROANOKE/FRANKLIN COUNTY WATERLINE EXTENSION PHASE II U.S. ROUTE 220 FRANKLIN COUNTY, VA	DATE: 01/14/09
DRAWN BY: BKS	TITLE: Plan and Profile STA - 40+00.00 to 55+00.00	DRAWING NUMBER: C3
REVIEWED BY: MEP	DRAWING NAME: STA - 40+00.00 to 55+00.00.dwg	SHEET NUMBER: 5 of 28
PROJECT NUMBER: FCPP1004	SCALE: H: 1" = 50' V: 1" = 10'	