
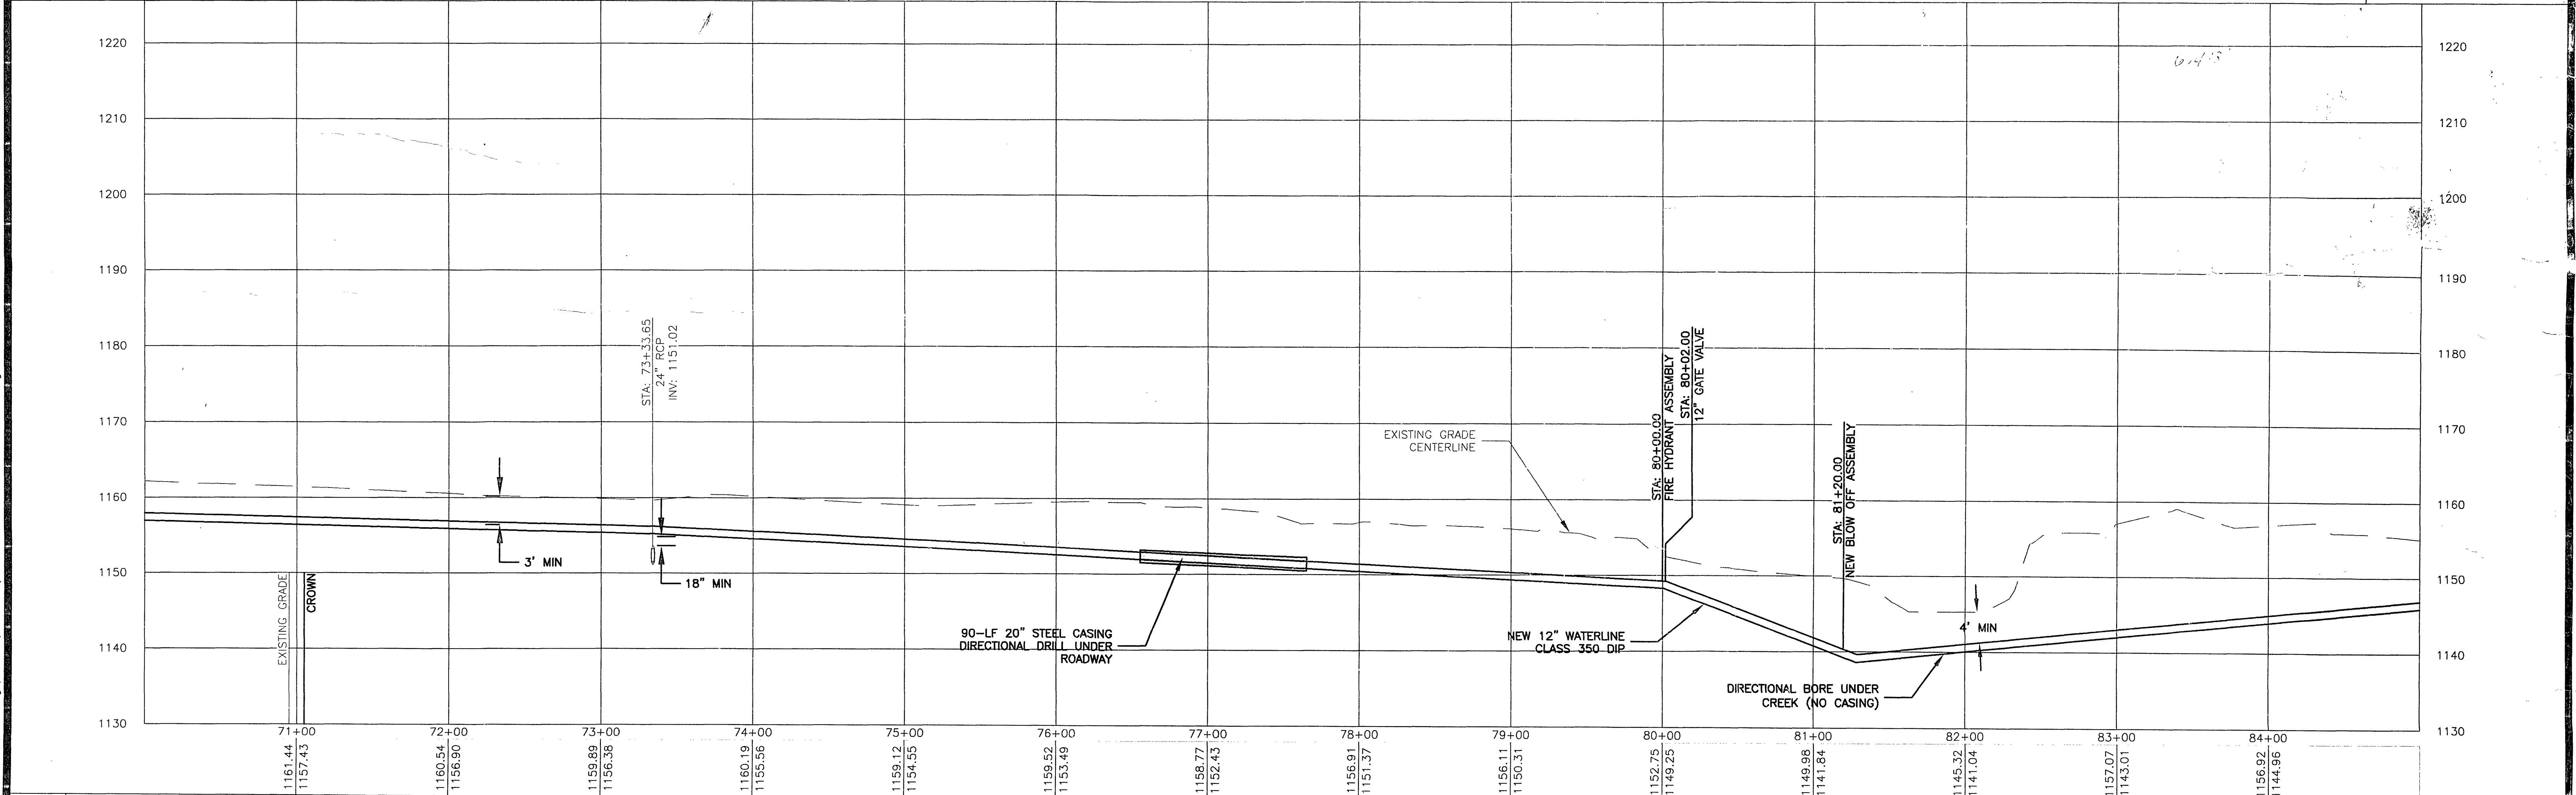


P:\FC - Plateau Plaza\FCPP1004\EEC.dwg Phase II\STA - 70+00.00 to 85+00.00.dwg

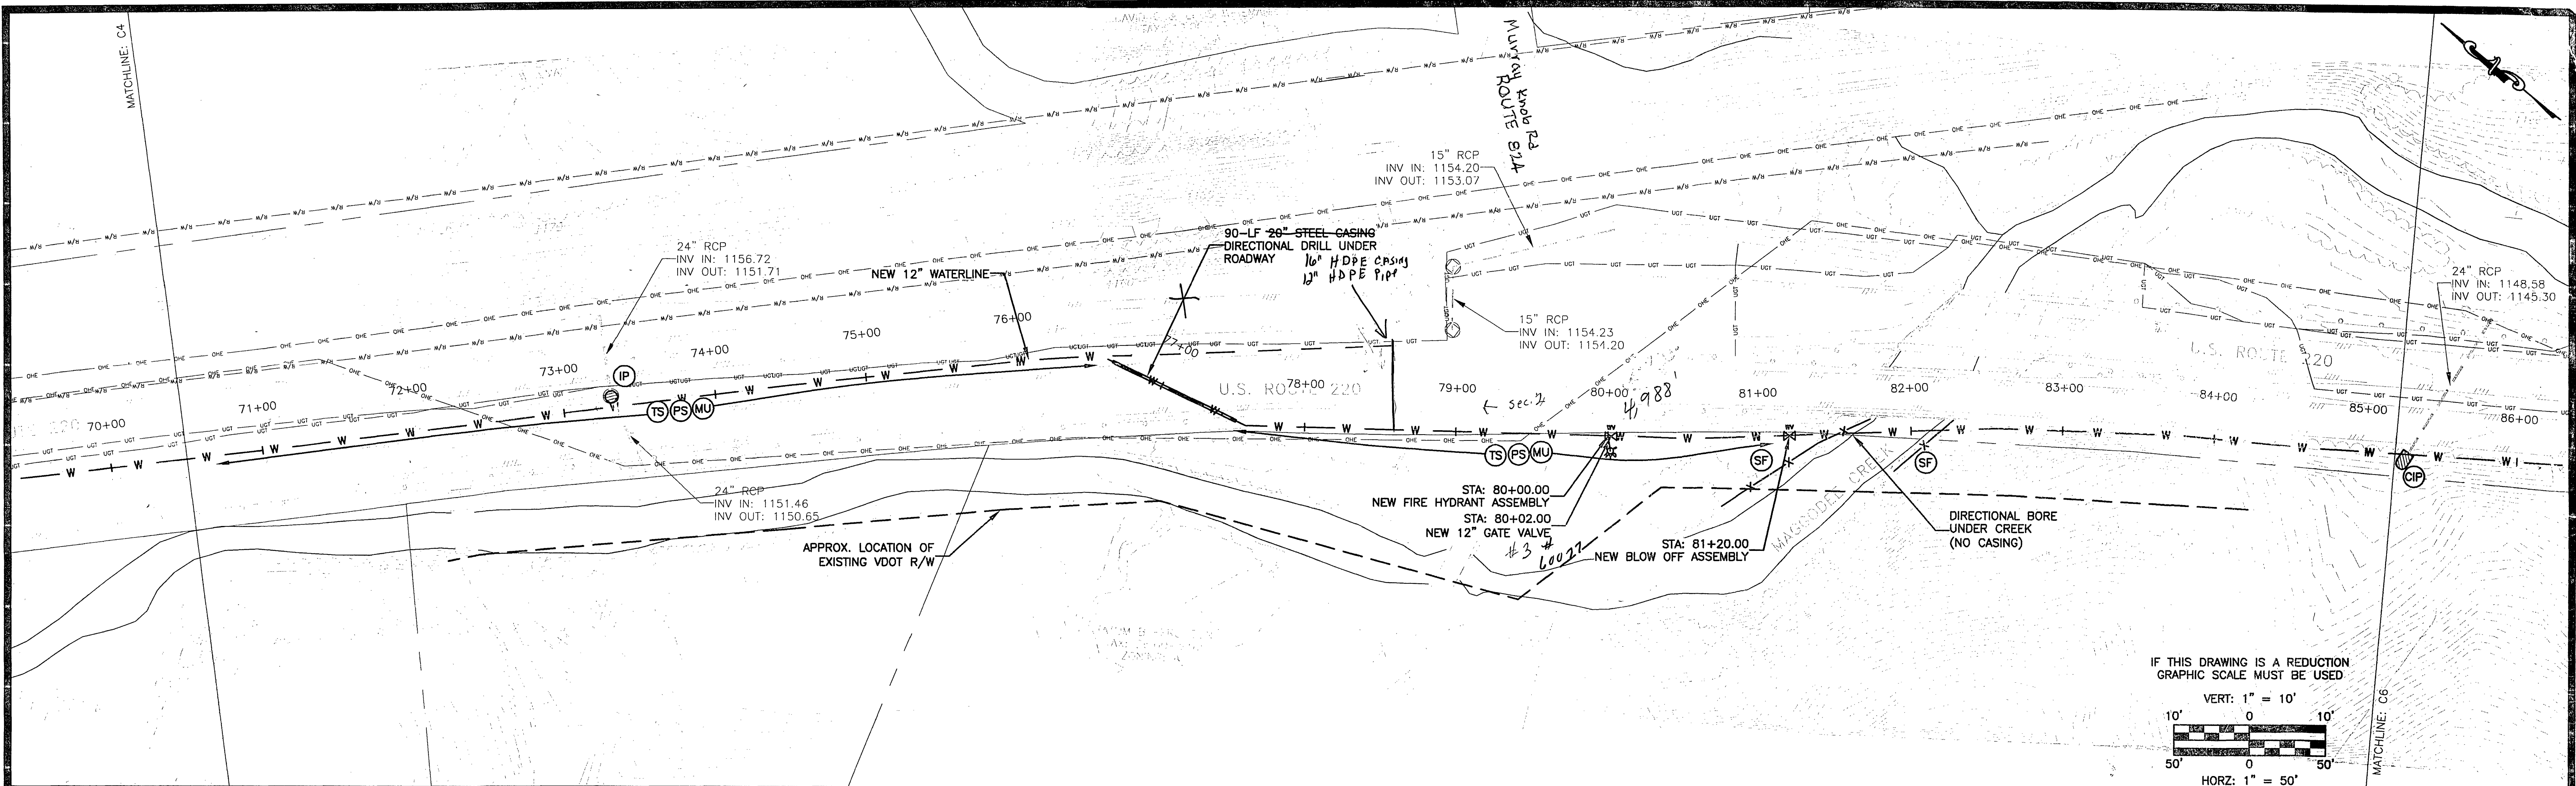

No.	Revisions:	Date:
1	FRANKLIN COUNTY COMMENTS	02/27/09

EARTH ENVIRONMENTAL CONSULTANTS, INC.
235 Claiborne Ave., Phone: (540) 483-5975
Rocky Mount, VA 24151 Fax: (540) 483-2221
www.earthenv.com

COMMONWEALTH OF VIRGINIA
MARTY EUGENE PRILLAMAN
Lic. No. 043205
2/27/09
PROFESSIONAL ENGINEER

WATER AUTHORITY
Franklin County
COUNTY OF ROANOKE, VIRGINIA

DESIGN BY: BKS/MEP	PROJECT: ROANOKE/FRANKLIN COUNTY WATERLINE EXTENSION PHASE II	DATE: 01/14/09
DRAWN BY: BKS	TITLE: U.S. ROUTE 220 FRANKLIN COUNTY, VA	DRAWING NUMBER: C5
REVIEWED BY: MEP	Plan and Profile STA - 70+00.00 to 85+00.00	SHEET NUMBER: 7 of 28
PROJECT NUMBER: FCPP1004	DRAWING NAME: STA - 70+00.00 to 85+00.00.dwg	SCALE: H: 1" = 50' V: 1" = 10'