
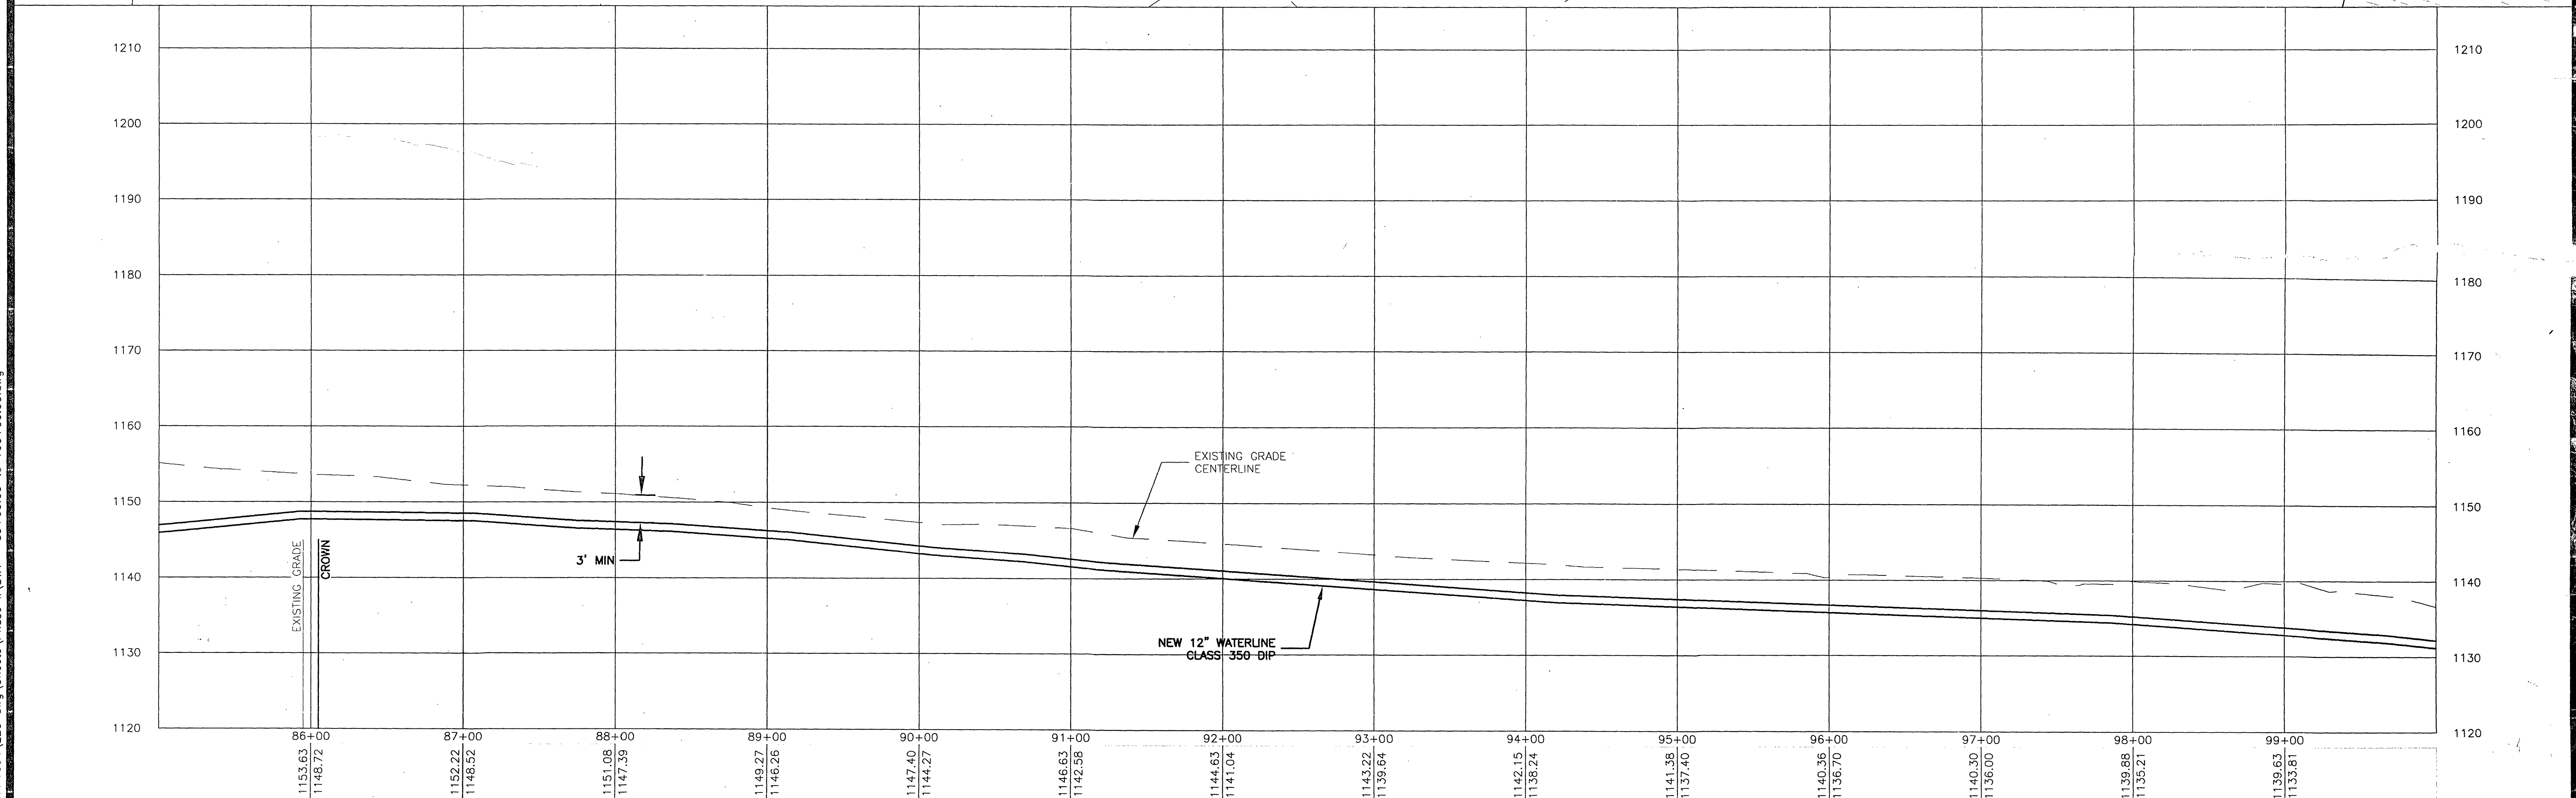
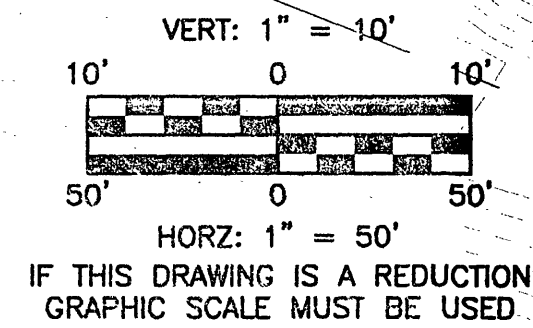
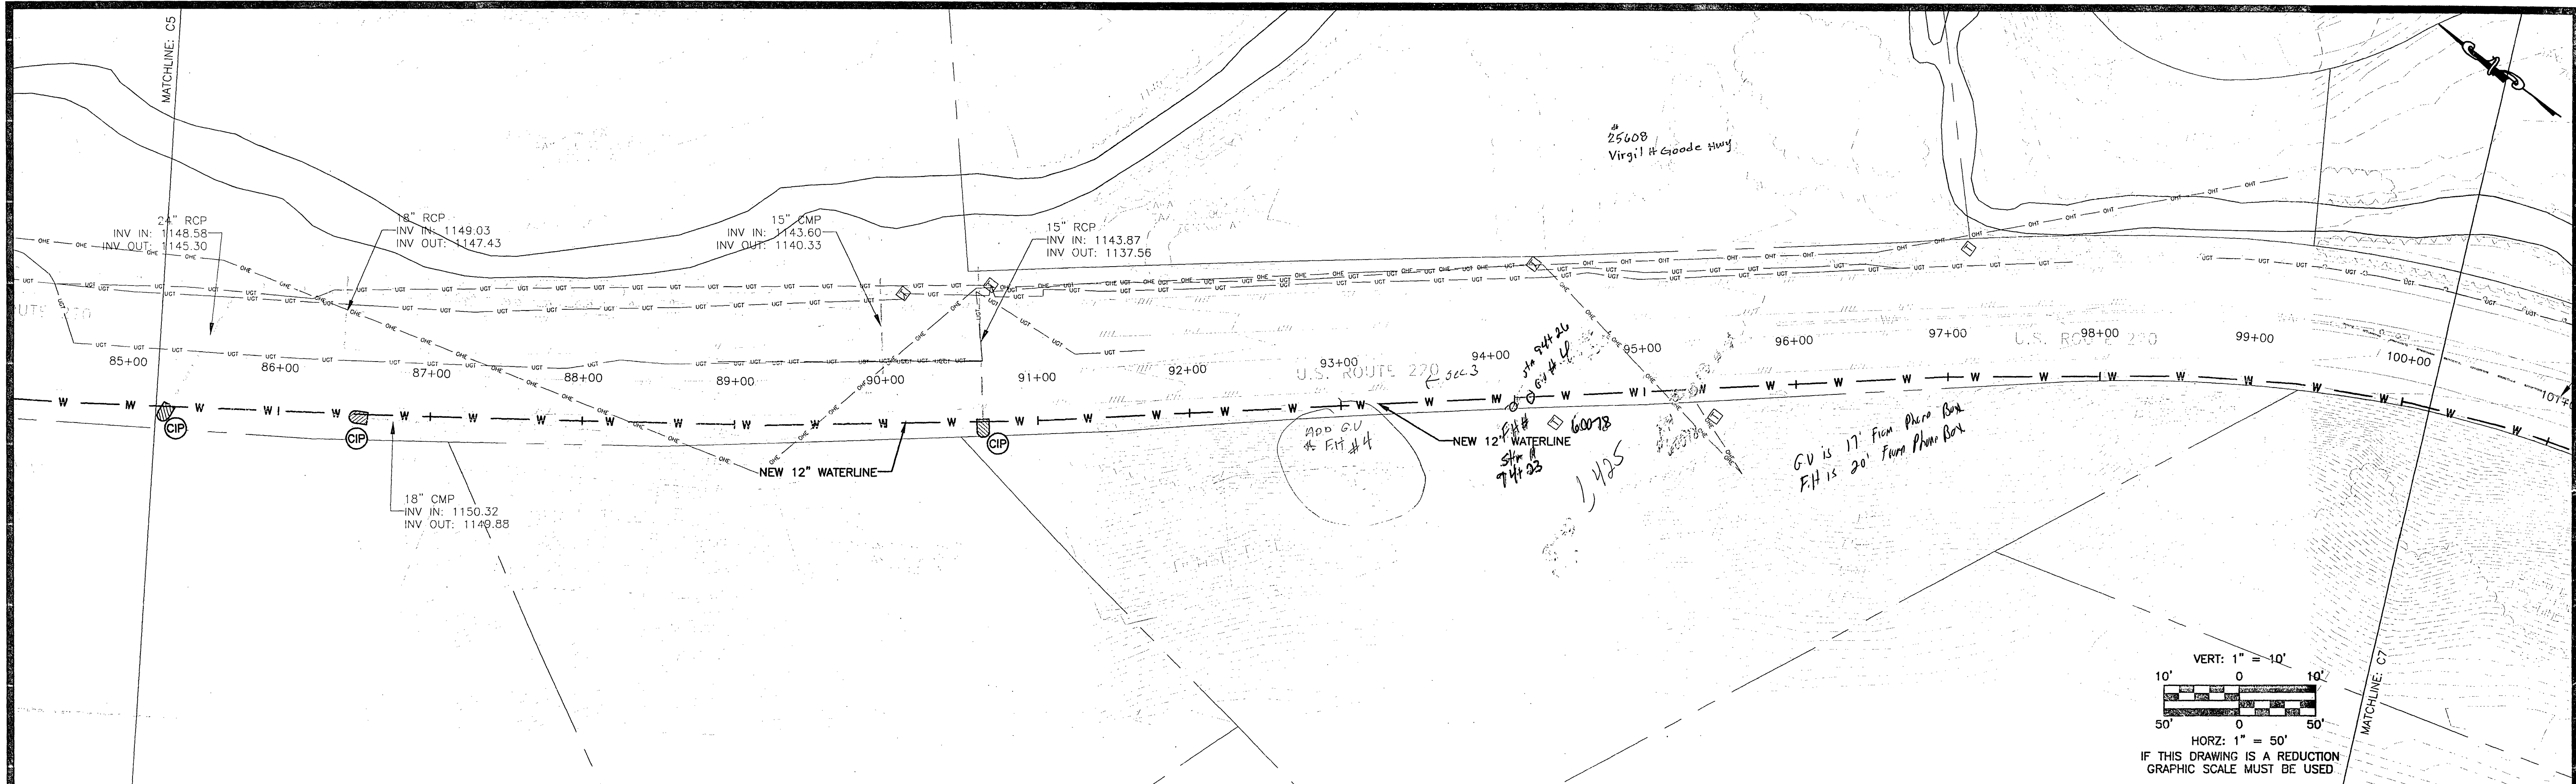
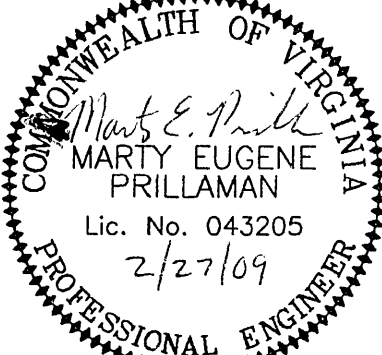


P:\FC - Plateau Plaza\FOP1004\EEC.dwg\Sheets\Phase II\STA - 85+00.00 to 100+00.00.dwg

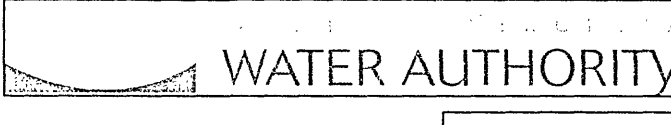

No:		Revisions:		Date:	
1	FRANKLIN COUNTY COMMENTS			02/27/09	

 EARTH ENVIRONMENTAL CONSULTANTS, INC.				 WATER AUTHORITY	
235 Claiborne Ave., Rocky Mount, VA 24151 www.earthenv.com		Phone: (540) 483-5975 Fax: (540) 483-2221			

DESIGN BY: BKS/MEP	PROJECT: ROANOKE/FRANKLIN COUNTY WATERLINE EXTENSION PHASE II U.S. ROUTE 220 FRANKLIN COUNTY, VA	DATE: 01/14/09
DRAWN BY: BKS		
REVIEWED BY: MEP	TITLE: Plan and Profile STA - 85+00.00 to 100+00.00	DRAWING NUMBER: C6
PROJECT NUMBER: FCPP1004		

DRAWING NAME: STA - 85+00.00 to 100+00.00.dwg	SCALE: H: 1" = 50' V: 1" = 10'	SHEET NUMBER: 8 of 28