



P:\FO - Plateau Plaza\FCPP1004\EEC.dwg\Sheets\Phase II\STA - 100+00.00 to 115+00.00.dwg

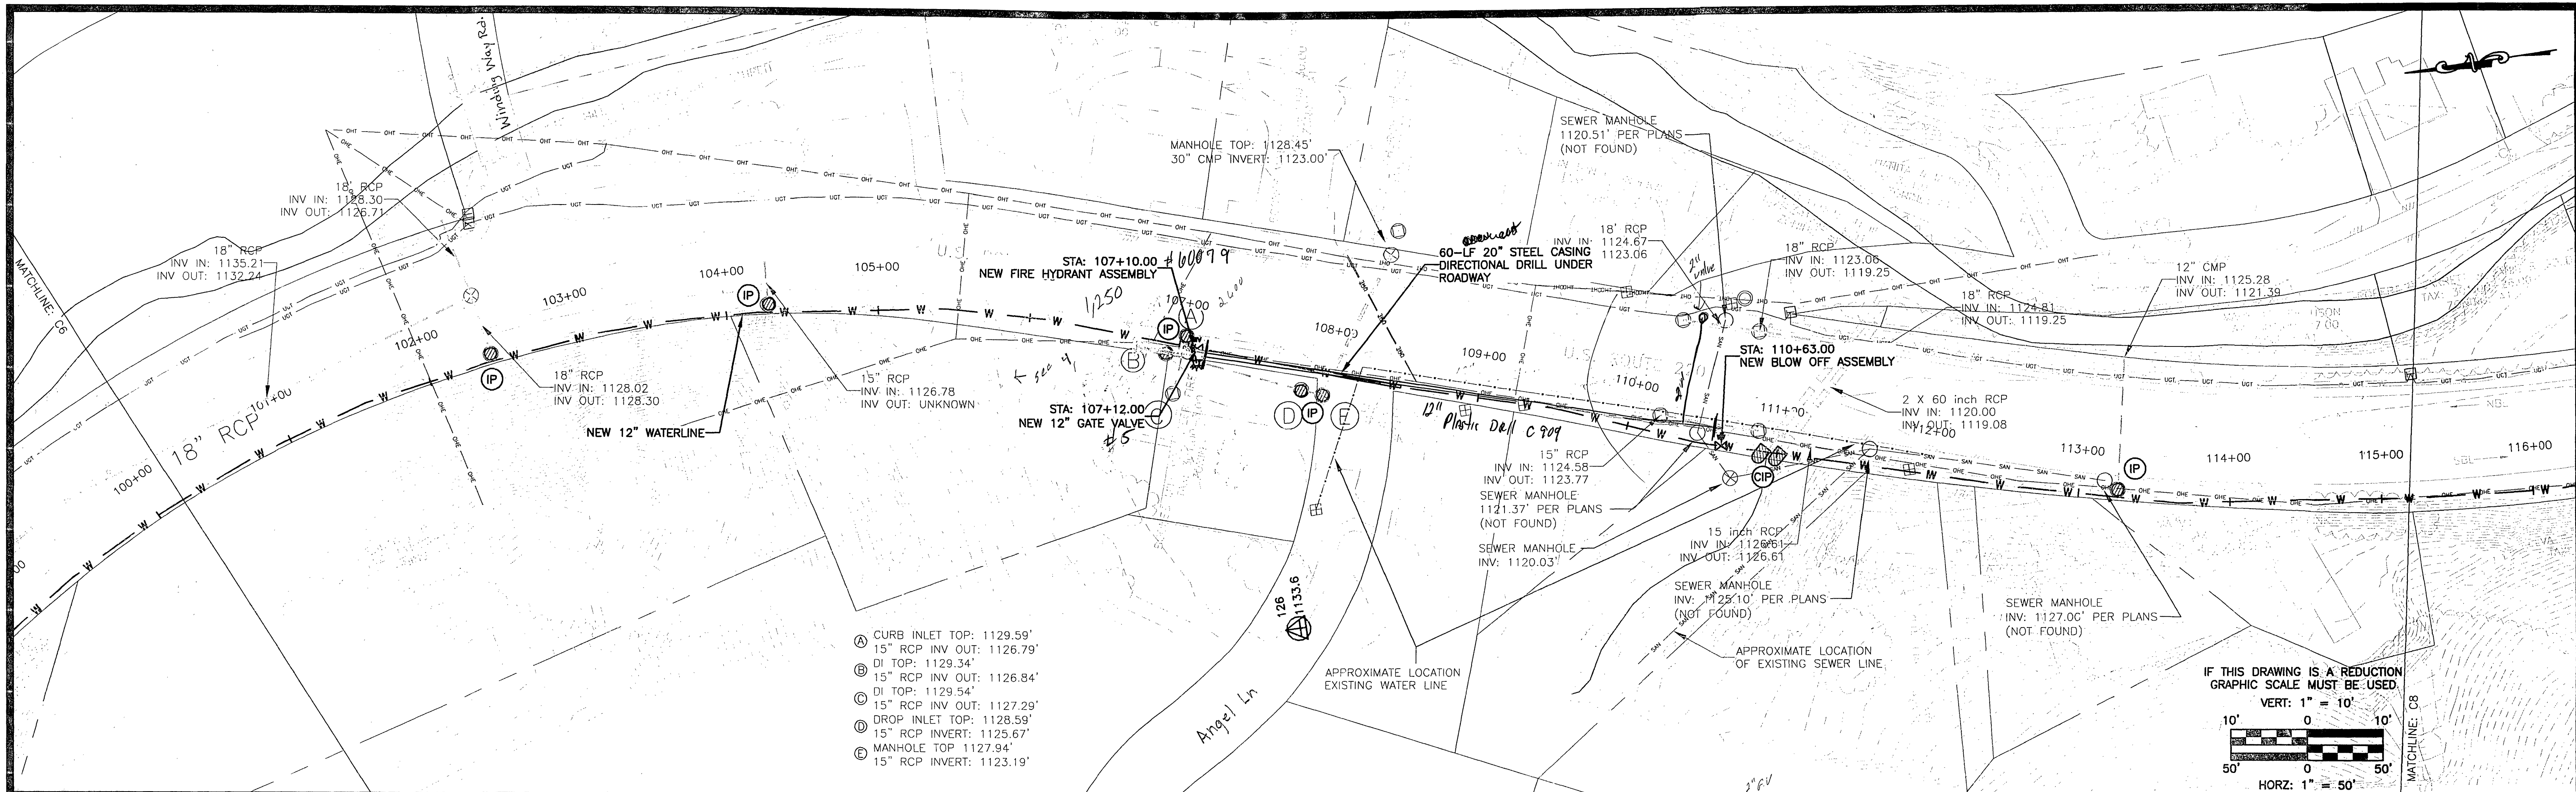



- ① CURB INLET TOP: 1129.59'
15" RCP INV OUT: 1126.79'
DI TOP: 1129.34'
② 15" RCP INV OUT: 1126.84'
DI TOP: 1129.54'
③ 15" RCP INV OUT: 1127.29'
DROP INLET TOP: 1128.59'
④ 15" RCP INVERT: 1125.67'
MANHOLE TOP 1127.94'
⑤ 15" RCP INVERT: 1123.19'

IF THIS DRAWING IS A REDUCTION
GRAPHIC SCALE MUST BE USED
VERT: 1" = 10'
HORIZ: 1" = 50'

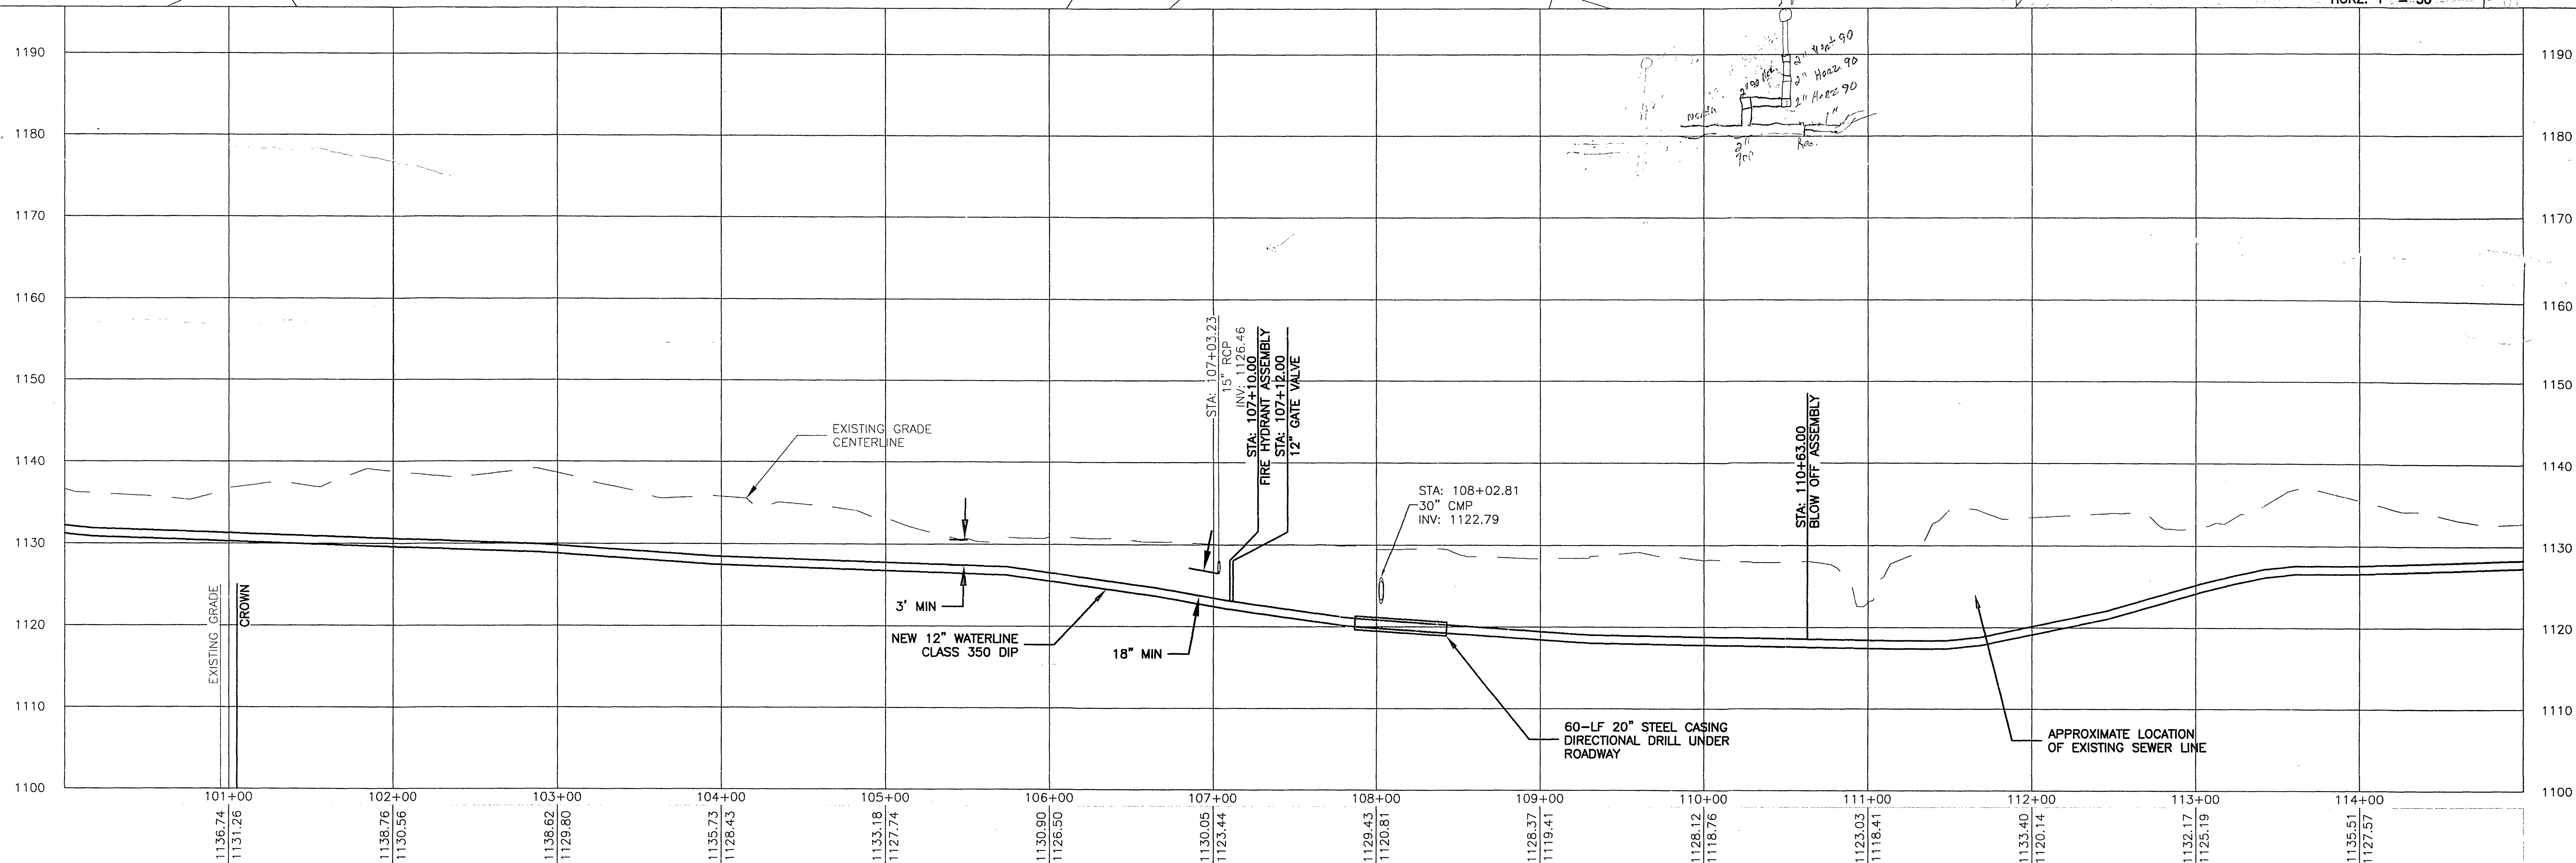

No.	Revisions:	Date:
1	FRANKLIN COUNTY COMMENTS	02/27/09

EARTH ENVIRONMENTAL CONSULTANTS, INC.
235 Claiborne Ave., Phone: (540) 483-5975
Rocky Mount, VA 24151 Fax: (540) 483-2221
www.earthenv.com

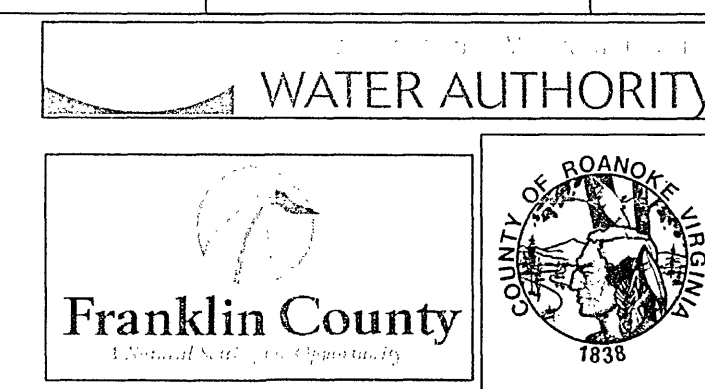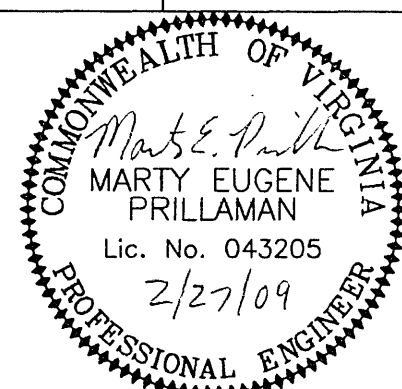

DESIGN BY: BKS/MEP	PROJECT: ROANOKE/FRANKLIN COUNTY WATERLINE EXTENSION PHASE II U.S. ROUTE 220 FRANKLIN COUNTY, VA	DATE: 01/14/09
DRAWN BY: BKS	TITLE: Plan and Profile STA - 100+00.00 to 115+00.00	DRAWING NUMBER: C7
REVIEWED BY: MEP	PROJECT NUMBER: FCPP1004	SHEET NUMBER: 9 of 28
DRAWING NAME: STA - 100+00.00 to 115+00.00.dwg	SCALE: H: 1" = 50' V: 1" = 10'	