
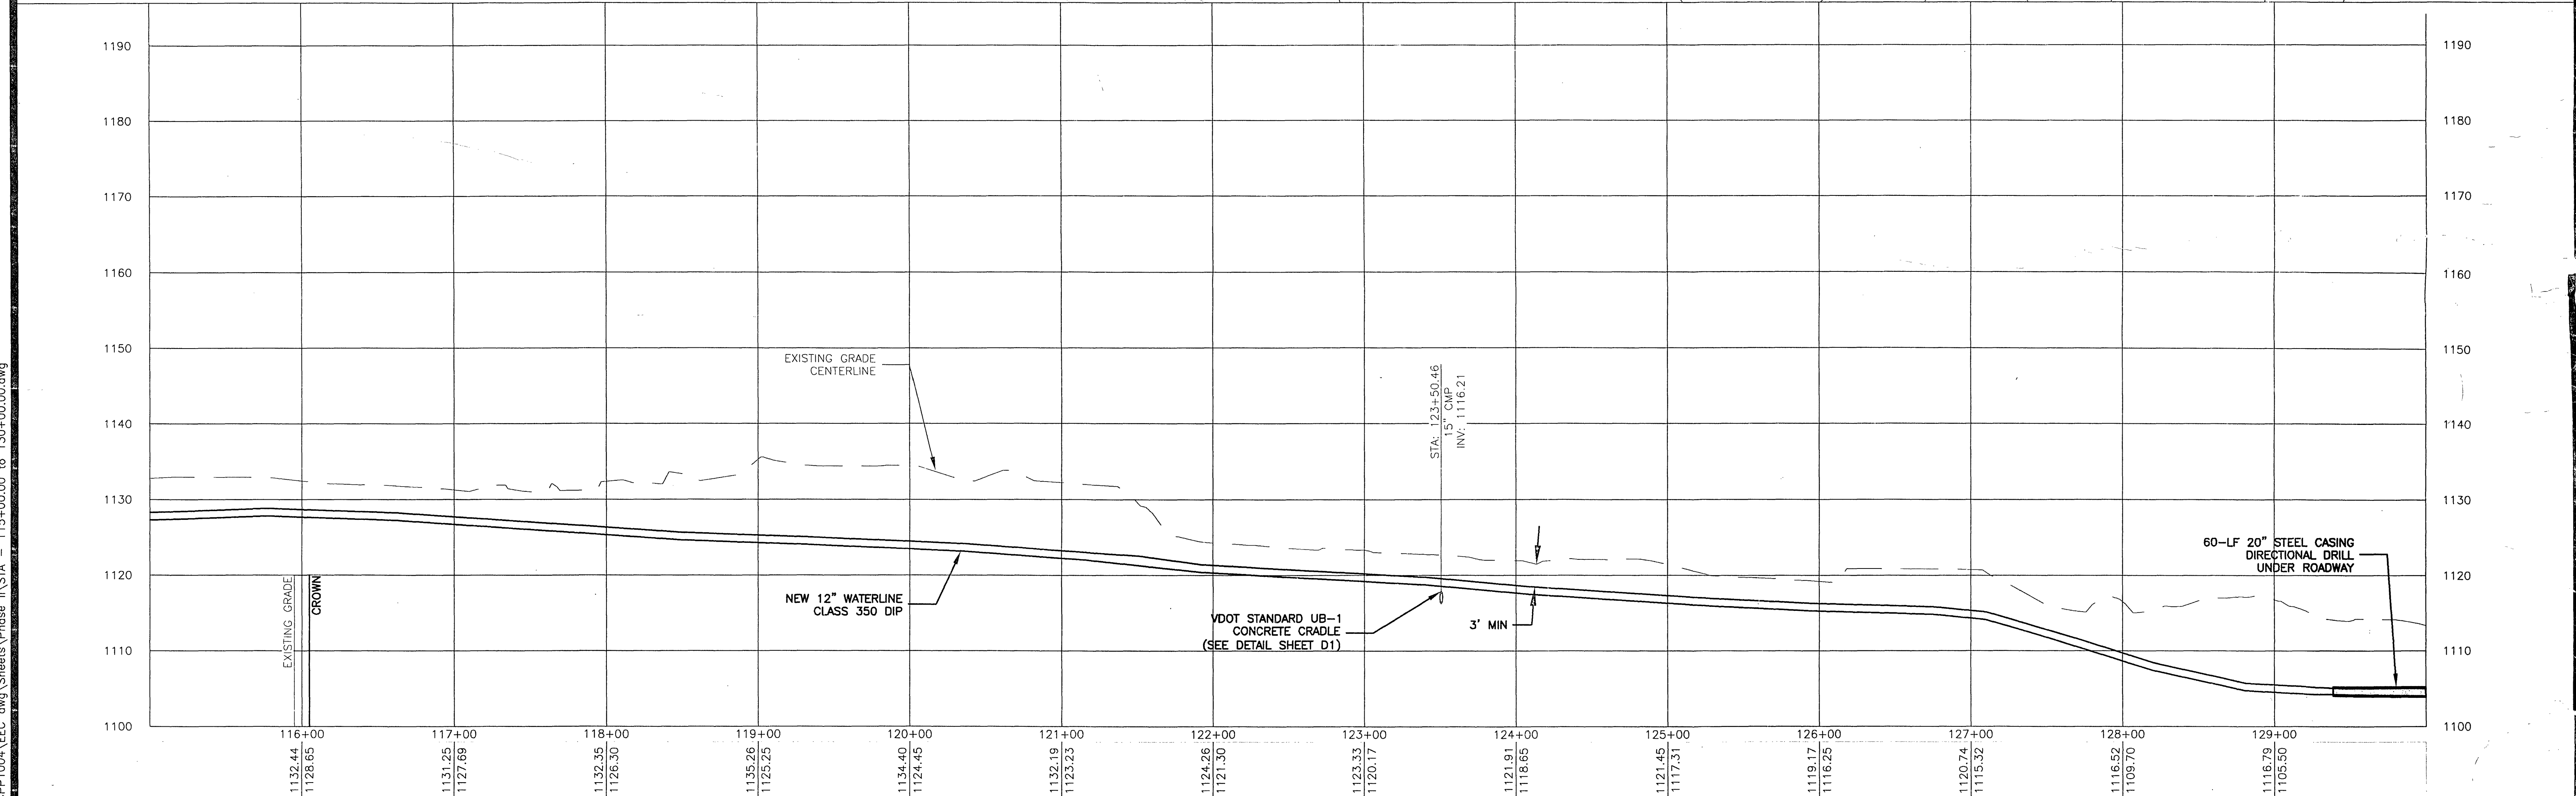
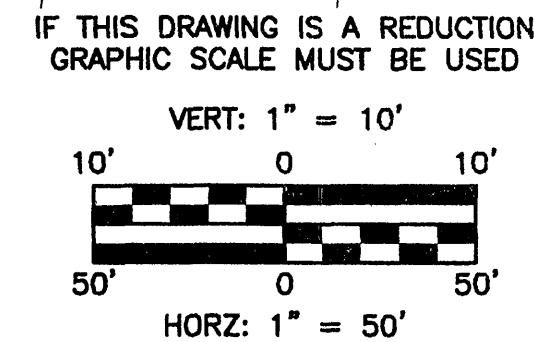
 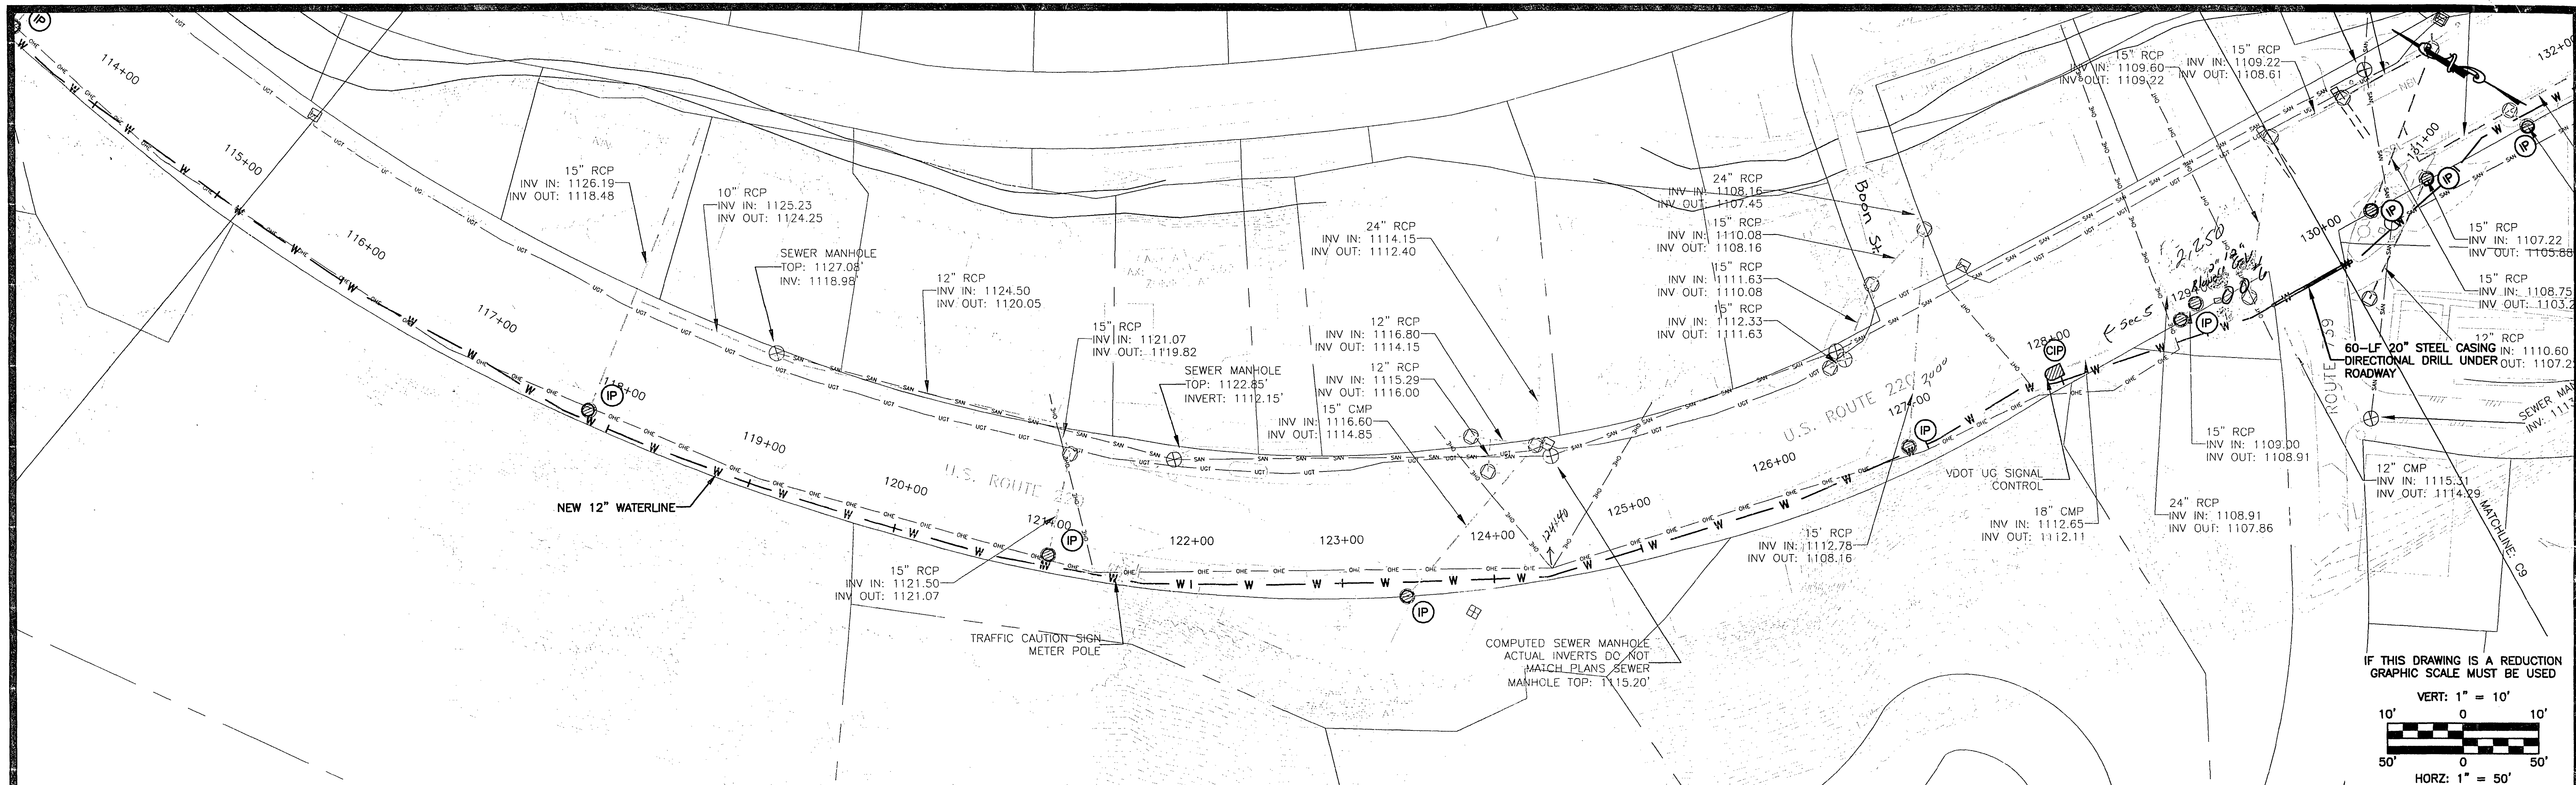
 


P:\FC - Plateau Plaza\FCPP1004\EEC.dwg\Sheets\Phase II\STA - 115+00.00 to 130+00.00.dwg



No:		Revisions:	Date:	 EARTH ENVIRONMENTAL CONSULTANTS, INC. 235 Claiborne Ave., Phone: (540) 483-5975 Rocky Mount, VA 24151 Fax: (540) 483-2221 www.earthenv.com	 MARTY EUGENE PRILLAMAN Lic. No. 043205 PROFESSIONAL ENGINEER	 WATER AUTHORITY  Franklin County Established 1784	DESIGN BY:	PROJECT:	DATE:
1	FRANKLIN COUNTY COMMENTS		02/27/09				BKS/MEP	ROANOKE/FRANKLIN COUNTY WATERLINE EXTENSION PHASE II	01/14/09
				DRAWN BY:	U.S. ROUTE 220	DRAWING NUMBER:			
				BKS	FRANKLIN COUNTY, VA	C8			
				REVIEWED BY:	Plan and Profile	SHEET NUMBER:			
				MEP	STA - 115+00.00 to 130+00.00	10 of 28			
				PROJECT NUMBER:	DRAWING NAME:				
				FCPP1004	STA - 115+00.00 to 130+00.00.dwg				
					SCALE:				
					H: 1" = 50'				
					V: 1" = 10'				