
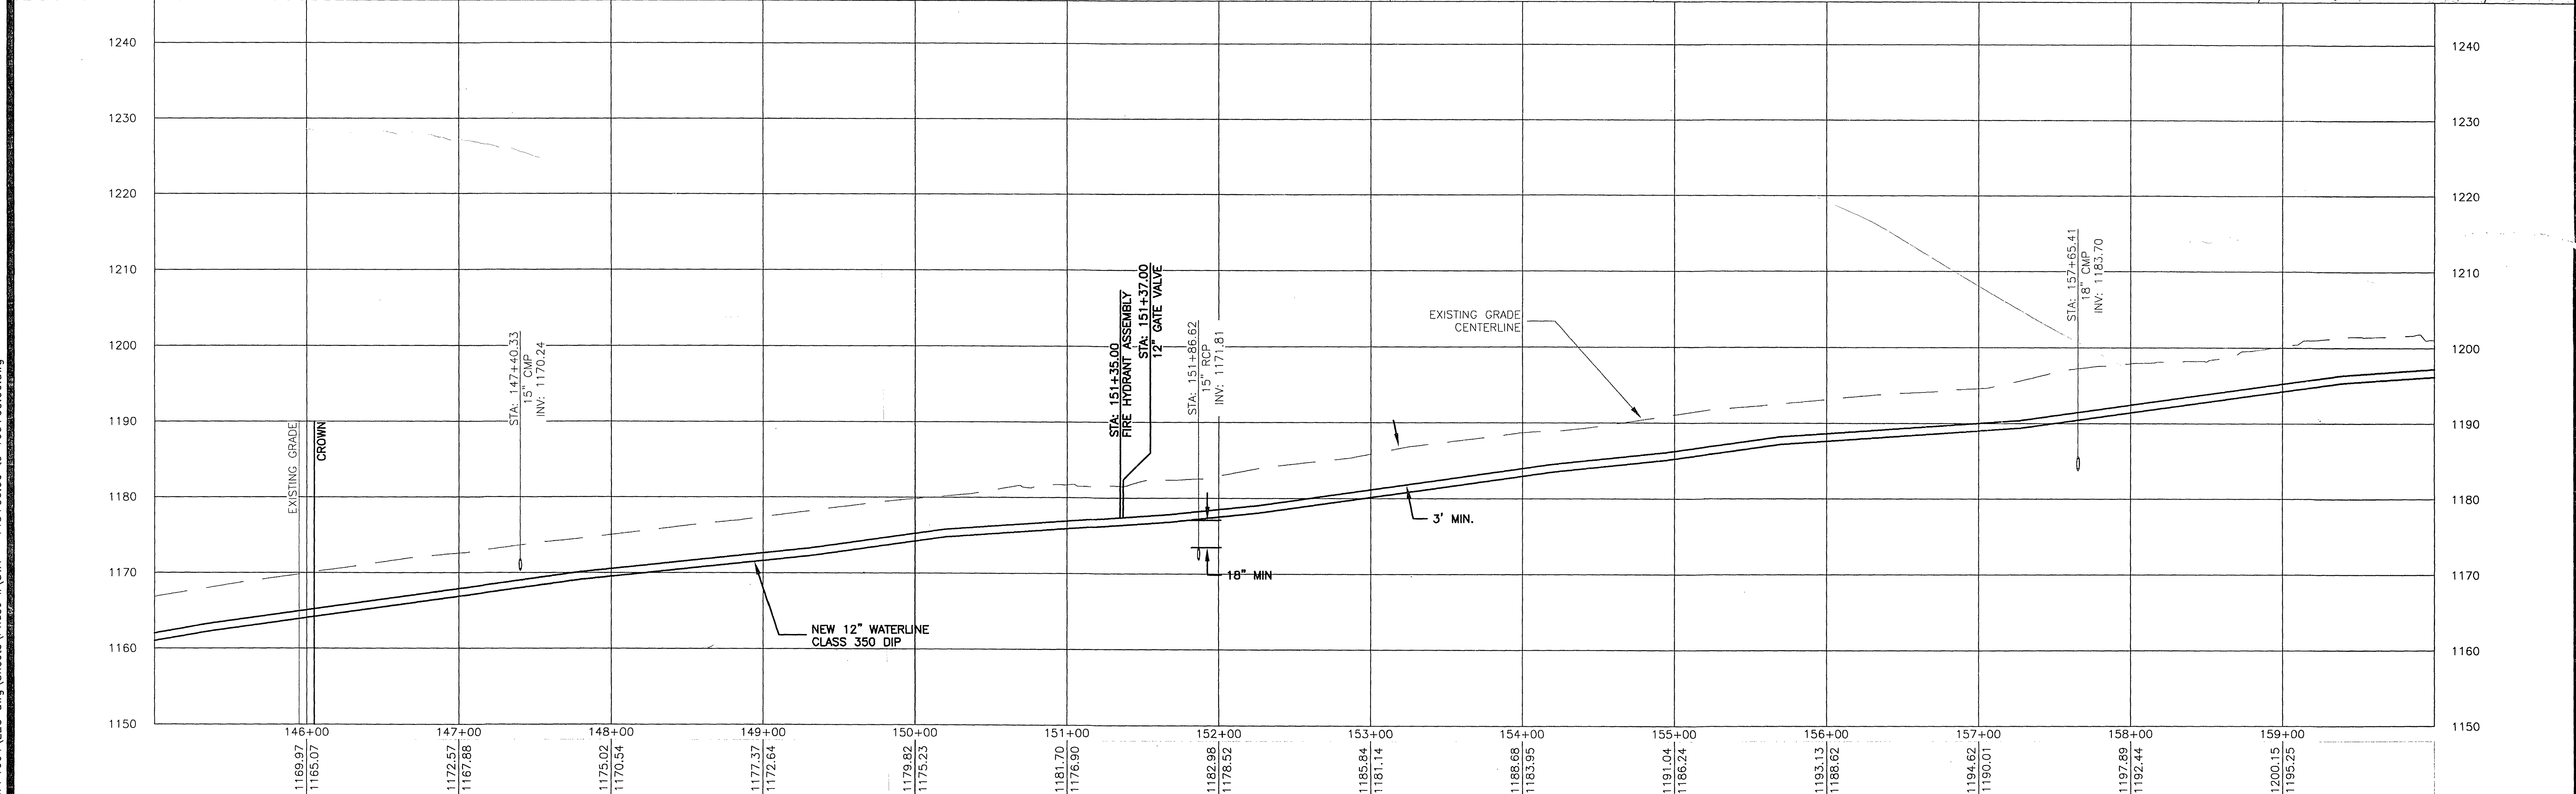


P:\VC - Plateau Plaza\FCPP1004\EEC.dwg Sheets\Phase II\STA - 145+00.00 to 160+00.00.dwg

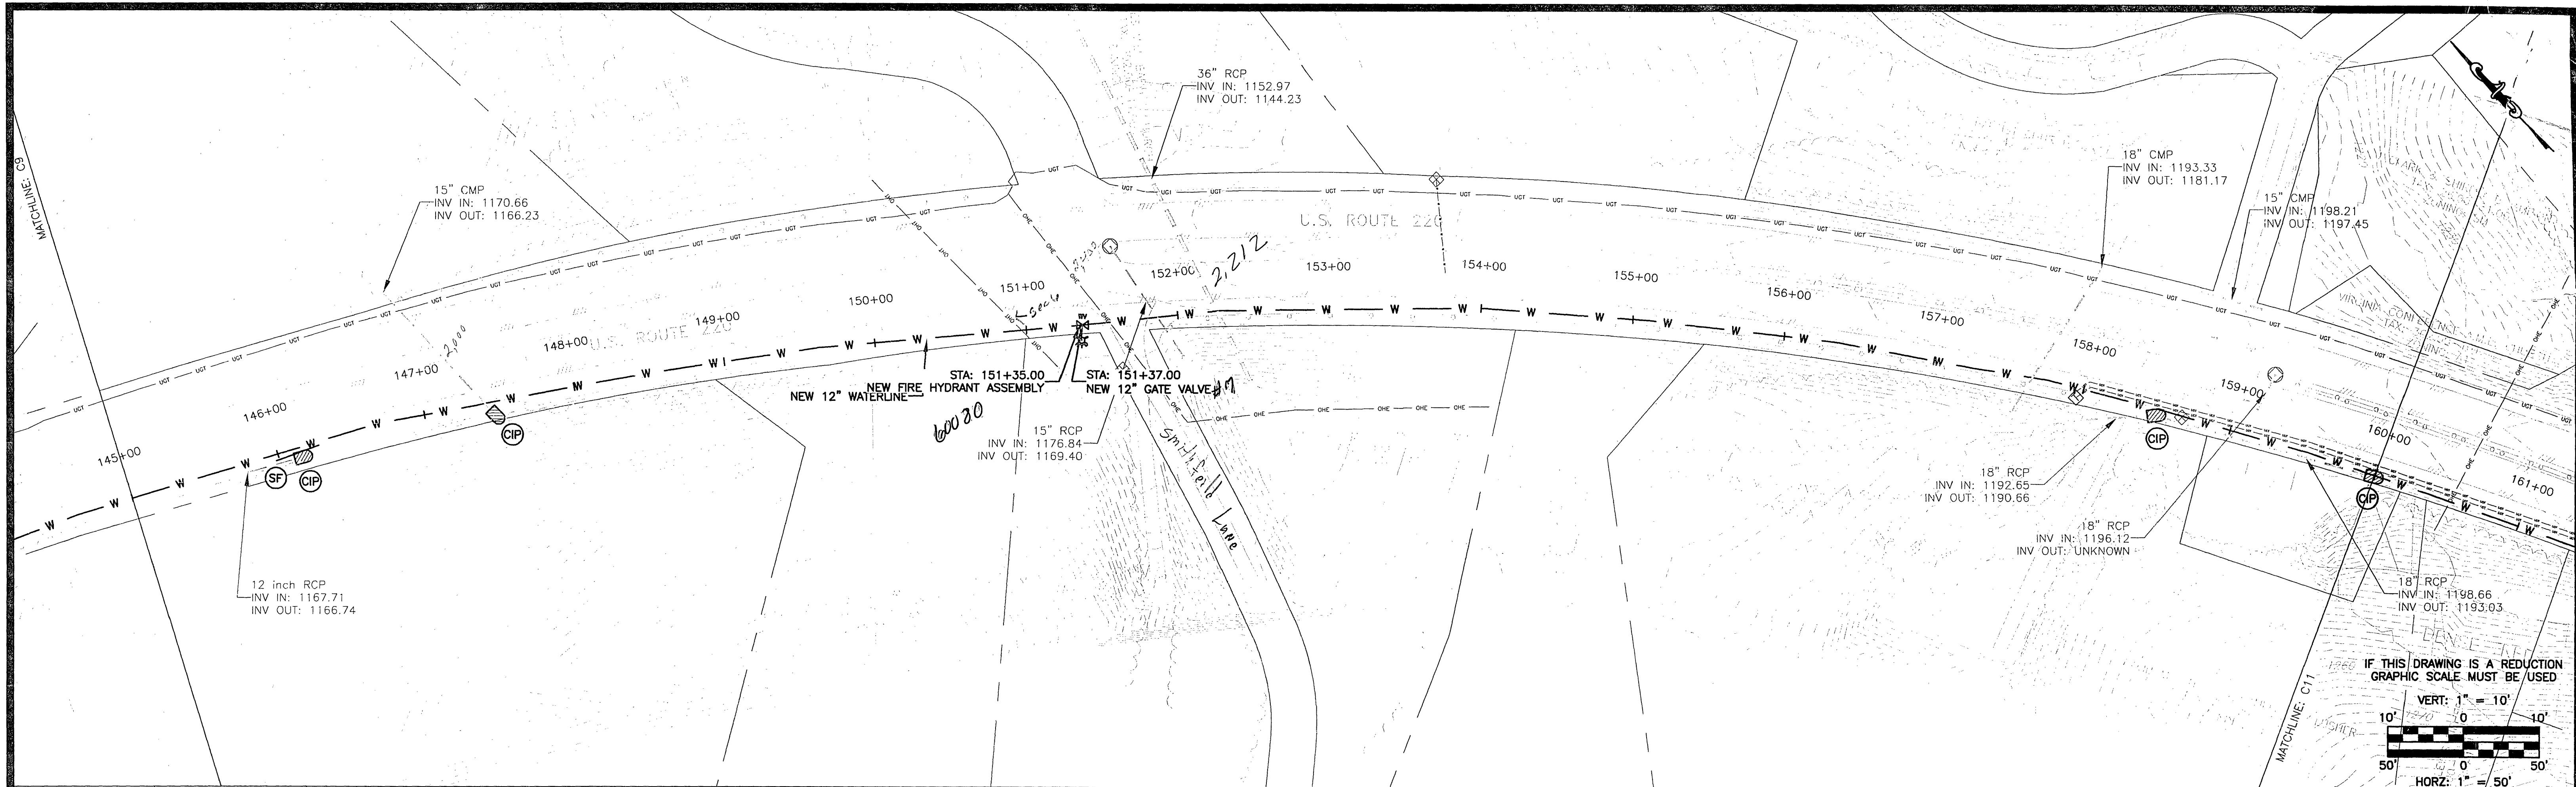

No:		Revisions:		Date:		DESIGN BY:		PROJECT:		DATE:	
1		FRANKLIN COUNTY COMMENTS		02/27/09		BKS/MEP		ROANOKE/FRANKLIN COUNTY WATERLINE EXTENSION PHASE II		01/14/09	
						DRAWN BY:		U.S. ROUTE 220		DRAWING NUMBER:	
						BKS		FRANKLIN COUNTY, VA		C10	
						REVIEWED BY:		Plan and Profile		SHEET NUMBER:	
						MEP		STA - 145+00.00 to 160+00.00		12 of 28	
						PROJECT NUMBER:		DRAWING NAME:		SCALE:	
						FCPP1004		STA - 145+00.00 to 160+00.00.dwg		H: 1" = 50'	
										V: 1" = 10'	

EARTH ENVIRONMENTAL CONSULTANTS, INC.
235 Claiborne Ave.,
Rocky Mount, VA 24151
Phone: (540) 483-5975
Fax: (540) 483-2221
www.earthenv.com

COMMONWEALTH OF VIRGINIA
MARTY EUGENE PRILLAMAN
Lic. No. 043205
2/27/09
PROFESSIONAL ENGINEER

WATER AUTHORITY
Franklin County
COUNTY OF ROANOKE VIRGINIA

DESIGN BY: BKS/MEP
DRAWN BY: BKS
REVIEWED BY: MEP
PROJECT NUMBER: FCPP1004
PROJECT: ROANOKE/FRANKLIN COUNTY WATERLINE EXTENSION PHASE II
U.S. ROUTE 220
FRANKLIN COUNTY, VA
TITLE: Plan and Profile
STA - 145+00.00 to 160+00.00
DRAWING NAME: STA - 145+00.00 to 160+00.00.dwg
SCALE: H: 1" = 50'
V: 1" = 10'