
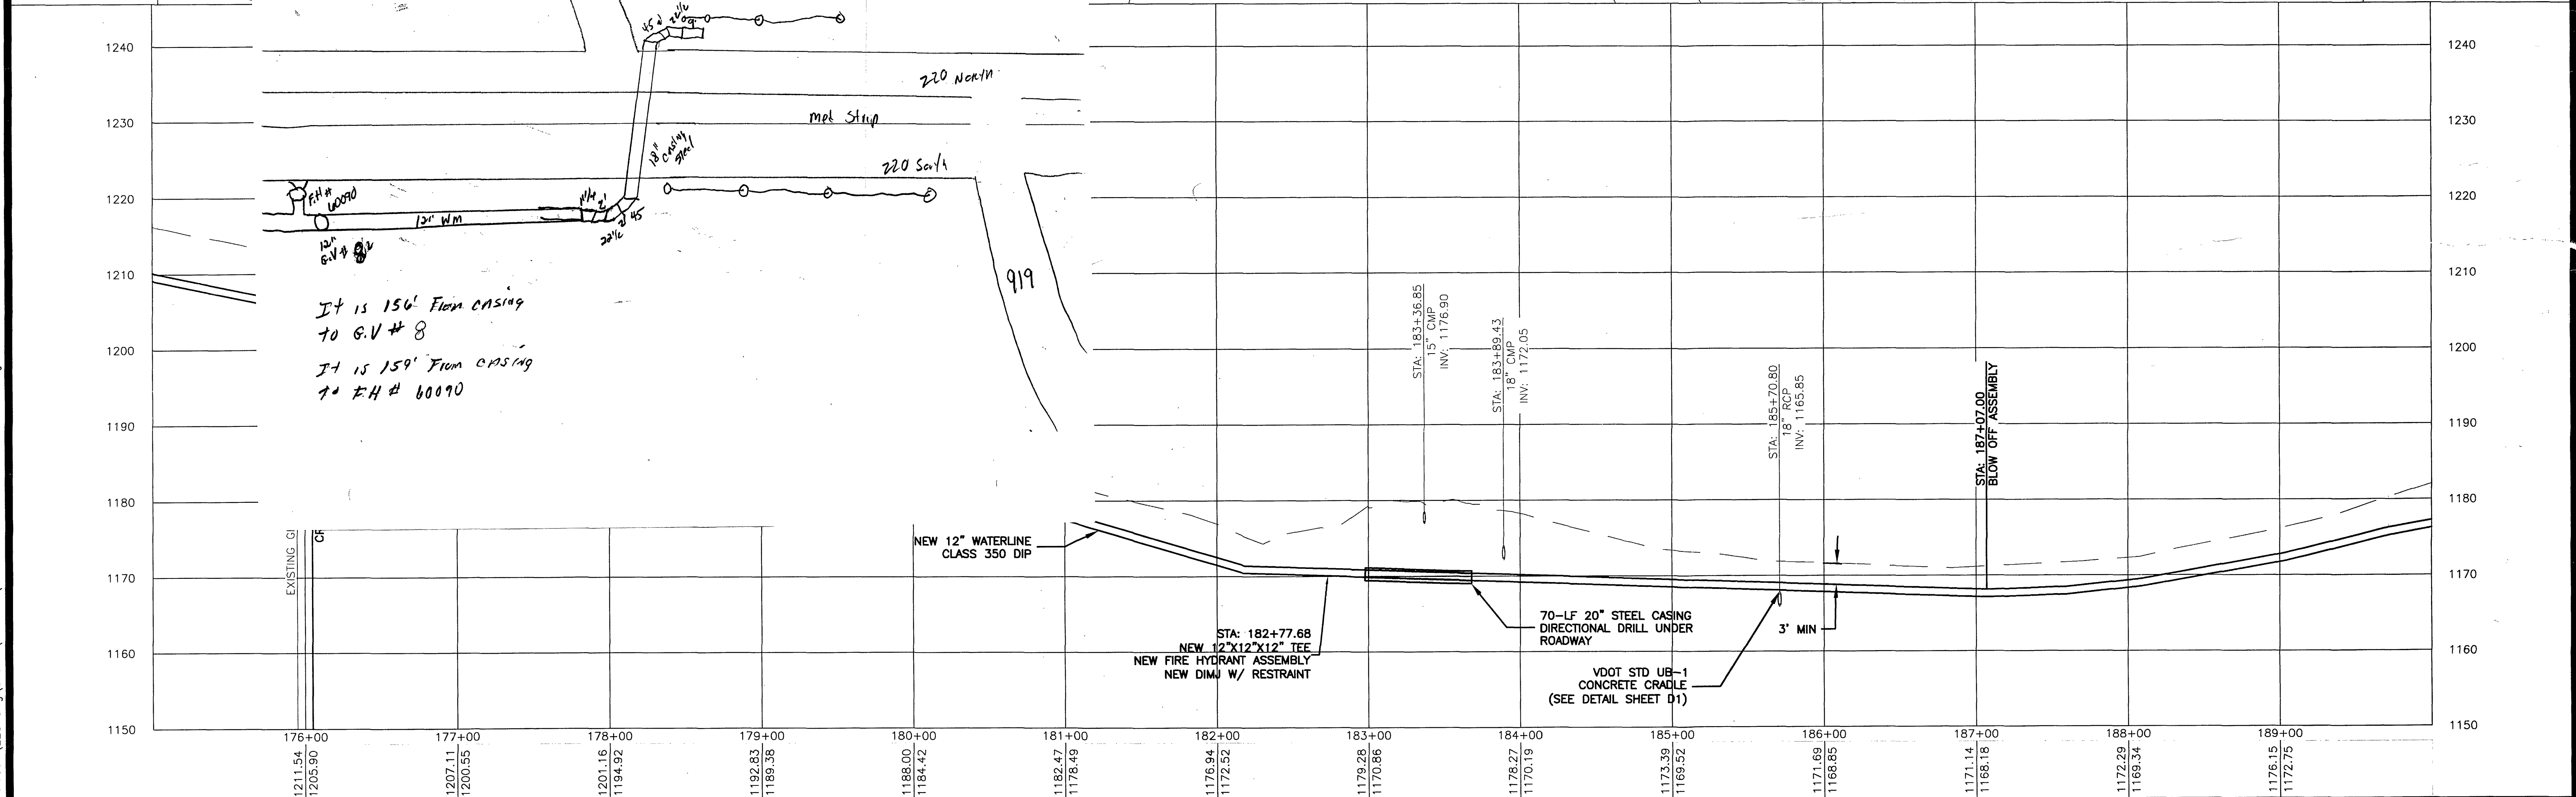
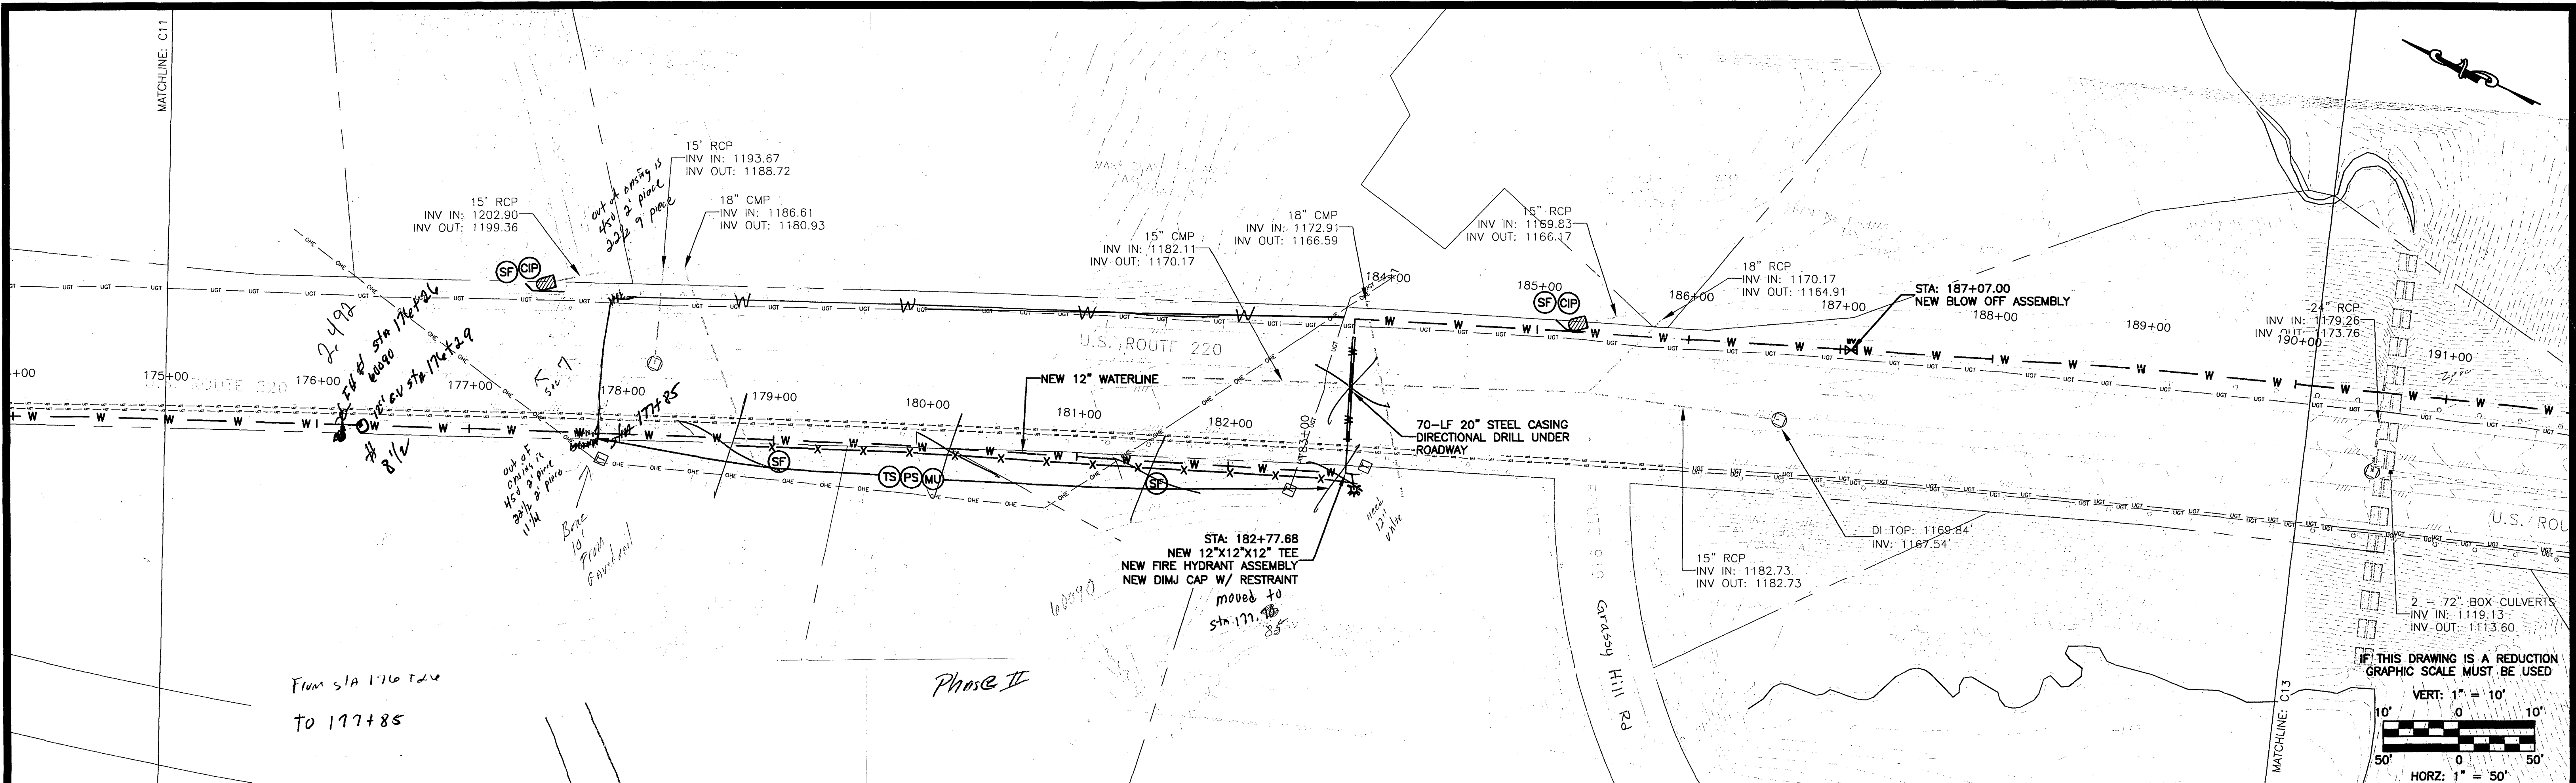


P:\FC - Plateau Plaza\FCPP100A\EEC.dwg\Sheets\Phase II\STA - 175+00.00 to 190+00.00.dwg

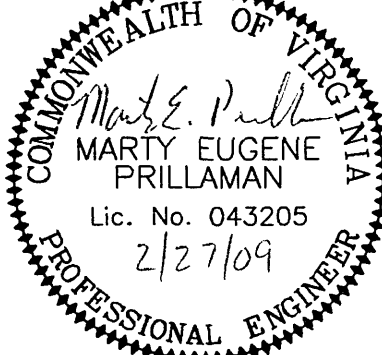

No:	Revisions:	Date:	 EARTH ENVIRONMENTAL CONSULTANTS, INC. 235 Claiborne Ave., Rocky Mount, VA 24151 www.earthenv.com Phone: (540) 483-5975 Fax: (540) 483-2221		 MARTY EUGENE PRILLAMAN Lic. No. 043205 2/27/09 PROFESSIONAL ENGINEER		 WATER AUTHORITY  Franklin County A Division of the Virginia Department of Transportation		DESIGN BY: BKS/MEP	PROJECT: ROANOKE/FRANKLIN COUNTY WATERLINE EXTENSION PHASE II U.S. ROUTE 220 FRANKLIN COUNTY, VA	TITLE: Plan and Profile STA - 175+00.00 to 190+00.00	SHEET NUMBER: 14 of 28
1	FRANKLIN COUNTY COMMENTS	02/27/09							DRAWN BY: BKS			
									REVIEWED BY: MEP			
									PROJECT NUMBER: FCPP1004			
									DRAWING NAME: STA - 175+00.00 to 190+00.00.dwg			
									SCALE: H: 1" = 50' V: 1" = 10'			