



P:\FC - Plateau Plaza\FCPP1004\EEC.dwg Phase II\STA - 190+00.00 to 205+00.00.dwg

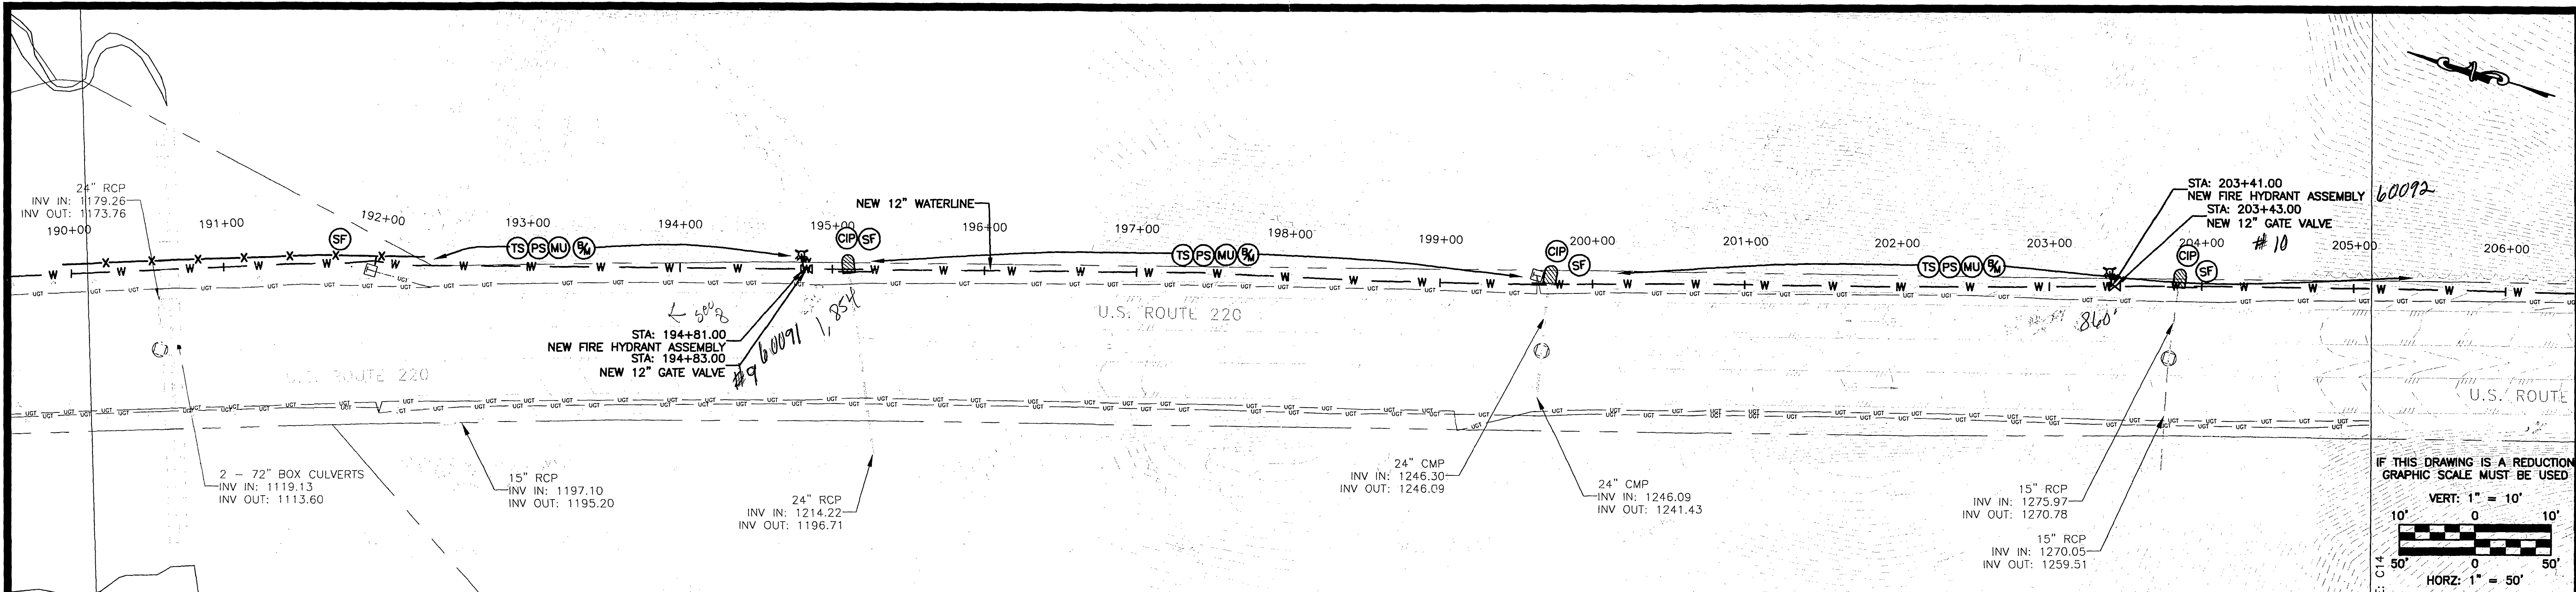


IF THIS DRAWING IS A REDUCTION
GRAPHIC SCALE MUST BE USED

VERT: 1" = 10'
HORIZ: 1" = 50'

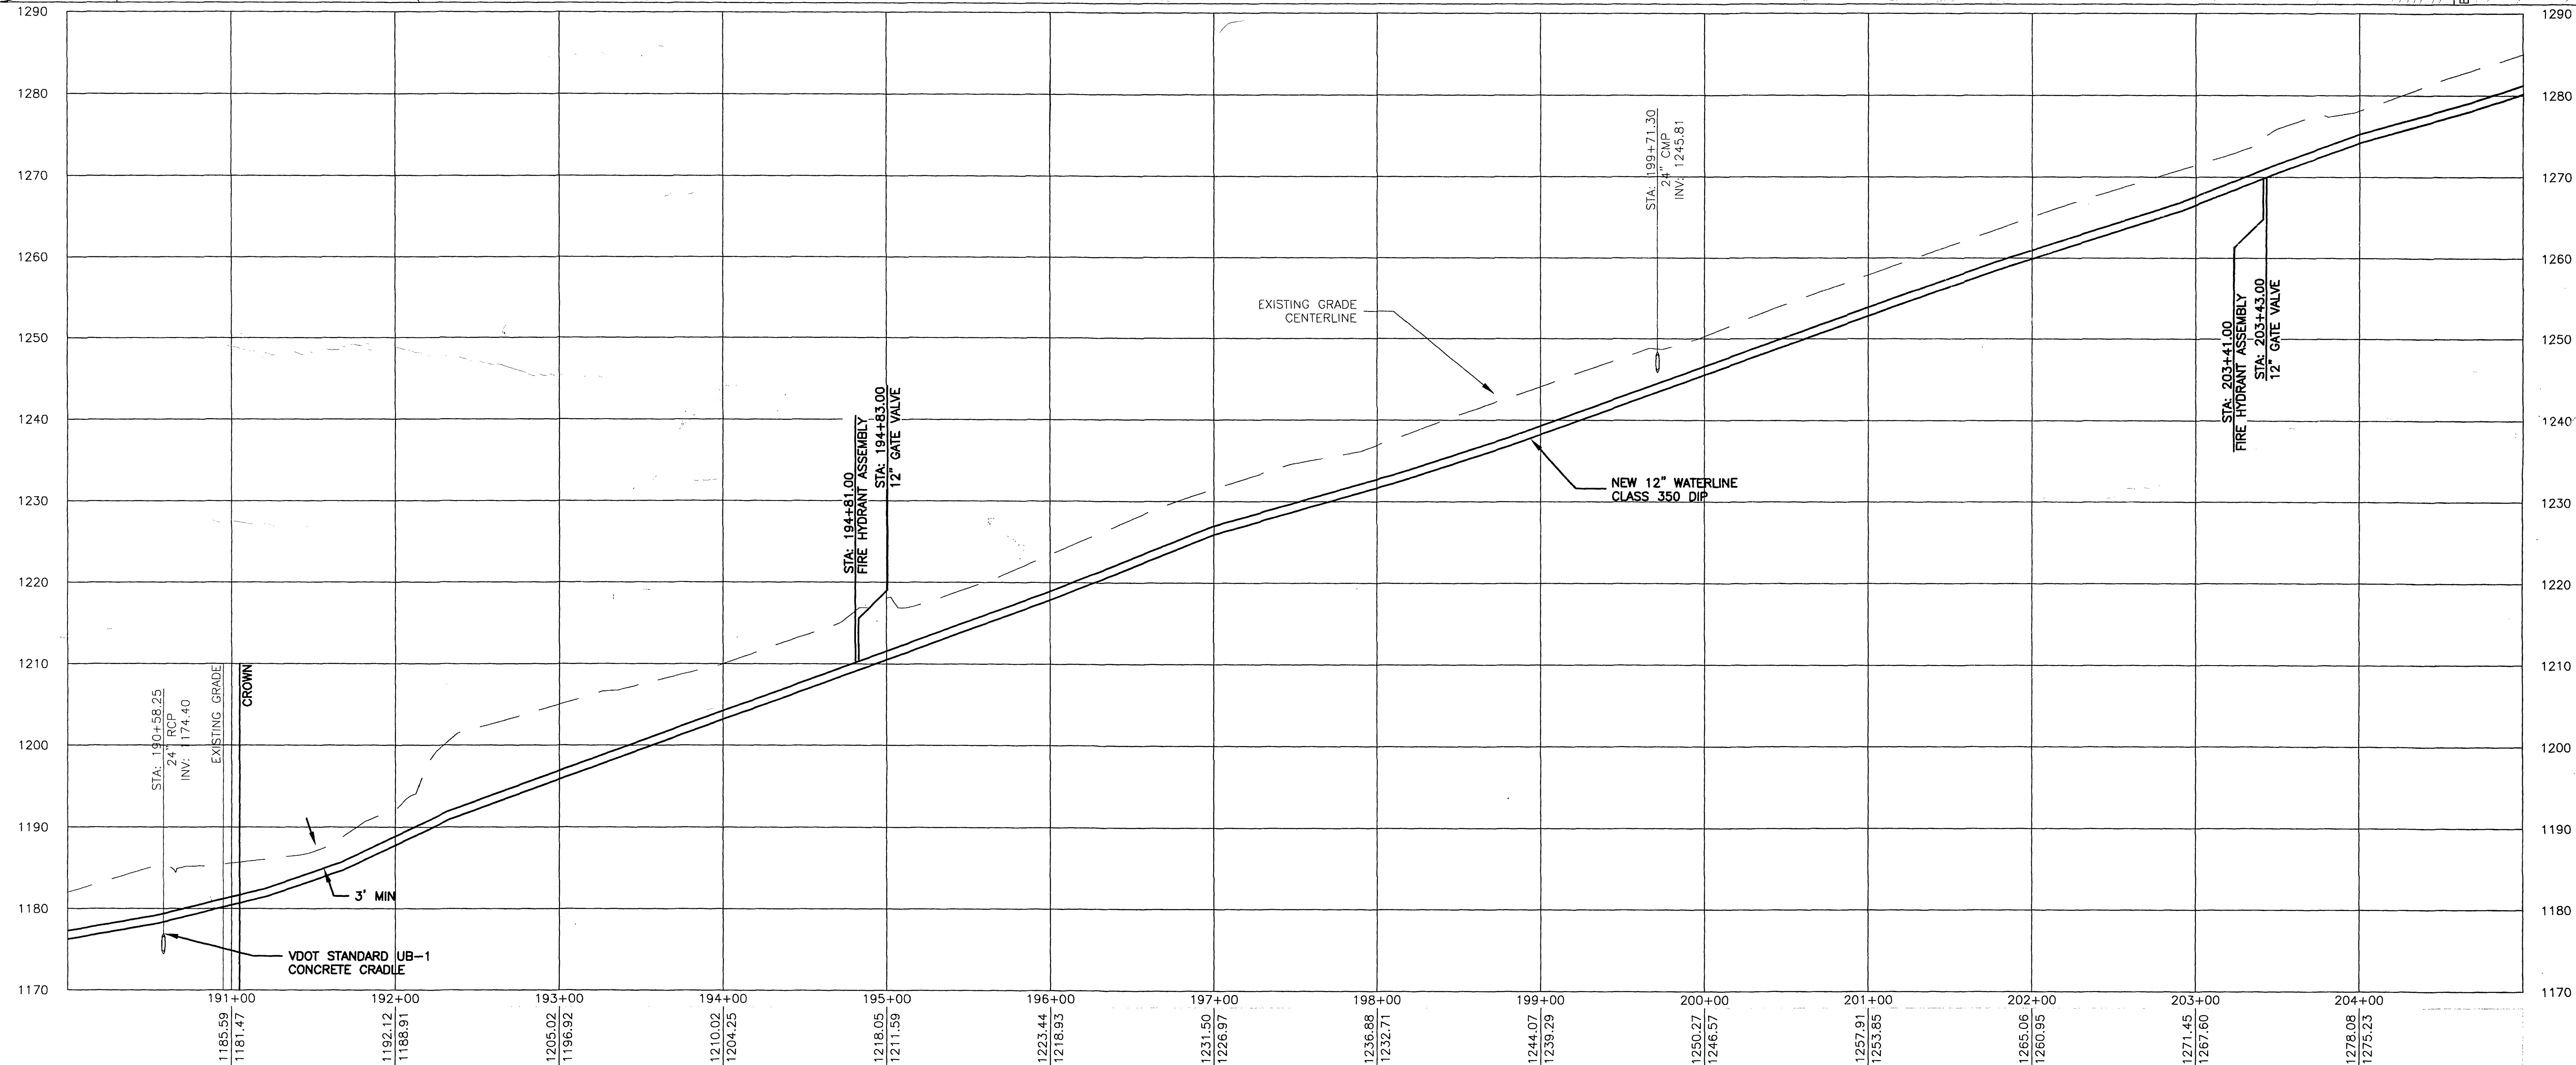


No.	Revisions:	Date:
1	FRANKLIN COUNTY COMMENTS	02/27/09

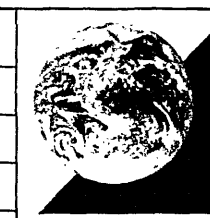

**EARTH
ENVIRONMENTAL
CONSULTANTS, INC.**

235 Claiborne Ave..
Rocky Mount, VA 24151
www.earthenv.com


Phone: (540) 483-5975
Fax: (540) 483-2221

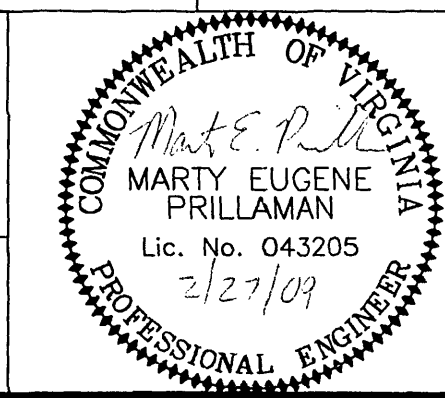

MARTY EUGENE
PRILLAMAN
Lic. No. 043205
2/27/09
PROFESSIONAL ENGINEER



WATER AUTHORITY

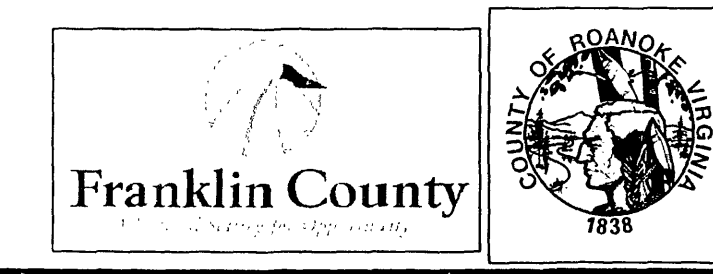

Franklin County

DESIGN BY: BKS/MEP	PROJECT: ROANOKE/FRANKLIN COUNTY WATERLINE EXTENSION PHASE II U.S. ROUTE 220 FRANKLIN COUNTY, VA	DATE: 01/14/09
DRAWN BY: BKS	TITLE: Plan and Profile STA - 190+00.00 to 205+00.00	DRAWING NUMBER: C13
REVIEWED BY: MEP	DRAWING NAME: STA - 190+00.00 to 205+00.00.dwg	SHEET NUMBER: 15 of 28
PROJECT NUMBER: FCPP1004	SCALE: H: 1" = 50' V: 1" = 10'	