
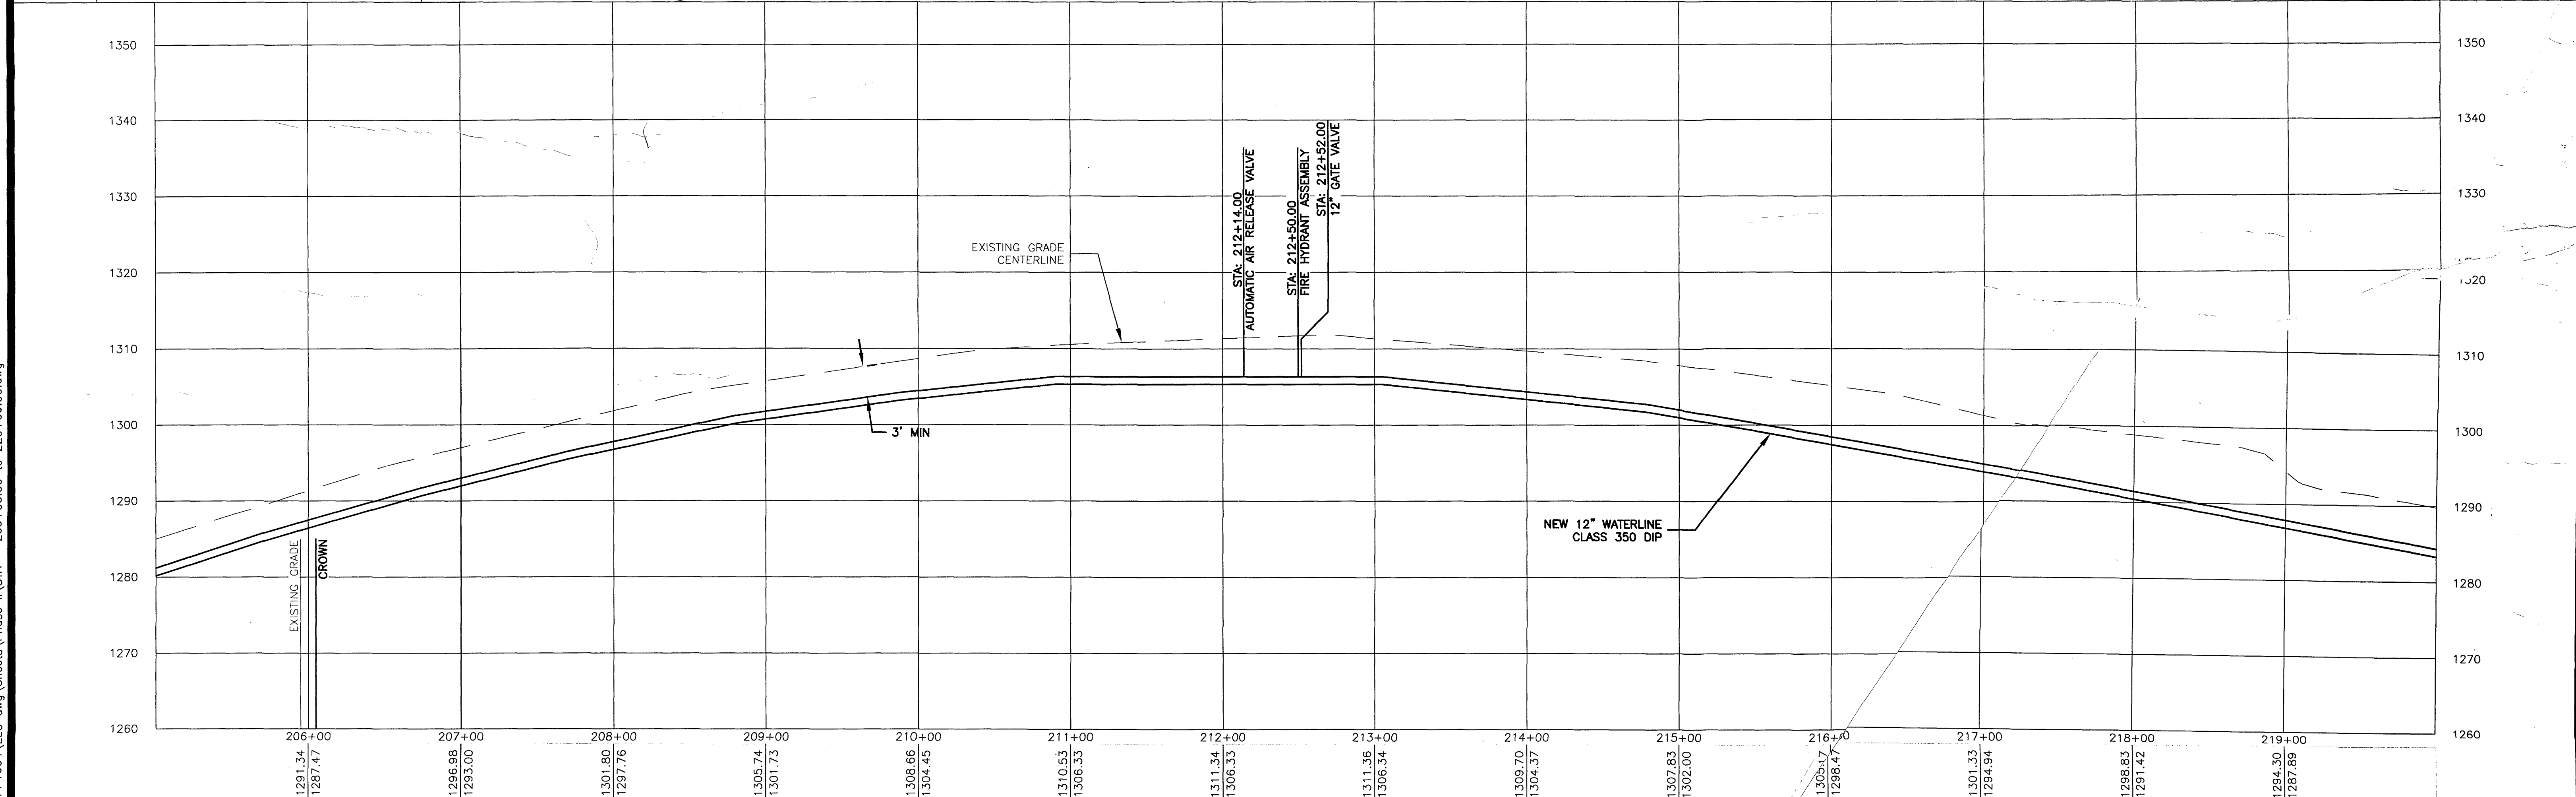
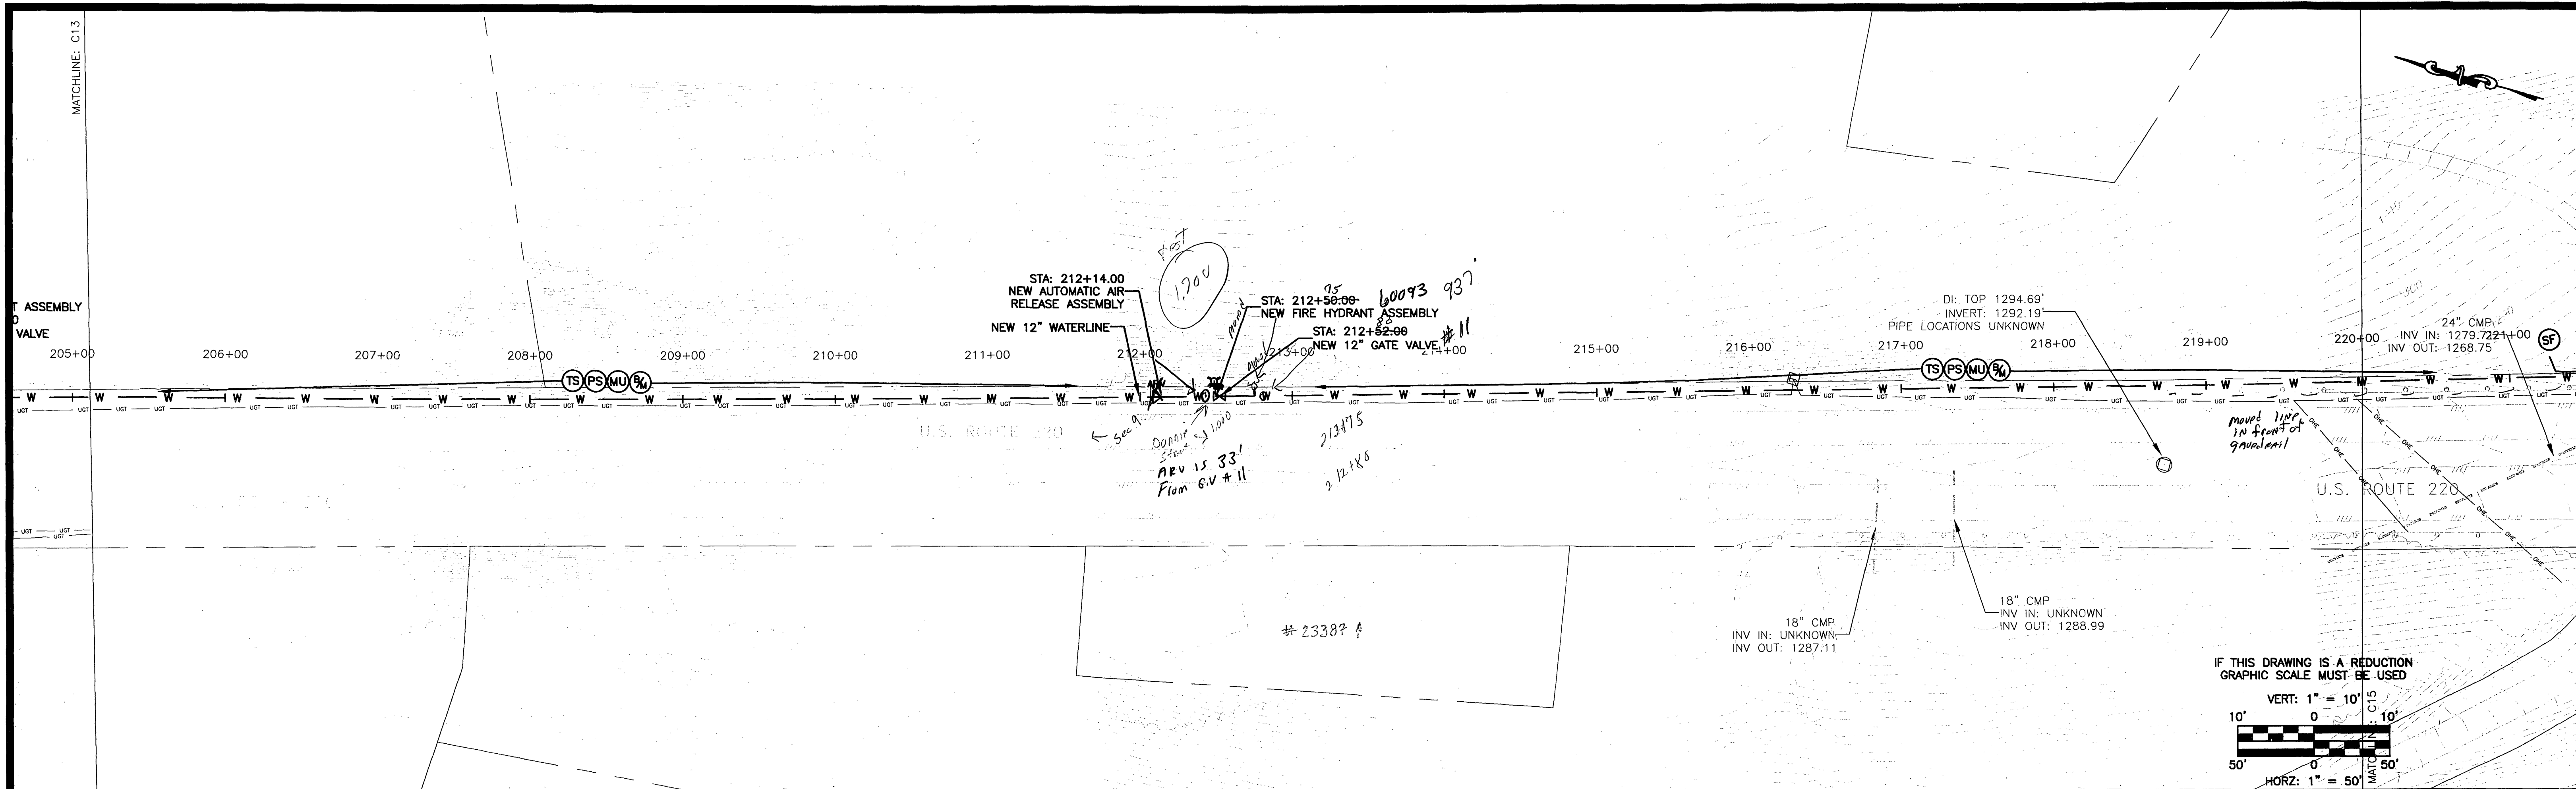
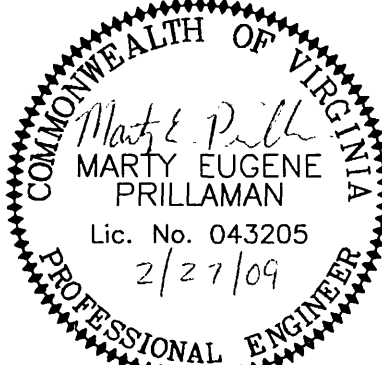


P:\VC - Plateau Plaza\FCPP1004\EEC.dwg\Sheets\Phase II\STA - 205+00.00 to 220+00.00.dwg

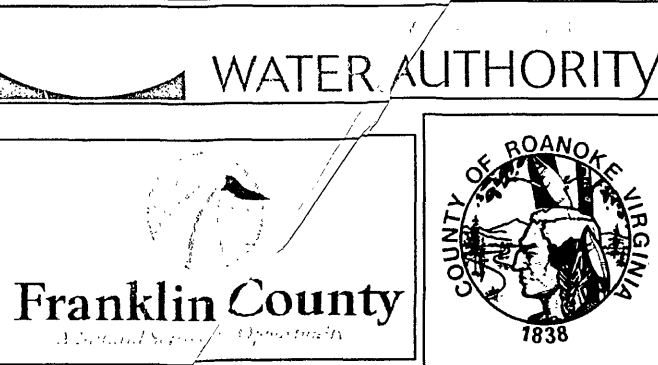

No.	Revisions:	Date:	 EARTH ENVIRONMENTAL CONSULTANTS, INC. 235 Claiborne Ave., Phone: (540) 483-5975 Rocky Mount, VA 24151 Fax: (540) 483-2221 www.earthenv.com		 COMMONWEALTH OF VIRGINIA Marty Eugene Prillaman Lic. No. 043205 2/27/09 PROFESSIONAL ENGINEER		 WATER AUTHORITY Franklin County COUNTY OF ROANOKE, VIRGINIA		DESIGN BY:	PROJECT:	DATE:
1	FRANKLIN COUNTY COMMENTS	02/27/09							BKS/MEP	ROANOKE/FRANKLIN COUNTY WATERLINE EXTENSION PHASE II	01/14/09
									DRAWN BY:	U.S. ROUTE 220 FRANKLIN COUNTY, VA	DRAWING NUMBER:
									BKS		C14
									REVIEWED BY:	Plan and Profile STA - 205+00.00 to 220+00.00	SHEET NUMBER:
									MEP		16 of 28
									PROJECT NUMBER:	DRAWING NAME:	SCALE:
									FCPP1004	STA - 205+00.00 to 220+00.00.dwg	H: 1" = 50' V: 1" = 10'