



P:\FC - Plateau Plaza\FOPFP1004\EEC.dwg\Sheets\Phase II\STA - 220+00.00 to 235+00.00.dwg

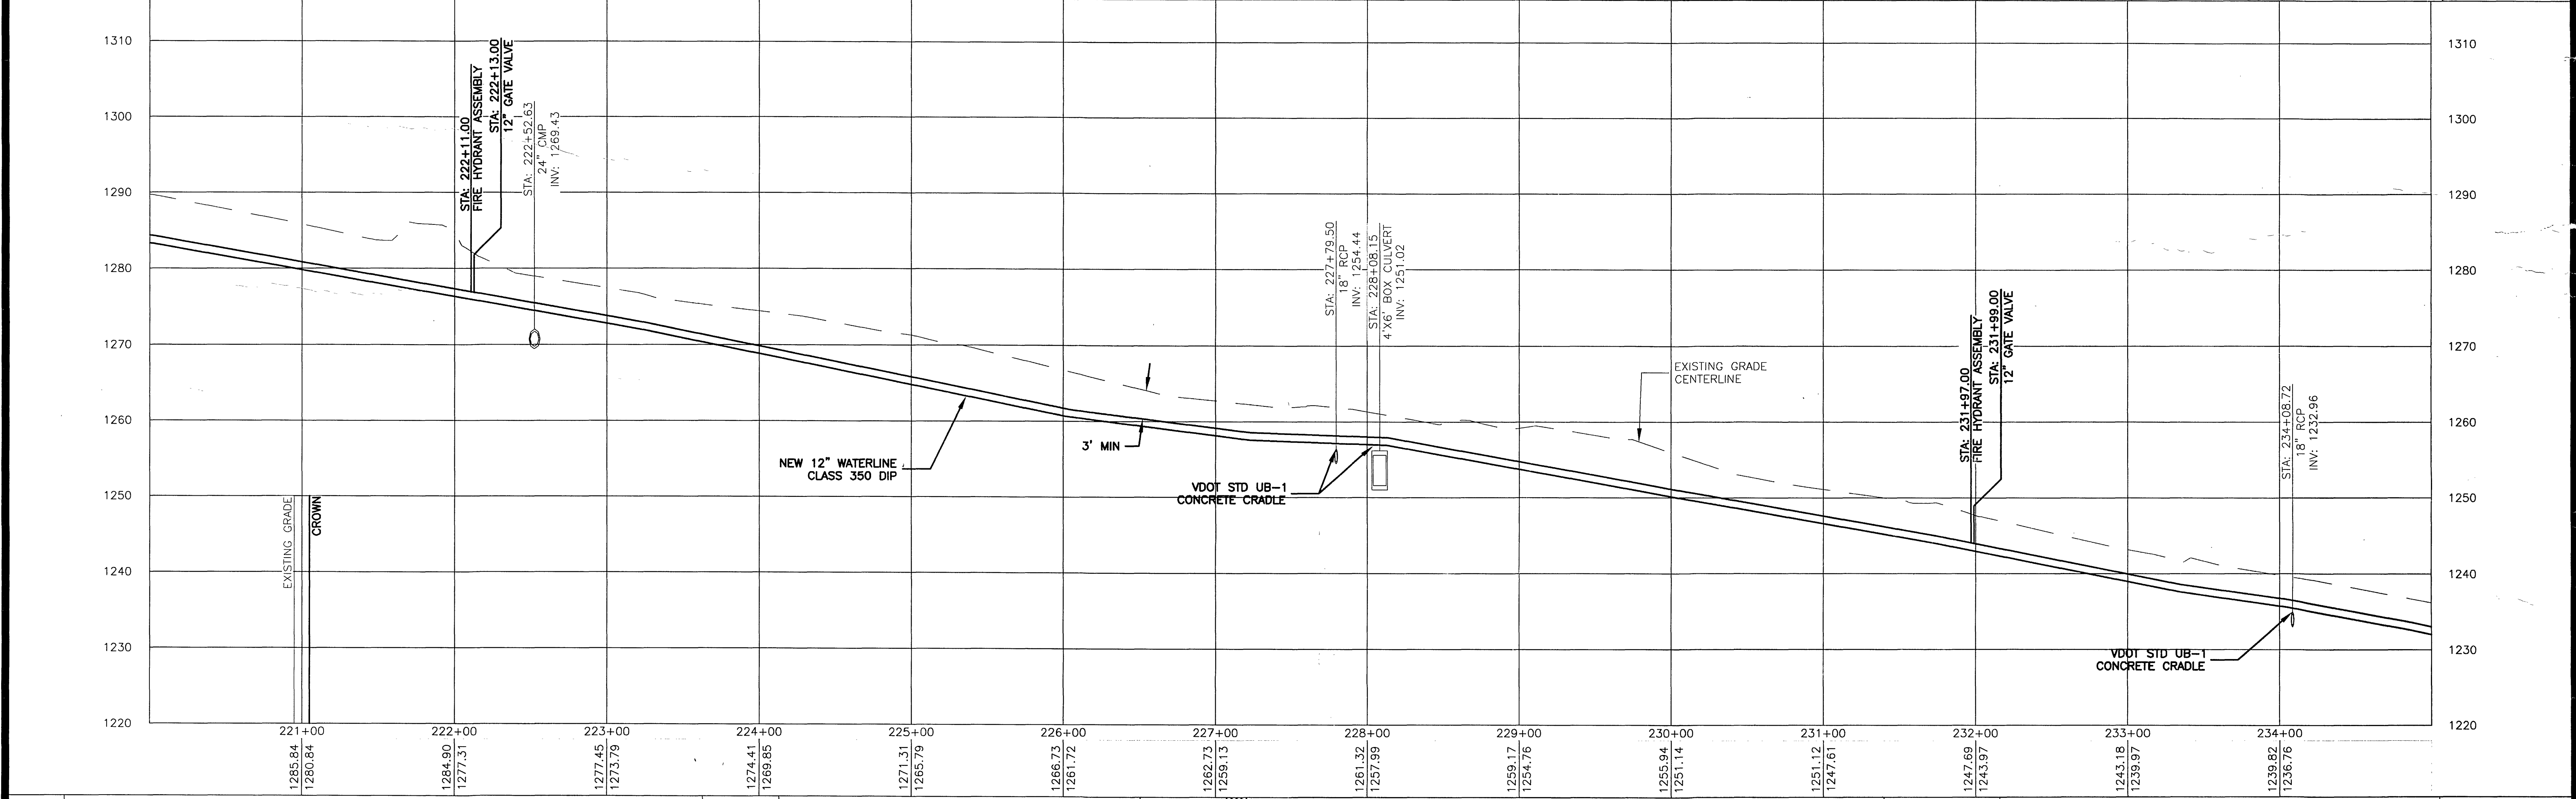


No.	Revisions:	Date:
1	FRANKLIN COUNTY COMMENTS	02/27/09

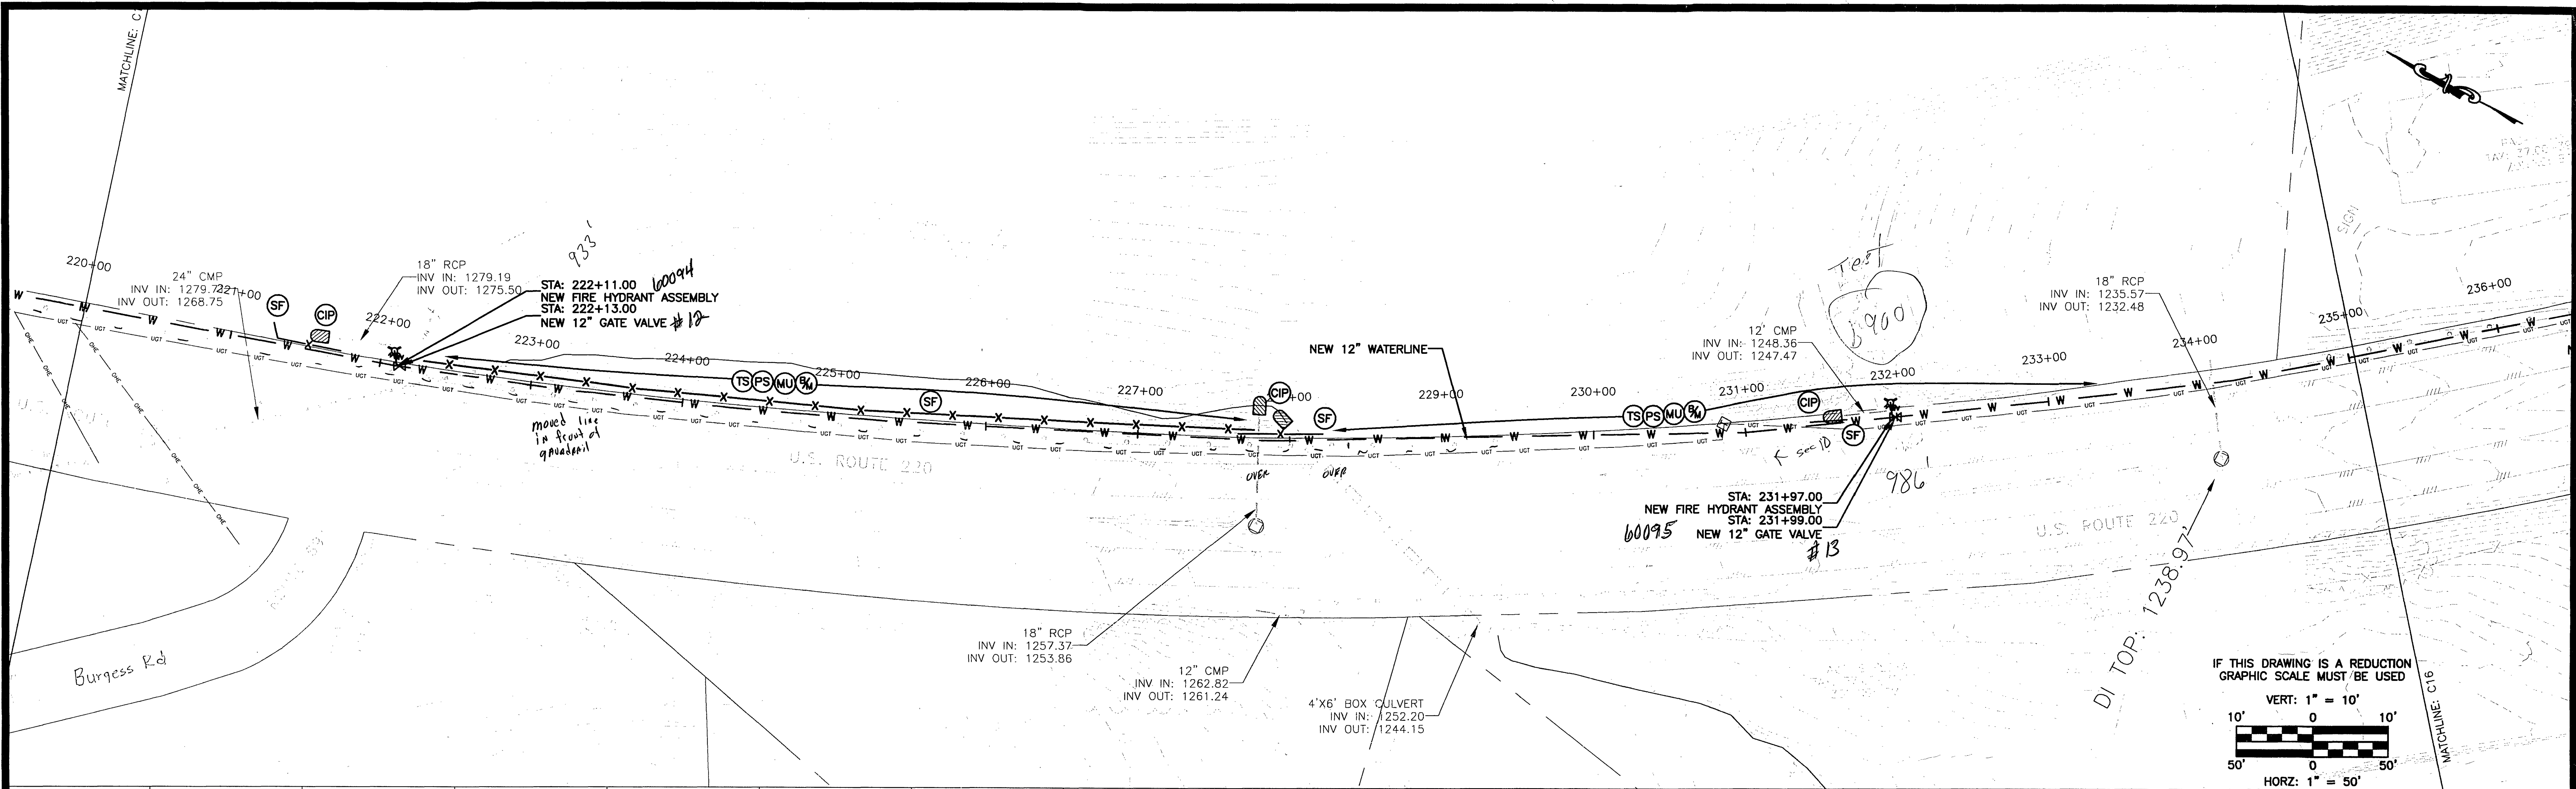

EARTH ENVIRONMENTAL CONSULTANTS, INC.

235 Claiborne Ave.,
Rocky Mount, VA 24151
www.earthenv.com

Phone: (540) 483-5975
Fax: (540) 483-2221

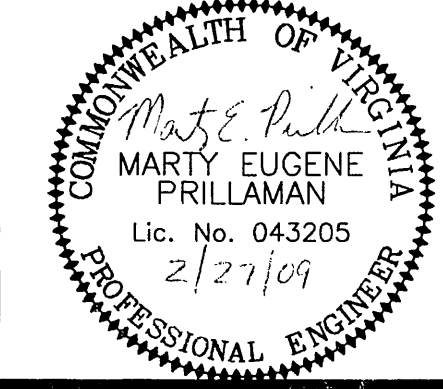

Marty Eugene Prillaman
Lic. No. 043205
2/27/09
PROFESSIONAL ENGINEER



WATER AUTHORITY

Franklin County

DESIGN BY: BKS/MEP	PROJECT: ROANOKE/FRANKLIN COUNTY WATERLINE EXTENSION PHASE II U.S. ROUTE 220 FRANKLIN COUNTY, VA	DATE: 01/14/09
DRAWN BY: BKS	TITLE: Plan and Profile STA - 220+00.00 to 235+00.00	DRAWING NUMBER: C15
REVIEWED BY: MEP	DRAWING NAME: STA - 220+00.00 to 235+00.00.dwg	SHEET NUMBER: 17 of 28
PROJECT NUMBER: FCPP1004	SCALE: H: 1" = 50' V: 1" = 10'	