

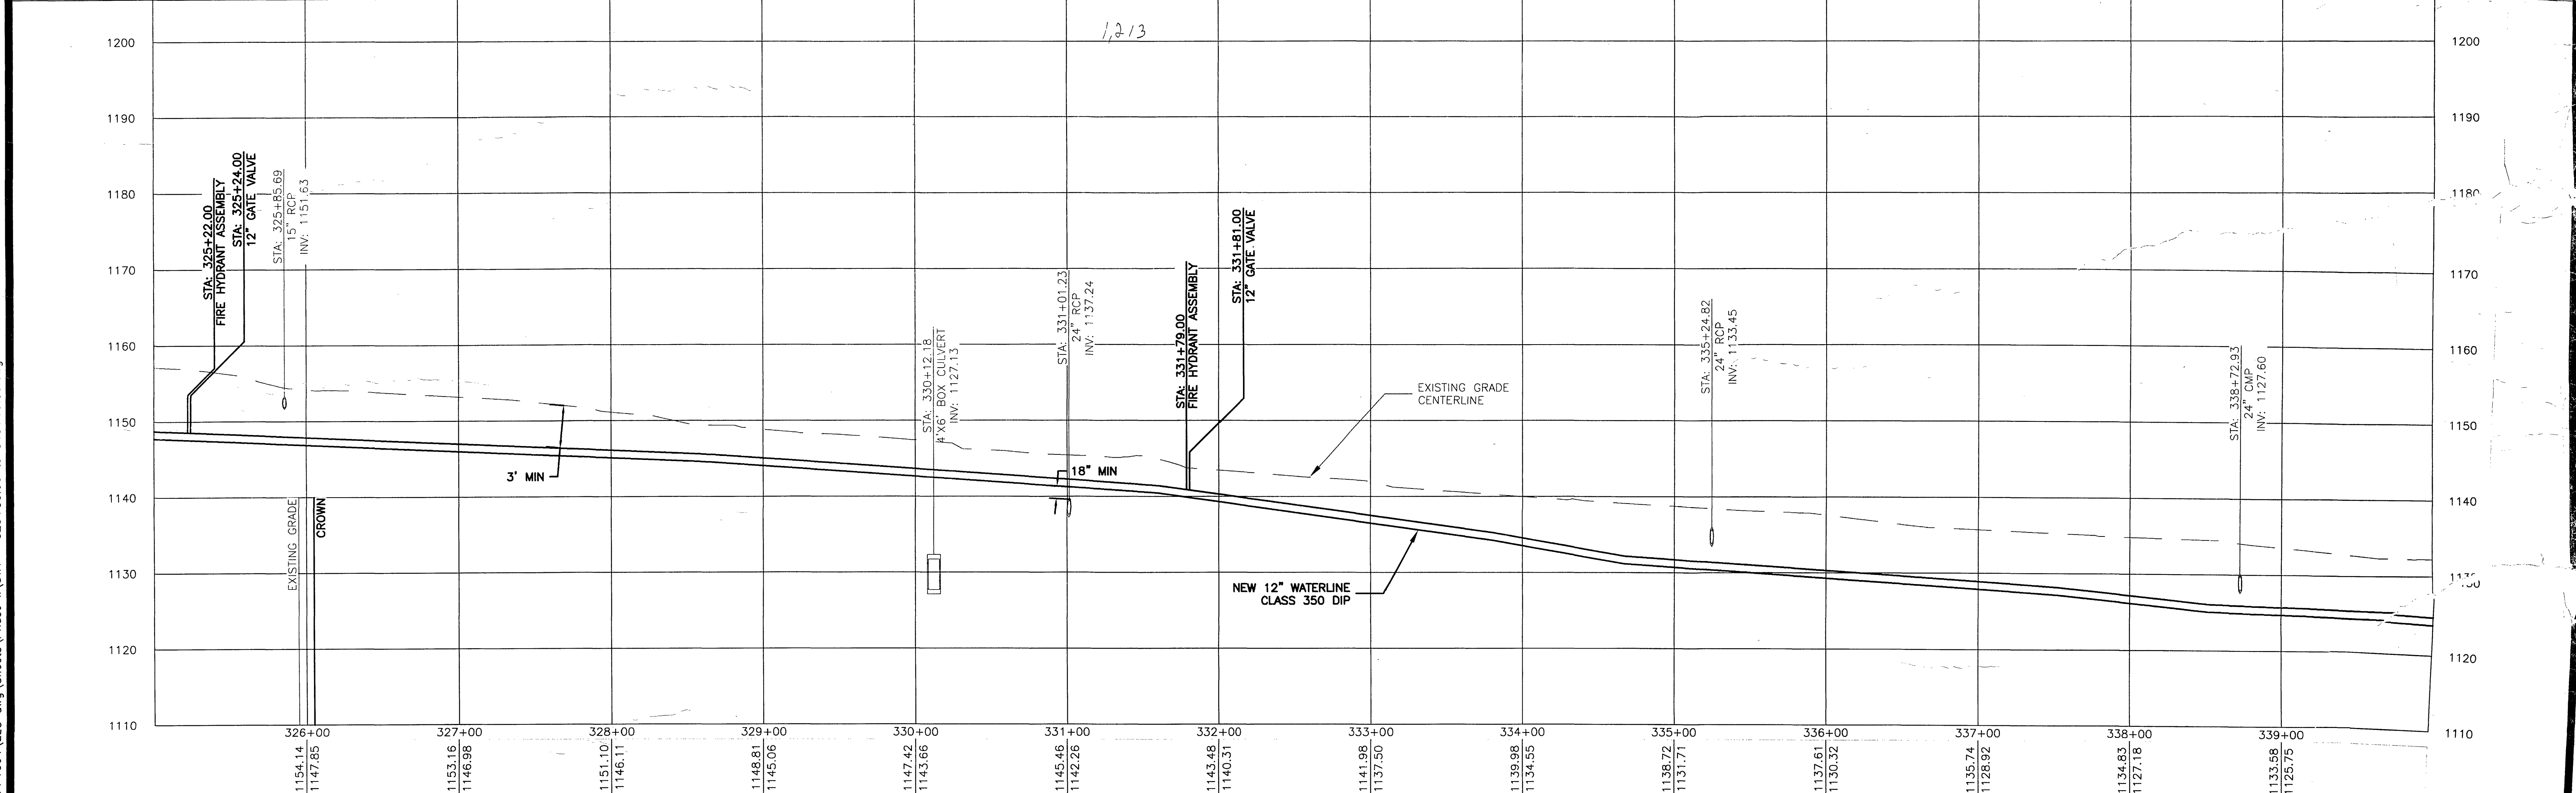


P:\FC - Plateau Plaza\FCPP1004\EEC dwg\Sheets\Phase I\STA - 325+00.00 to 340+00.00.dwg

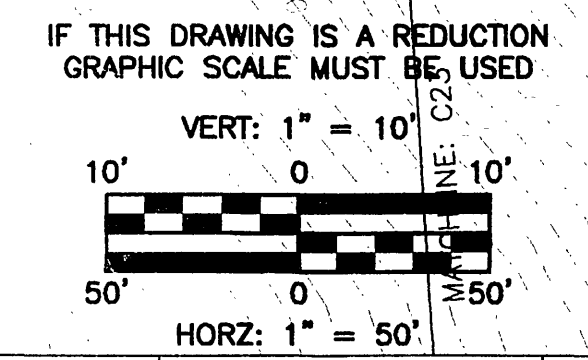


No:	Revisions:	Date:
1	FRANKLIN COUNTY COMMENTS	02/27/09

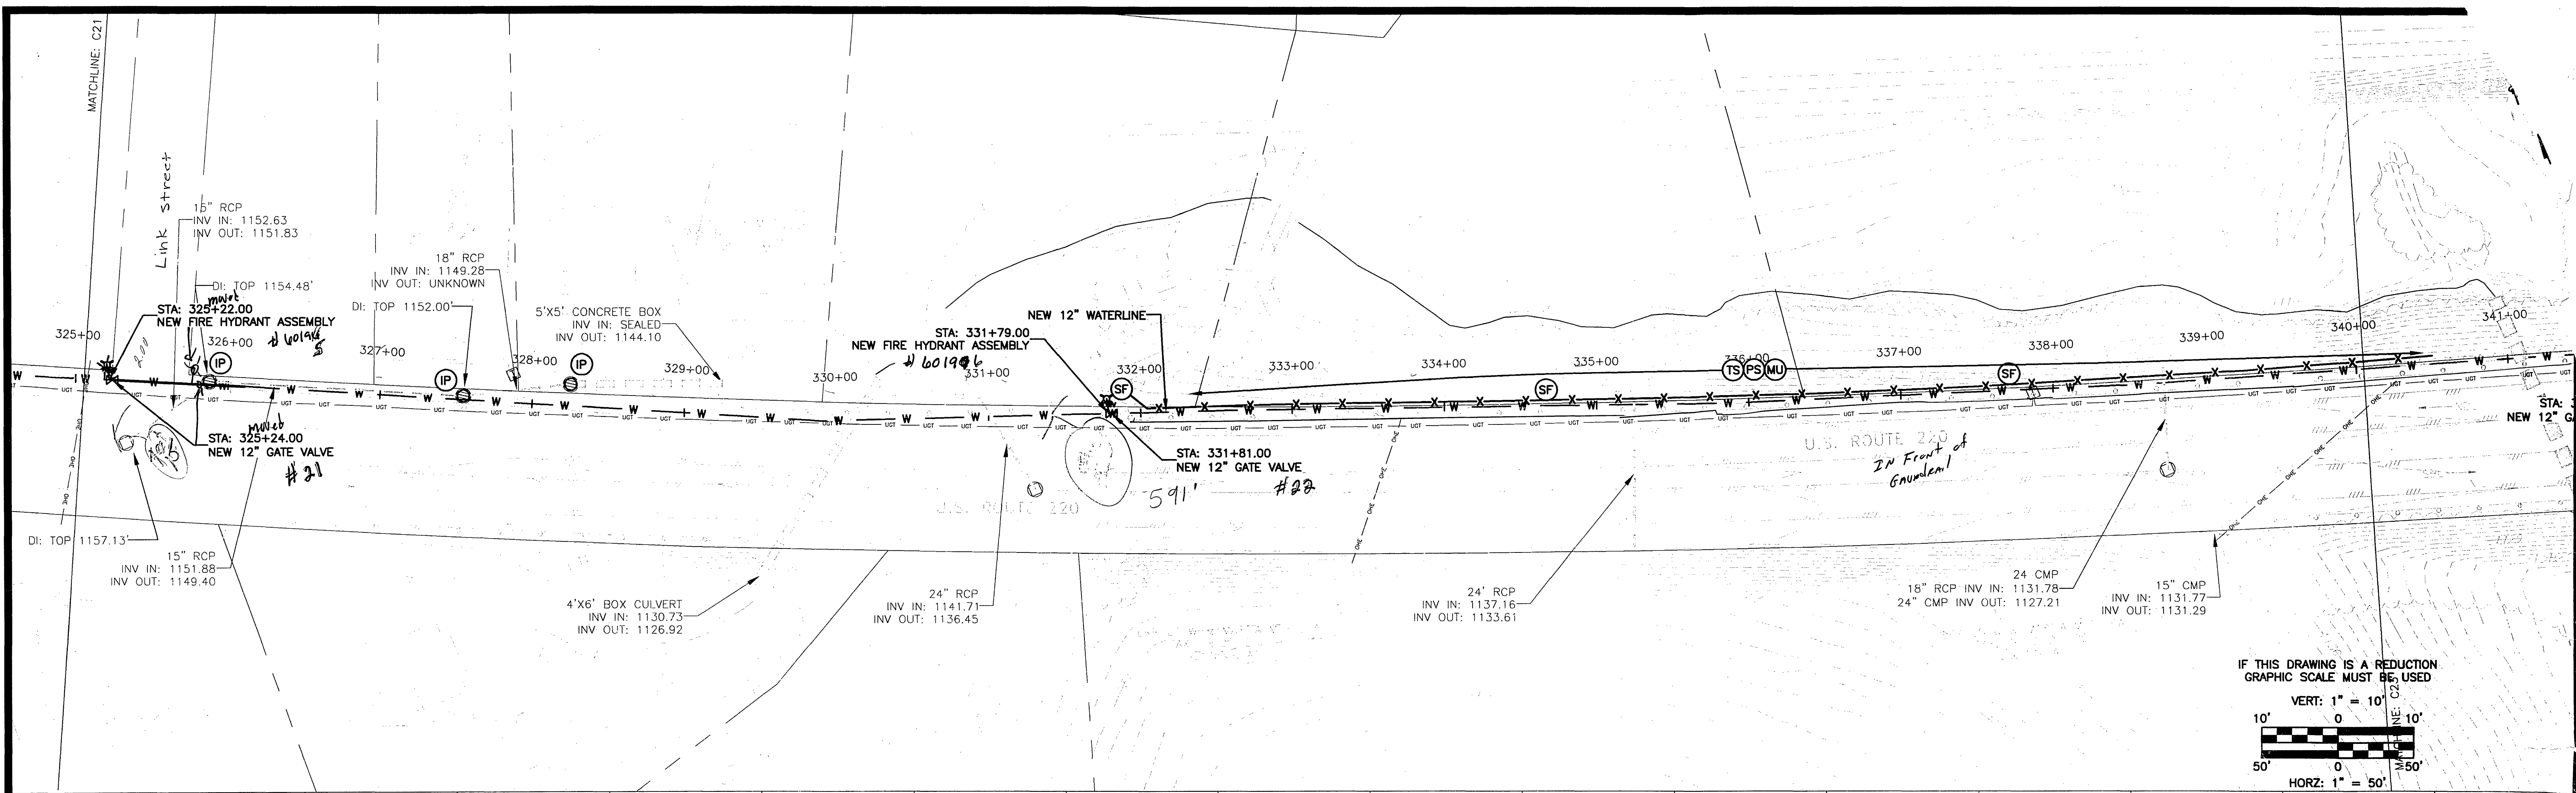


**EARTH
ENVIRONMENTAL
CONSULTANTS, INC.**


235 Claiborne Ave.,
Rocky Mount, VA 24151
www.eearthenv.com

 Phone: (540) 483-5975
Fax: (540) 483-2221

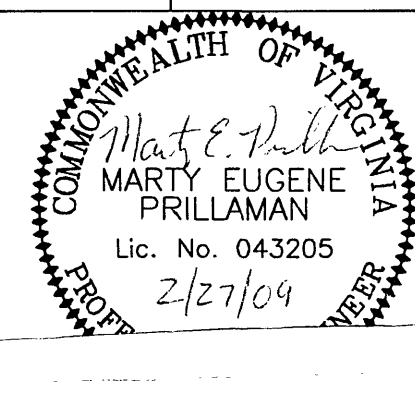



WATER AUTHORITY

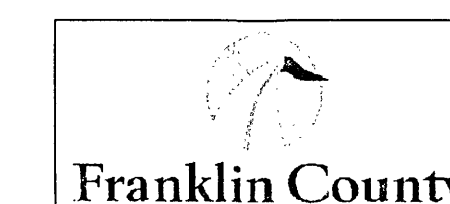

Franklin County

DESIGN BY: BKS/MEP	PROJECT: ROANOKE/FRANKLIN COUNTY WATERLINE EXTENSION PHASE II U.S. ROUTE 220 FRANKLIN COUNTY, VA	DATE: 01/14/09
DRAWN BY: BKS	TITLE: Plan and Profile STA - 325+00.00 to 340+00.00	DRAWING NUMBER: C22
REVIEWED BY: MEP	DRAWING NAME: STA - 325+00.00 to 340+00.00.dwg	SHEET NUMBER: 24 of 28
PROJECT NUMBER: FCPP1004	SCALE: H: 1" = 50' V: 1" = 10'	