
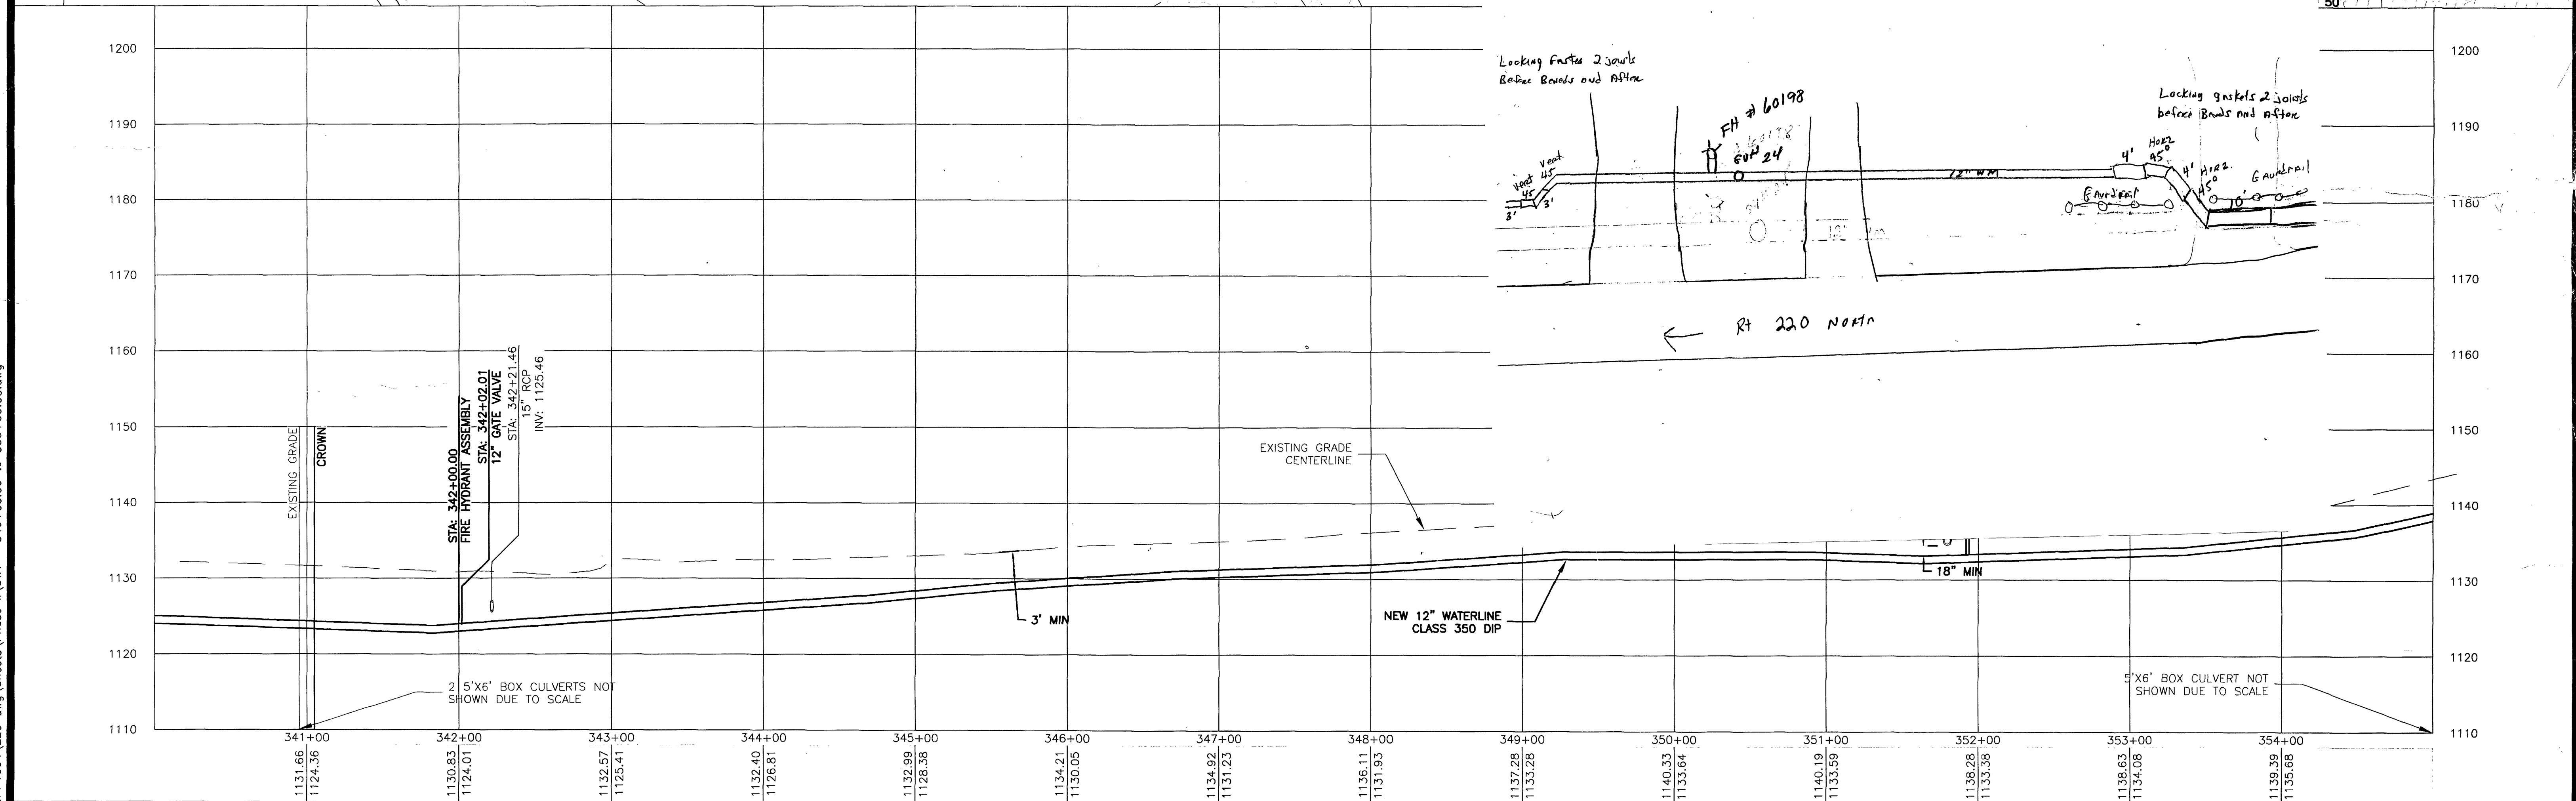



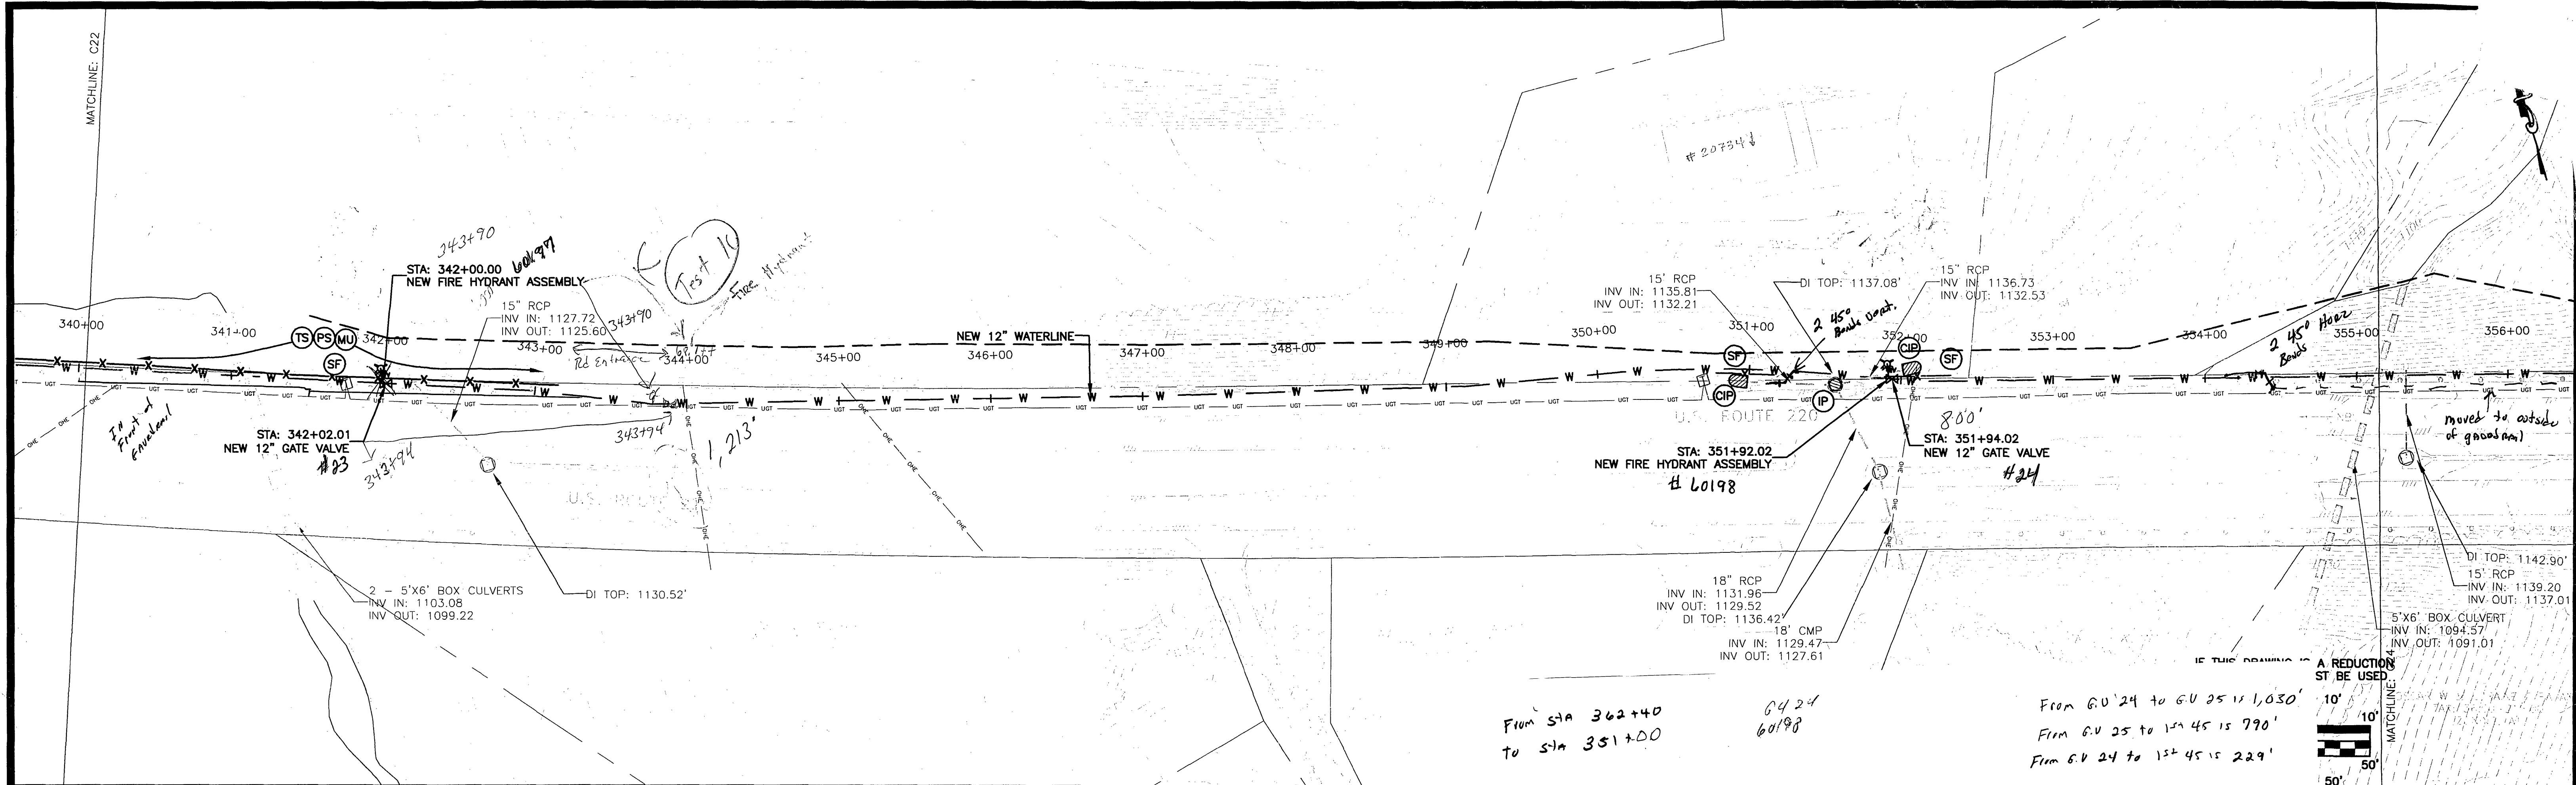


No.	Revisions:	Date:
1	FRANKLIN COUNTY COMMENTS	02/27/09

EARTH ENVIRONMENTAL CONSULTANTS, INC.

235 Claiborne Ave.,
Rocky Mount, VA 24151
www.earthenv.com

Phone: (540) 483-5975
Fax: (540) 483-2221

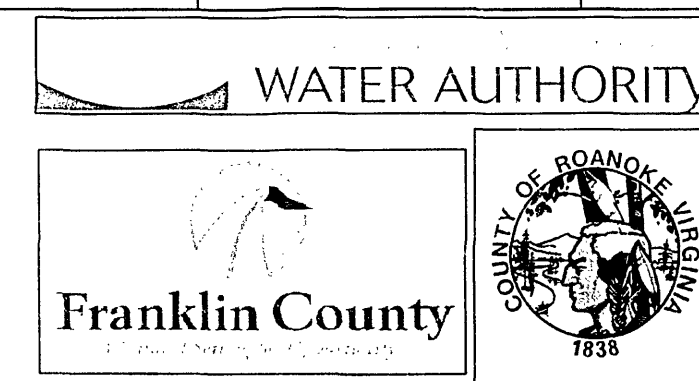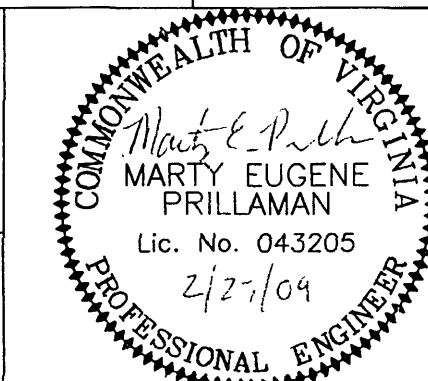

DESIGN BY: BKS/MEP	PROJECT: ROANOKE/FRANKLIN COUNTY WATERLINE EXTENSION PHASE II U.S. ROUTE 220 FRANKLIN COUNTY, VA	DATE: 01/14/09
DRAWN BY: BKS	TITLE: Plan and Profile STA - 340+00.00 to 355+00.00	DRAWING NUMBER: C23
REVIEWED BY: MEP	PROJECT NUMBER: FCPP1004	SHEET NUMBER: 25 of 28
DRAWING NAME: STA - 340+00.00 to 355+00.00.dwg	SCALE: H: 1" = 50' V: 1" = 10'	