
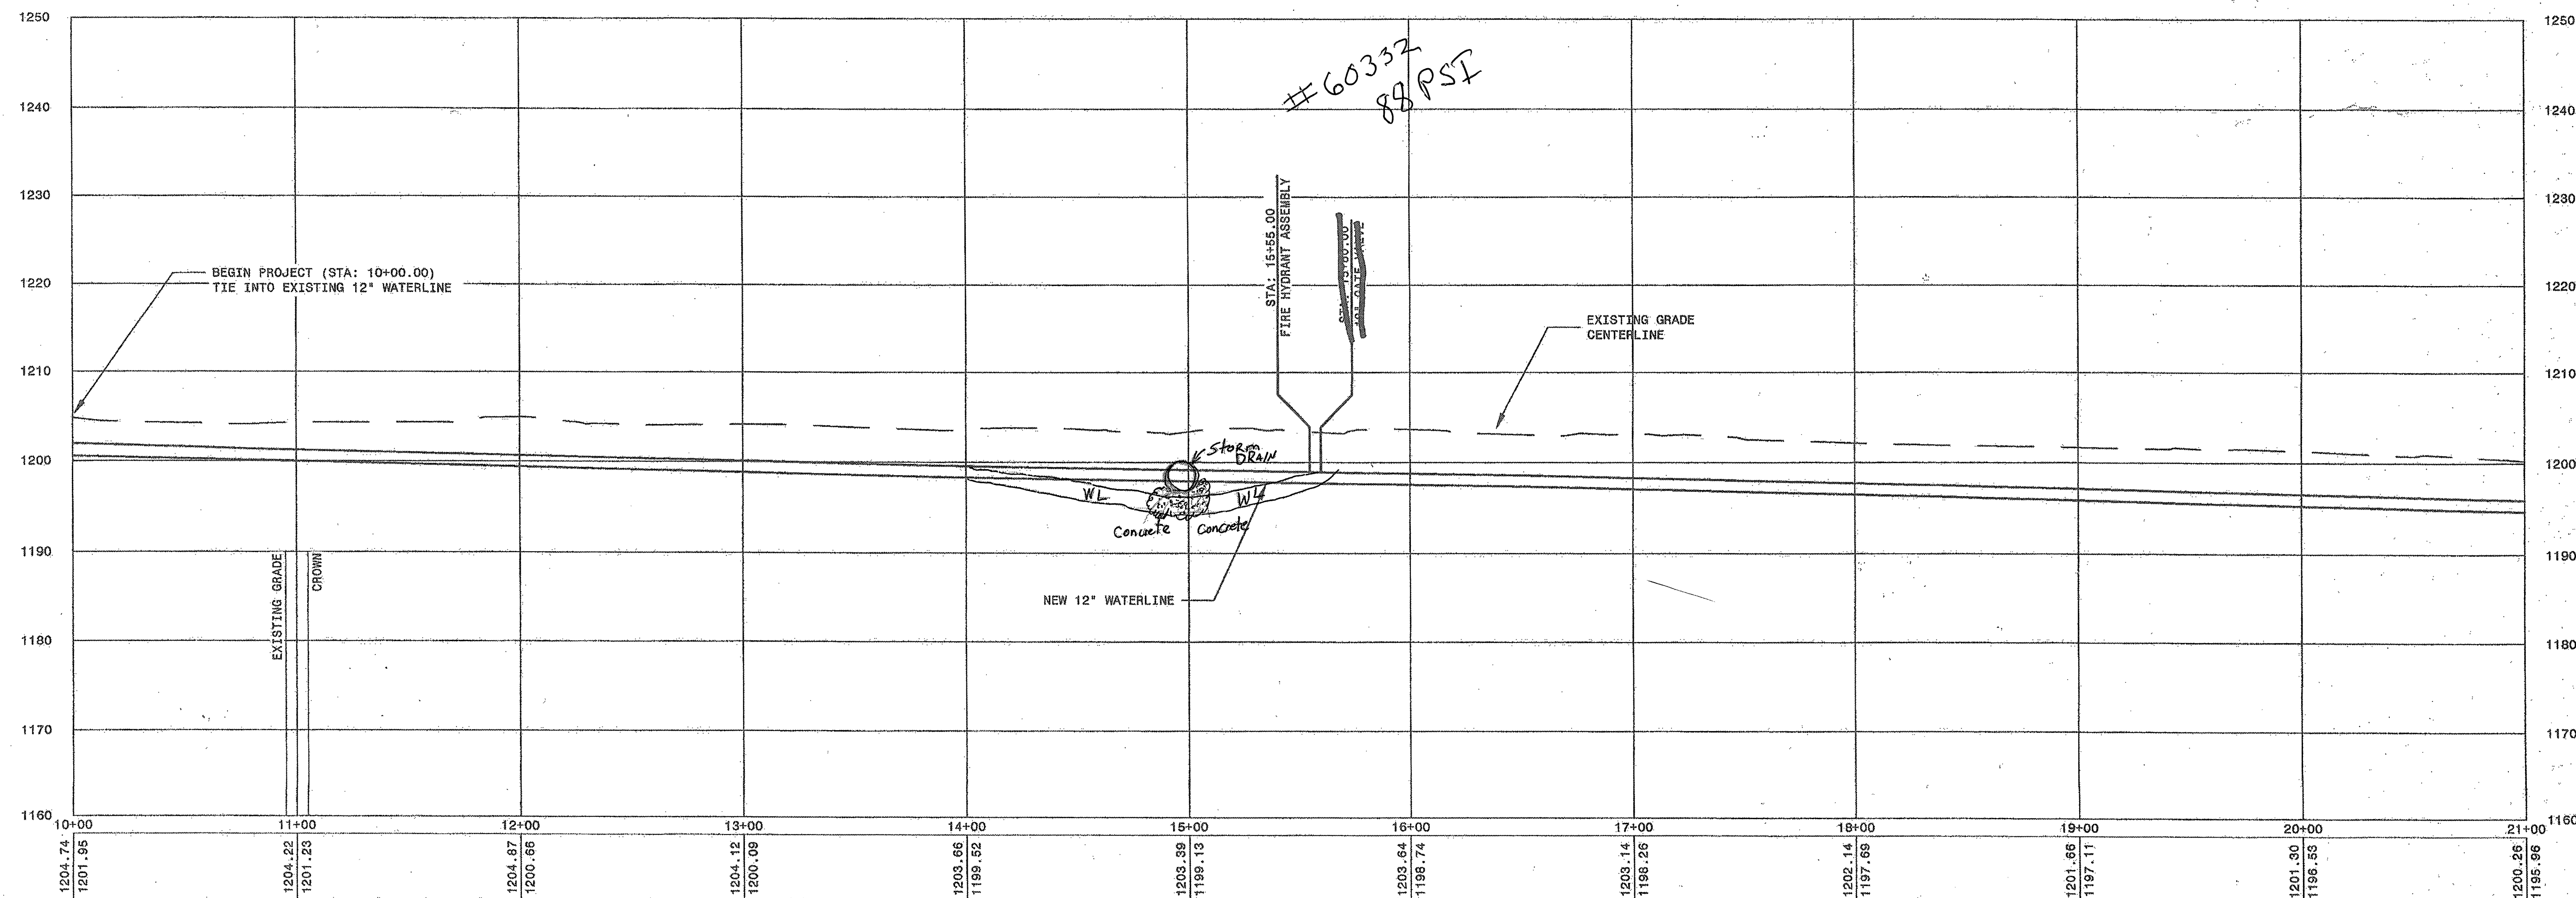


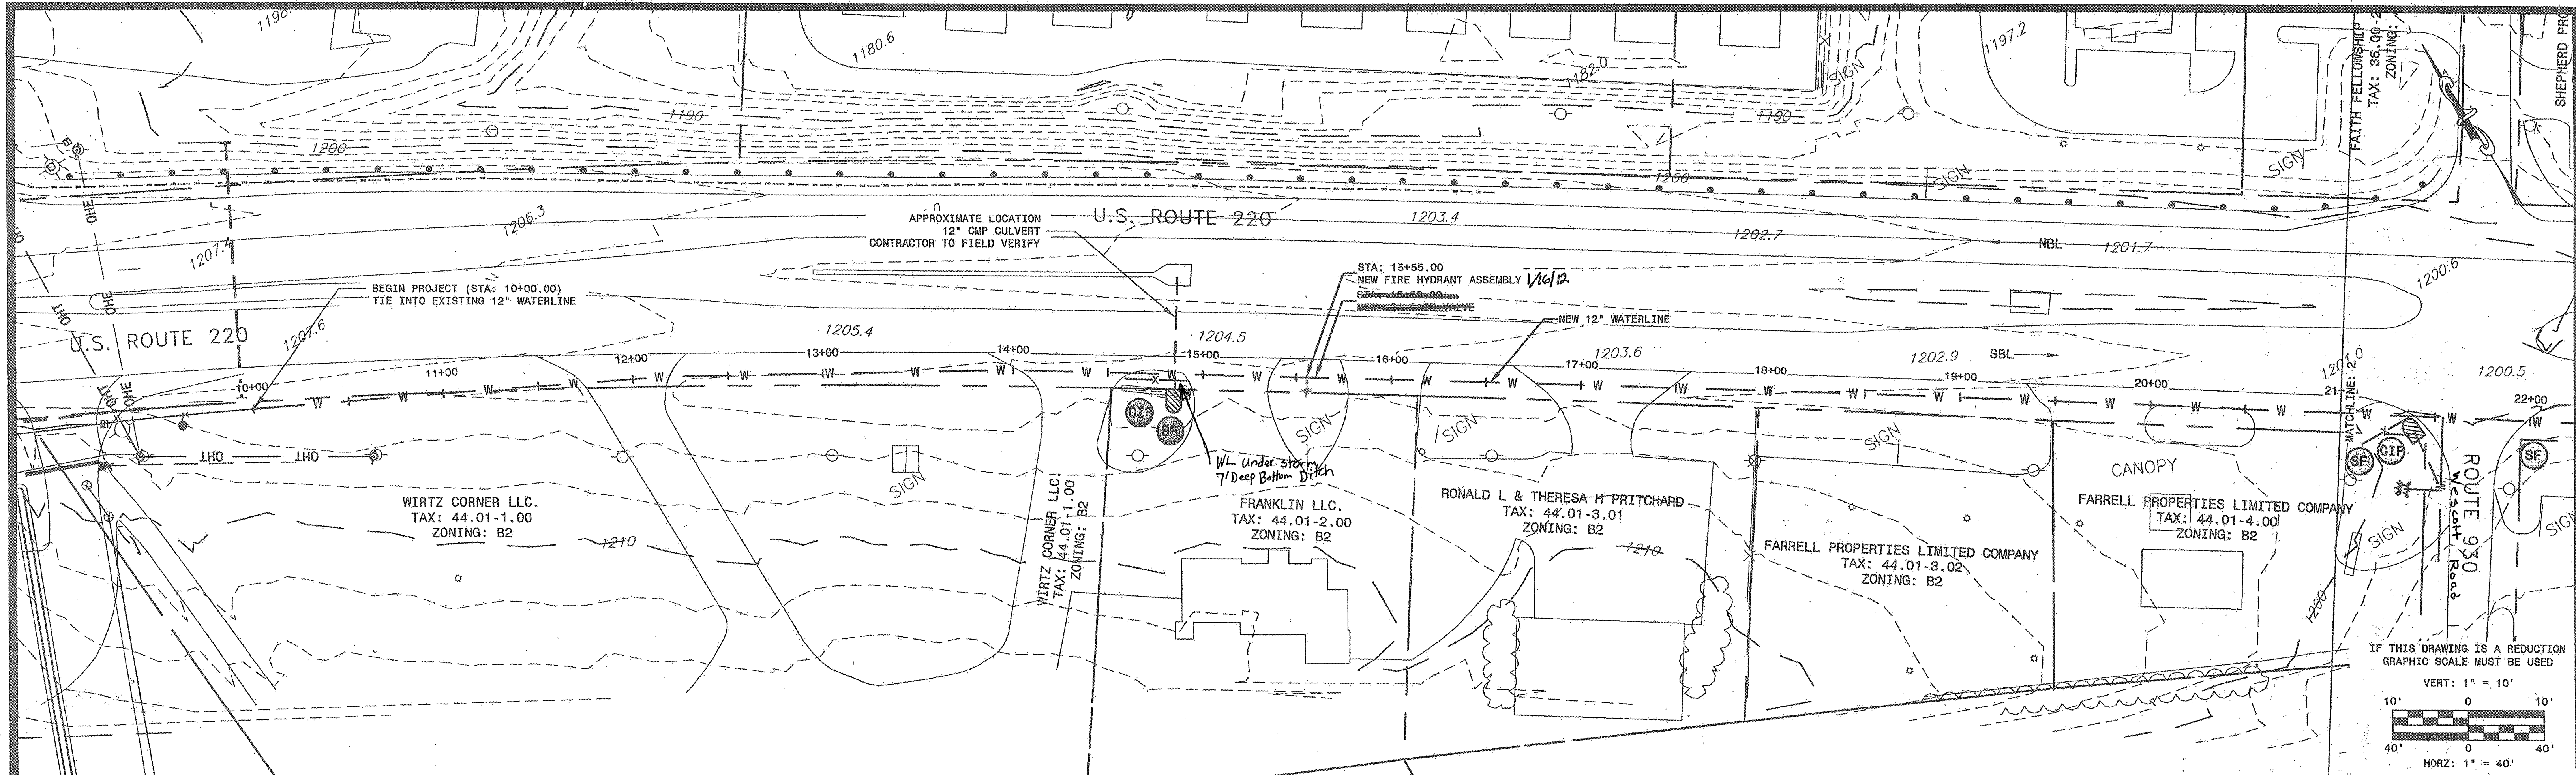

P:\Western VA Water Authority\11-0061 - RT 220 WL EXT South\11-0061.dwg


| No. | Revisions: | Date: |
|-----|------------|-------|
|     |            |       |
|     |            |       |
|     |            |       |
|     |            |       |
|     |            |       |

**earth**  
environmental and civil

ADDRESS:  
235 CLAIRBORNE AVE.  
ROCKY MOUNT, VA 24151

PHONE NUMBERS:  
PHONE: (540) 483-5975  
FAX: (540) 483-2221

WEBSITE  
WWW.EARTHENV.COM

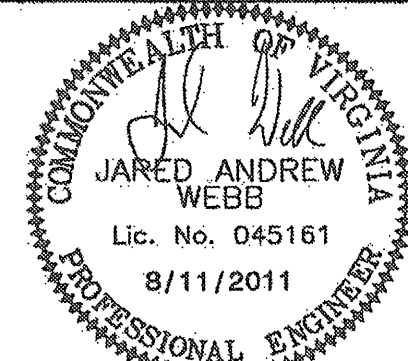

As Built *Woll*  
3-30-12

|                            |                                                                                      |                         |
|----------------------------|--------------------------------------------------------------------------------------|-------------------------|
| DESIGN BY:<br>BKS          | PROJECT:<br>ROUTE 220 WATERLINE EXTENSION                                            | DATE:<br>8/11/2011      |
| DRAWN BY:<br>BKS           | TITLE:<br>US 220 WATERLINE EXTENSION<br>PLAN AND PROFILE - STA: 10+00.00 TO 21+00.00 | DRAWING NUMBER:<br>C1   |
| REVIEWED BY:<br>JAW        | DRAWING NAME:<br>11-0061.dwg                                                         | SHEET NUMBER:<br>2 of 5 |
| PROJECT NUMBER:<br>11-0061 | SCALE:<br>H: 1" = 40'<br>V: 1" = 10'                                                 |                         |