

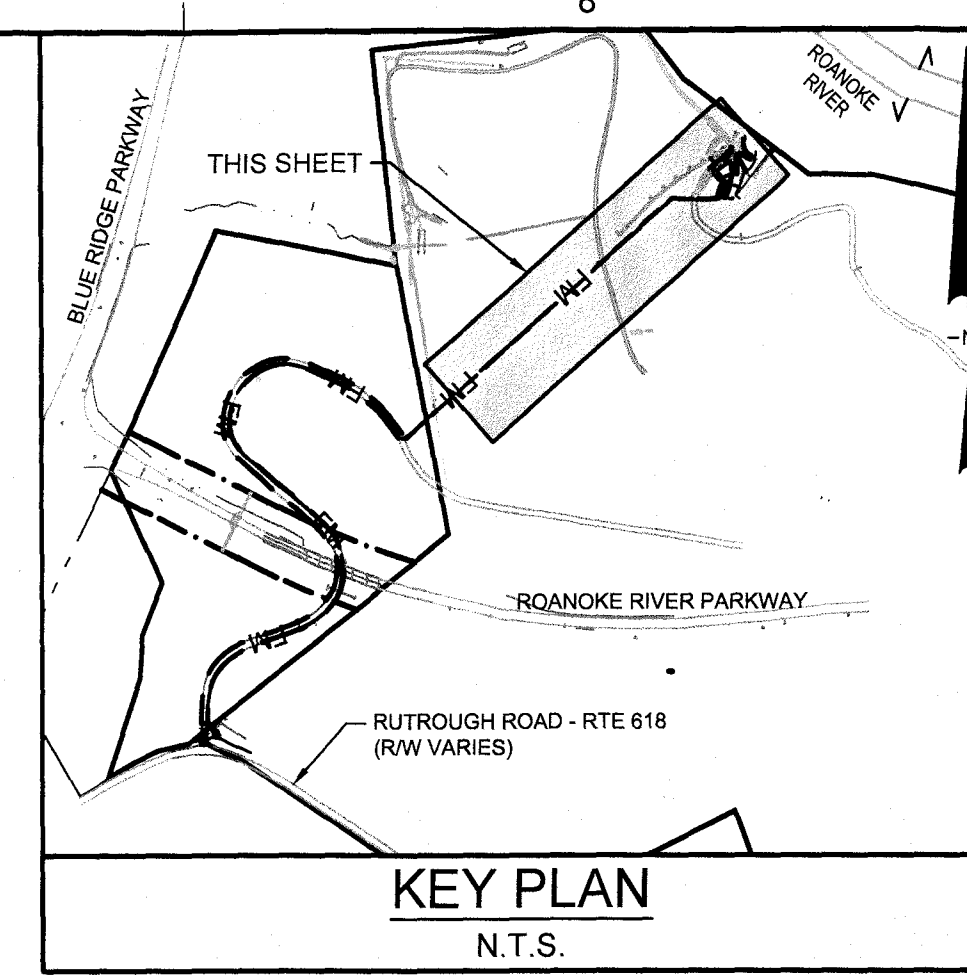
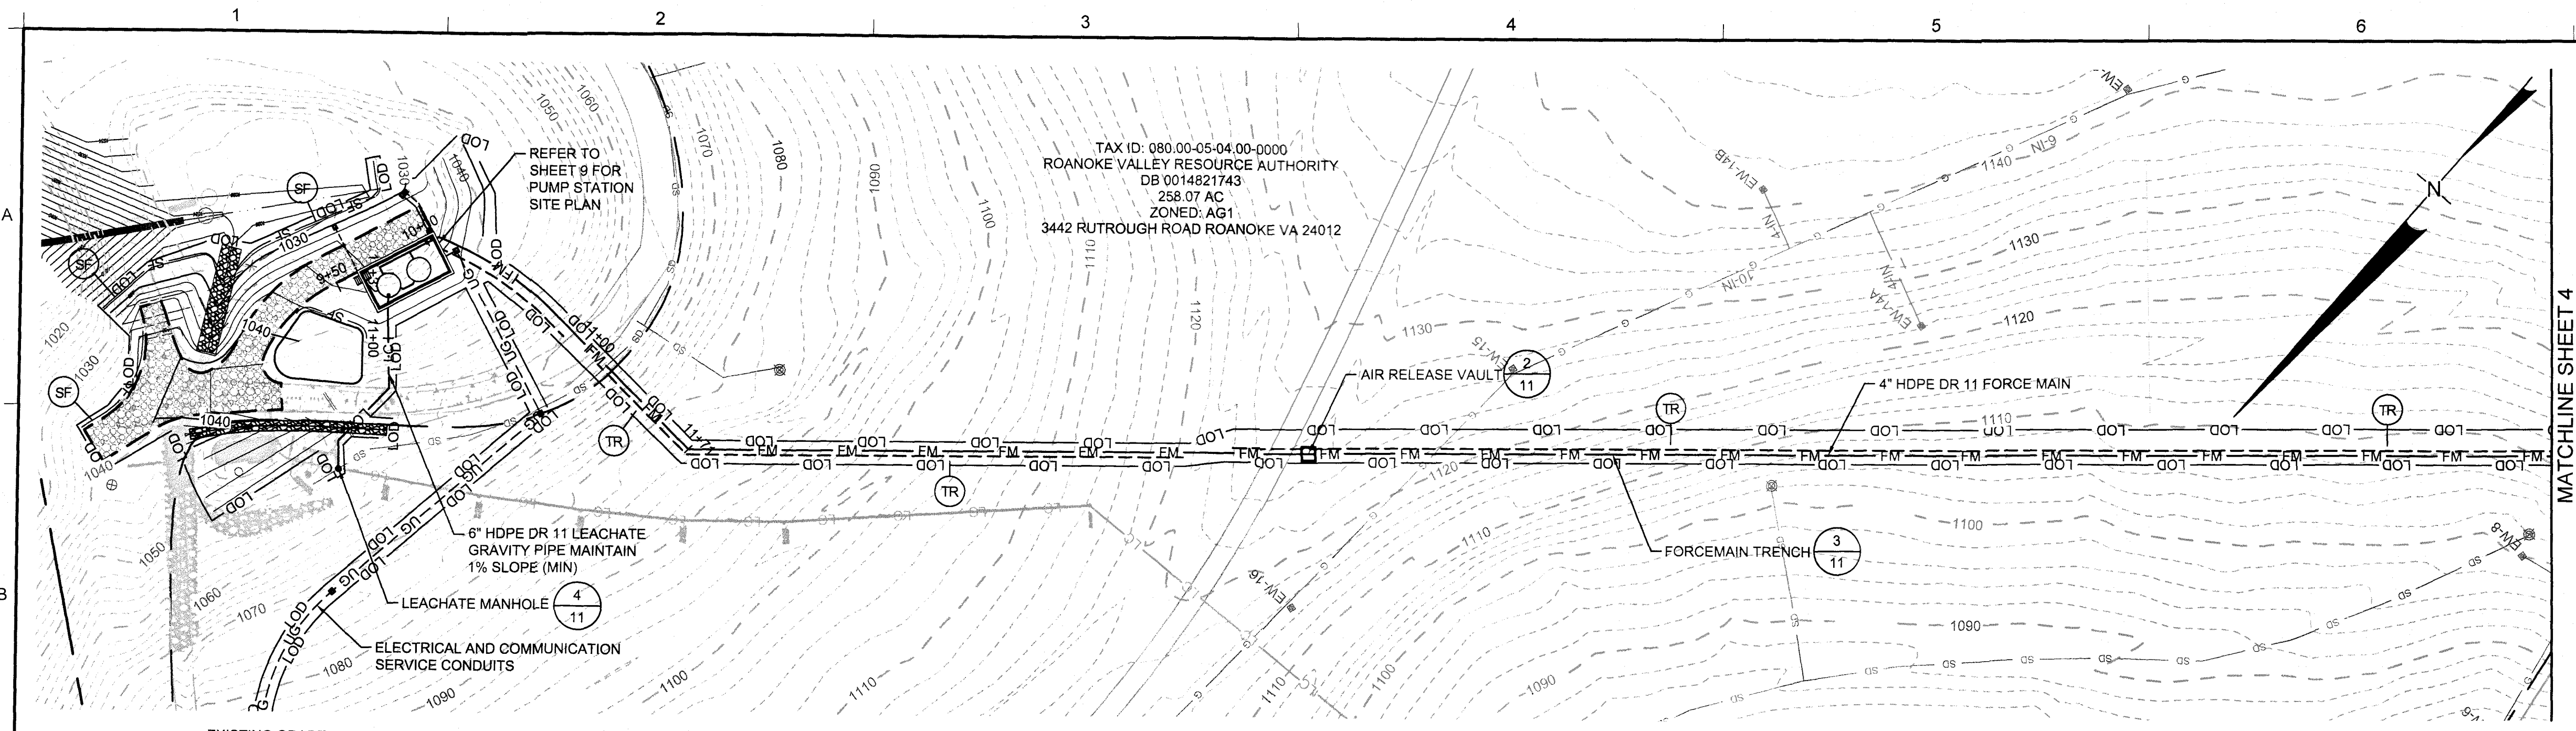
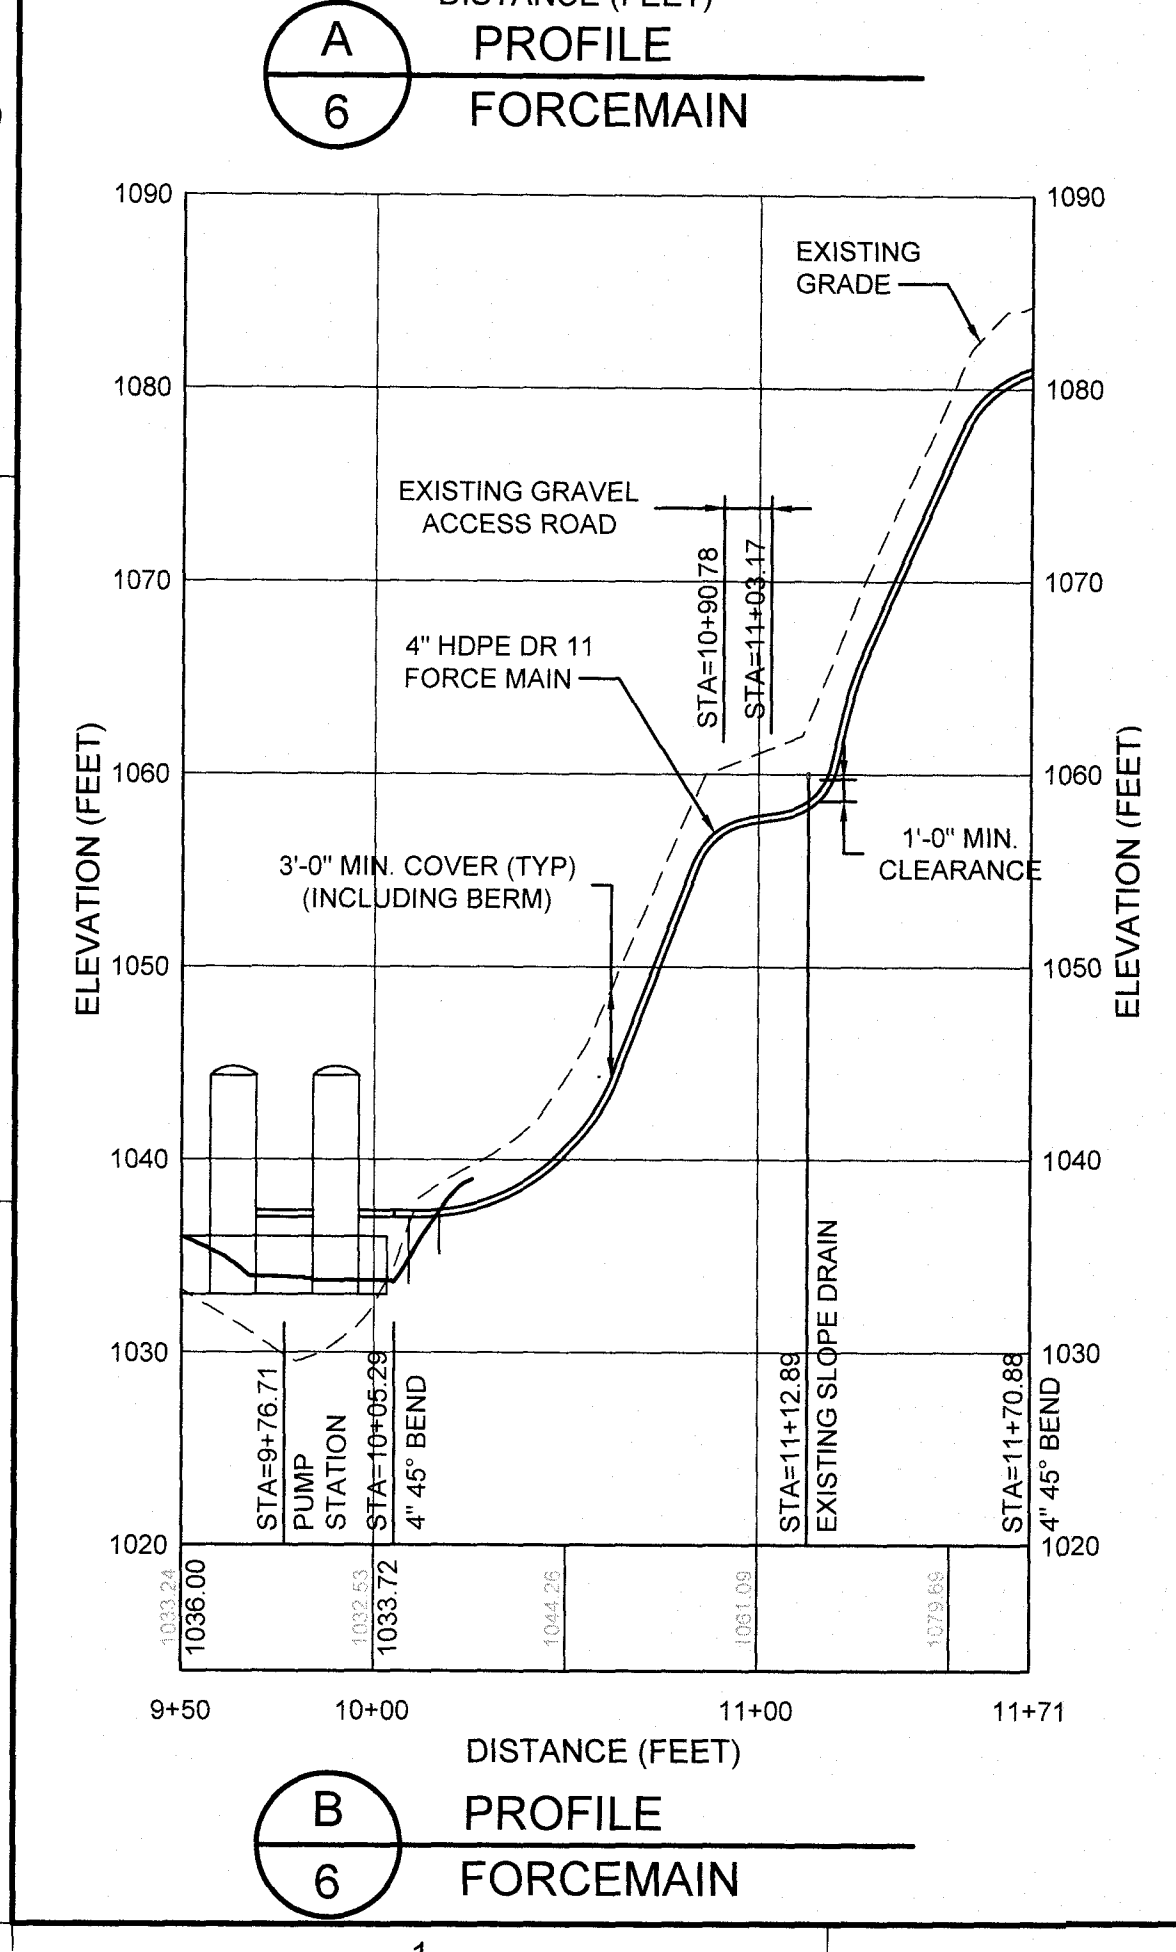
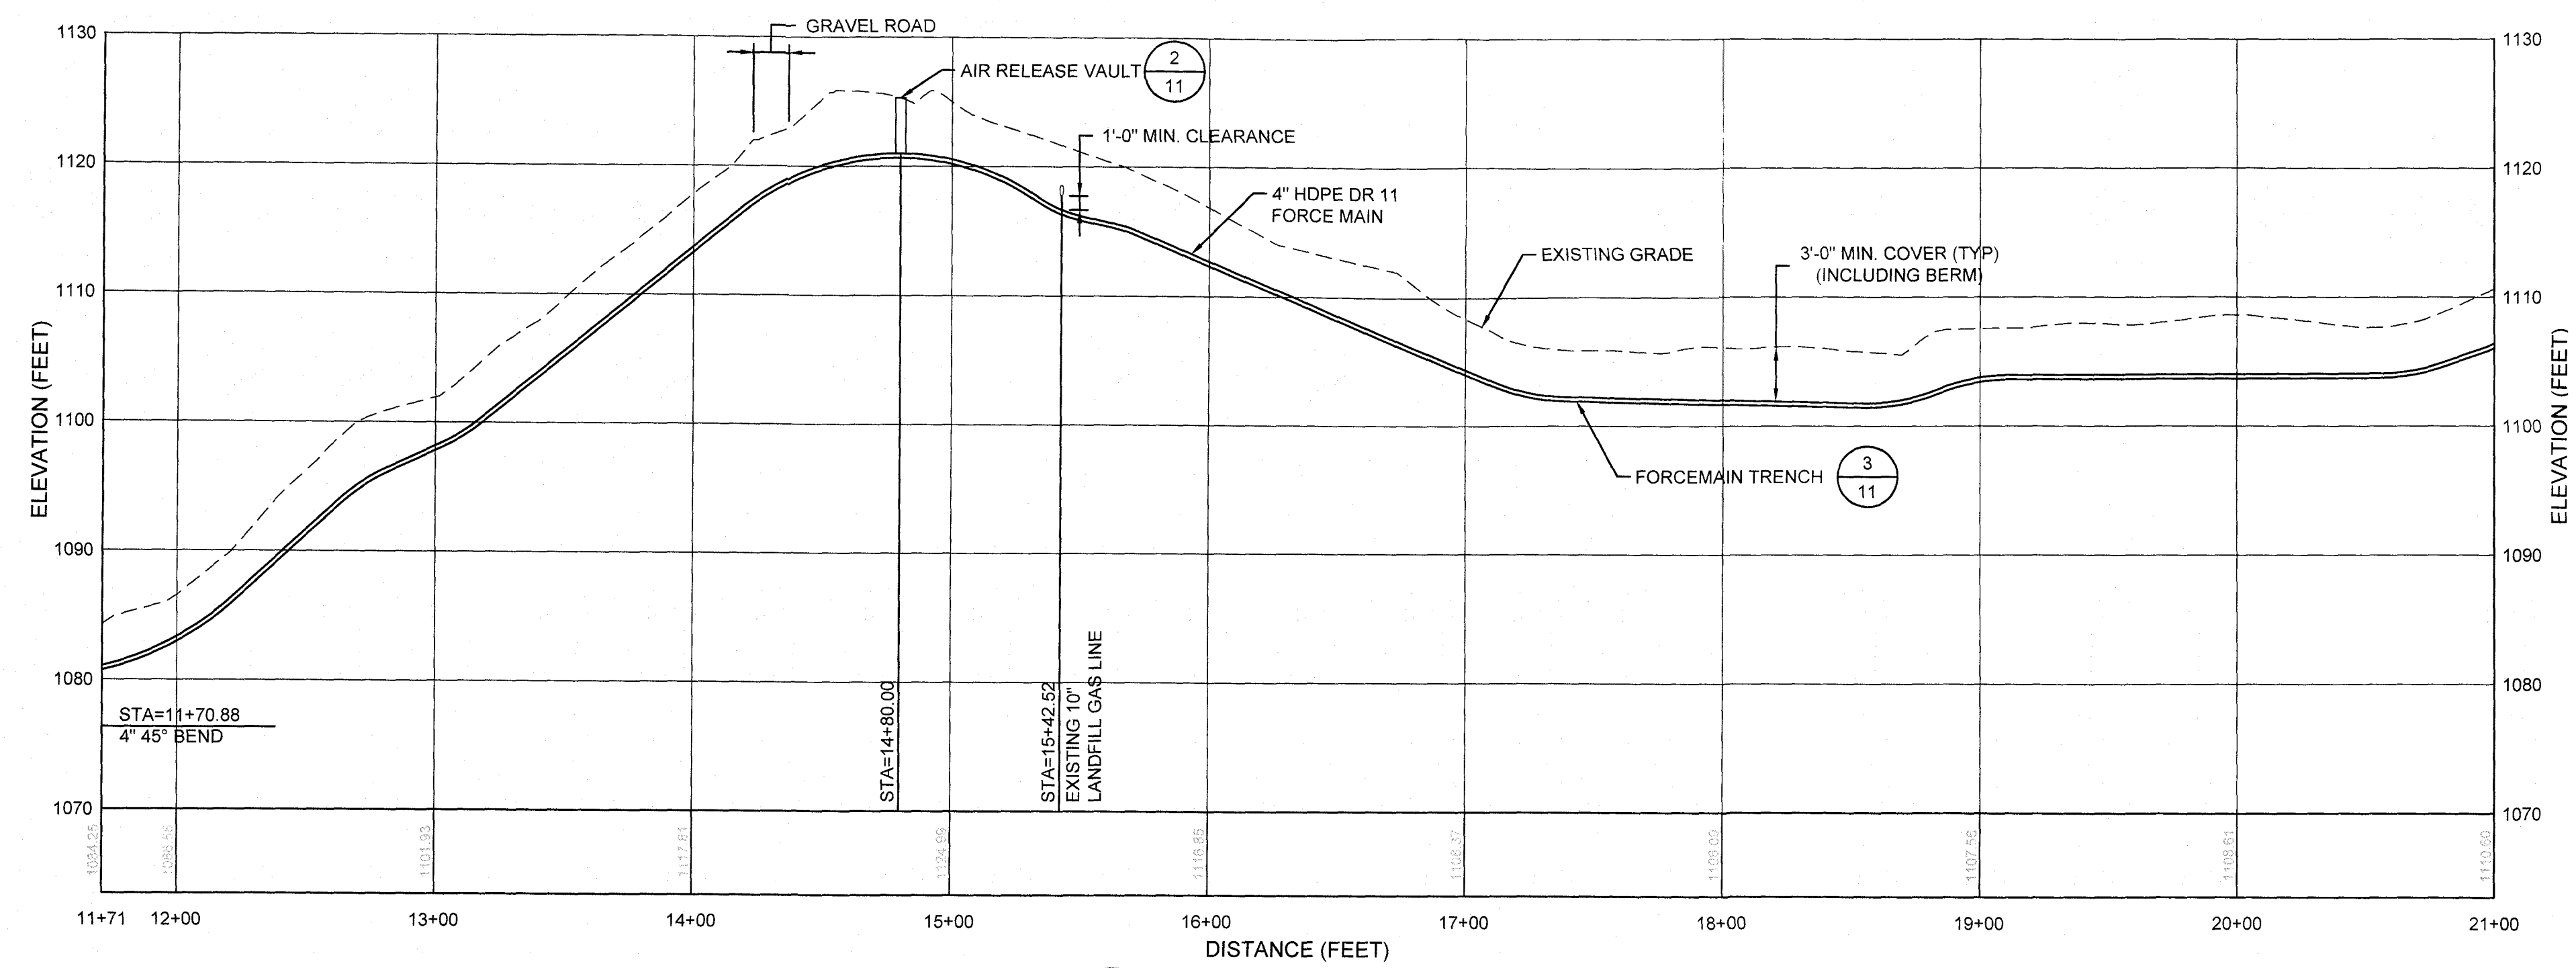


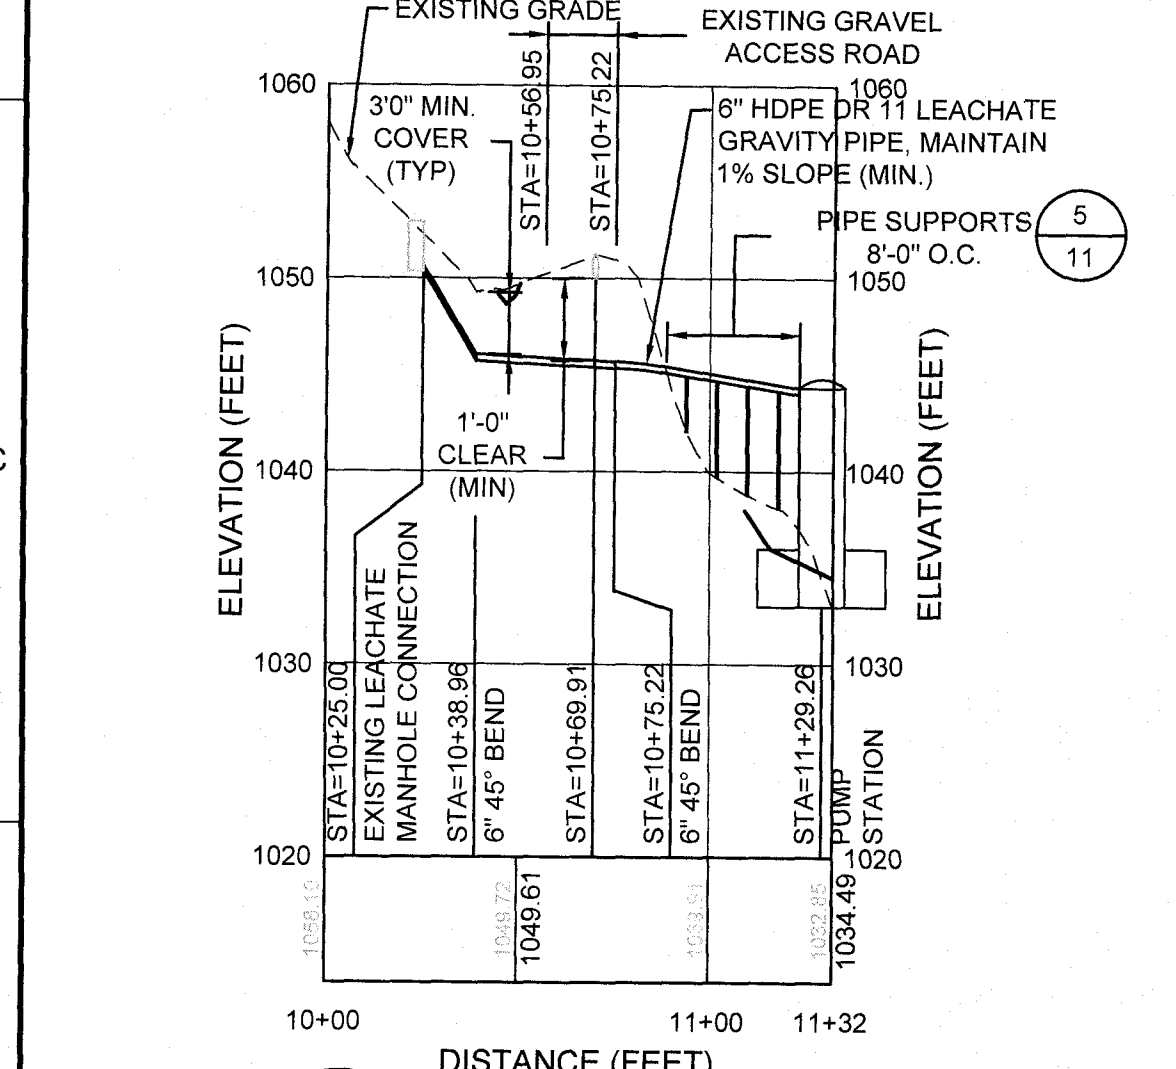

NO	KEY	SYMBOL	DESCRIPTION
3.05	(SF)	— SF —	SILT FENCE
3.07	(IP)	⊗	INLET PROTECTION
3.08	(CIP)	⊗	CULVERT INLET PROTECTION
		— LOD —	LIMITS OF DISTURBANCE
	(TR)	---	TRENCH PROTECTION

LEGEND	
— OHU —	EXISTING OVERHEAD POWER
————	EXISTING PROPERTY LINE
————	EXISTING ROAD - ASPHALT
————	EXISTING ROAD - GRAVEL
————	EXISTING STORM PIPE
— 1034 —	EXISTING CONTOUR
— > —	EXISTING GUY WIRE
— ⚡ —	EXISTING POWER POLE
————	EXISTING LANDFILL LIMITS
— LC — LC —	EXISTING LEACHATE PIPE
— G — G —	EXISTING LANDFILL GAS LINE
— SD — SD —	EXISTING SLOPE DRAIN
————	STORM PIPE BY OTHERS
— FM — FM —	PROPOSED FORCE MAIN
————	PROPOSED TRENCH PROTECTION
— LC — LC —	PROPOSED LEACHATE COLLECTION PIPE
— 1034 —	PROPOSED CONTOUR
— UG — UG —	ELECTRICAL AND COMMUNICATIONS CONDUITS

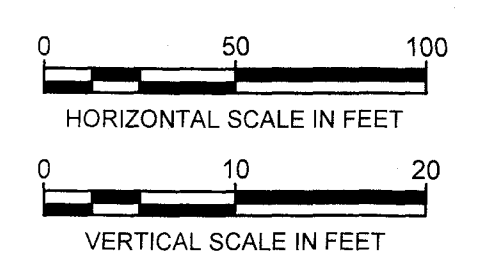

REV	DATE	DESCRIPTION	DRN	APP
Geosyntec[®] consultants 9211 ARBORETUM PARKWAY, SUITE 200 RICHMOND, VA 23236 USA PHONE: 804.787.2205				
Roanoke Valley Resource Authority 1020 HOLLINS ROAD, NE ROANOKE, VA 24012-8011 PHONE: 540.857.5050				
TITLE: PLAN AND PROFILE - EROSION AND SEDIMENT CONTROL 1 OF 3				
PROJECT: CONSTRUCTION PLAN				
SITE: RUTROUGH ROAD LANDFILL PUMP STATION AND FORCE MAIN ROANOKE VALLEY RESOURCE AUTHORITY ROANOKE, VIRGINIA				
DESIGN BY:	KEL	DATE:	SEPTEMBER 2017	
DRAWN BY:	TAW	PROJECT NO.:	MV1427	
CHECKED BY:	JEC	FILE:	1427-006-008.DWG	
REVIEWED BY:	KEL	DRAWING NO.:	6 OF 14	
APPROVED BY:	KEL			

PERMIT DRAWINGS