



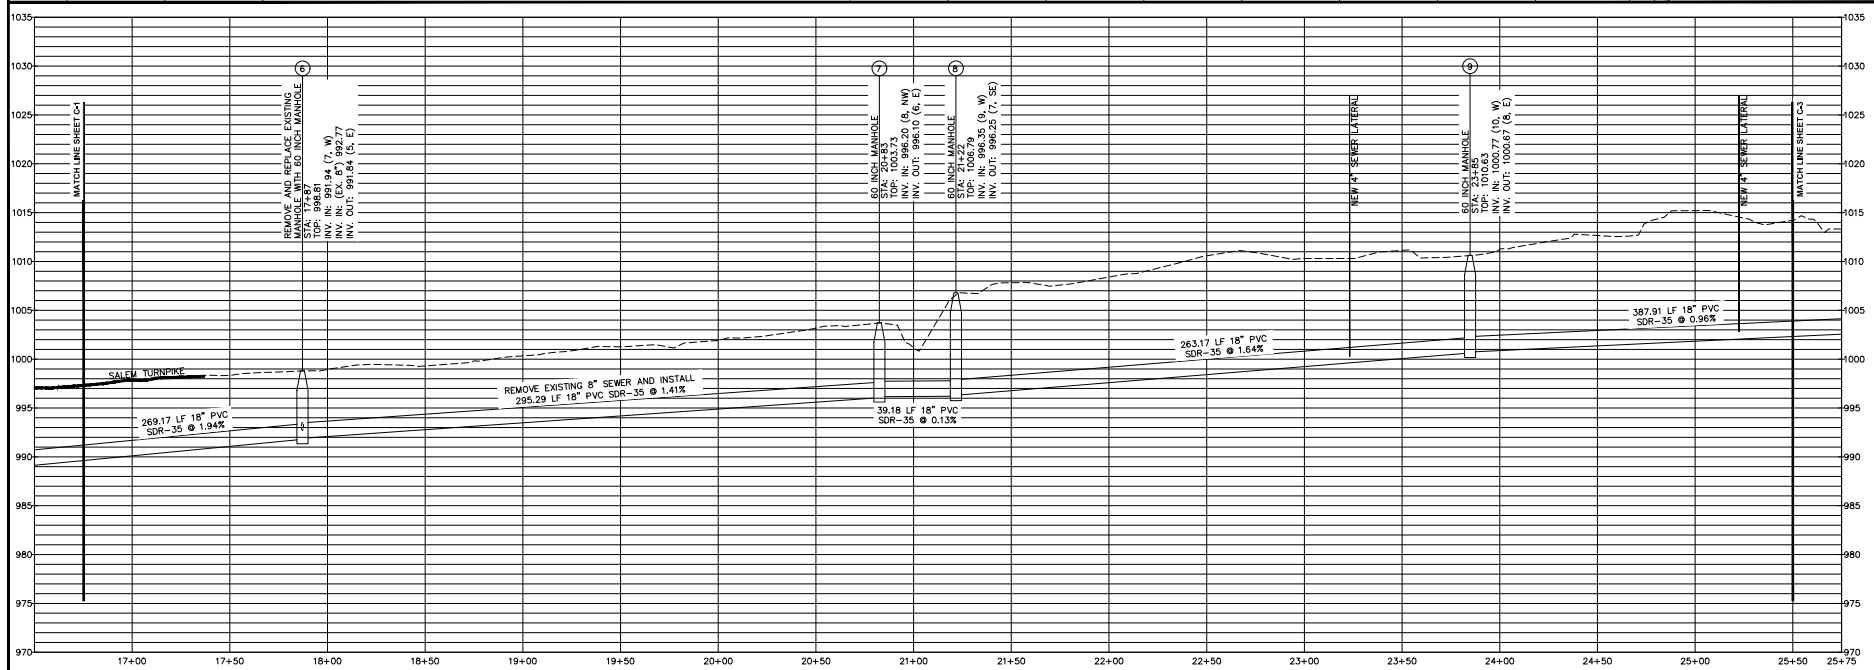

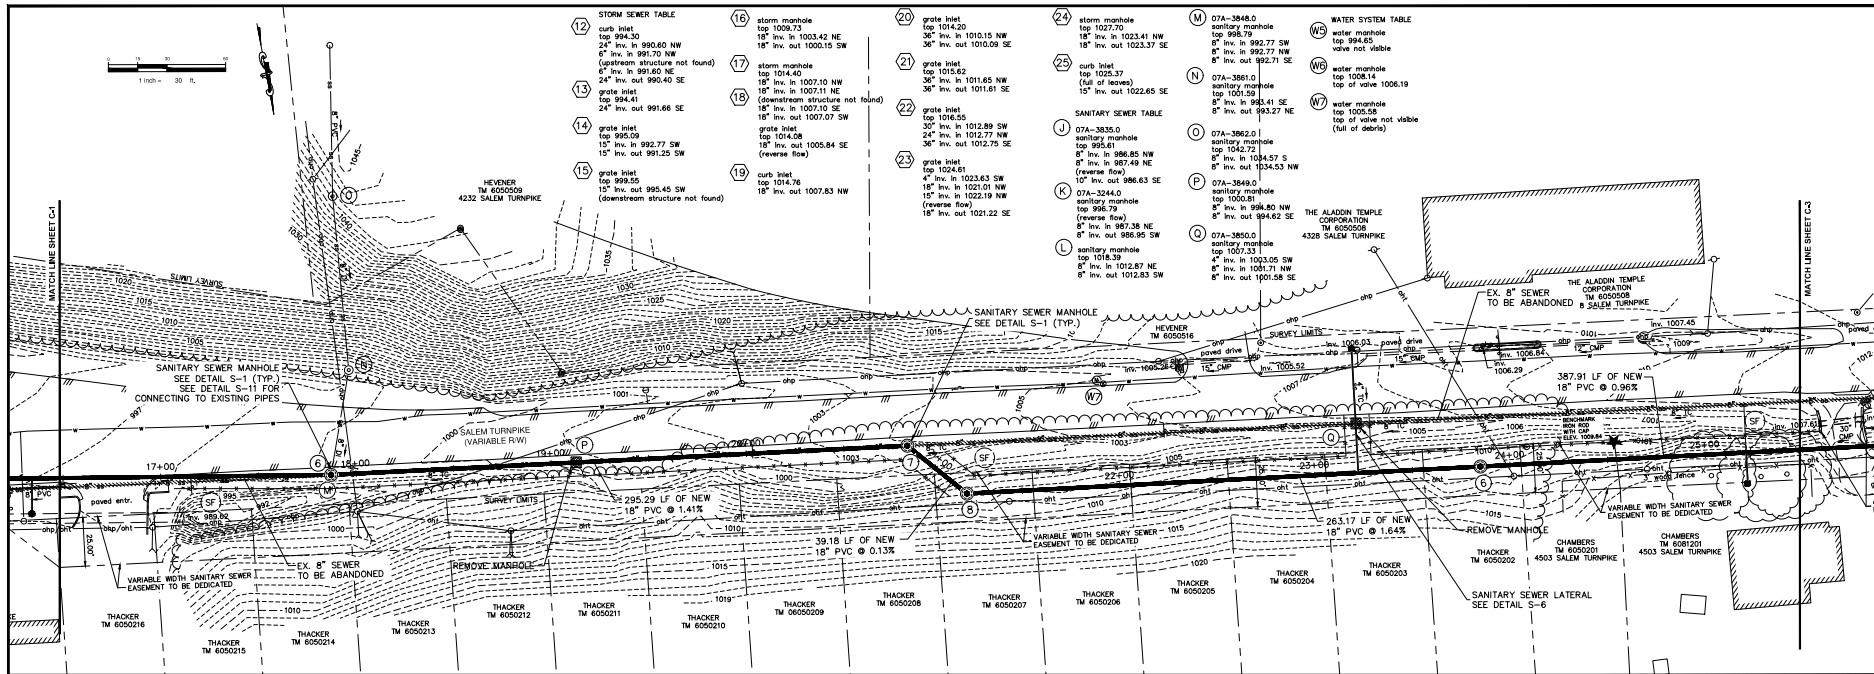

Draper Aden Associates
 Engineering • Surveying • Environmental Sciences
 2206 South Main Street
 Blacksburg, VA 24060
 540-552-5555 • Fax 540-552-4291
 www.daa.com

 
SEWER MAIN PLAN AND PROFILE
SALEM TURNPIKE SANITARY SEWER
 ROANOKE CITY, VIRGINIA

REVISIONS

NO.	DATE	DESCRIPTION
1	SEPTEMBER 2018	ISSUED FOR PERMIT

DESIGNED BY: BSC/JSL
 DRAWN BY: BSC/JYG
 CHECKED BY: MSH
 SCALE: H: 1" = 30'; V: 5:1
 DATE: SEPTEMBER 2018
 PROJECT NUMBER: 17010596-010301

C-2


 JAY S. LESTER
 No. 16854
 11/12/18