

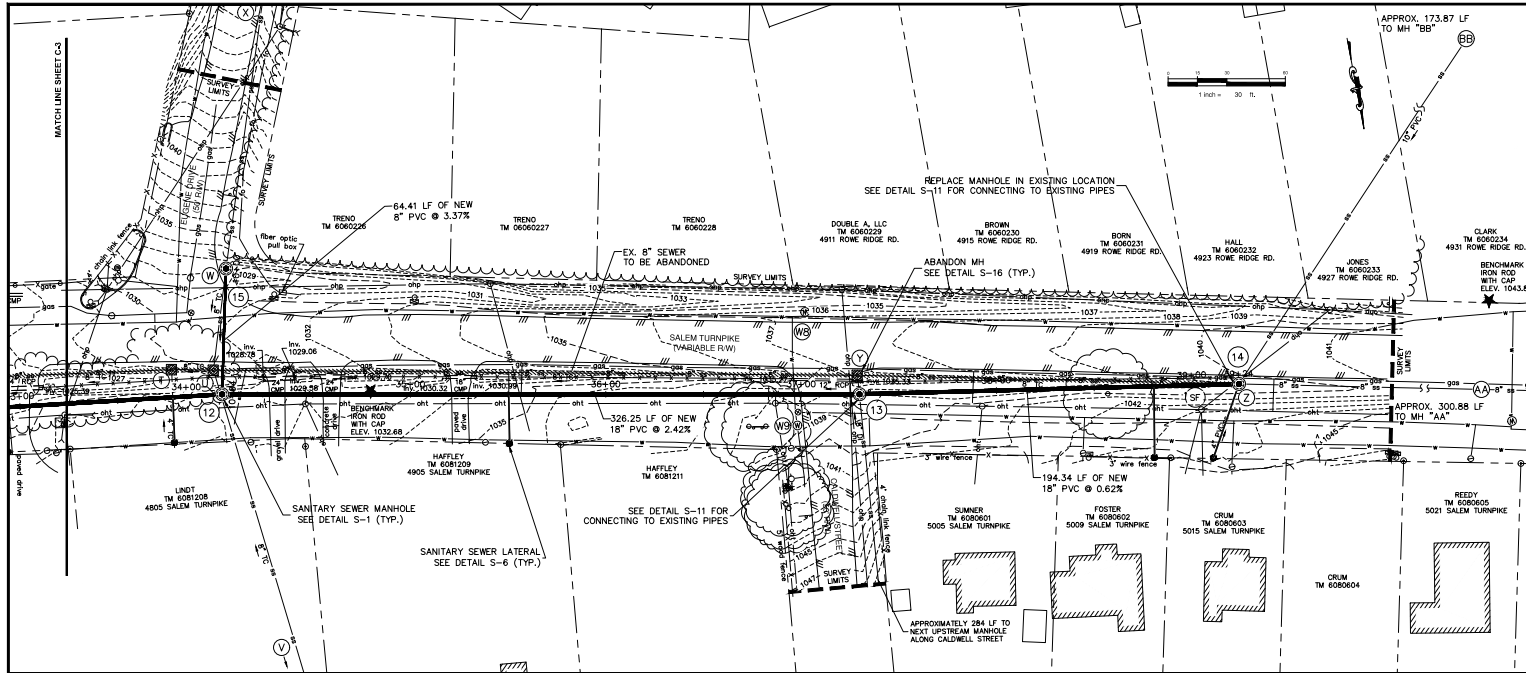


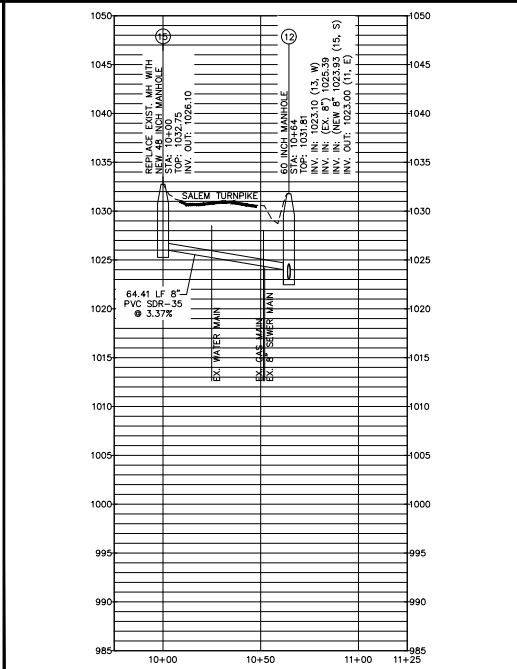

STORM SEWER TABLE	
20	grate inlet top 1014.20 36\"/>

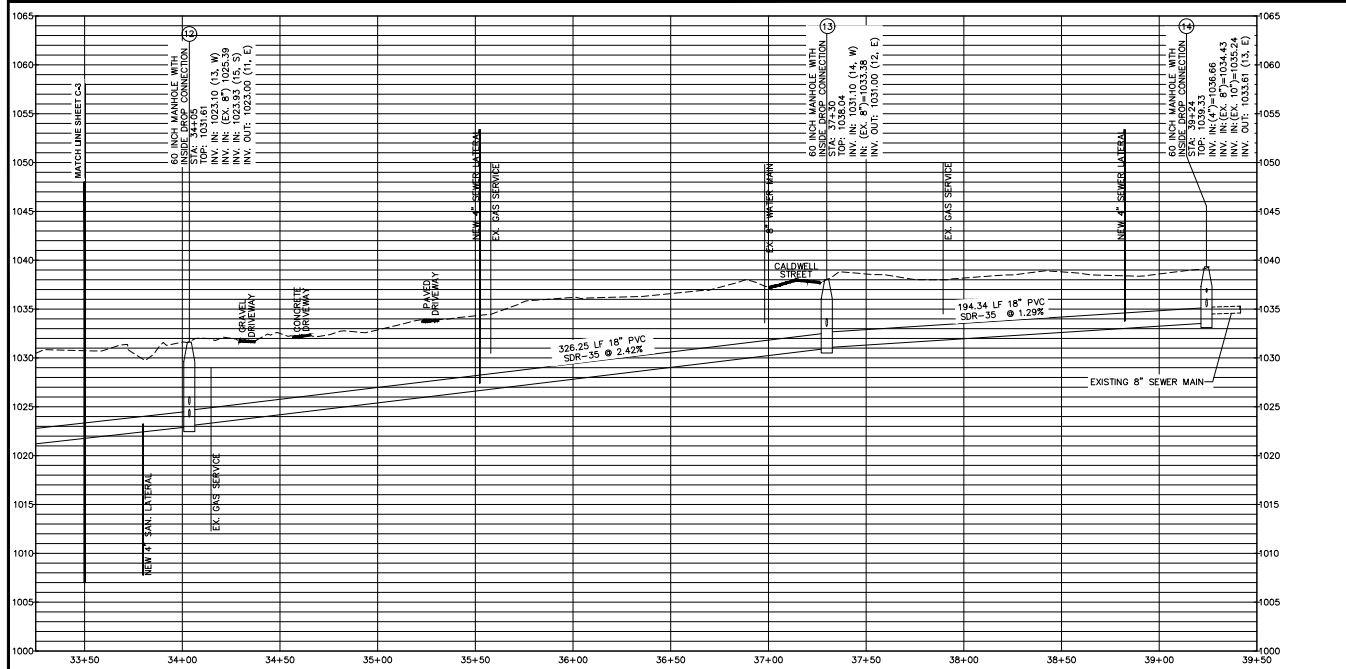

Draper Aden Associates
 Engineering • Surveying • Environmental Services
 2208 South Main Street
 Blacksburg, VA 24060
 540-550-0000
 www.daas.com

• Raleigh, NC
 • Fayetteville, NC
 • Charlottesville, VA
 • Hampton Roads, VA
 • Virginia Beach, VA
 • Richmond, VA

SEWER MAIN PLAN AND PROFILE
SALEM TURNPIKE SANITARY SEWER
 ROANOKE CITY, VIRGINIA

REVISIONS

DESIGNED BY:	BSC / JSL
DRAWN BY:	BSC / JYG
CHECKED BY:	MSH
SCALE:	H: 1" = 30'; V: 5:1
DATE:	SEPTEMBER 2018
PROJECT NUMBER:	17010596-010301

C-4