
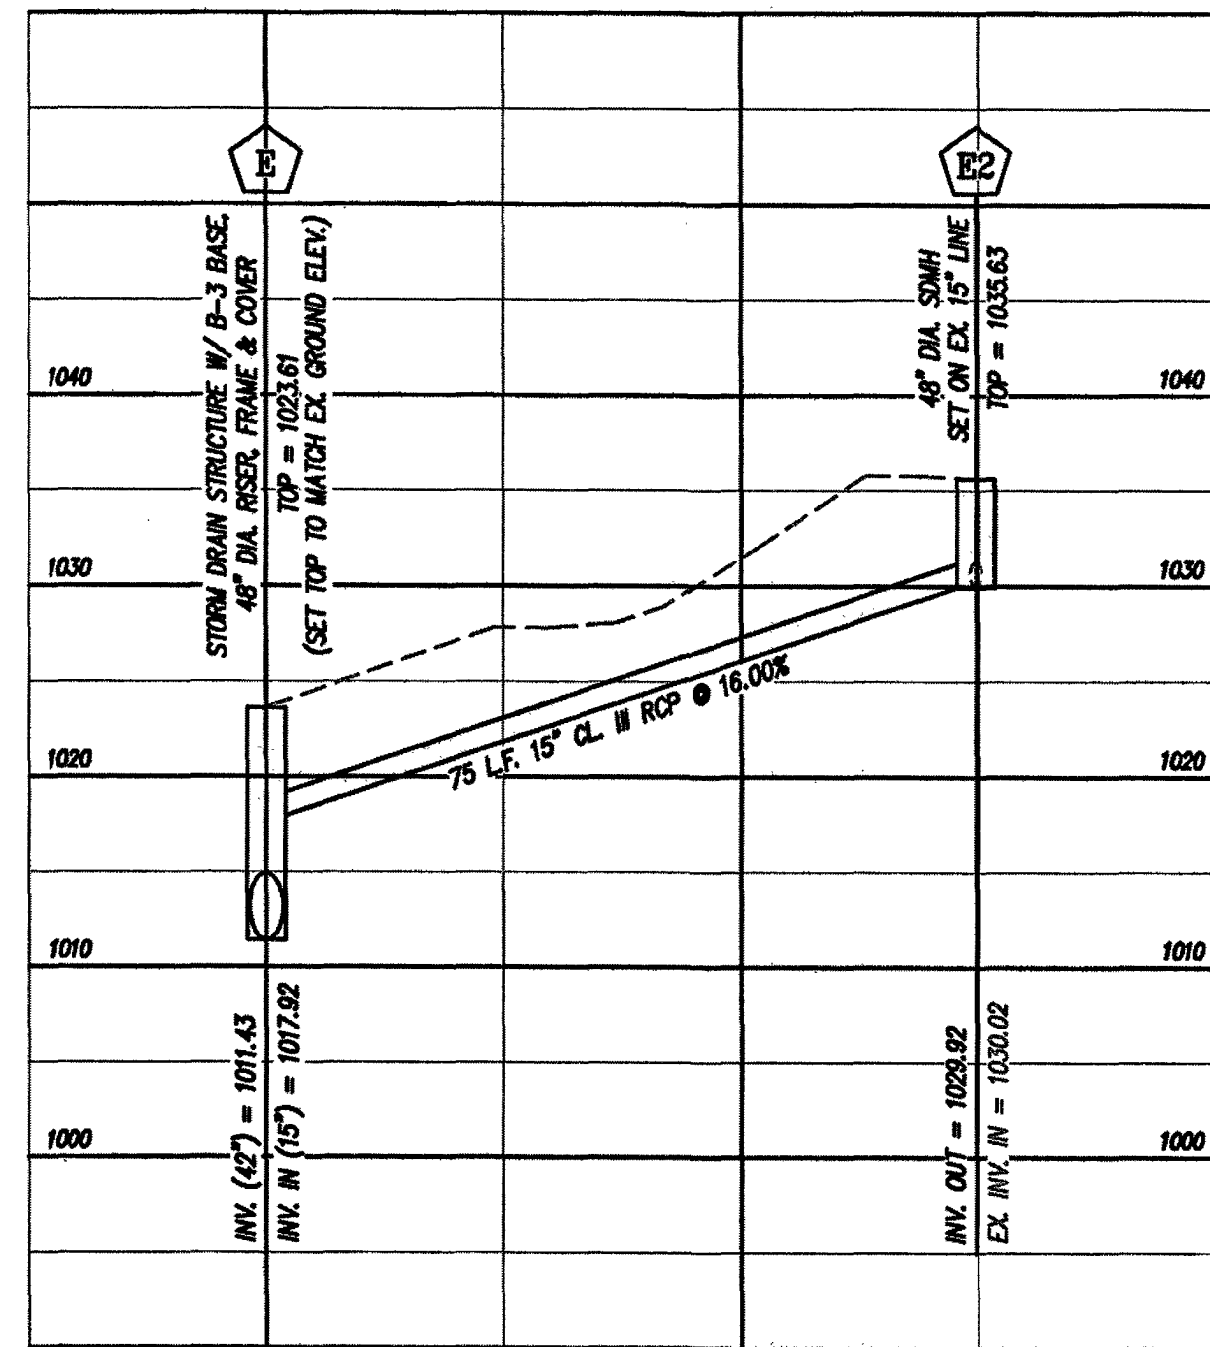
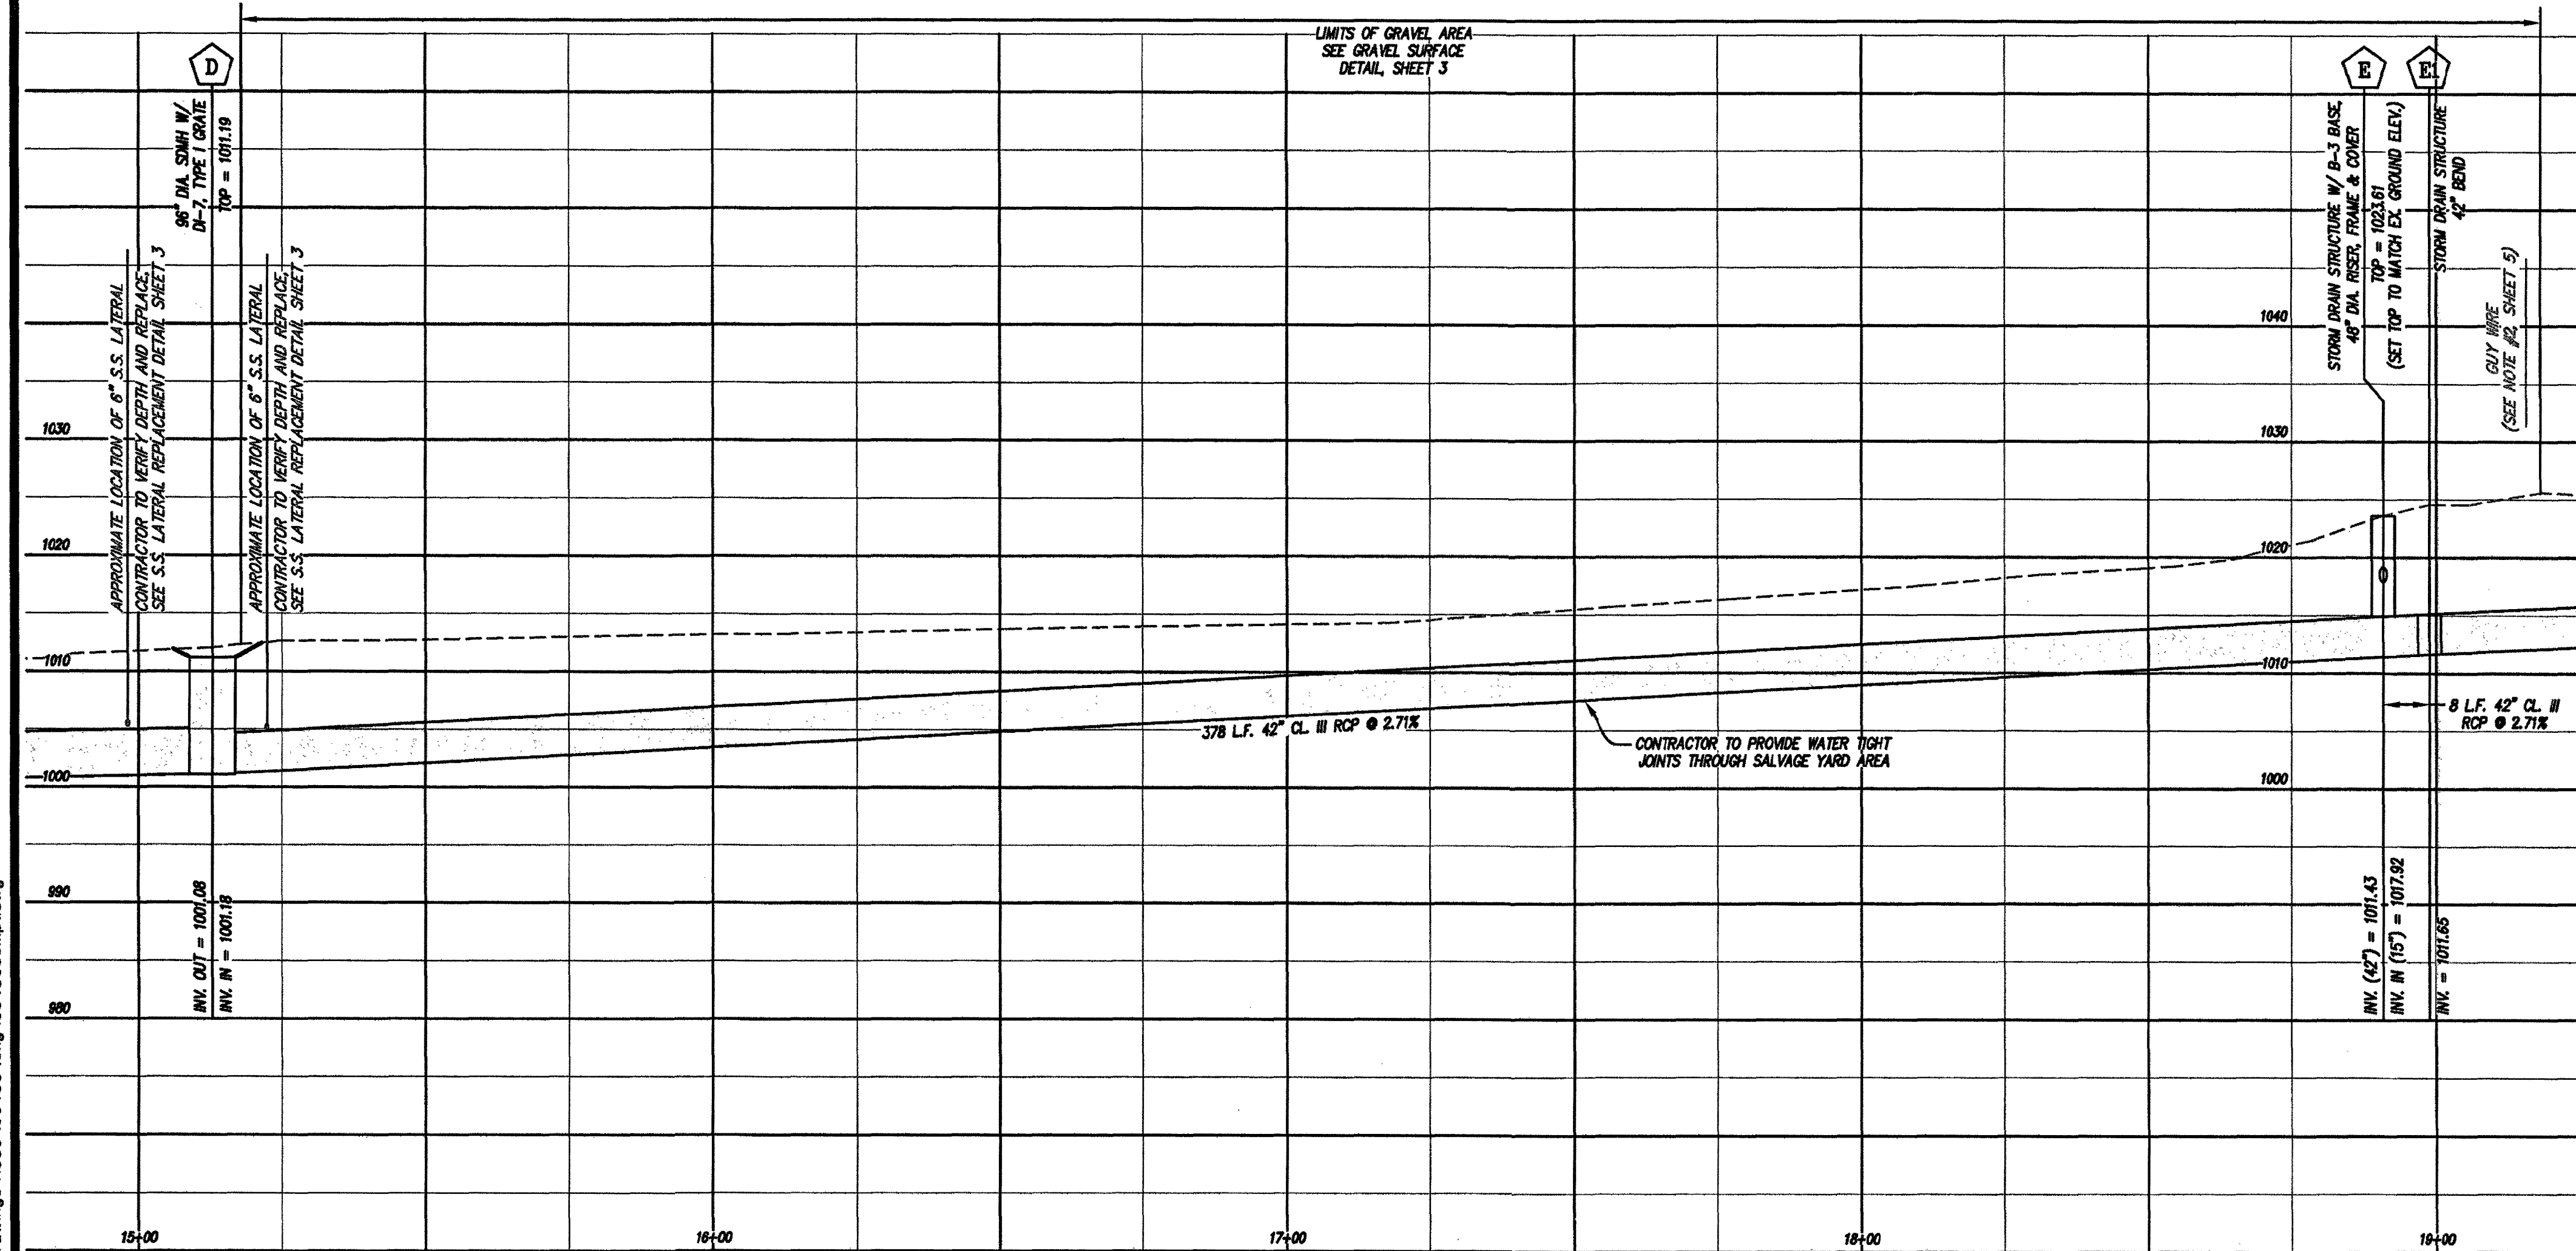


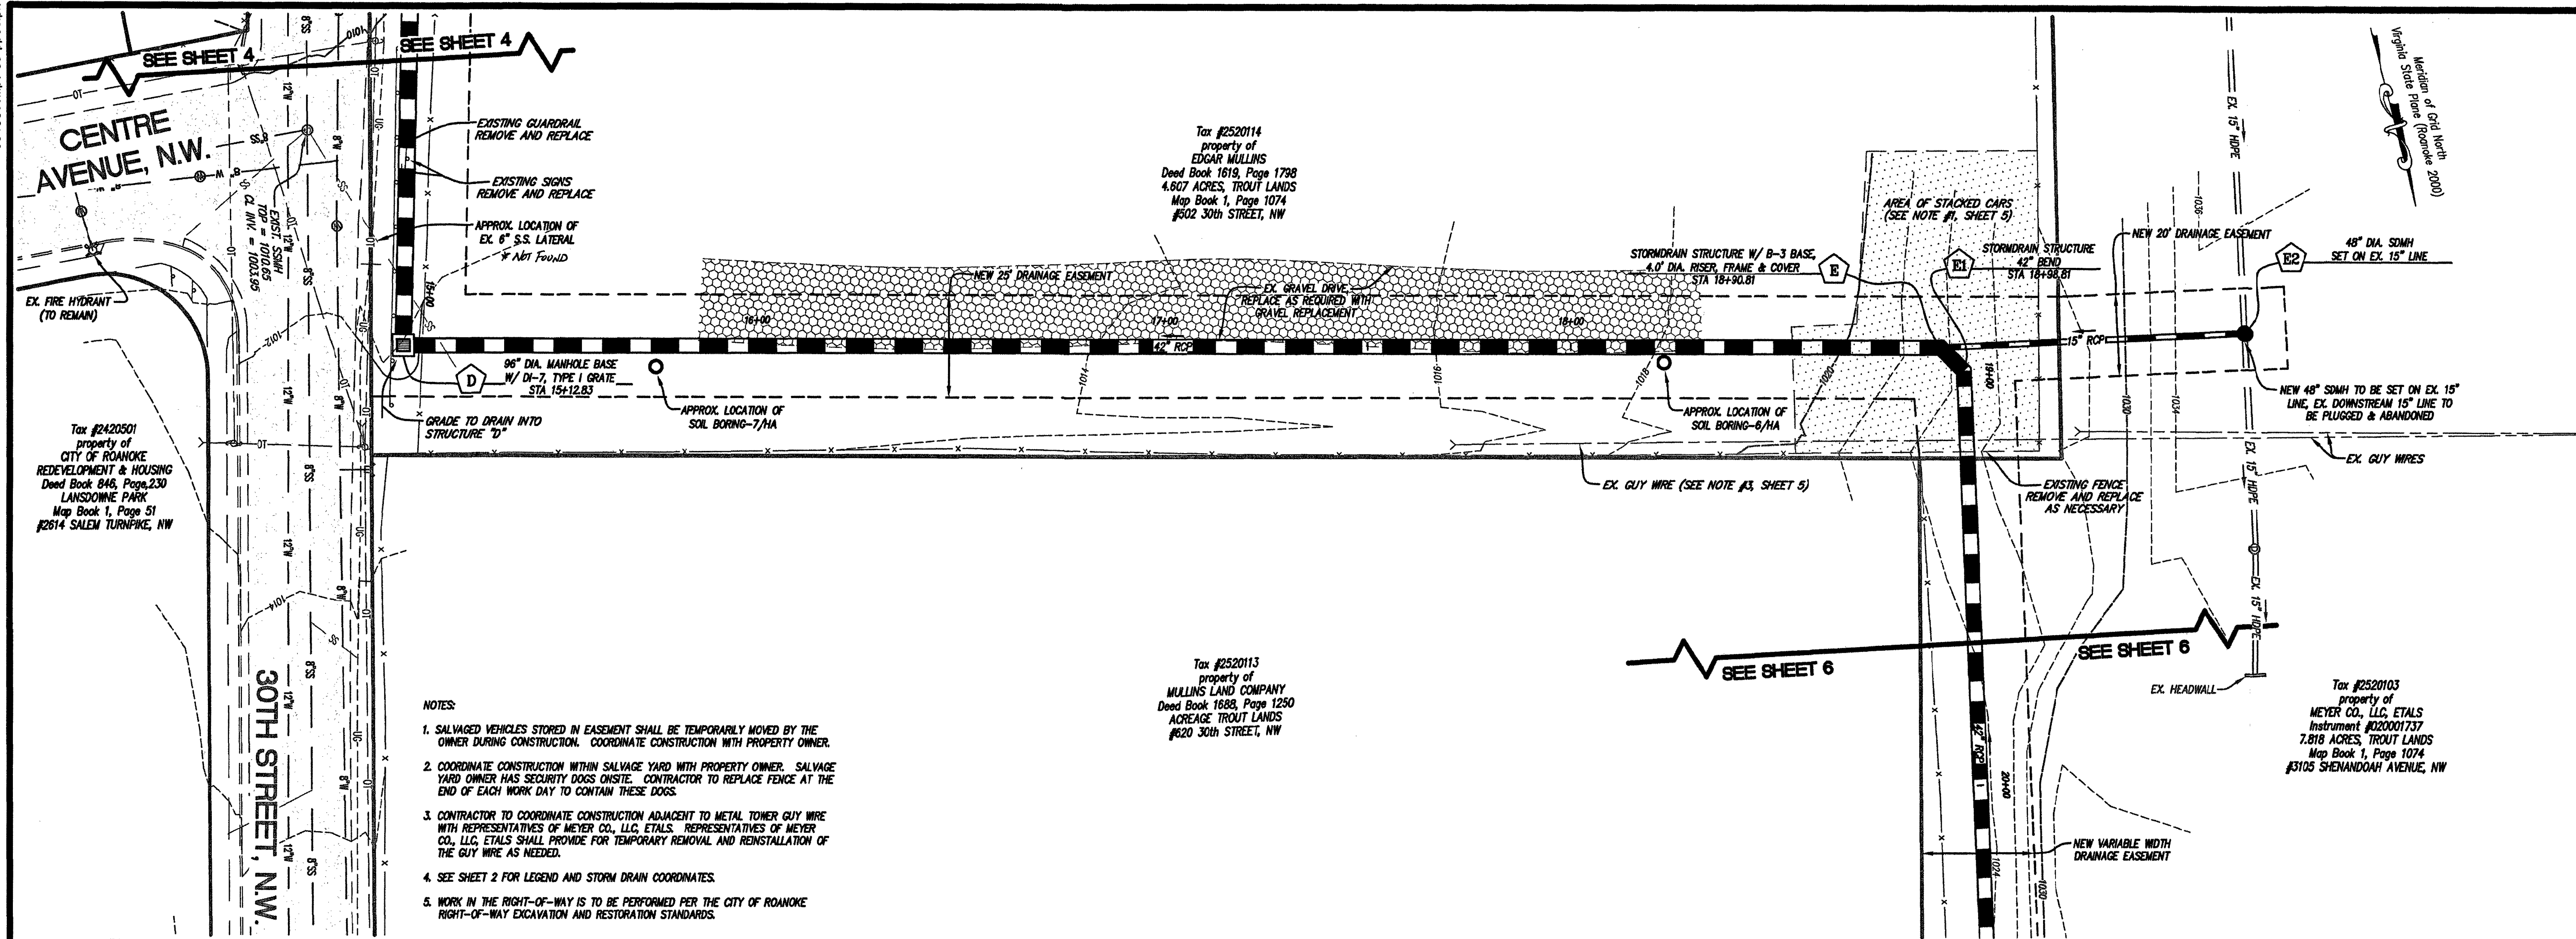

LUMSDEN ASSOCIATES, P.C.
ENGINEERS-SURVEYORS-PLANNERS
ROANOKE, VIRGINIA

COMMONWEALTH OF VIRGINIA
THOMAS C. DALE
Lic. No. 033002
2/5/13
PROFESSIONAL ENGINEER

SALEM TURNPIKE STORM DRAINAGE PROJECT
29th STREET TO 31st STREET
PREPARED FOR
THE CITY OF ROANOKE, VIRGINIA

STORM DRAIN PLAN AND PROFILE

NO.	DATE	DESCRIPTION
1		
2		
3		
4		
5		

DATE: August 5, 2013

SCALE: 1" = 20' (H); 1" = 10' (V)

COMMISSION NO.: 99-436

SHEET 5 OF 11

APPROVED
NOV 07 2013

PHONE: (540) 774-4411
FAX: (540) 772-9445
E-MAIL: MAIL@LUMSDENPC.COM

4664 BRAMBLETON AVENUE
P.O. BOX 20669
ROANOKE, VIRGINIA 24018