
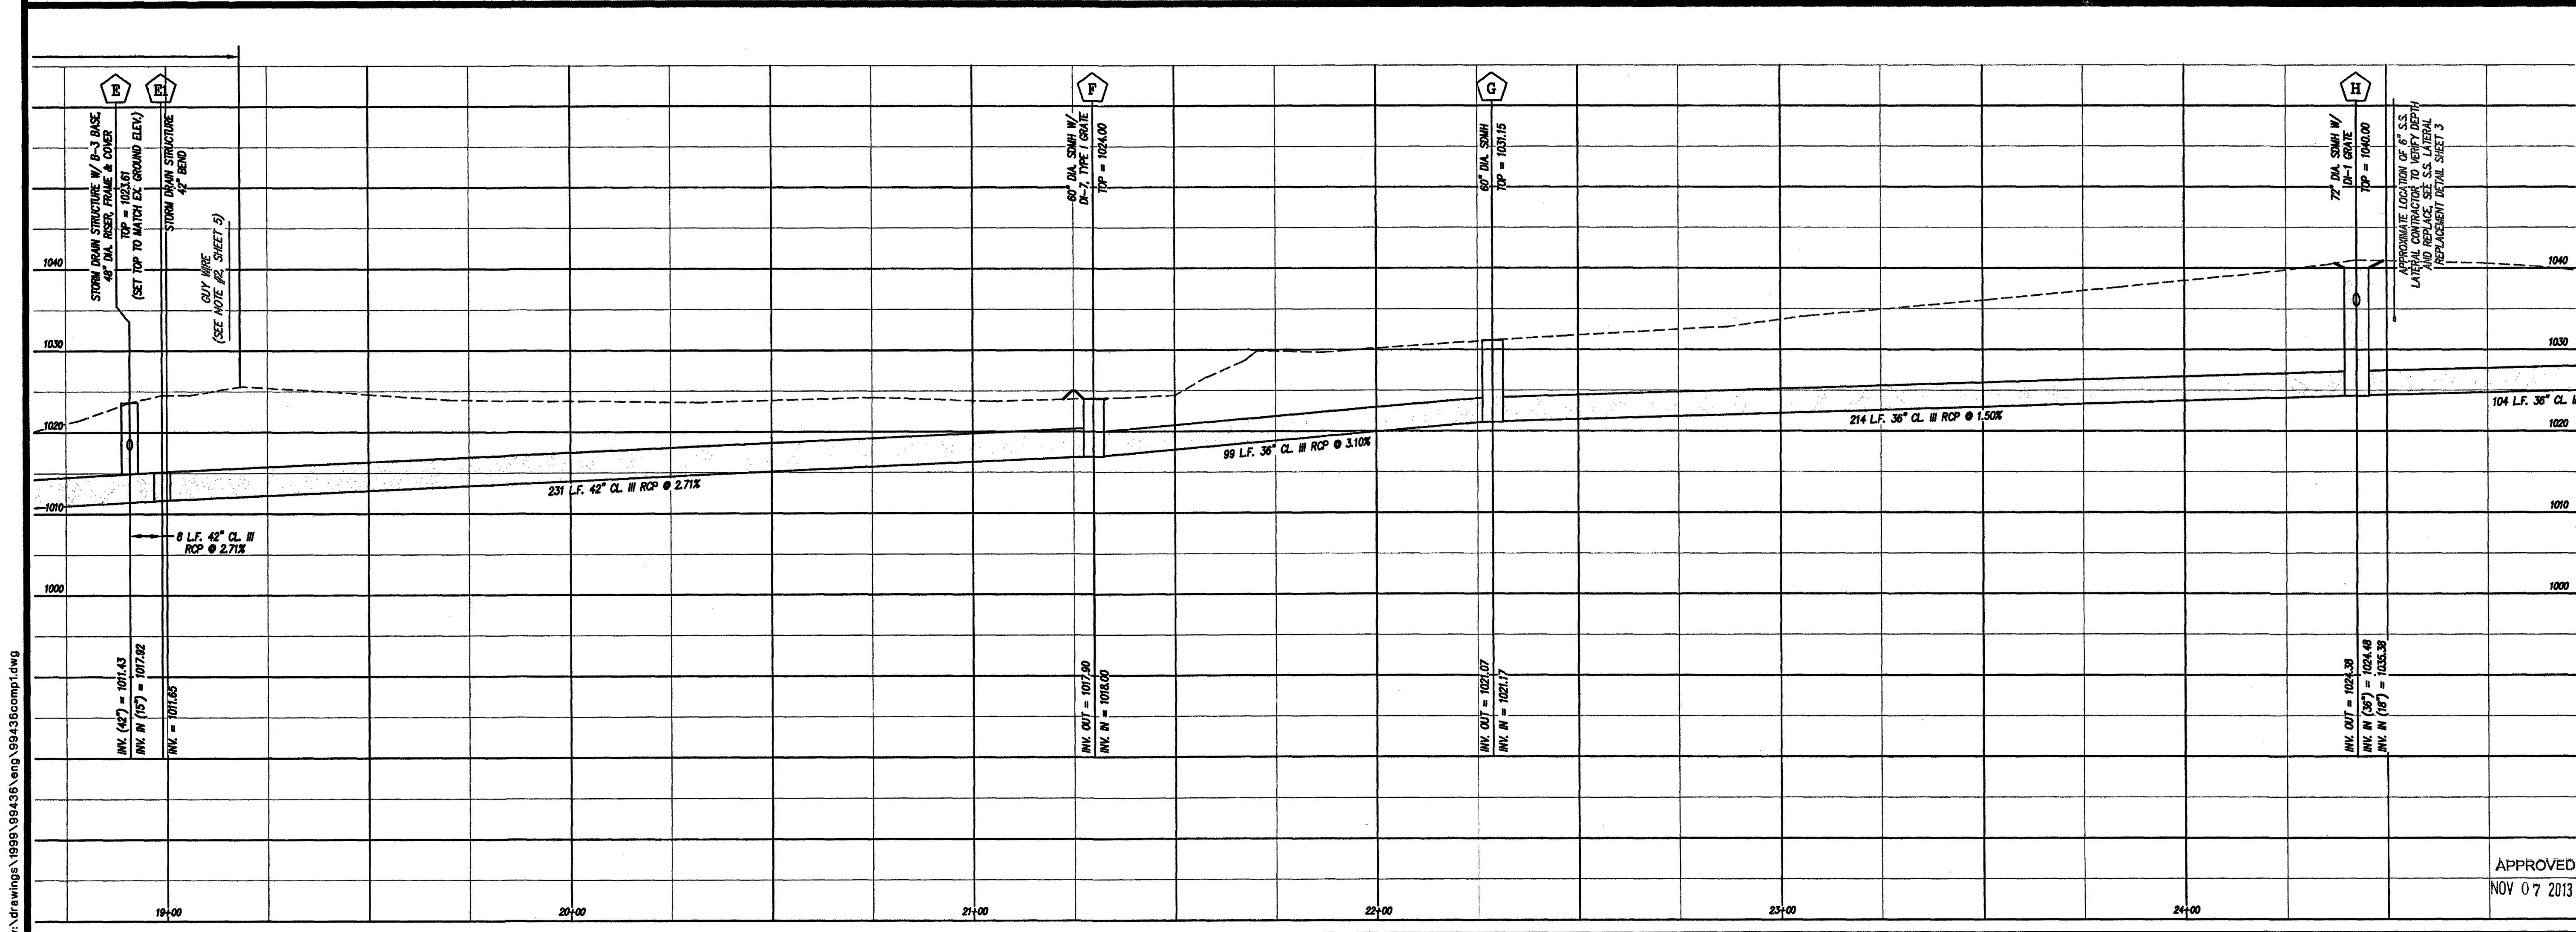


99436comp1.06-pp05.plt

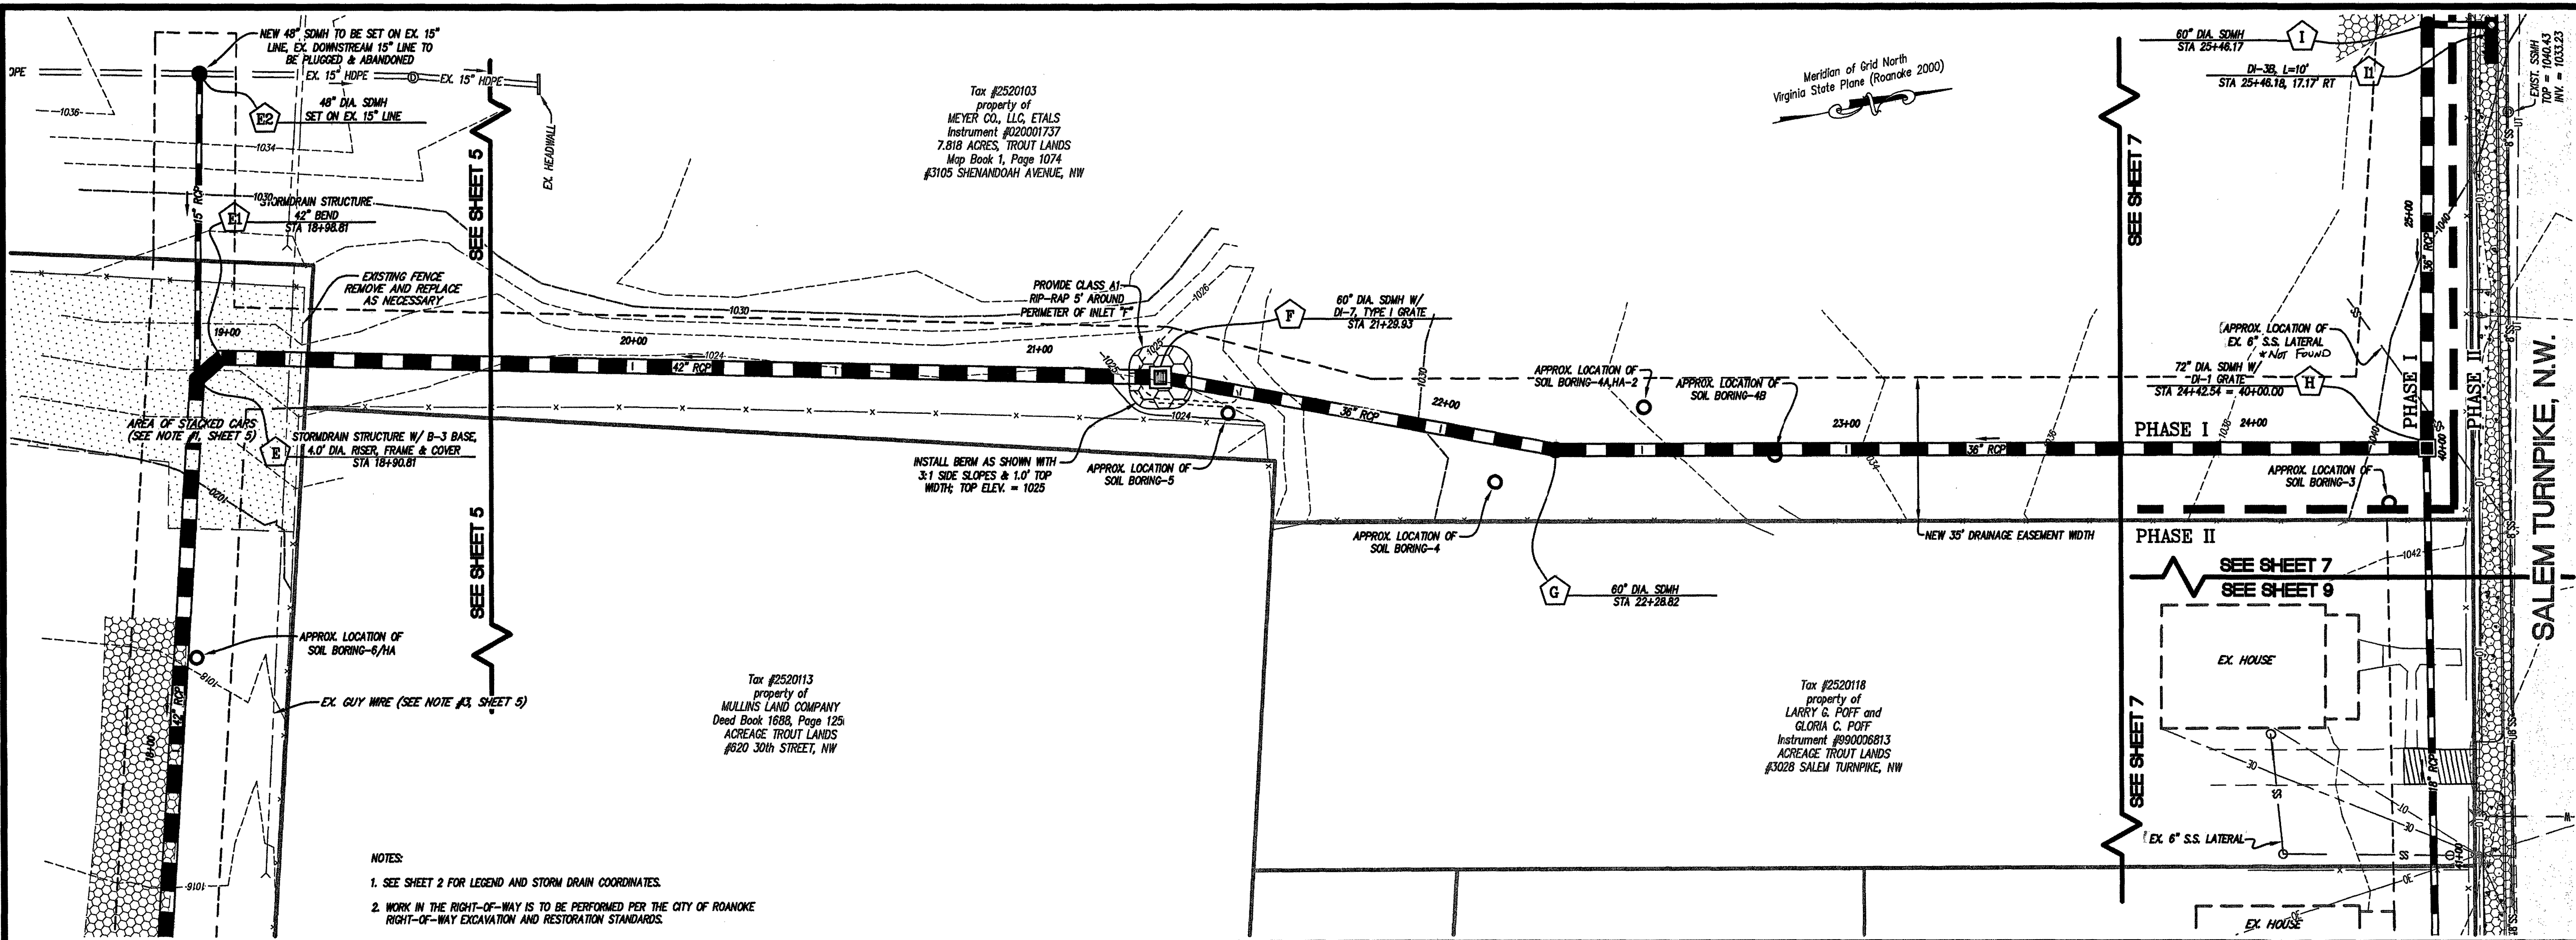

LUMSDEN ASSOCIATES, P.C.
ENGINEERS-SURVEYORS-PLANNERS
ROANOKE, VIRGINIA

THOMAS C. DALE
Lic. No. 033002
8/5/13
PROFESSIONAL ENGINEER

**STORM DRAIN
PLAN AND PROFILE**

**SALEM TURNPIKE STORM
DRAINAGE PROJECT**
29th STREET TO 31st STREET
PREPARED FOR
THE CITY OF ROANOKE, VIRGINIA

REVISIONS	
NO.	DESCRIPTION
1	
2	
3	
4	
5	

DATE: August 5, 2013
SCALE: 1" = 20' (H); 1" = 10' (V)
COMMISSION NO.: 99-436
APPROVED
NOV 07 2013
SHEET 6 OF 11

w:\drawings\1999\99436\eng\99436comp1.dwg