


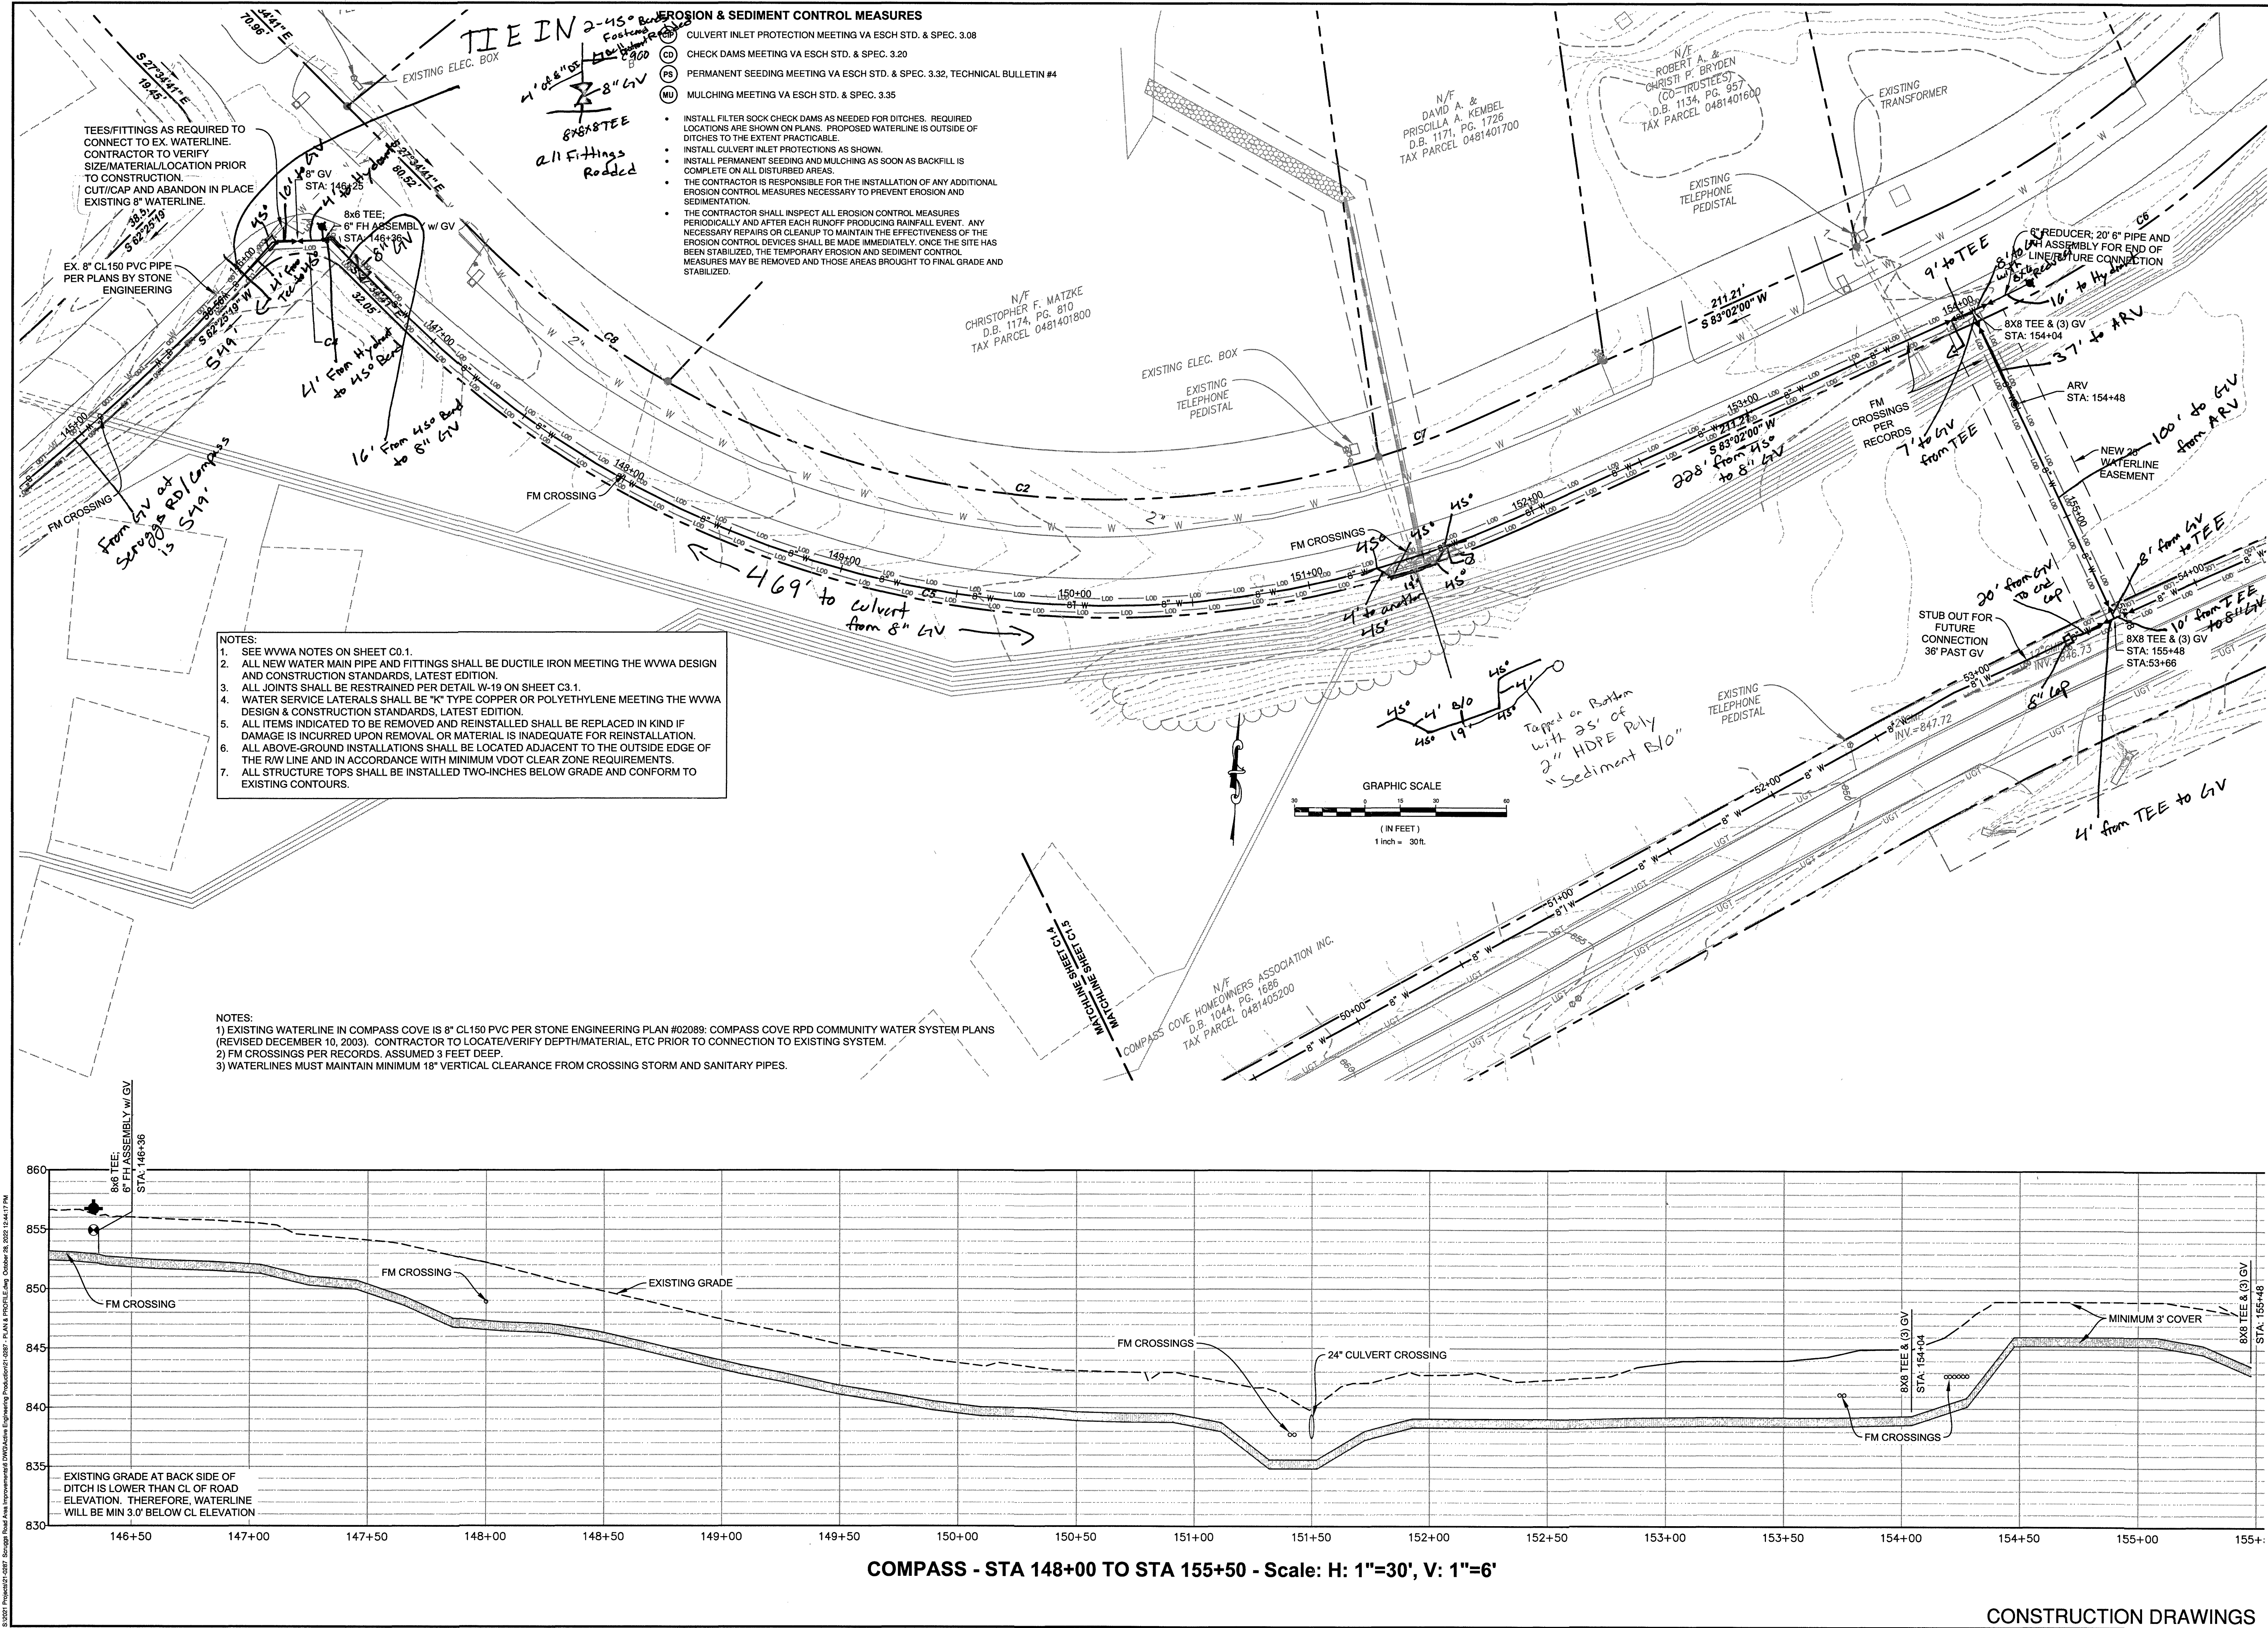

PROFESSIONAL ENGINEER
SIMON L. RUTROUGH
Lic. No. 050774
10/26/2022

parker
DESIGN GROUP
ENGINEERS + SURVEYORS
PLANNERS + LANDSCAPE ARCHITECTS
2122 Carolina Ave. SW
Roanoke, VA 24014
(540)-387-1153
1915-B W. Cary Street
Richmond, VA 23220
(804)-358-2947
www.parkergd.com

These documents are the property of Parker Design Group (PDG) and may not be reproduced or used without the express permission of PDG. Any reuse of these documents without authorization of PDG will be at the sole risk of the individual or entity utilizing said documents.

SCRUGGS ROAD AREA IMPROVEMENTS
WINDMERE - COMPASS COVE - BERNARD'S LANDING
WATER MAIN EXTENSION & PRV SITES
PREPARED FOR WESTERN VIRGINIA WATER AUTHORITY
FRANKLIN COUNTY, VIRGINIA

REVISIONS

NO.	DESCRIPTION	DATE
1	REALIGNMENT - COMPASS COVE	OCTOBER 26, 2022

DESIGNED BY: CEP
DRAWN BY: CEP
CHECKED BY: JDE & BLR
SCALE: 1" = 30'
DATE: AUGUST 12, 2022
PROJECT NUMBER: 21-0287
SHEET TITLE: PLAN AND PROFILE STA 148+00 TO STA 155+50

C1.9