


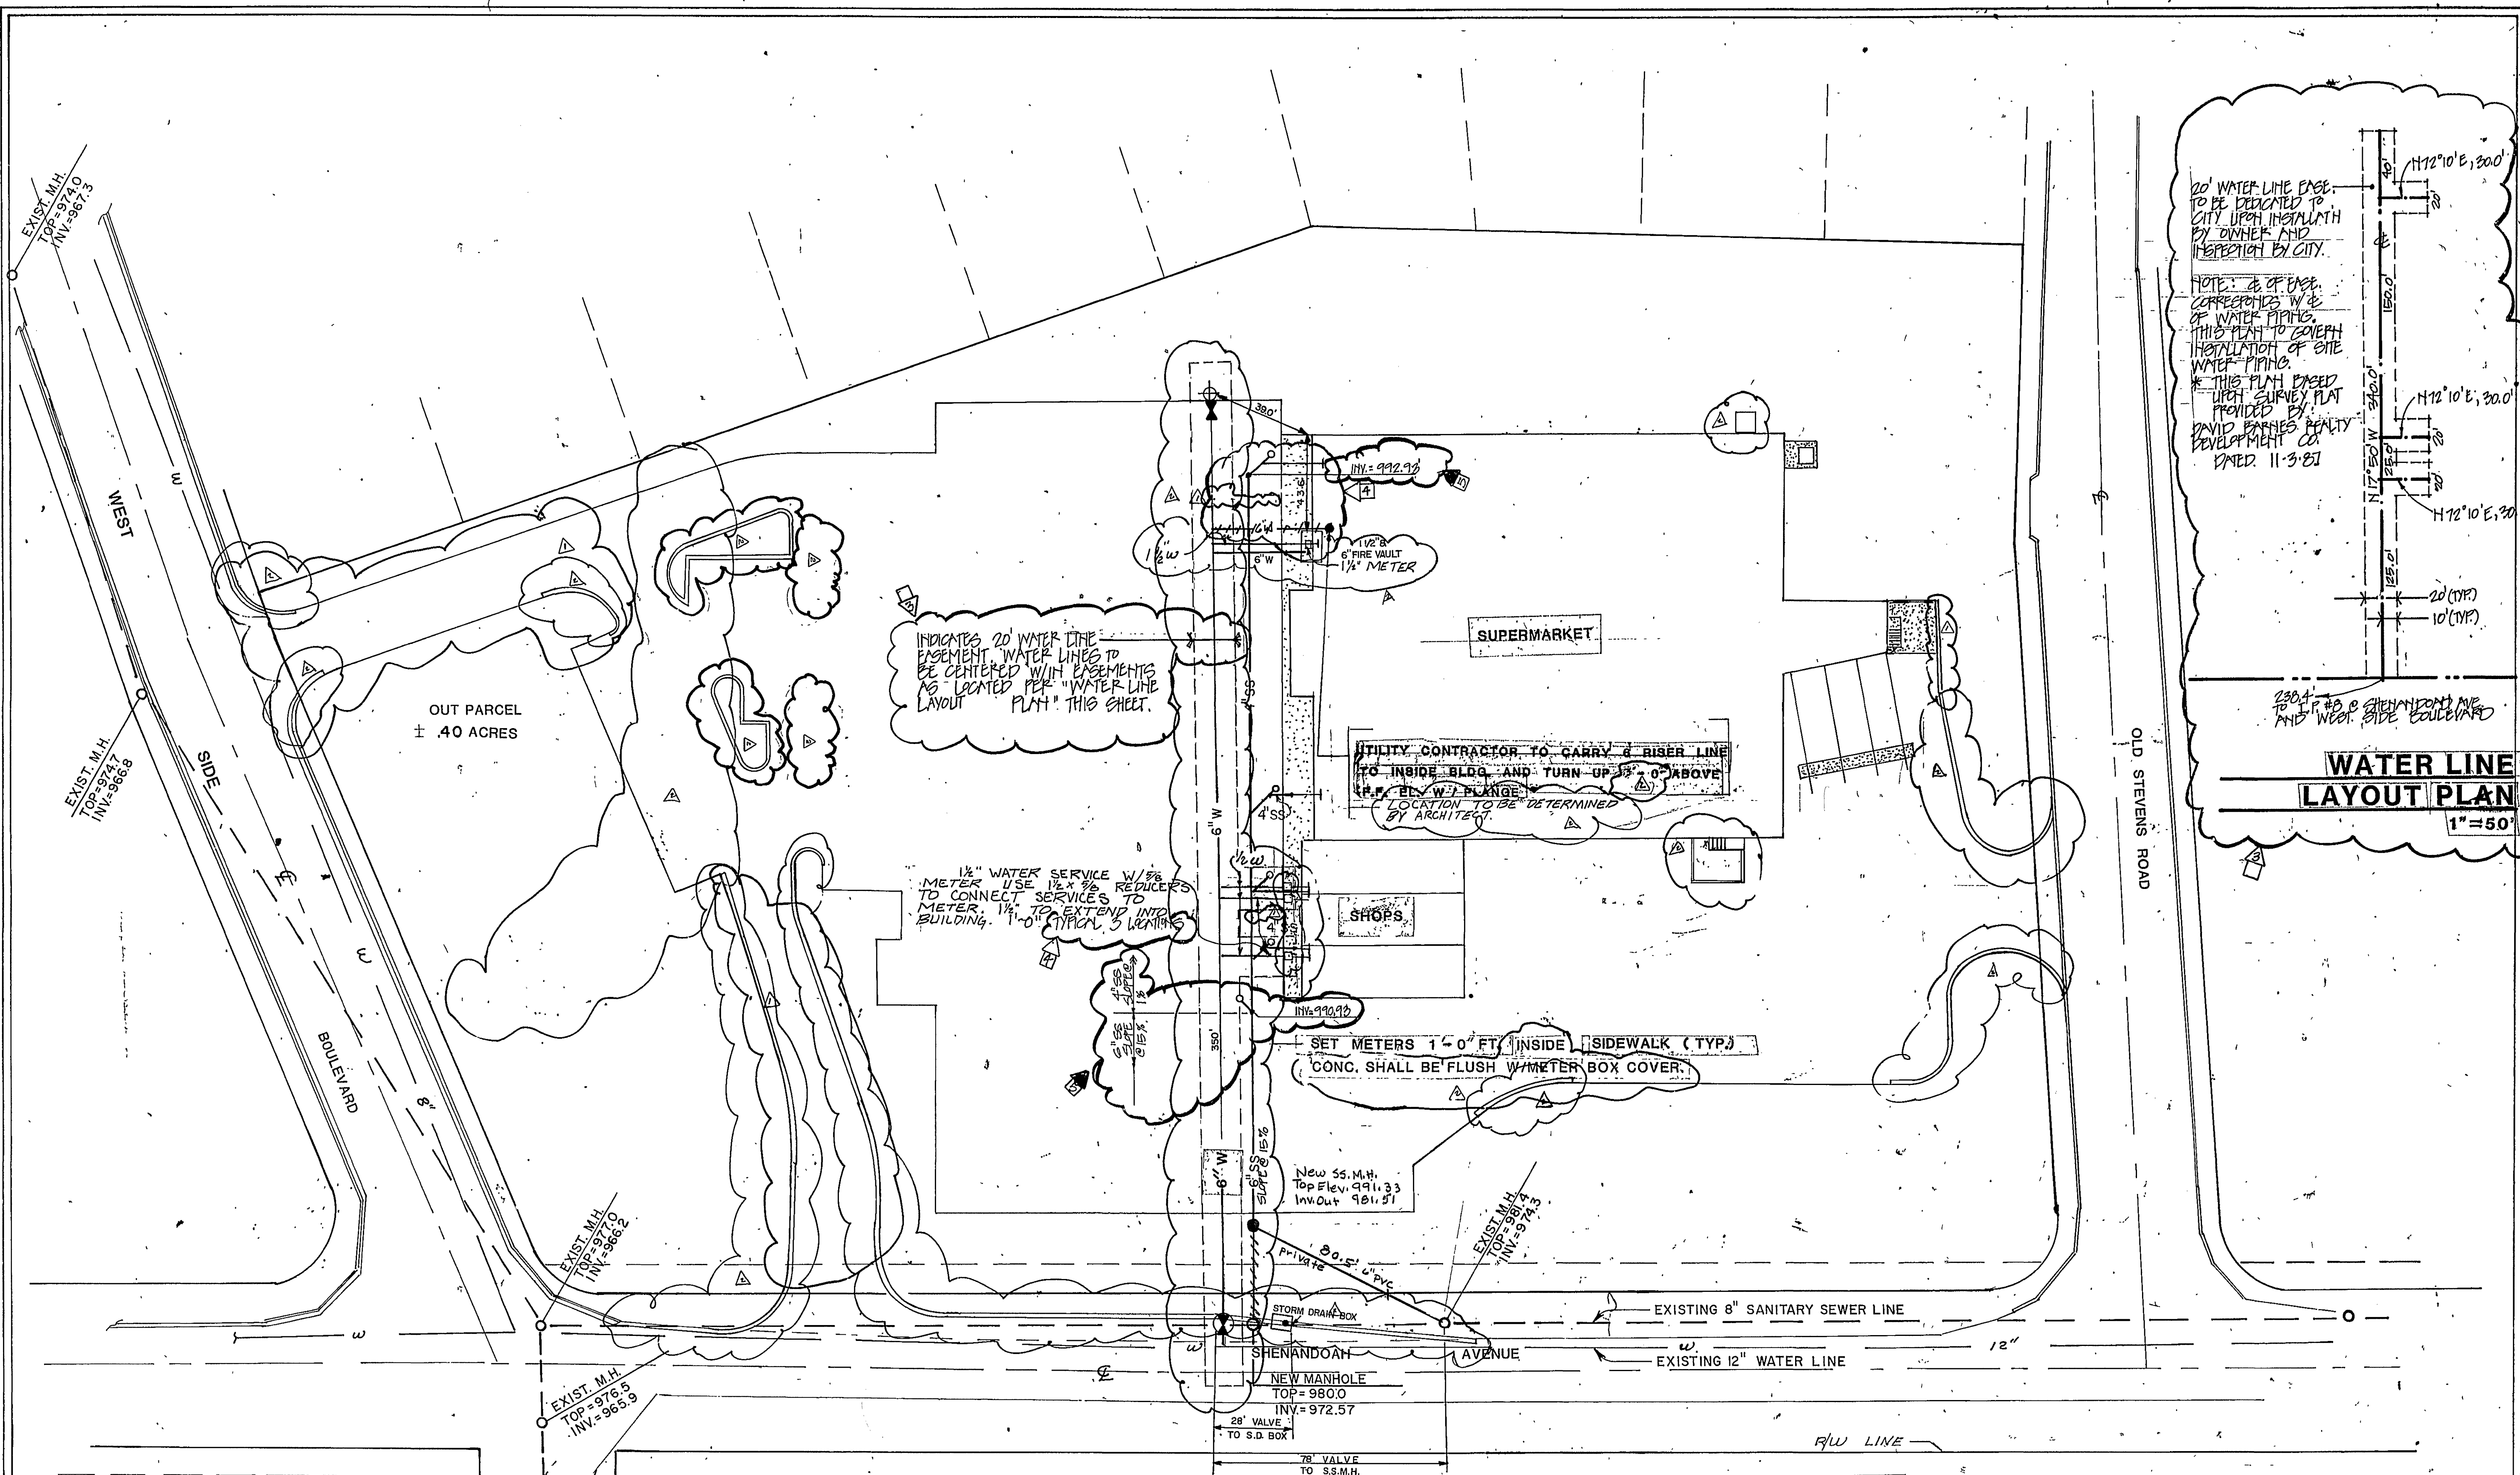

- GENERAL NOTES - SITE UTILITY**
- UTILITY CONTRACTOR IS RESPONSIBLE FOR CONTACTING LOCAL UTILITIES PRIOR TO INSTALLATION TO EACH UTILITY.
 - UTILITY CONTRACTOR IS TO VERIFY LOCATION OF ALL EXISTING UTILITIES PRIOR TO CONSTRUCTION.
 - UTILITY CONTRACTOR IS TO TERMINATE ALL UTILITIES 5 FEET OUTSIDE OF BUILDING AND CAP UNTIL SUCH TIME AS NEEDED. UNLESS OTHERWISE NOTED.
 - INSTALLATION OF UTILITIES IS TO CONFORM TO ALL STATE AND LOCAL CODES.
 - SHOULD ANY CONFLICTS IN PIPE CROSSINGS OCCUR, IT IS THE RESPONSIBILITY OF THE CONTRACTOR TO NOTIFY THE ENGINEER IMMEDIATELY PRIOR TO INSTALLATION.
 - SEE SHEET C-8 FOR PIPE INSTALLATION DETAILS.
 - ALL DIMENSIONS ARE MEASURED FROM FACE OF CURB.

- CONSTRUCTION OF SANITARY SEWER AND PAVEMENT REPLACEMENT TO BE IN ACCORDANCE WITH CITY OF ROANOKE SPECIFICATIONS.
- CONTRACTOR SHALL VERIFY LOCATION OF ALL UTILITIES PRIOR TO CONSTRUCTION.

UTILITY PLAN
(SCALE: 1" = 30')

LEGEND

CONC. SIDEWALK	4" SS
SANITARY SEWER LINE	2" W
WATER LINE	
WATER METER	
FIRE HYDRANT	
SANITARY SEWER CLEANOUT	
WATER VALVE	

AS-BUILT				
DATE SURVEYED	2-15-88			
DATE COMP.	4-5-88			
FILE NAME	SIZE	VALUE	UNIT	BOX
350'	6"	1	1	
FILE NAME OF 1.000				
FILE COMP.				
FILE STUD				
FILE ONLY				
FILE INS. BY	H.T. BOWLING			
FILE THIS BY				
FILE SERV. INS.				
FILE OR CO.	CITY			
FILE INSP.	ENGINEERING - BILL DIVERS			

WATER DEPARTMENT #88-01

no.	revision	date
1	DATE SURVEYED	9-9-87
2	DATE DRAWN	10-5-87
3	DATE CHECKED	11-23-87
4	DATE APPROVED	12-17-87
5	DATE INSP.	1-6-88
6		
7		
8		
9		
10		
11		
12		
13		
14		
15		
16		
17		
18		

SHOPPING CENTER
SHENANDOAH & WEST SIDE BLVD
ROANOKE, VA

architecture, planning
interior design, graphics
chattanooga, tennessee
phone - 615-265-4313

artech design group, incorporated

COMMONWEALTH OF VIRGINIA
J. DAVID HUDSON
No. 006103
ARCHITECT

job no. 87-126
date 8-27-87
drawn A.L.
ch'k G.A.H.
sheet: C-3
of 1/A