


LIGHTING FIXTURE SCHEDULE										
FIX NO.	MANUF. OR APPROVED	CATALOG SERIES NUMBER	VTL	LAMPS NO. & SIZE	FINISH	MTC				REMARKS
						C	W	R	P	
A	FOCAL POINT	FEQ 22 B 2 TSHO E 277 ?? AL LB35 WH	277	(2) T5-HO SP35	WHITE			X		2x2 INDIRECT/DIRECT CORRIDOR FIXTURE
B	LITHONIA	AW 3 32 AR MVOLT GEB01S	277	(3) GE F32T8 SP35	WHITE	X				ARCHITECTURAL WRAPAROUND
C	FOCAL POINT	FV35 DR2 2TSHO 1C 277 E C24 EC WH 4'	277	(2) T5-HO SP35	WHITE			X		LINEAR PENDANT WITH PARABOLIC LOUVERS BOX DOWNLIGHT, 20K UPLIGHT, 24" CABLE HANGER
D	GUTH	VPW 42T	120	(1) 42W CFL	WHITE		X			ELEVATOR PIT LIGHT
F	LITHONIA	LF8 2/26T1RT F803 MVOLT GEB10	277	(2) 26W T1RT FLUOR	WHITE		X			8" FLUORESCENT DOWNLIGHTING IN LOBBY
H	FOCAL POINT	FV3W DR2 2T5 1C 277 E WM LB35 WH 12"	277	(2) T5 SP35	WHITE	X				WALL MOUNTED LINEAR FLUORESCENT FIXTURE WITH PARABOLIC LOUVERS
J	LITHONIA	LF8 2/26DTT F602 MVOLT GEB10	277	2-26W DTT FLUOR	WHITE		X			6" RESTROOM FLUORESCENT DOWNLIGHT
K	LITHONIA	FIXTURE SELECTED BY OWNER	277	(2) GE F32T8 SP35	WHITE		X			ENTRANCE WALL SCONCE \$600.00 ALLOWANCE
L		FIXTURE SELECTED BY OWNER								DECORATIVE PENDANT FIXTURE \$600.00 ALLOWANCE
S1	ANTIQUE	ES22ST 100W MED QPC SR3 70W SF HS ANBK WITH EAC/A ANBK POLE TOP BRACKET POLE: EPAX 16 S4 5-3/8TTL ANBK	277	(1) 100W M.H.	BLACK					SITE LIGHTING - ANTIQUE POLE MOUNTED FIXTURE WITH HOUSE SIDE SHIELD - FULL CUTOFF FIXTURE 16'-0" ROUND POLE
S2	ANTIQUE	ES22ST 70W MED QPC SR3 70W SF HS ANBK WITH EAC/A ANBK WALL BRACKET	277	(1) 70W M.H.	BLACK					SITE LIGHTING - ANTIQUE BUILDING MOUNTED FIXTURE WITH HOUSE SIDE SHIELD - FULL CUTOFF FIXTURE
S3	ANTIQUE	ES22ST 100W MED QPC SR3 70W SF ANBK WITH EAC/A ANBK POLE TOP BRACKET POLE: EPAX 10' SF 5-3/8TTL ANBK	277	(1) 100W M.H.	BLACK					SITE LIGHTING - ANTIQUE POLE MOUNTED FIXTURE FULL CUTOFF FIXTURE 10'-0" ROUND POLE
X1	LITHONIA	LDM-S-W-3-R-120/277 ELM	120	LED5 INCLUDED	WHITE					EXIT SIGN


- 1) VERIFY ARROWS FOR EACH SIGN AND PROVIDE AS NECESSARY
- 2) SURFACE, PENDANT OR CHAIN MOUNT IN MECHANICAL ROOMS TO 5' A.F.F. COORDINATE WITH MECHANICAL, DUCTWORK, CABLE TRAYS & PIPING.

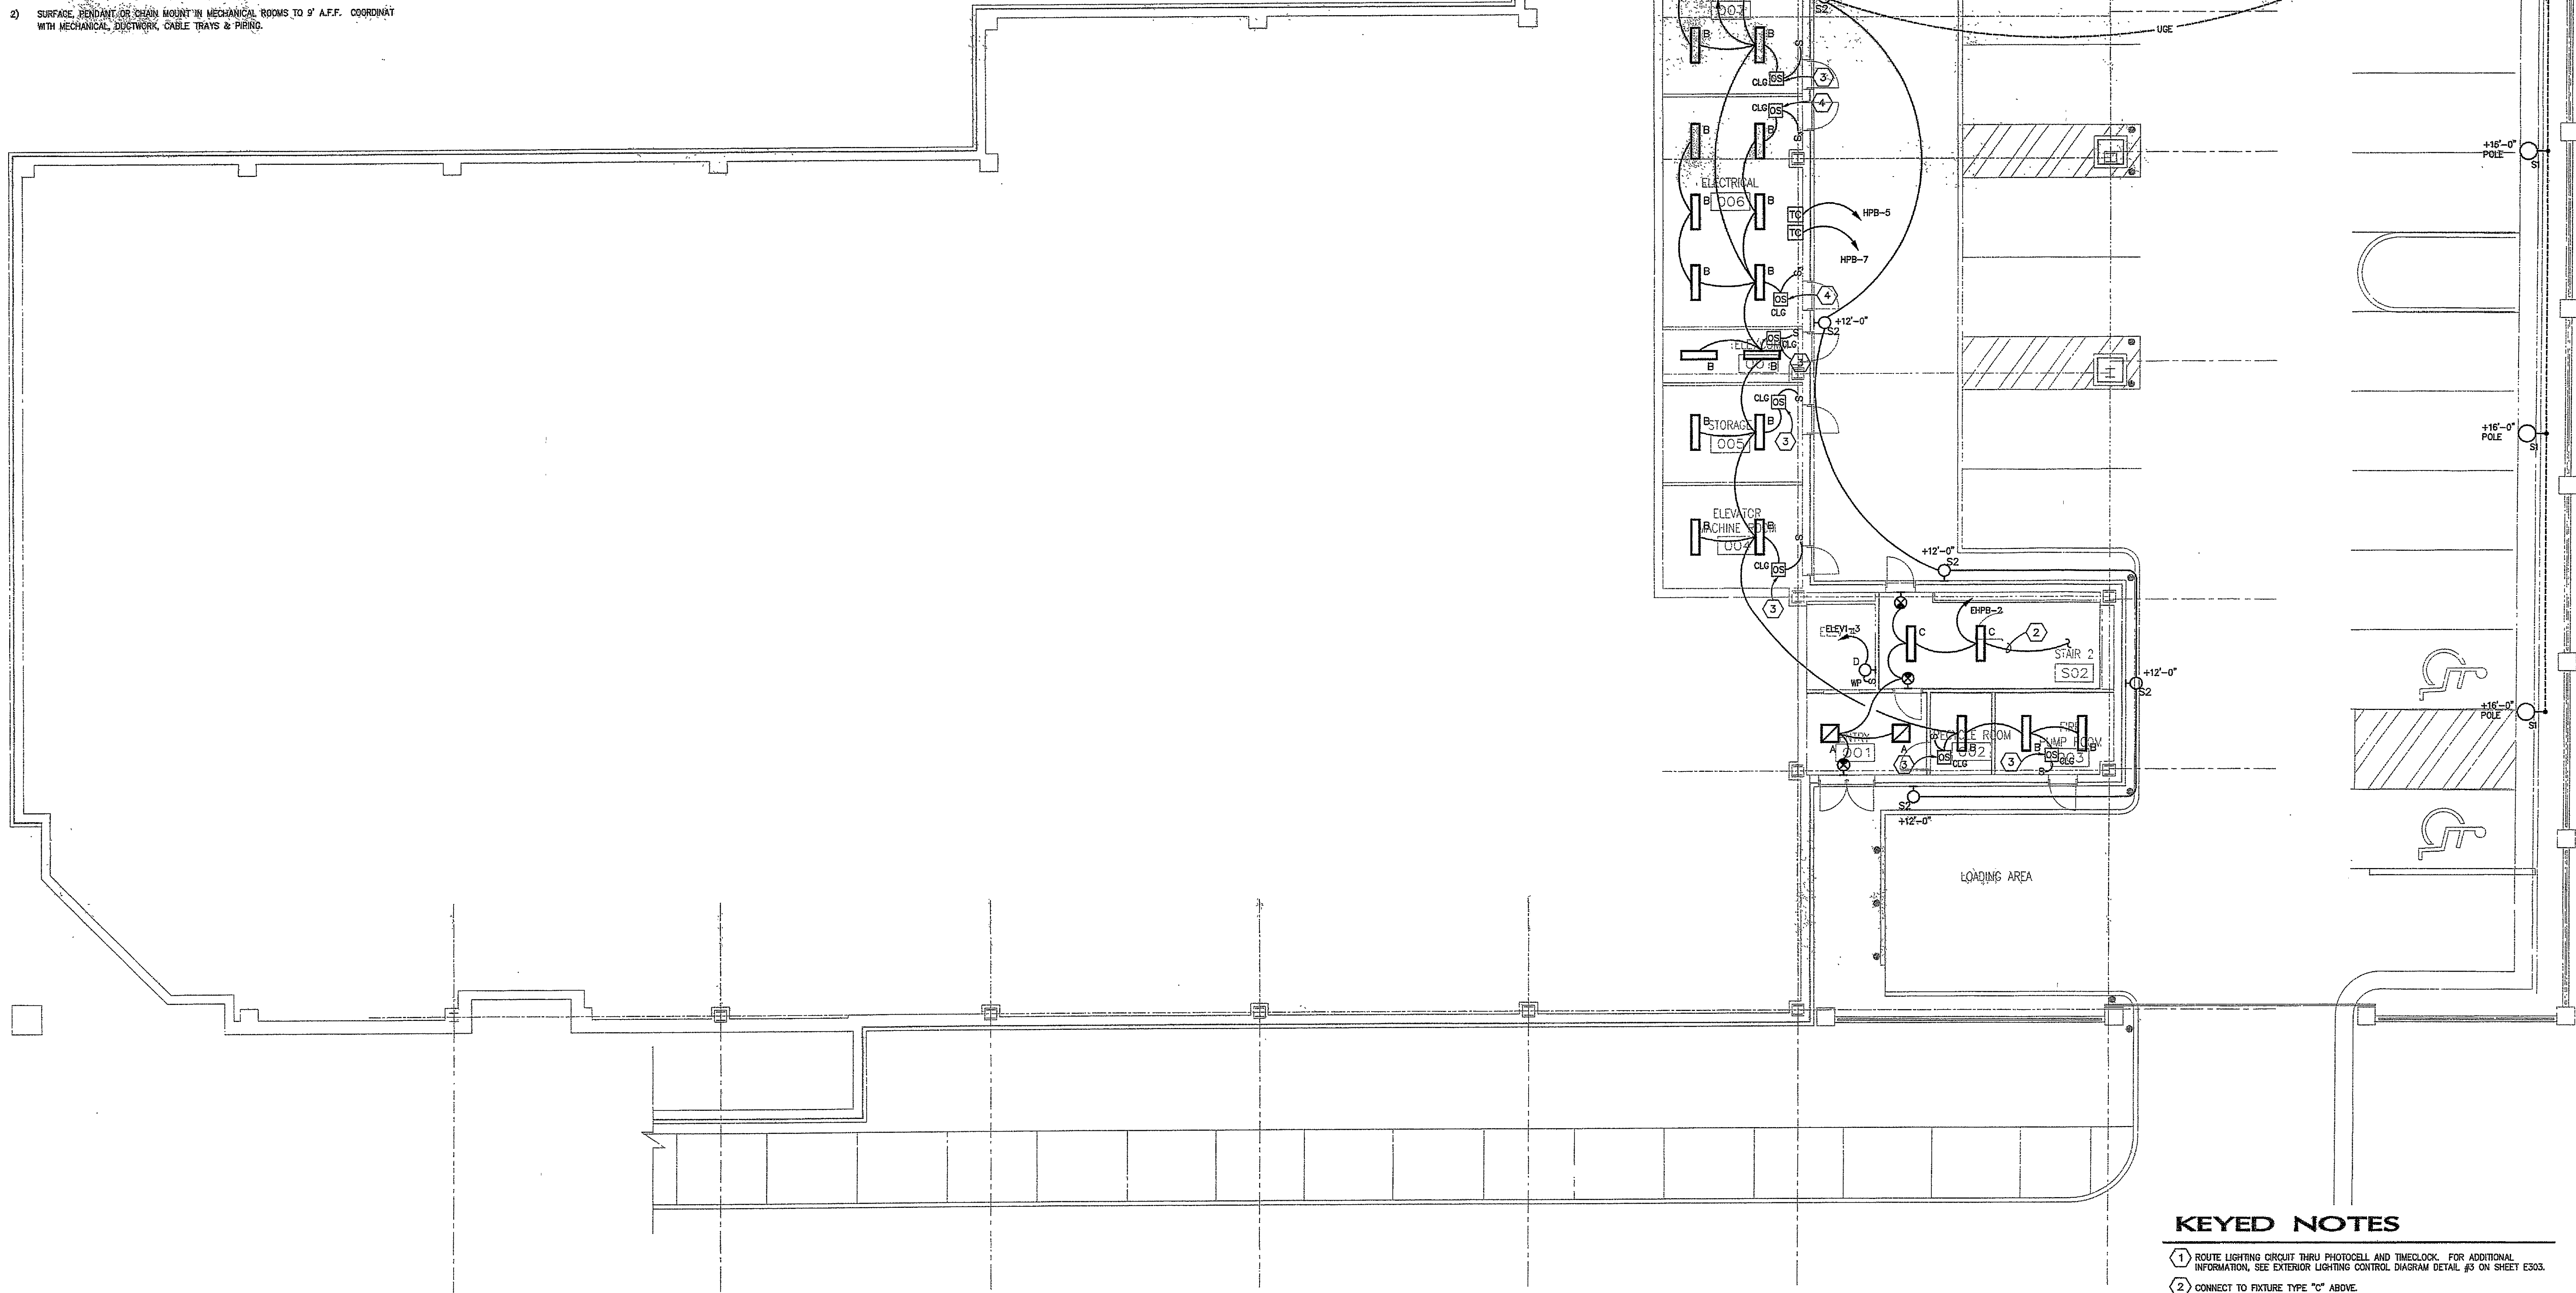

KEYED NOTES

- 1) ROUTE LIGHTING CIRCUIT THRU PHOTOCELL AND TIMECLOCK. FOR ADDITIONAL INFORMATION, SEE EXTERIOR LIGHTING CONTROL DIAGRAM DETAIL #3 ON SHEET E303.
- 2) CONNECT TO FIXTURE TYPE "C" ABOVE.
- 3) OCCUPANCY SWITCH WITH MANUAL SWITCH OVERRIDE.
- 4) THREE-WAY OCCUPANCY SWITCH WITH MANUAL THREE-WAY SWITCH OVERRIDE.

1 GROUND LEVEL LIGHTING PLAN
SCALE: 1/8" = 1'-0"

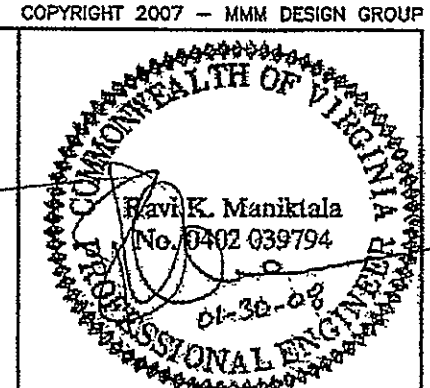

BUILDING SHELL PACKAGE
SOCIAL SECURITY ADMINISTRATION BUILDING
ROANOKE, VIRGINIA

MMM DESIGN GROUP
ARCHITECTS + ENGINEERS + PLANNERS
300 East Main Street
Norfolk, Virginia 23510
757.623.1641

Drawn: AT/TM
Checked: RC/RO
Approved:
Date: JAN 18, 2008
Proj. No: 11433.03

GROUND LEVEL LIGHTING PLAN

Sheet Number:
E100
Sheet: 000 of 999

