


BUILDING SHELL PACKAGE
SOCIAL SECURITY ADMINISTRATION BUILDING
ROANOKE, VIRGINIA

	
300 East Main Street Norfolk, Virginia 23510 757.623.1641	
Drawn:	AT/TM
Checked:	RC/RO
Approved:	
Date:	JAN 18, 2008
Proj. No:	11433.03

FIRST FLOOR LIGHTING PLAN

Sheet Number:
E101
Sheet: 000 of 999

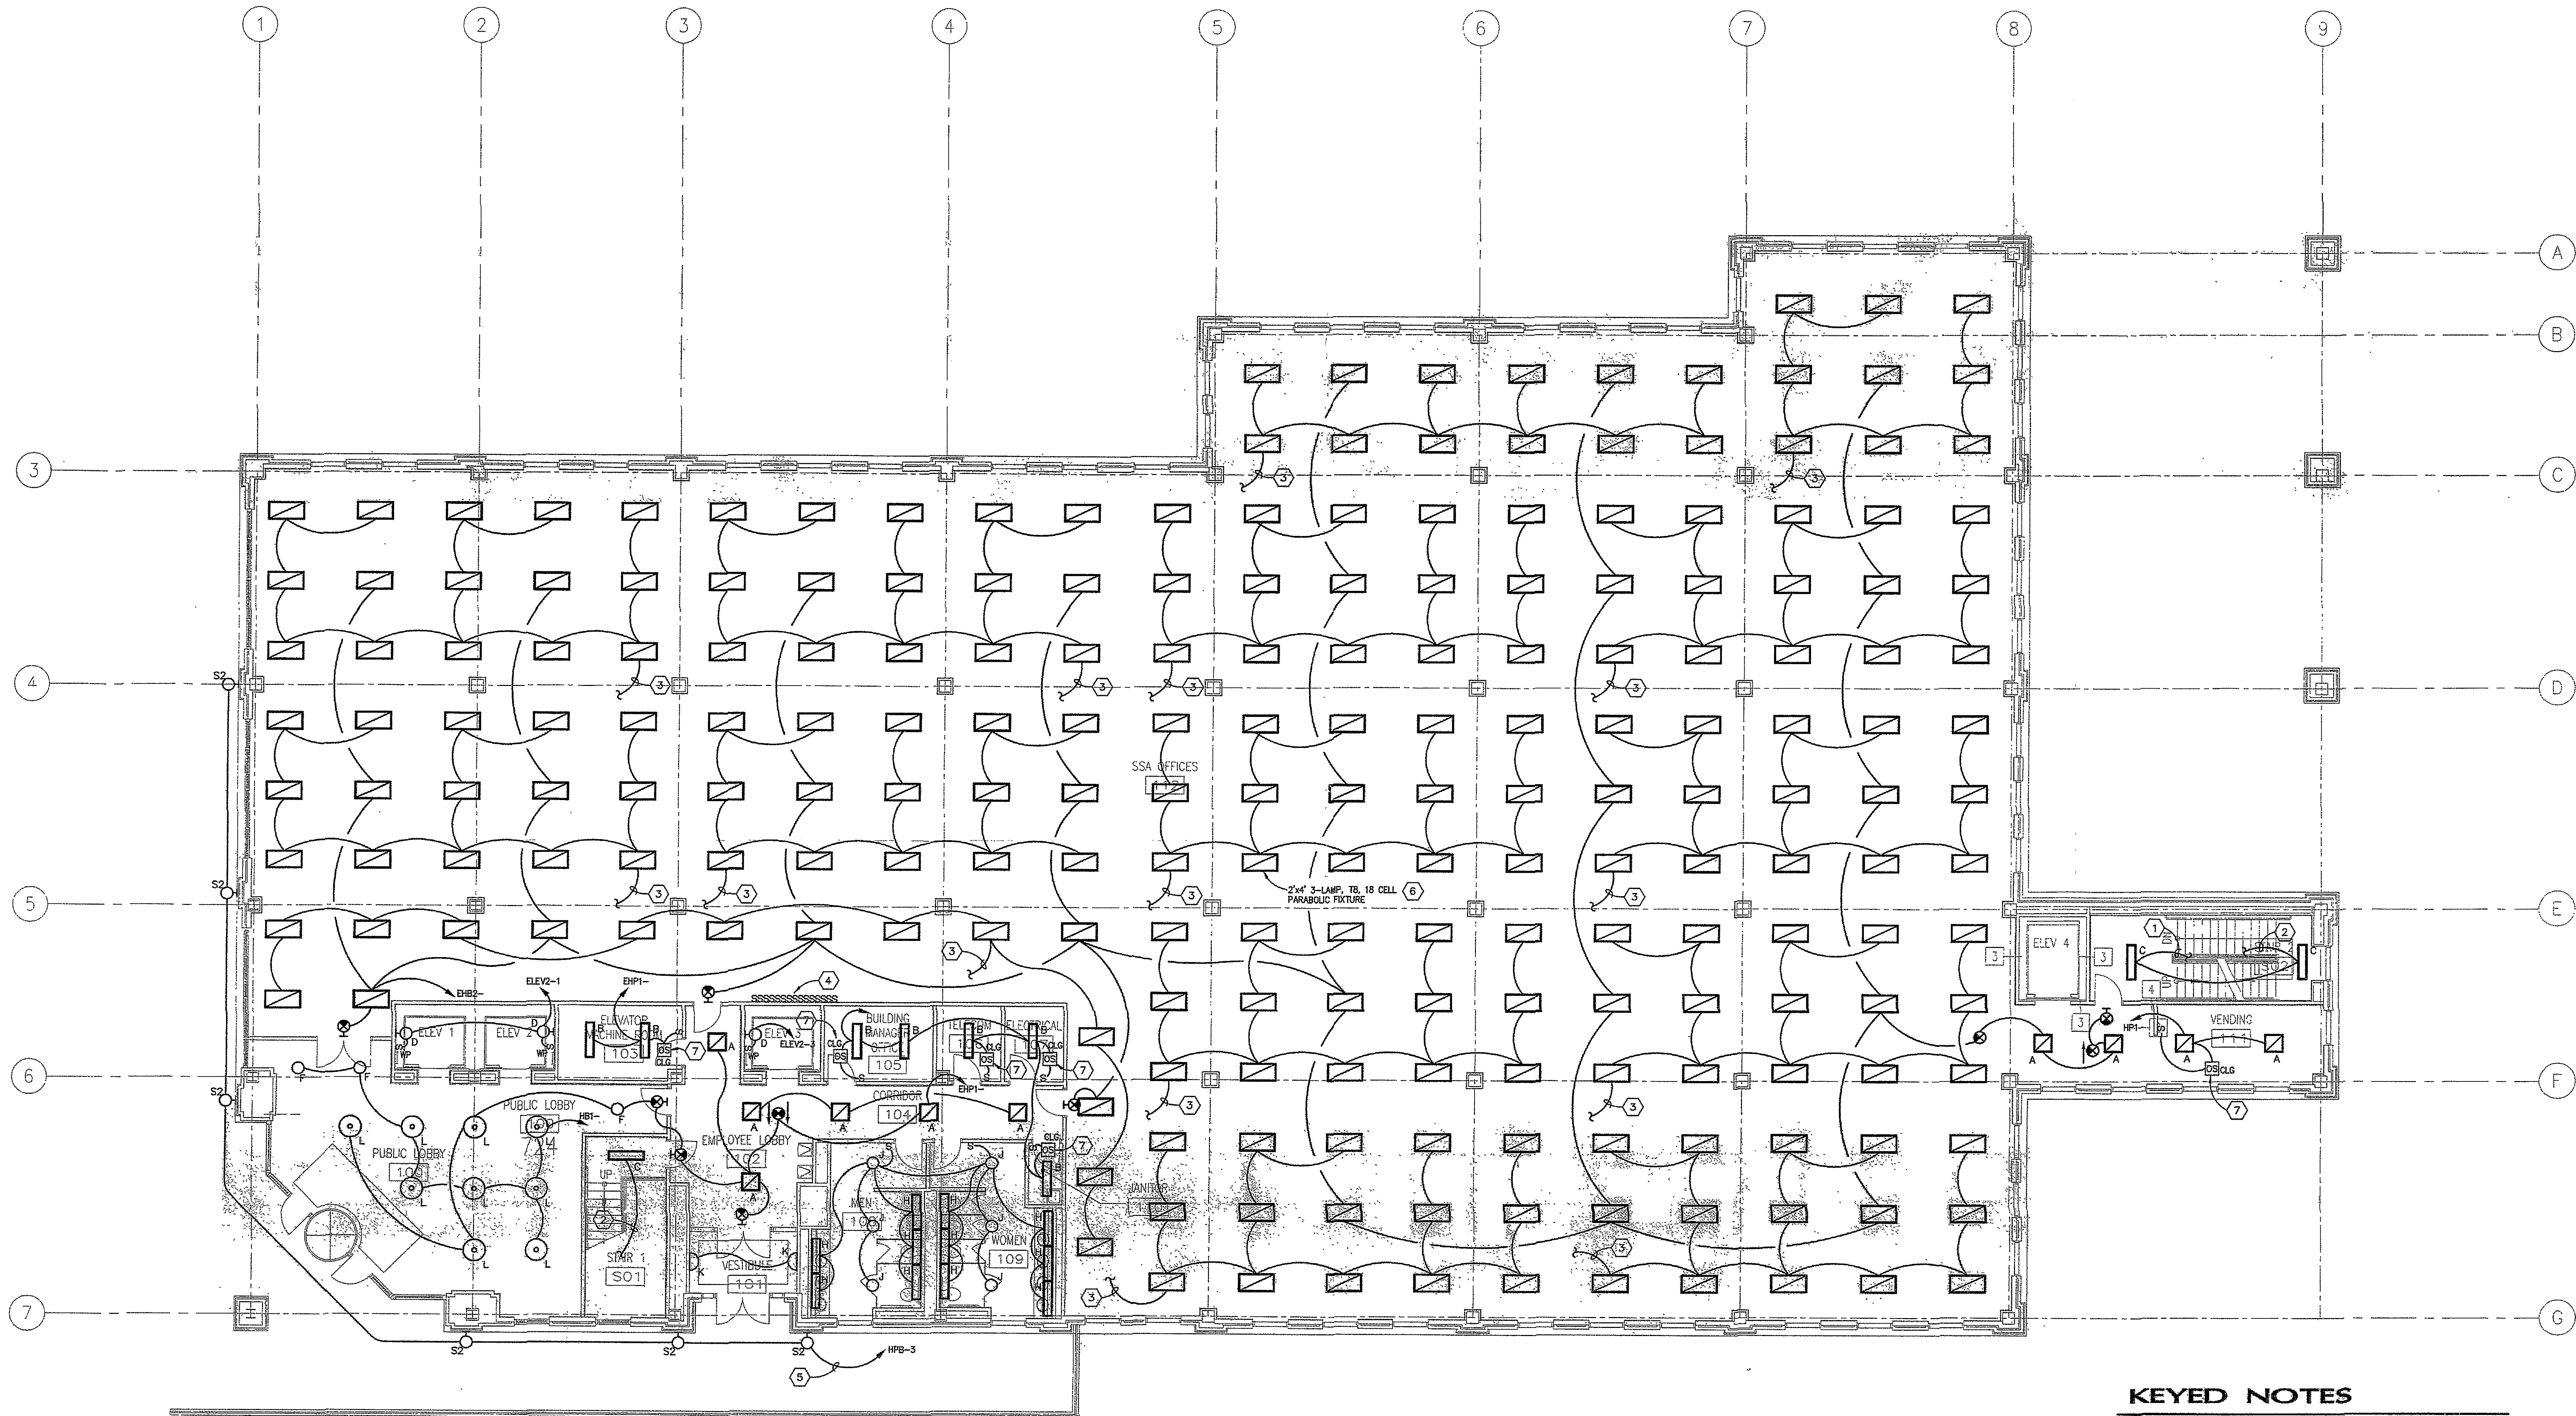

 **1** **FIRST FLOOR LIGHTING PLAN**
SCALE: 1/8" = 1'-0"

KEYED NOTES

- 1 CONNECT TO FIXTURE TYPE "C" BELOW.
- 2 CONNECT TO FIXTURE TYPE "C" ABOVE.
- 3 CONNECT LIGHTING CIRCUIT TO SUBPANEL DESIGNATED BY KEYED NOTE #4.
- 4 LIGHTING SWITCHBANK.
- 5 ROUTE LIGHTING CIRCUIT THRU SWITCHCELL AND TIMECLOCK. FOR ADDITIONAL INFORMATION, SEE EXTERIOR LIGHTING CONTROL DIAGRAM DETAIL #5 ON SHEET 80.
- 6 PARABOLIC TYPE 2'x4' FLUORESCENT LIGHTING FIXTURES SHALL BE INSTALLED IN THE CEILING GRID FOR AN OPEN OFFICE AREA AT THE RATIO OF ONE (1) 2'x4' FIXTURE PER 80 SQ/FT OFFICE AREA SQUARE FEET UNDER THE TENANT IMPROVEMENT.
- 7 OCCUPANCY SWITCH WITH MANUAL SWITCH OVERRIDE.