


DISCLAIMER:  
ALTHOUGH THIS DATA HAS BEEN TESTED BY ANDERSON & ASSOCIATES, NO WARRANTY EXPRESSED OR IMPLIED IS MADE BY ANDERSON & ASSOCIATES AS TO ITS ACCURACY, NOR SHALL THE FACT OF DISTRIBUTION CONSTITUTE ANY SUCH WARRANTY, AND NO RESPONSIBILITY IS ASSUMED BY ANDERSON & ASSOCIATES IN CONNECTION THEREWITH

# SOUTH PEAK DEVELOPMENT

## PHASE 1 WATER SYSTEM IMPROVEMENTS

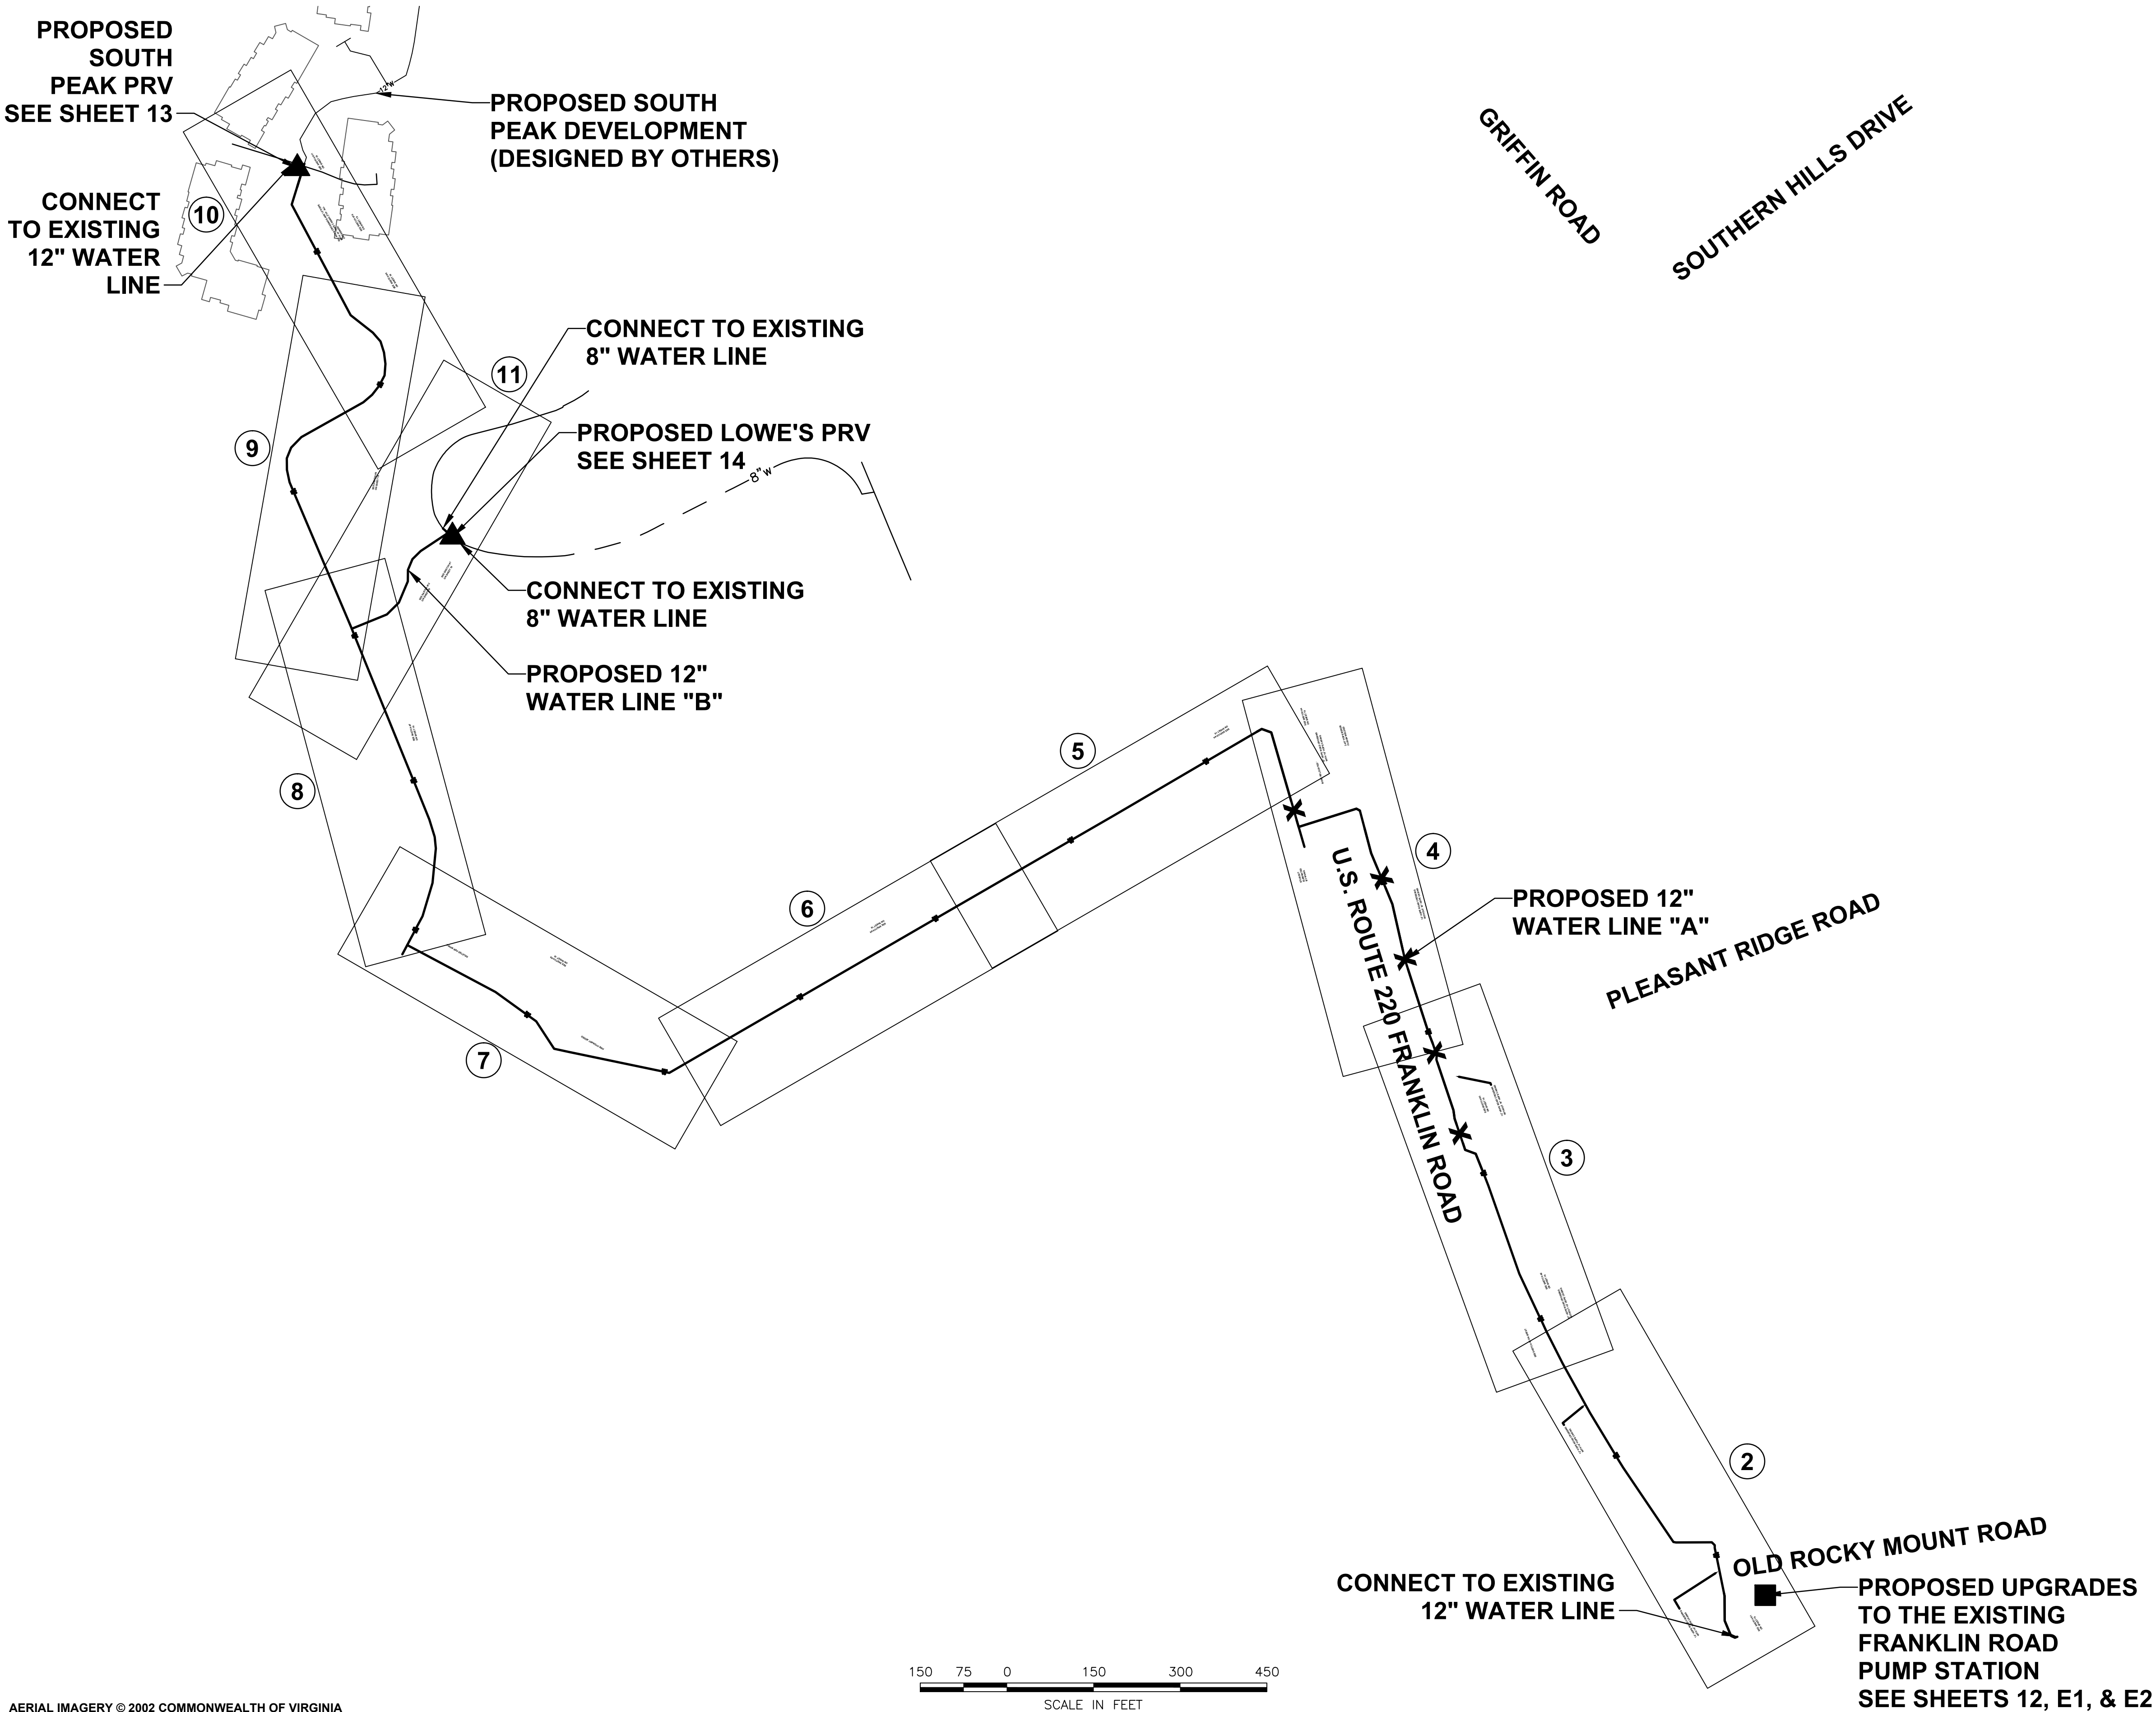

### SHEET INDEX

1. COVER SHEET
- 1A. SHEET INDEX
- 1B. PROJECT NOTES 1
- 1C. PROJECT NOTES 2
- 1D. EROSION & SEDIMENT CONTROL NOTES
- 1E. EROSION & SEDIMENT CONTROL NARRATIVE
- 1F. EROSION & SEDIMENT CONTROL DETAILS 1
- 1G. EROSION & SEDIMENT CONTROL DETAILS 2
- 1H. EROSION & SEDIMENT CONTROL DETAILS 3
- 1I. EROSION & SEDIMENT CONTROL DETAILS 4
- 1J. TRAFFIC CONTROL DETAIL
- 1K. OVERALL PARCEL & ZONING MAP
2. WATER PLAN & PROFILE SHEET  
LINE "A" STA 10+25± TO STA 16+50
3. WATER PLAN & PROFILE SHEET  
LINE "A" STA 16+50 TO STA 23+00
4. WATER PLAN & PROFILE SHEET  
LINE "A" STA 23+00 TO STA 29+00
5. WATER PLAN & PROFILE SHEET  
LINE "A" STA 29+00 TO STA 35+00
6. WATER PLAN & PROFILE SHEET  
LINE "A" STA 35+00 TO STA 41+00
7. WATER PLAN & PROFILE SHEET  
LINE "A" STA 41+00 TO STA 47+00
8. WATER PLAN & PROFILE SHEET  
LINE "A" STA 47+00 TO STA 53+00
9. WATER PLAN & PROFILE SHEET  
LINE "A" STA 53+00 TO STA 58+00
10. WATER PLAN & PROFILE SHEET  
LINE "A" STA 58+00 TO END OF LINE
11. WATER PLAN & PROFILE SHEET  
LINE "B" STA 10+00 TO END OF LINE
12. FRANKLIN ROAD PUMP STATION PLAN & SECTIONS
13. SOUTH PEAK PRV SITE PLAN & DETAIL SHEET
14. LOWE'S PRV SITE PLAN & DETAIL SHEET
15. WVWA GENERAL STANDARD DETAILS
16. WVWA WATER STANDARD DETAILS 1
17. WVWA WATER STANDARD DETAILS 2
- E1. ELECTRICAL LEGEND, ABBREVIATIONS, & SCHEMATIC
- E2. PUMP STATION POWER PLAN, MDP, MCC ONE-LINE  
AND FRONT ELEVATION

AERIAL IMAGERY © 2002 COMMONWEALTH OF VIRGINIA



**ANDERSON & ASSOCIATES, INC.**  
Professional Design Services  
www.andassoc.com

100 Ardmore St.  
Blacksburg, Va. 24060  
540-552-5592

DATE : 13 APR 12	REV. # 5	COMMENTS 1ST REVIEW	DATE 06 JUL 12
DESIGNED: BJM	6	2ND REVIEW	20 AUG 12
DRAWN : BJM		RECORD	04 SEP 13
CHECKED : DAA			
QA / QC : JKD			

SOUTH PEAK DEVELOPMENT  
PHASE I WATER SYSTEM IMPROVEMENTS

SHEET INDEX

DOCUMENT NO.	26787 — 002
1A SHEET	30
OF	

Dunford, Carmen / 12/16/2013 11:03 AM / \\opprojects\projects\26\26787\engineering\design\plans\plan\_set\26787\_south\_peak\_waterline\_sheets\_record\_drawings.dwg