

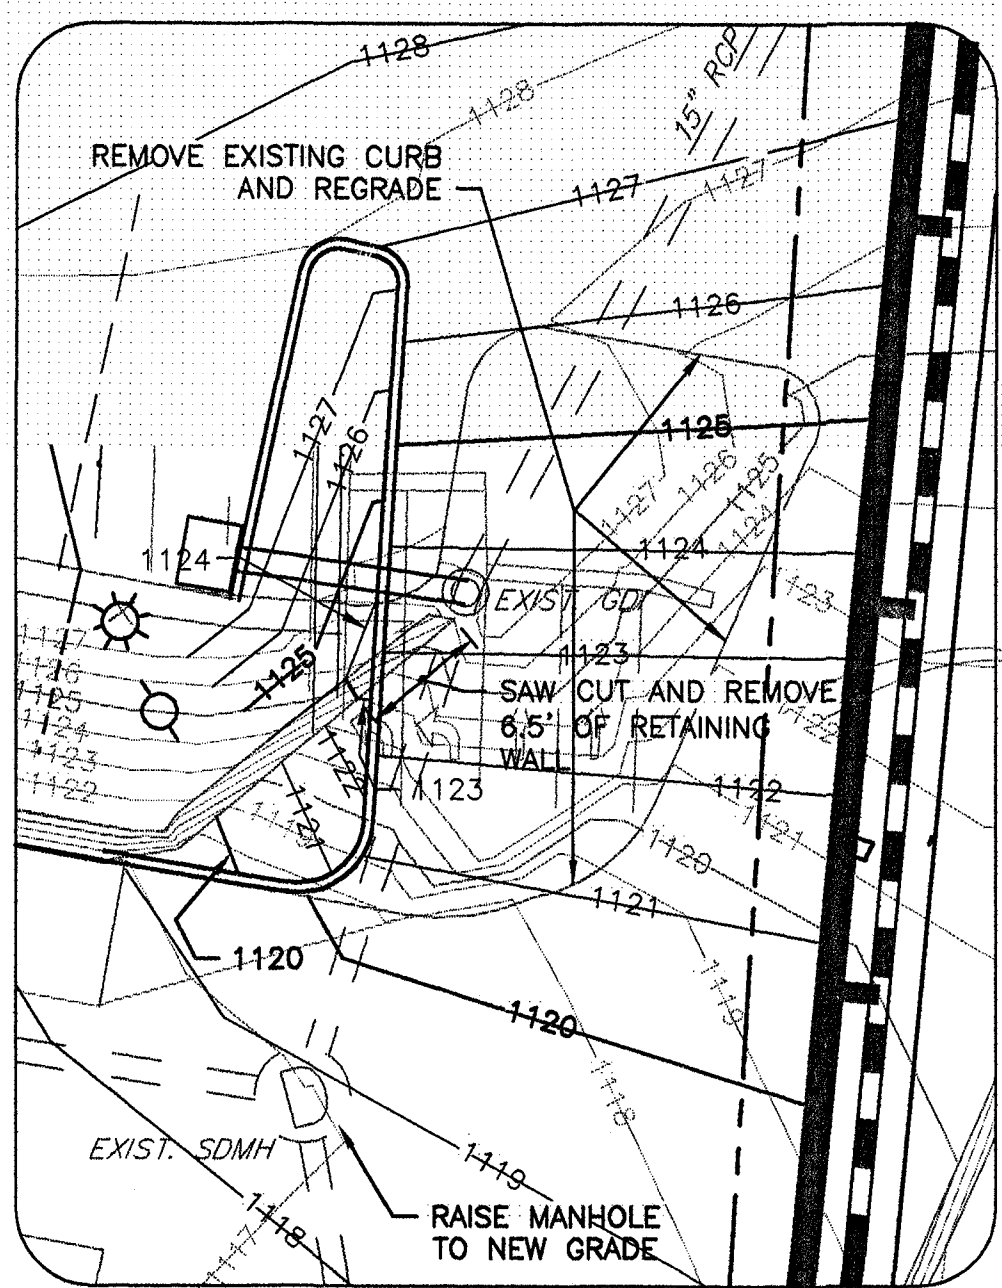


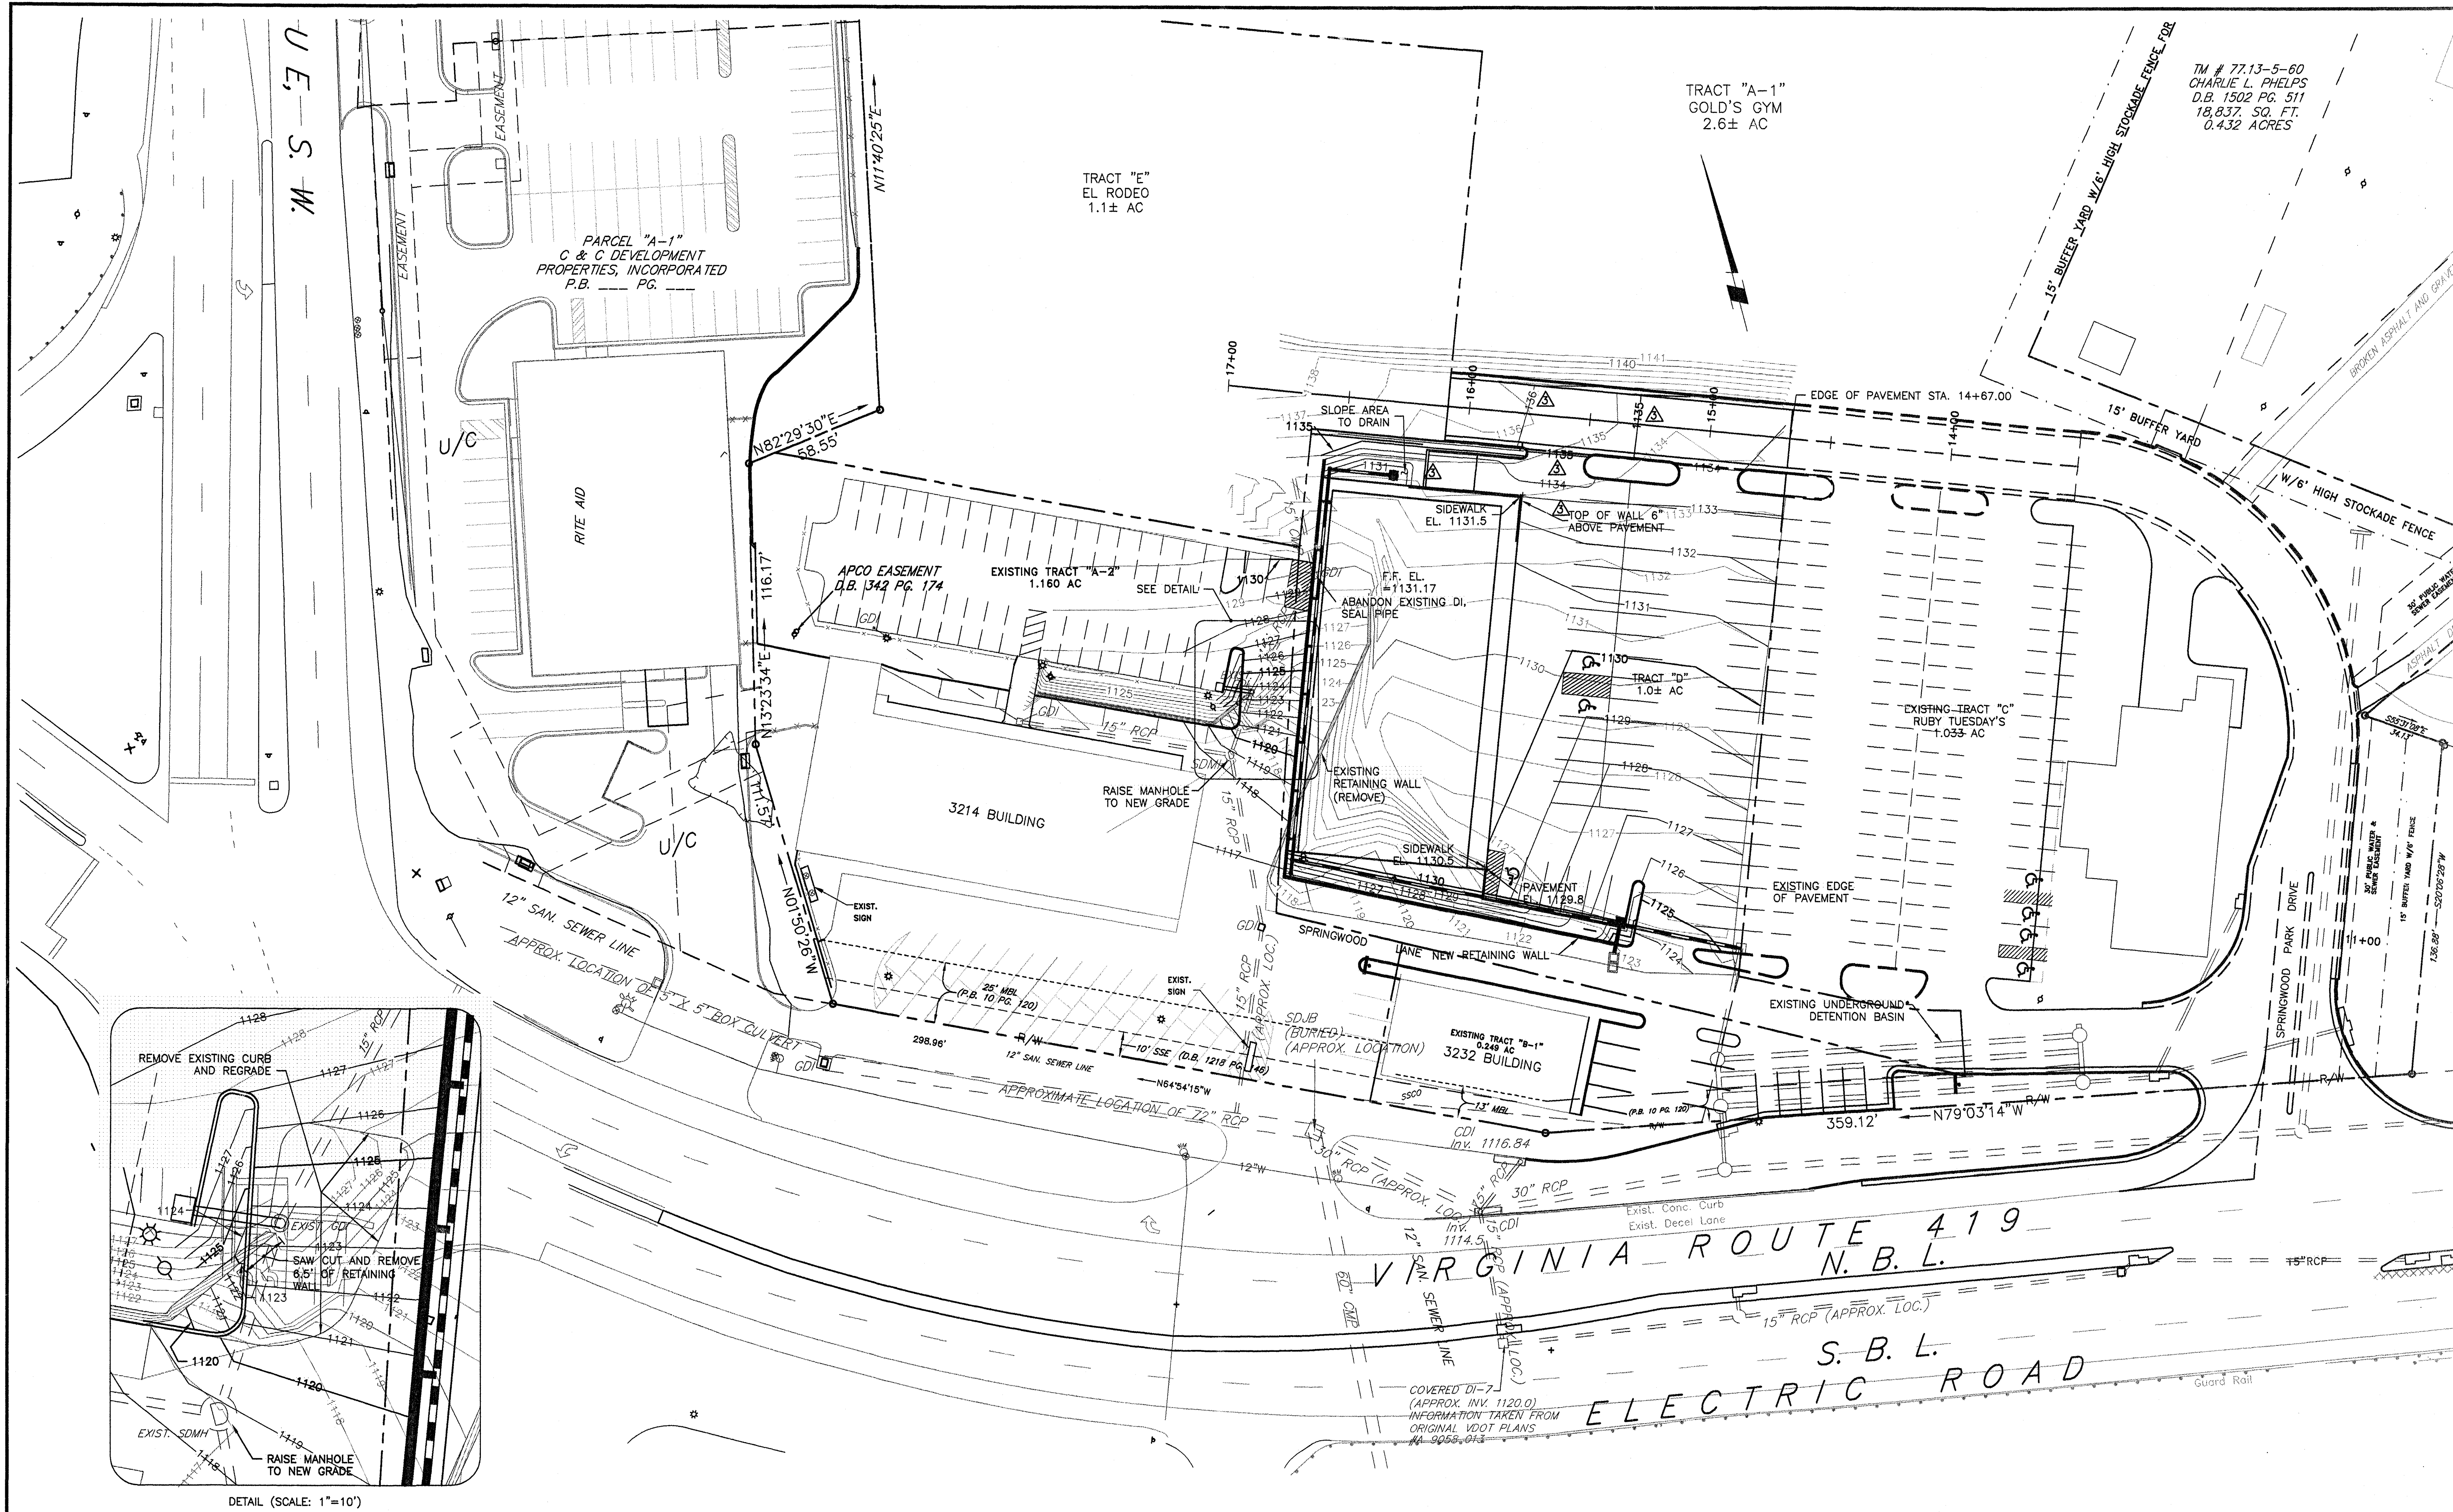


DETAIL (SCALE: 1"=10')

REV	DATE	DESCRIPTION	BY	APP
1	4/3/03	REV. INVERT FOR EXIST. SMH AND SEWER LINE GRADES	MAS	NAB
2	5/28/03	REV. INVERT FOR SMH #1 AND SMH #3 AND SEWER LINE GRADES; RELOCATE WATER LINE TIE-IN TO BLDG.	MAS	NAB
3	6/27/03	REV. WATER LINE LOCATION AND GRADES OVER UTILITY LINES; ADD WALL IN FRONT AND ON SIDE OF BUILDING	MAS	NAB

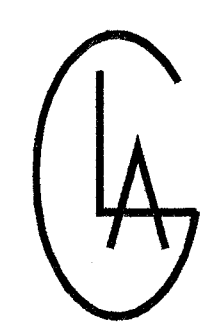

L. A. GATES COMPANY
 ENGINEERS AND CONSULTANTS
 306 MARKET STREET, SE
 ROANOKE, VIRGINIA 24011
 (540)342-8423 - FAX (540)342-8425
 BECKLEY, WV CHARLESTON, WV ROANOKE, VA

Springwood Associates, L.L.C.
 Property Management
 and Development
 Suite 200, 3214 Electric Road, S.W.
 Roanoke, Virginia 24018
 Tel. (540)774-6500 Fax (540)776-0891

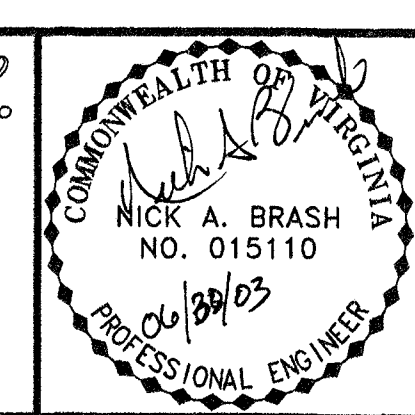

SPRINGWOOD TRACT D				
GRADING PLAN				
ROANOKE COUNTY, VIRGINIA				
DRAWN	CHECKED	DESIGNED	DATE	PROJECT ID NO
MAS	NAB	MAS	JUN 30, '03	39522.180
				1"=10' SHEET
				SCALE: 1"=30' C4