

STARKEY SEWAGE PUMP STATION FORCE MAIN AND GRAVITY SEWER

PROJECT NO. 84-1-S
COUNTY OF ROANOKE, VIRGINIA
11 JANUARY 1985


HAYES, SEAY, MATTERN AND MATTERN
ARCHITECTS - ENGINEERS - PLANNERS

AS BUILT 8/30/89 84-1-S



INDEX TO DRAWINGS

SHEET NO.	TITLE
1	TITLE SHEET
2	ABBREVIATIONS
3	LEGENDS, SYMBOLS AND GENERAL NOTES
4	PUMP STATION, SITE PLAN
5	PUMP STATION, EQUIPMENT
6	PUMP STATION, STRUCTURAL
7	PUMP STATION, ARCHITECTURAL
8	PUMP STATION, ELECTRICAL
9	PUMP STATION, MECHANICAL AND ELECTRICAL
10-15	GRAVITY SEWER, PLAN AND PROFILE
16-23	FORCE MAIN, PLAN AND PROFILE
24	FLOW METER STATION
25-27	DETAILS

PROJECT INDEX MAP

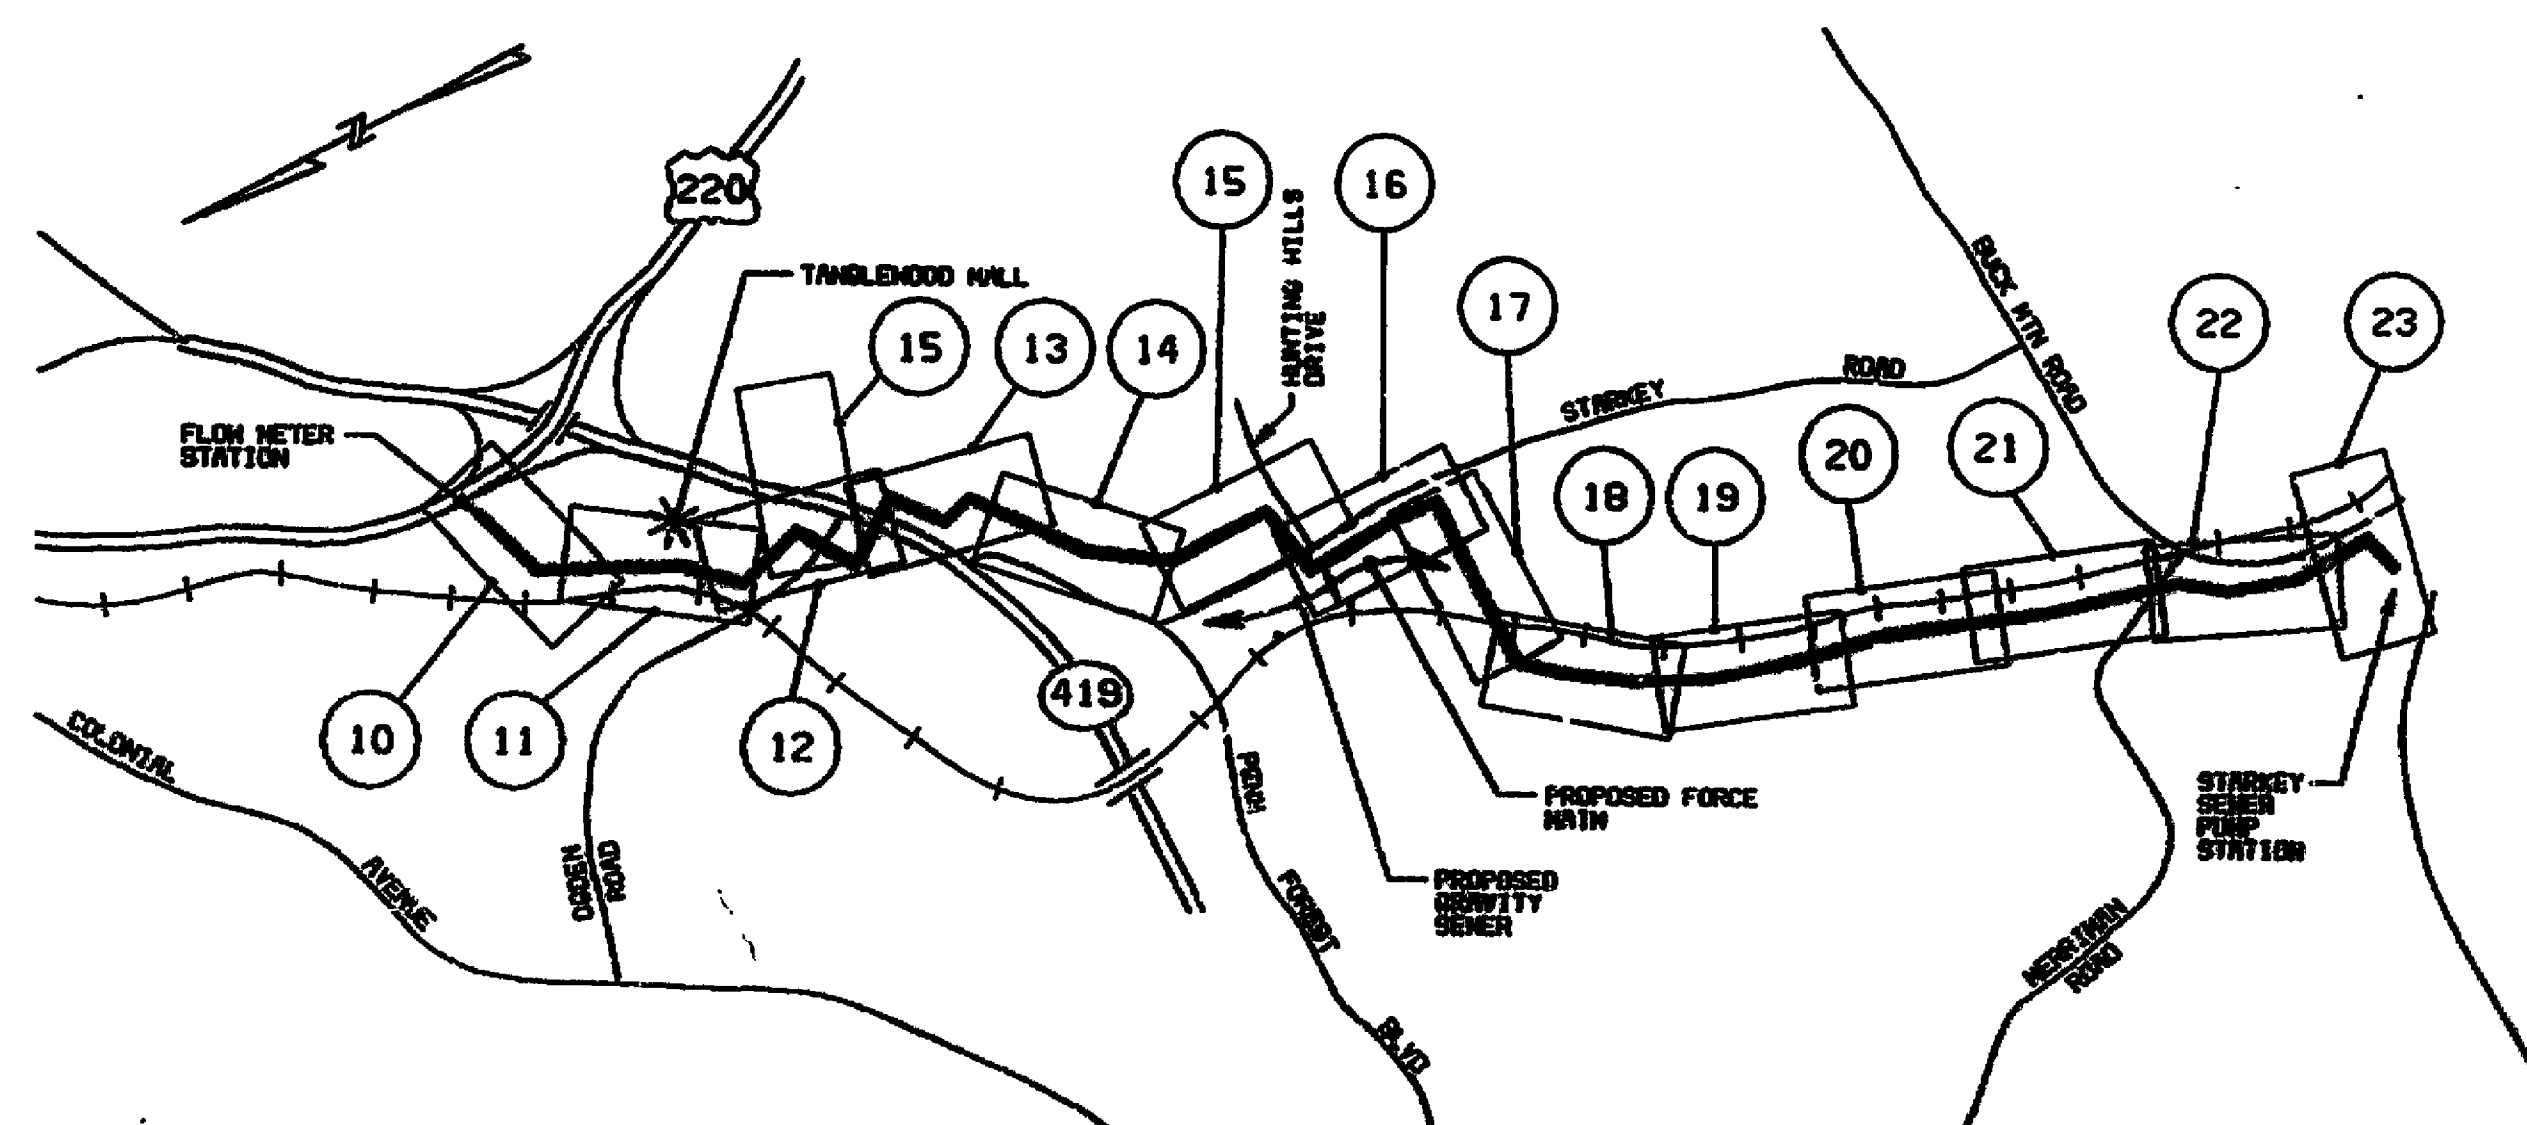

PROJECT VICINITY MAP

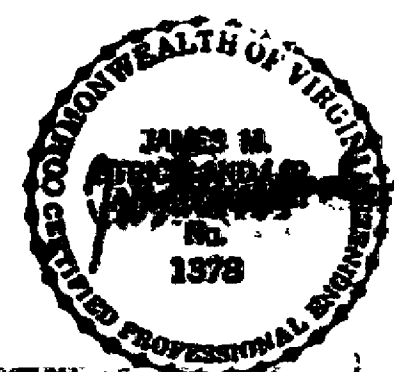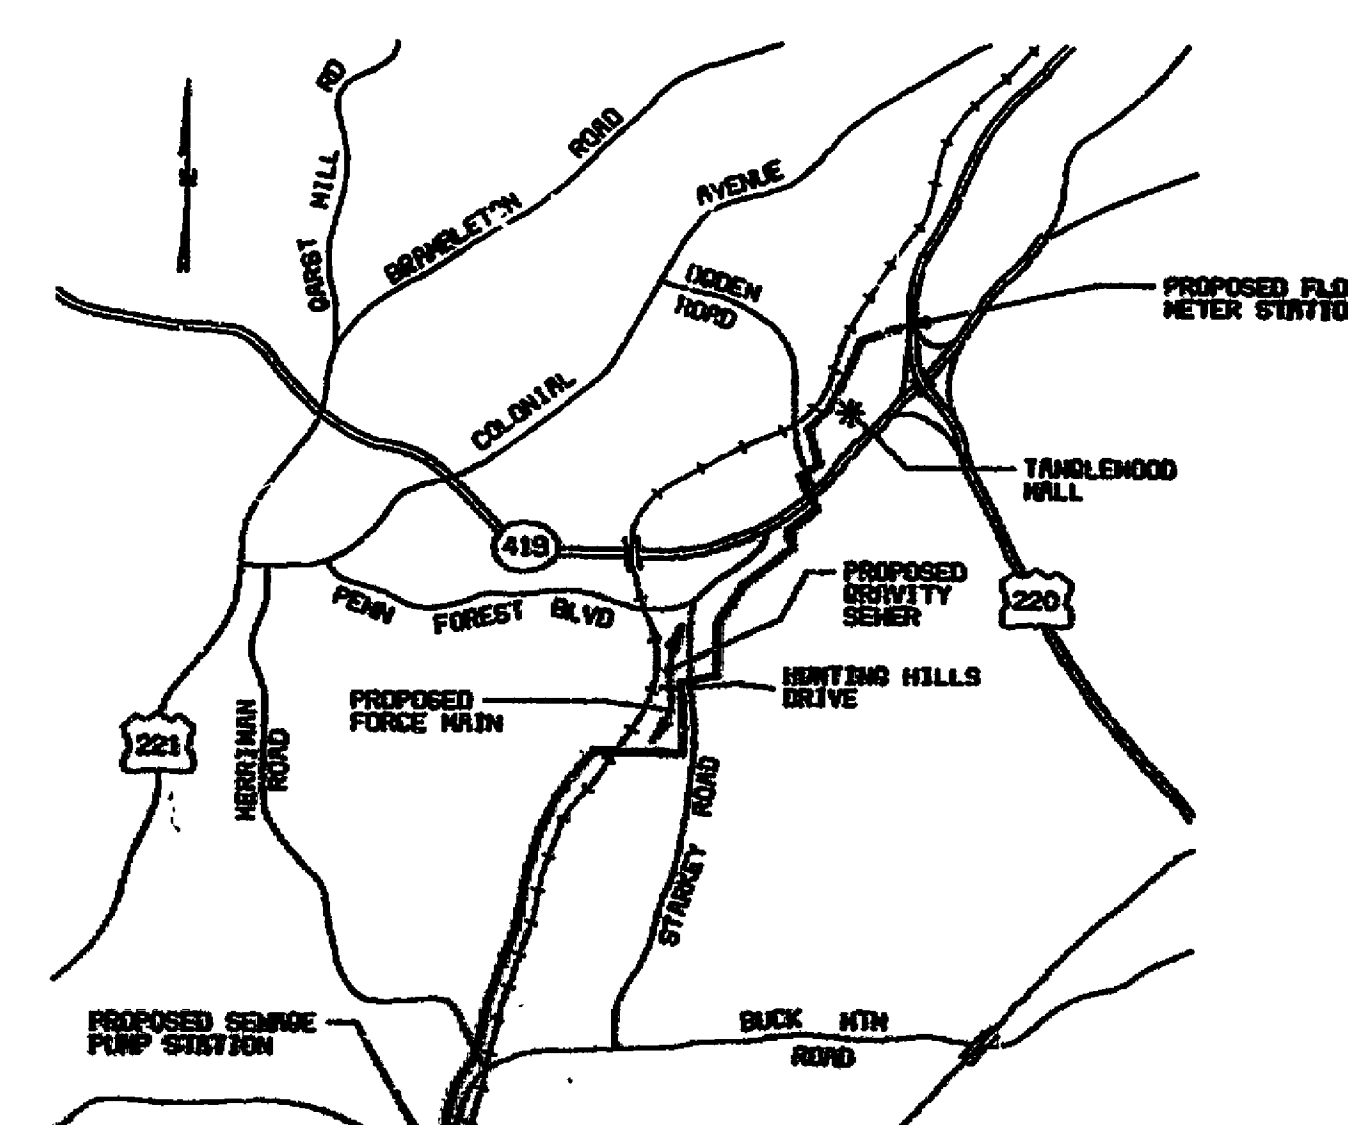

04C AP2885-04185

