



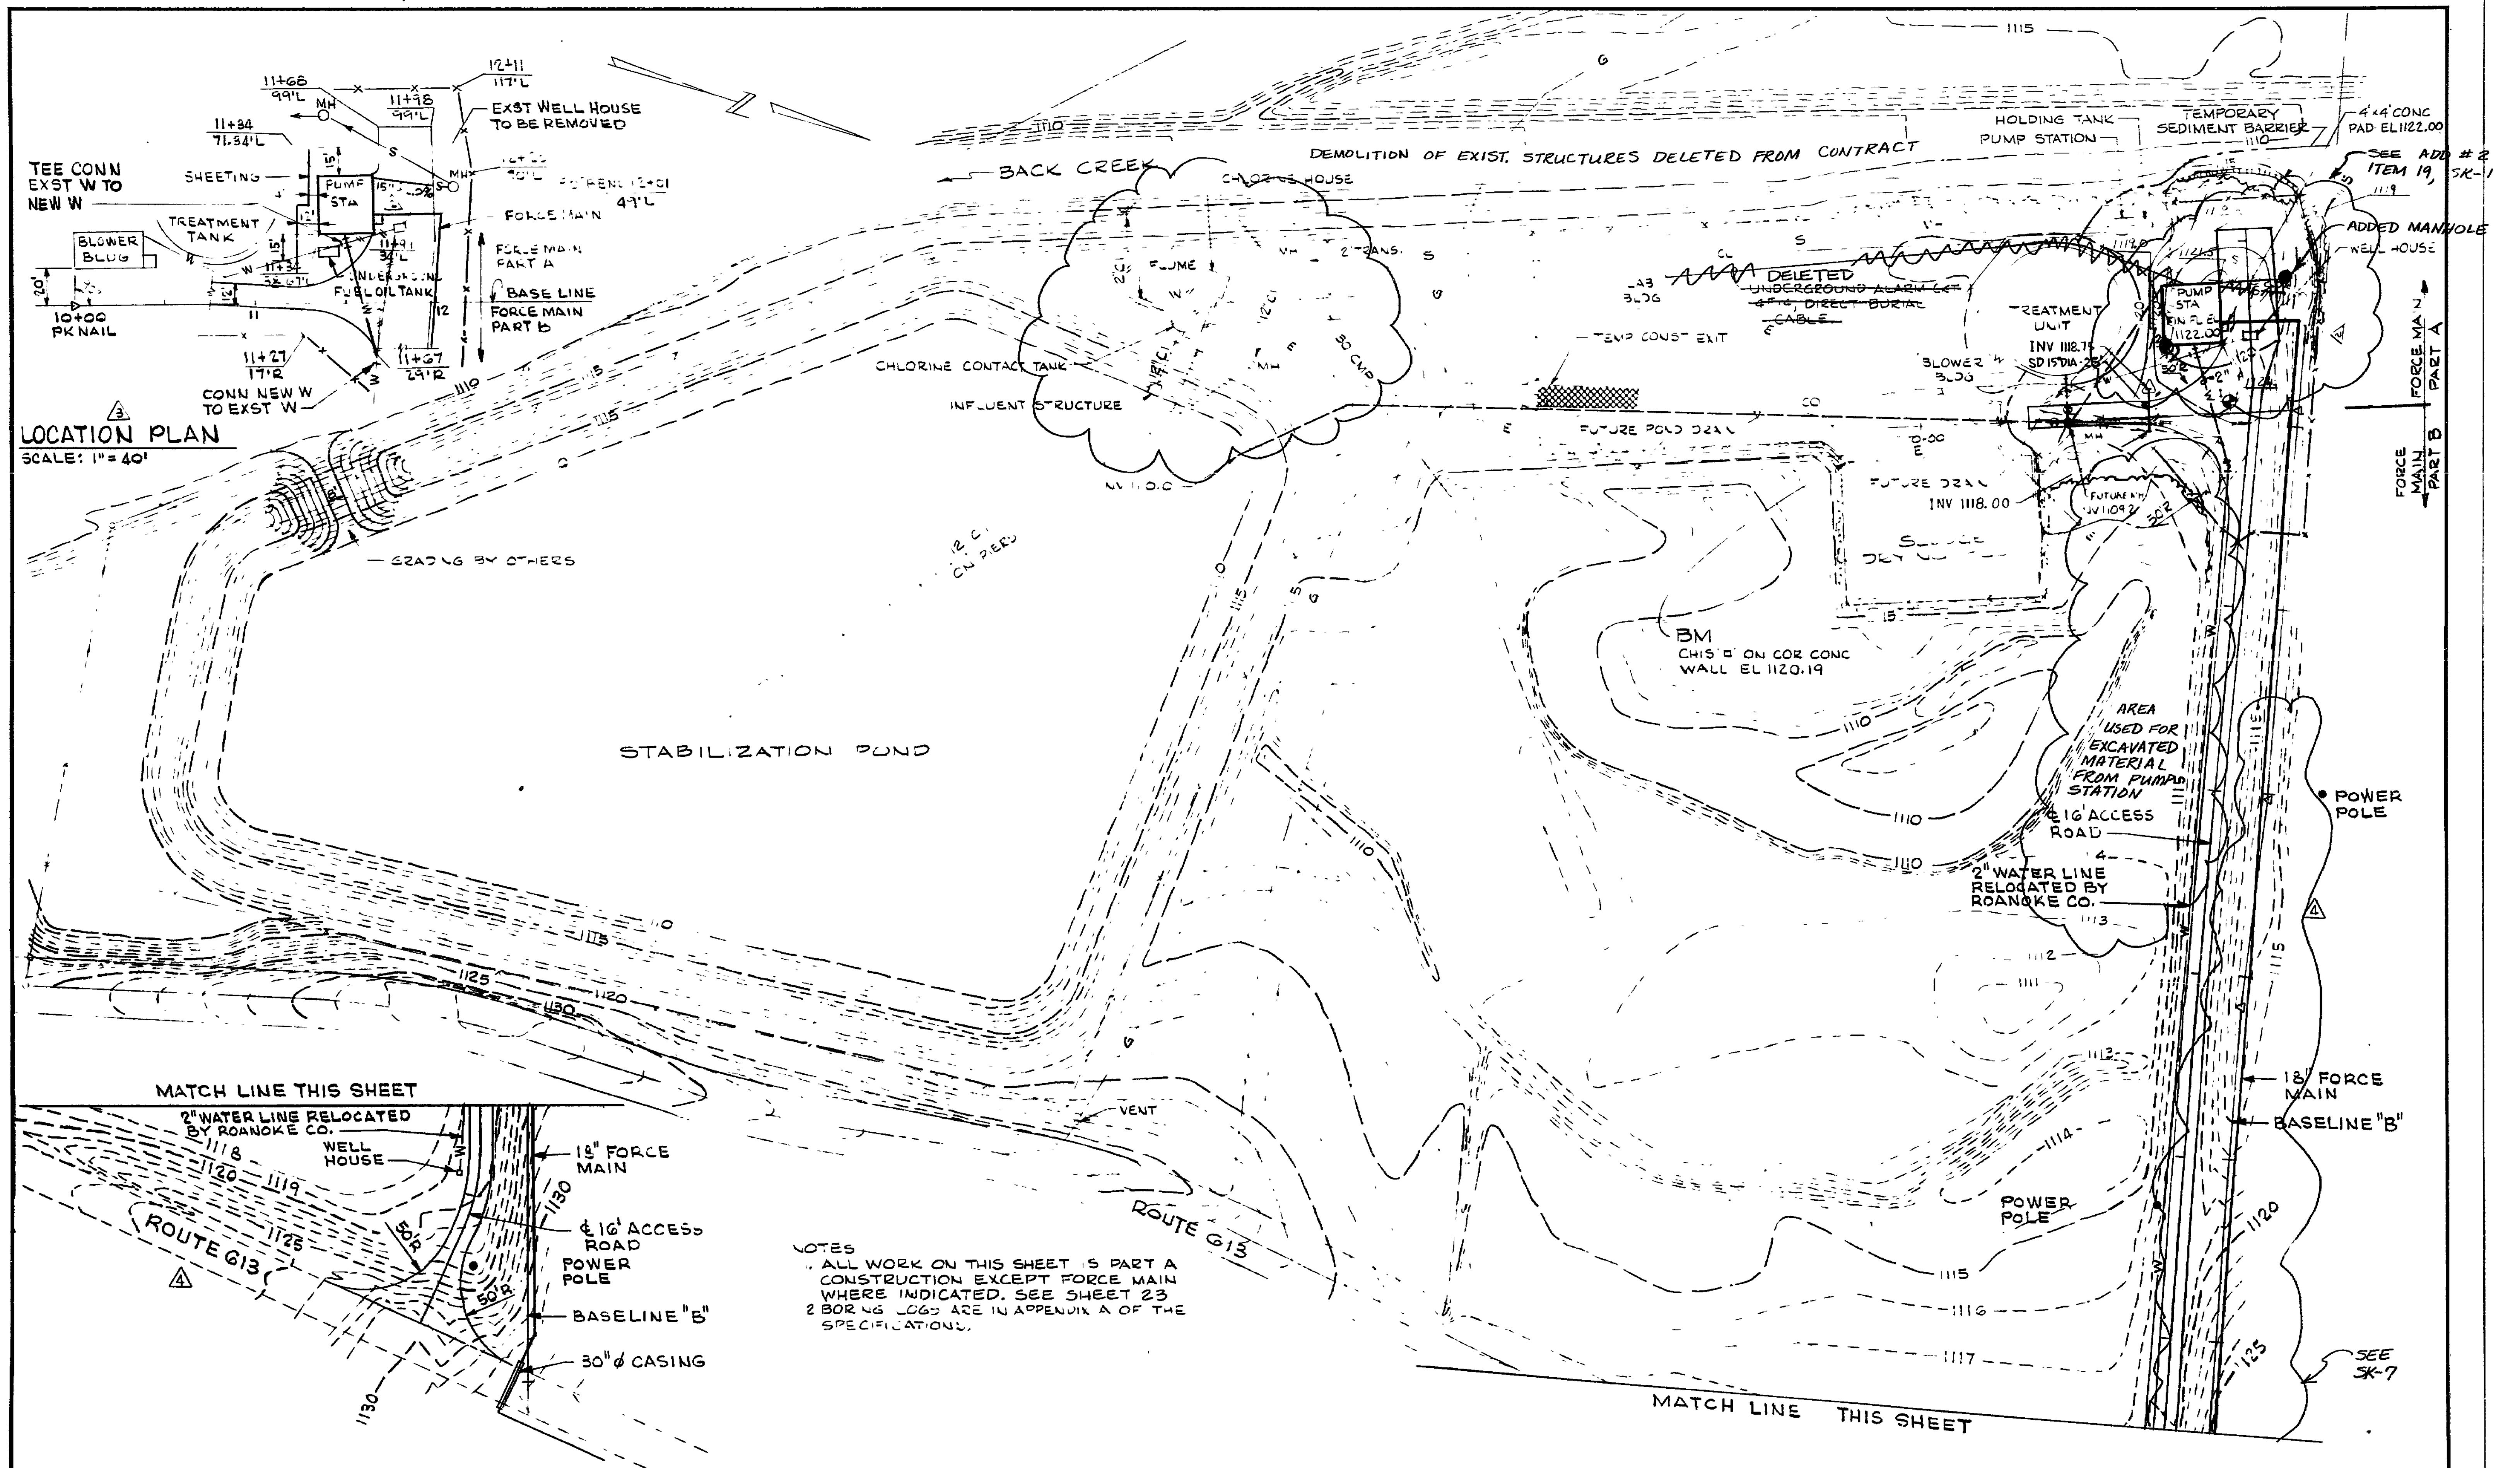

DESIGNED				REVISIONS				REVISIONS			
DATE	BY	DESCRIPTION	DATE	BY	DESCRIPTION	DATE	BY	DESCRIPTION	DATE	BY	DESCRIPTION
5/1/85	MLB		8/15/85	MLB	REVISIONS PER ROANOKE CO 8/1/85						
5/10/85	LR		7/19/88	SG	REV. PER ADDENDUM #2 12/87						
	MM		7/19/88	SG	REV ACCESS ROAD						
5/13/85	RR										

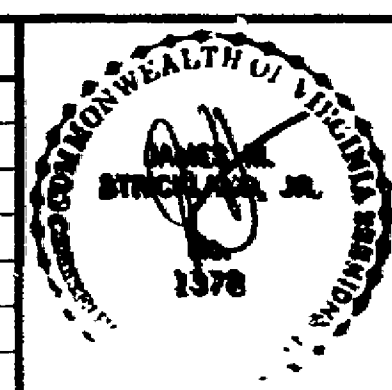

STARKEY SEWAGE PUMP STATION, FORCE MAIN AND GRAVITY SEWER
COUNTY OF ROANOKE, VIRGINIA
11 JANUARY 1985
 HAYES, SEAY, MATTERN AND MATTERN
 ARCHITECTS - ENGINEERS - PLANNERS

PUMP STATION SITE PLAN			
SCALE:	COMM. NO.	DRAWING NO.	
1" = 40'	4185	4	

SI-0251

