

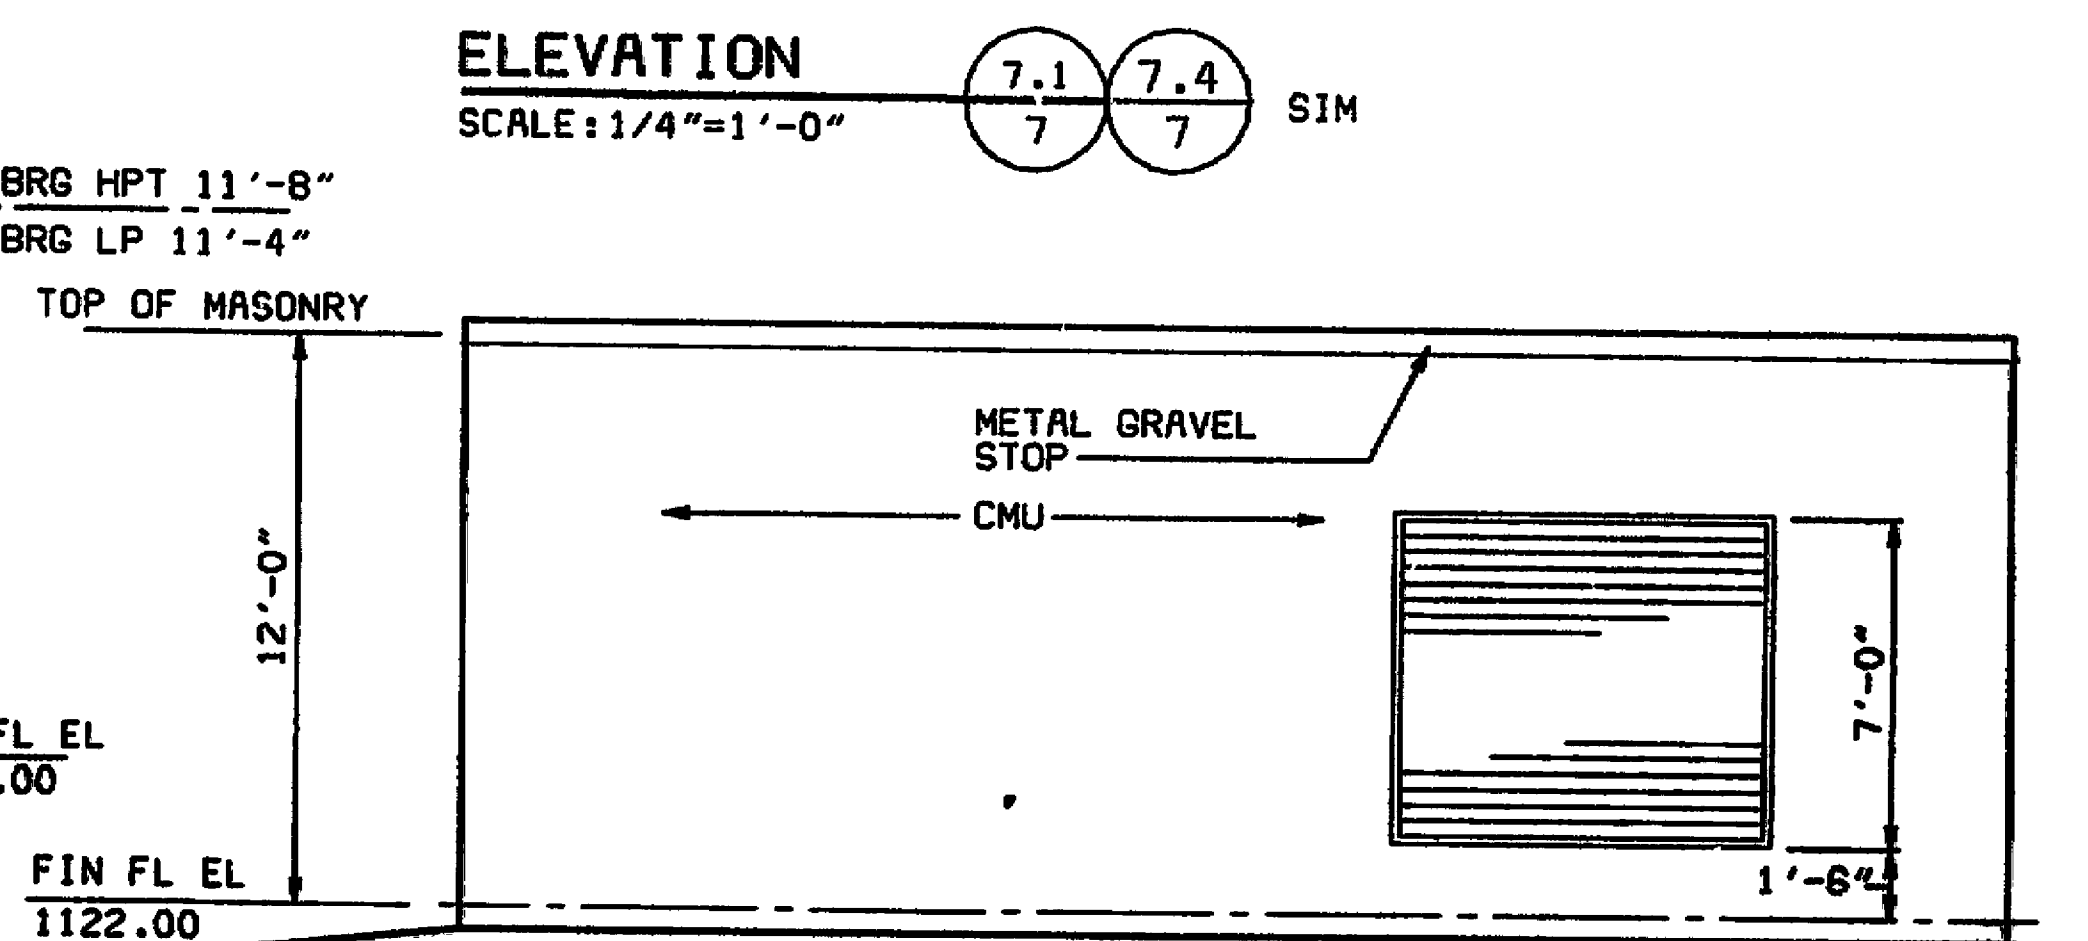
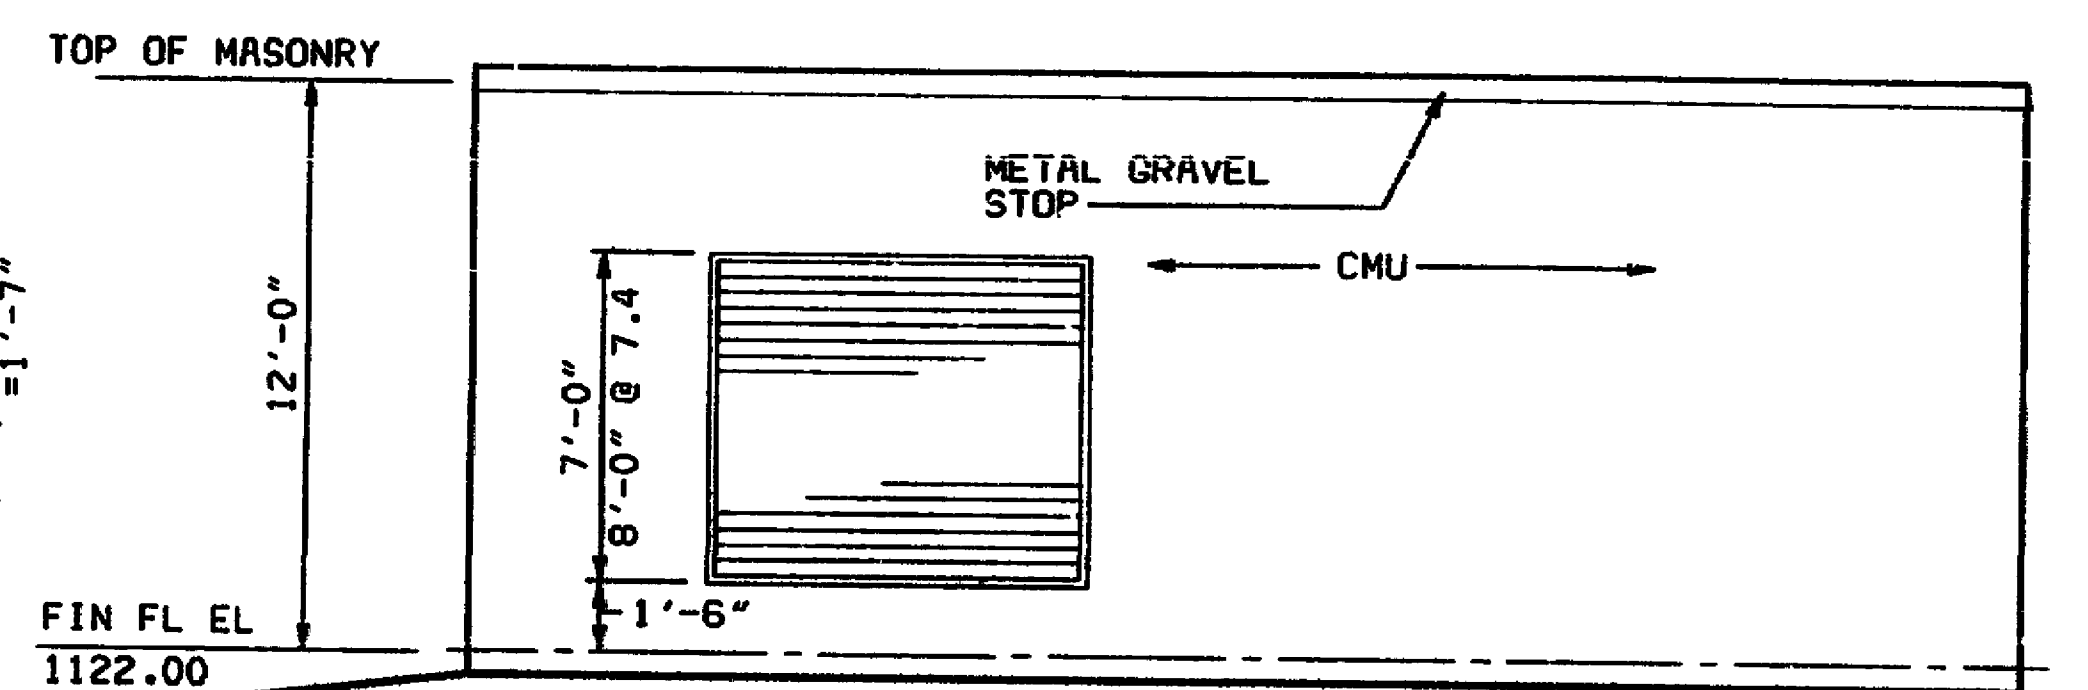
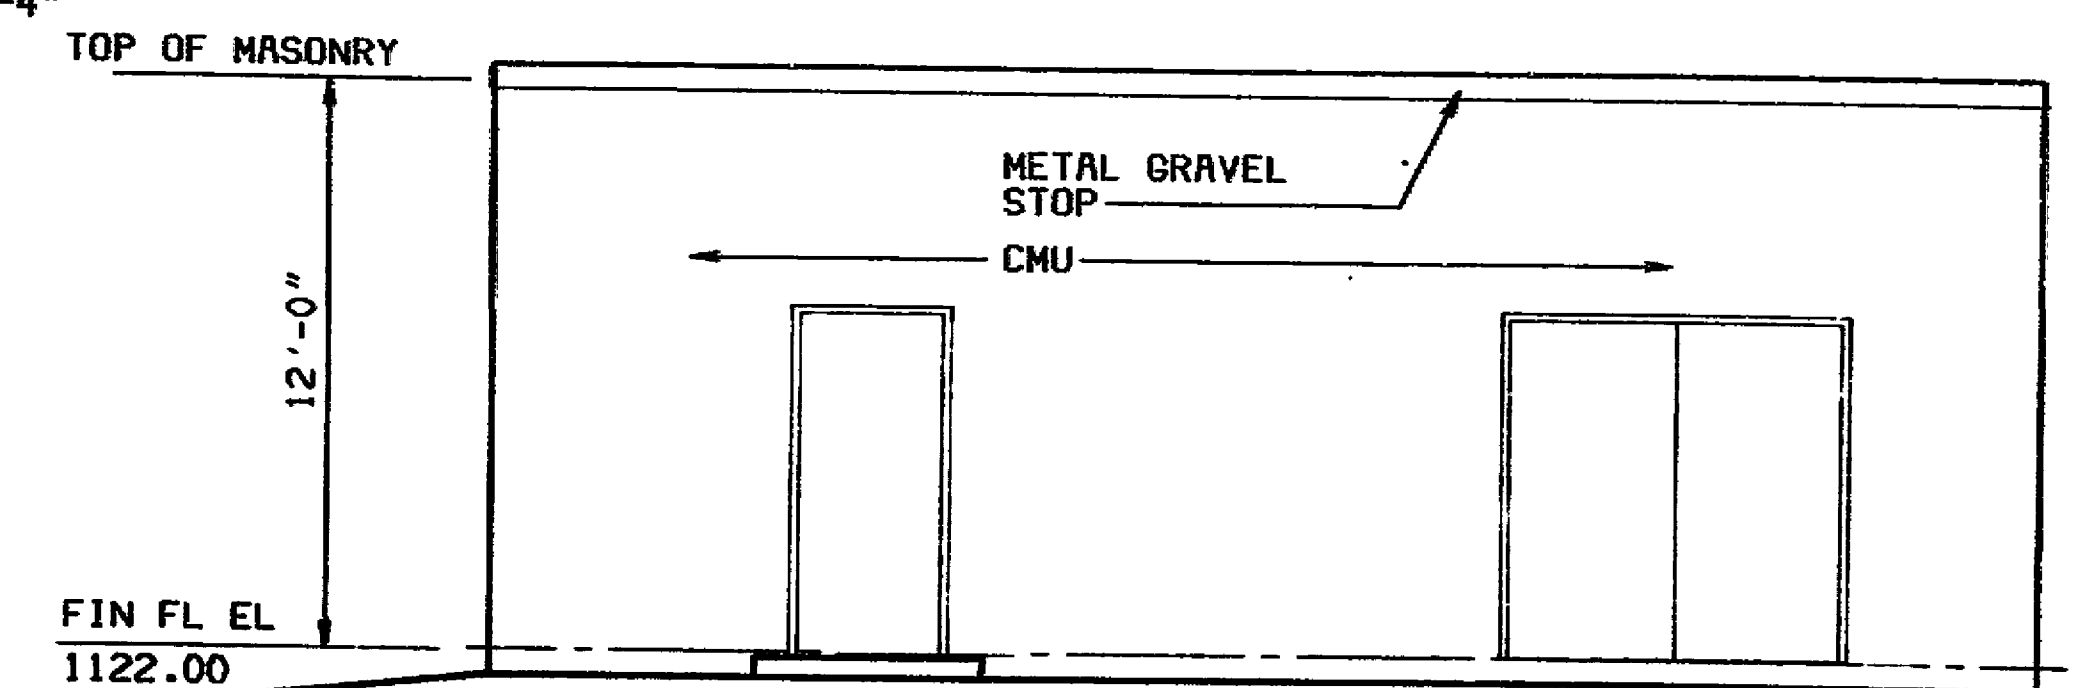
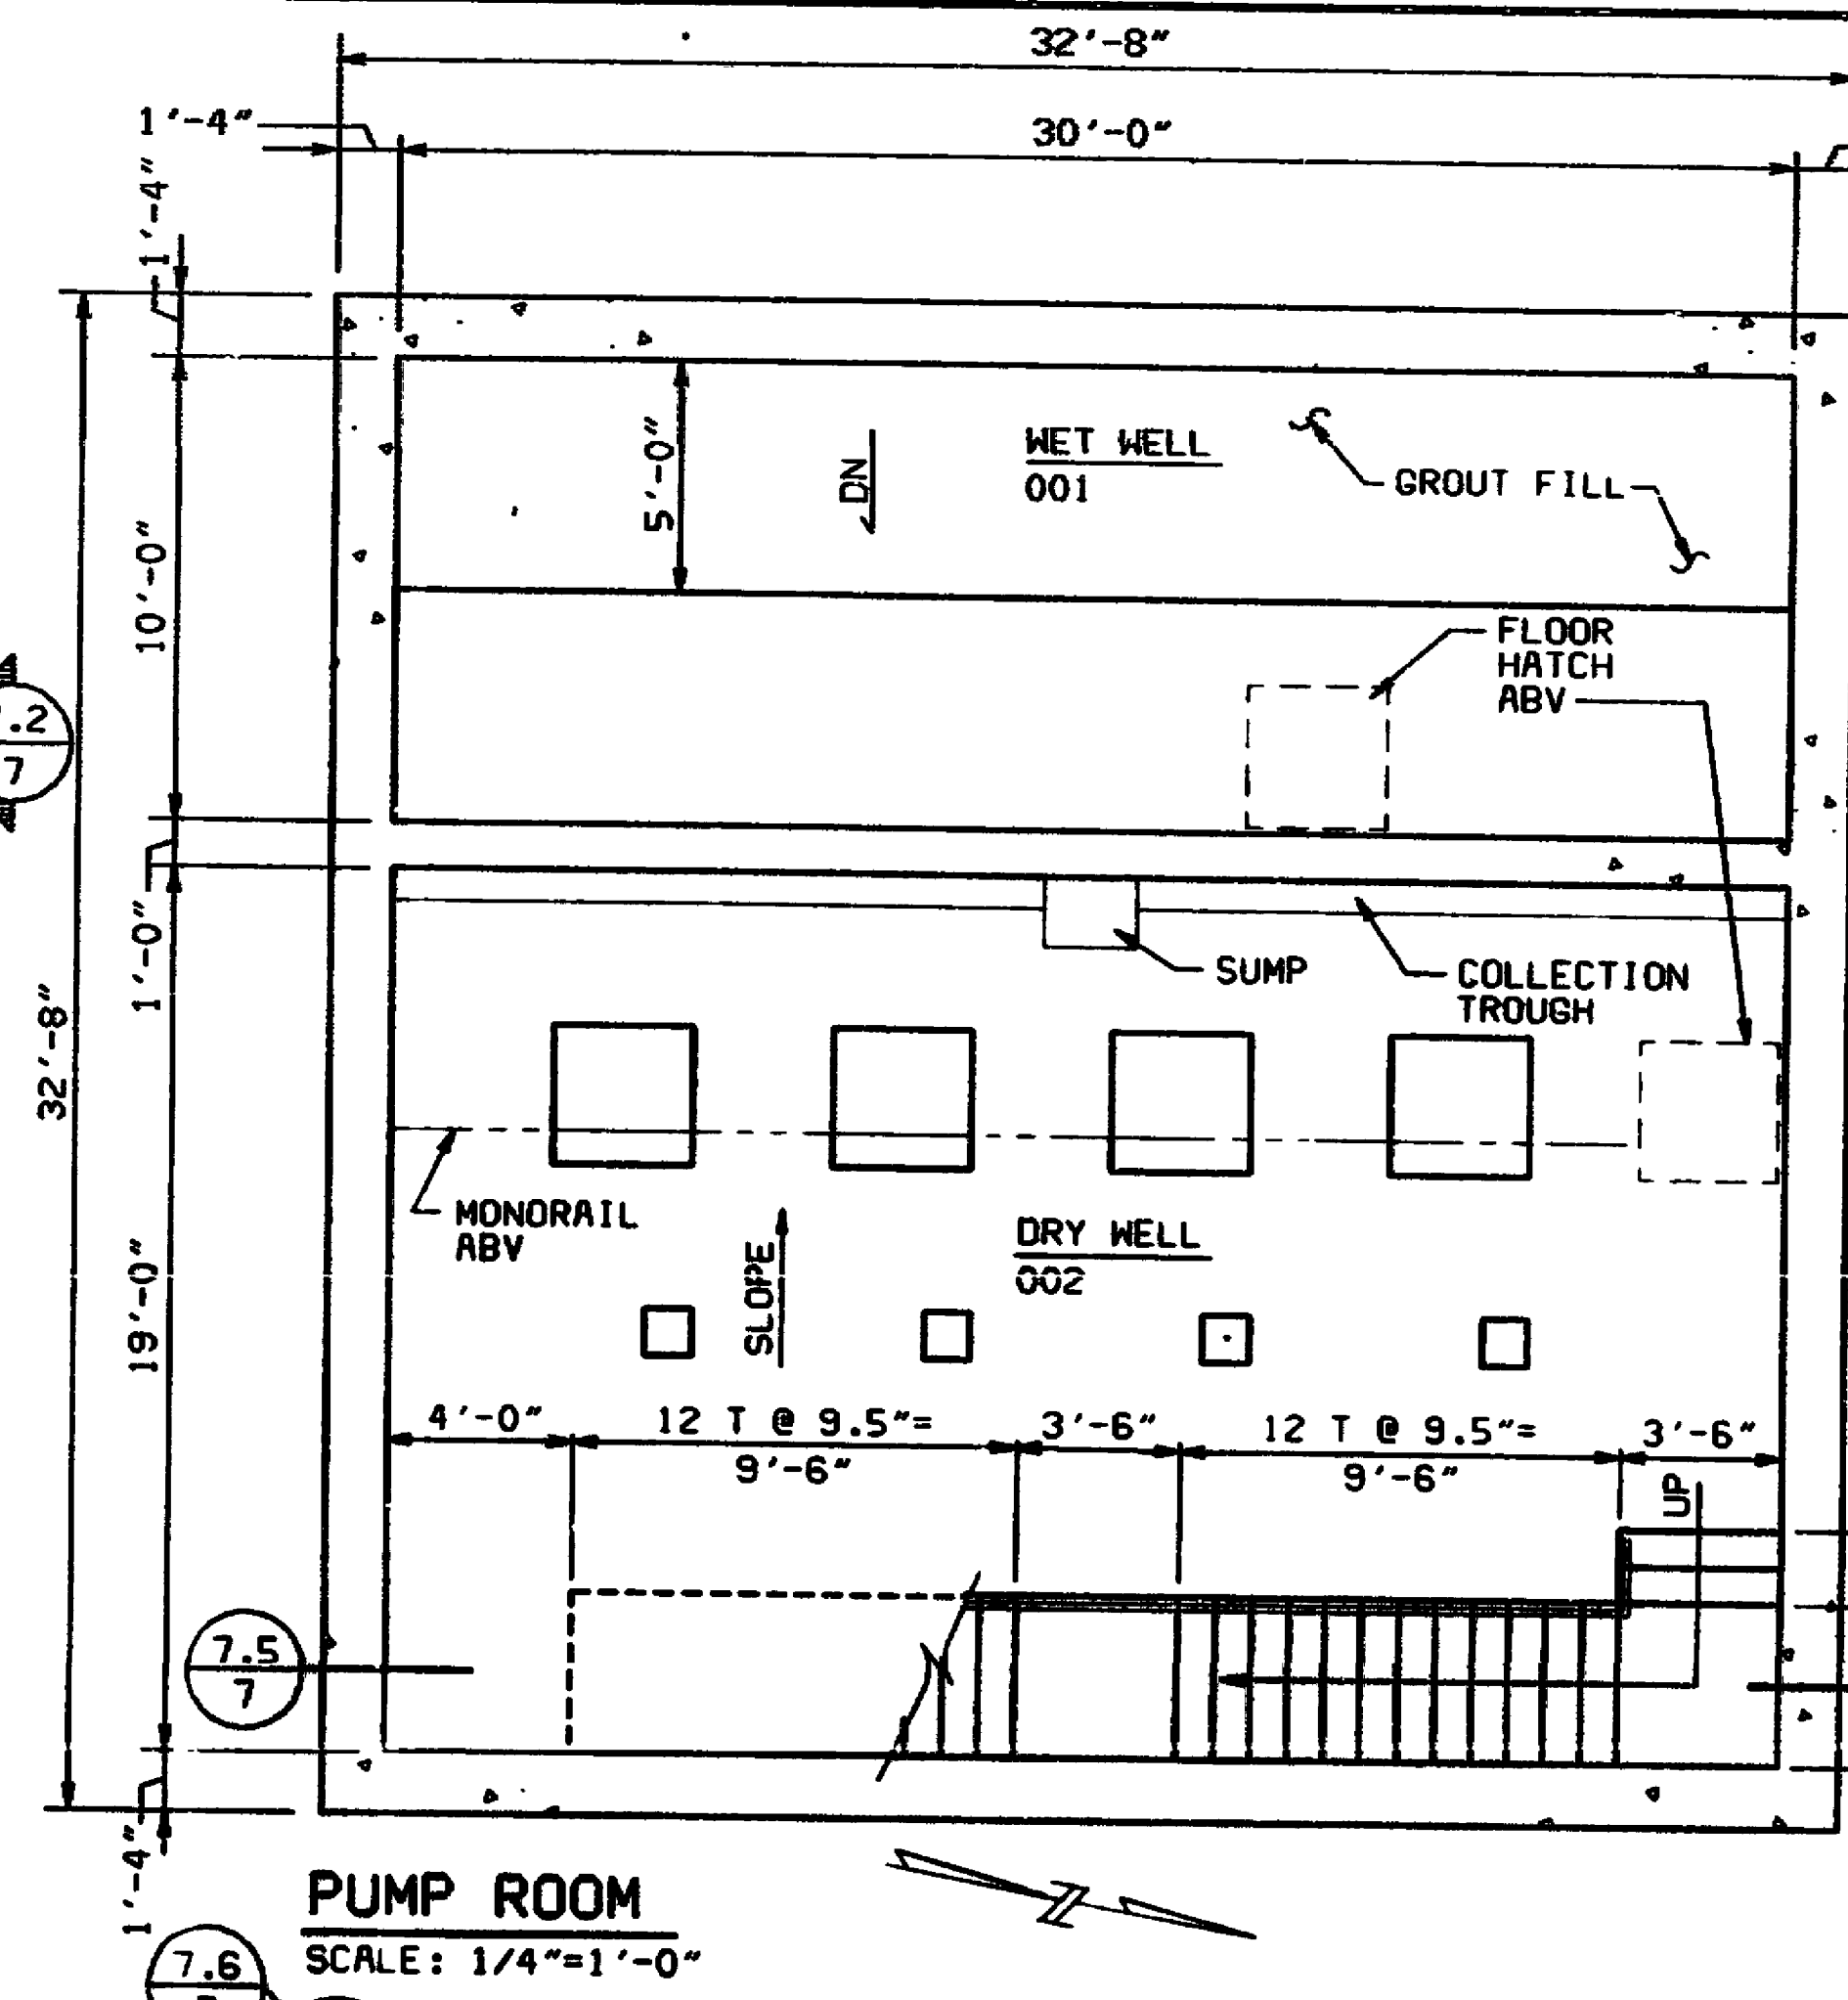
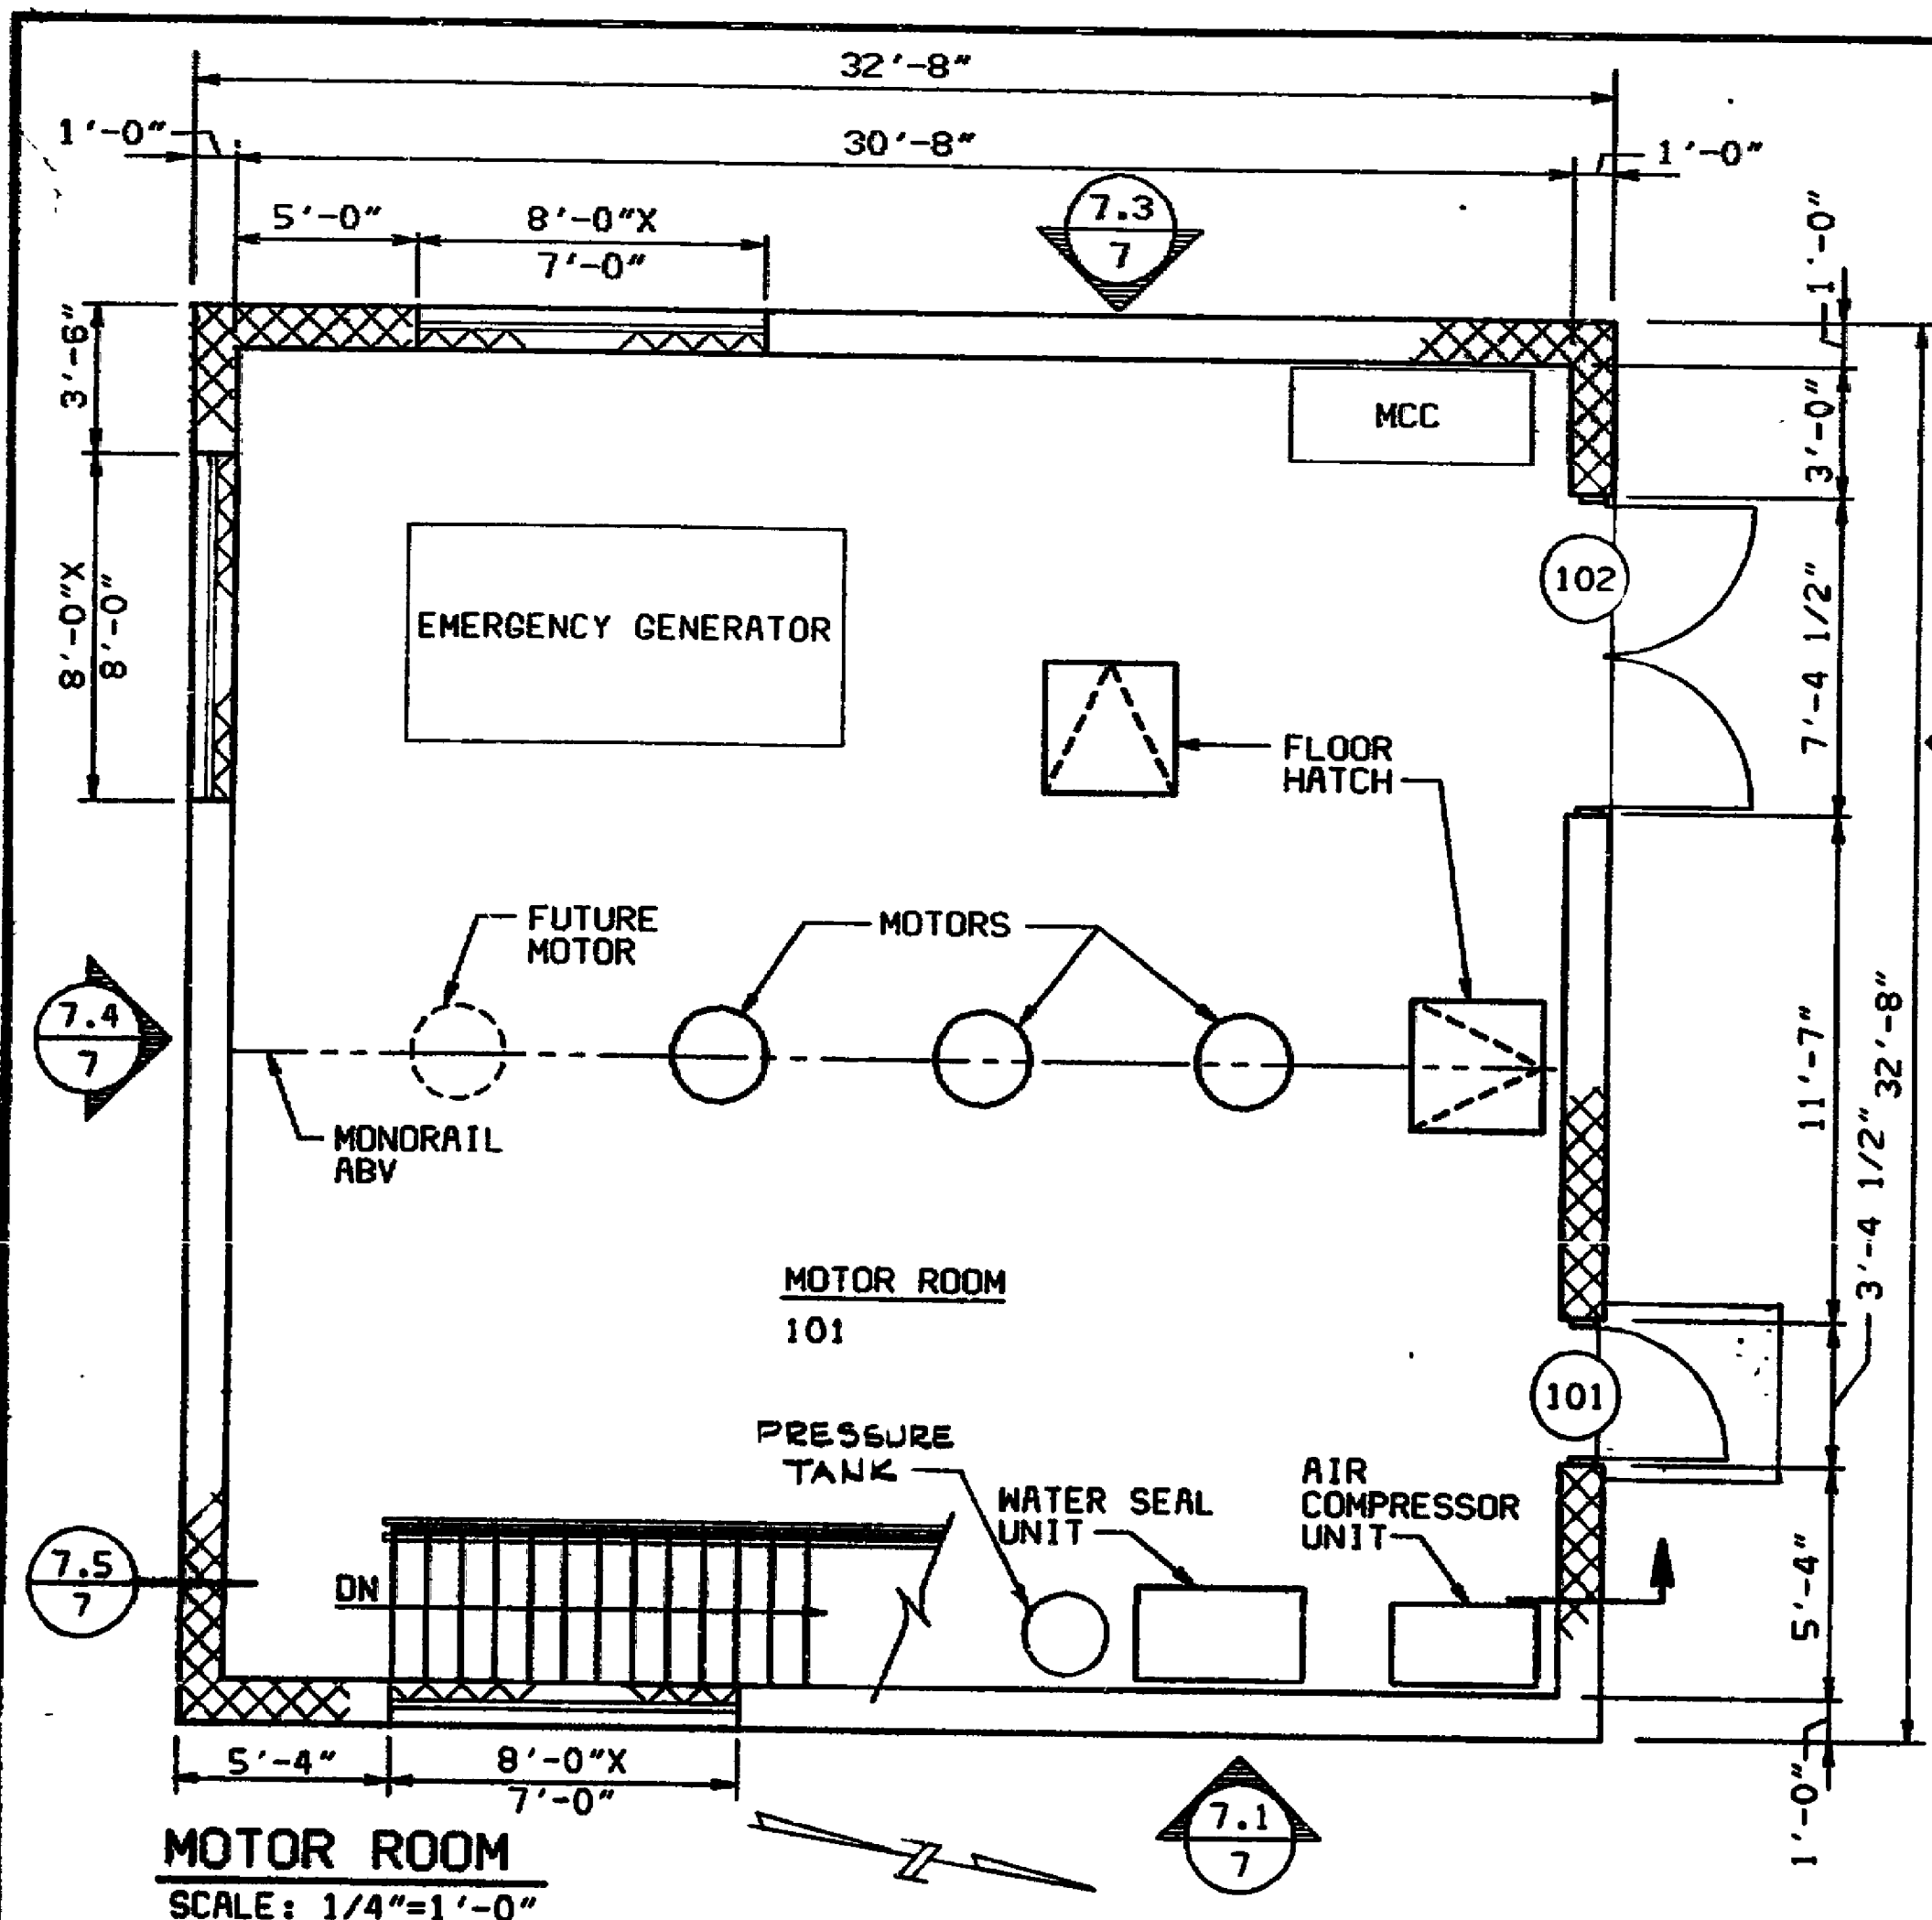
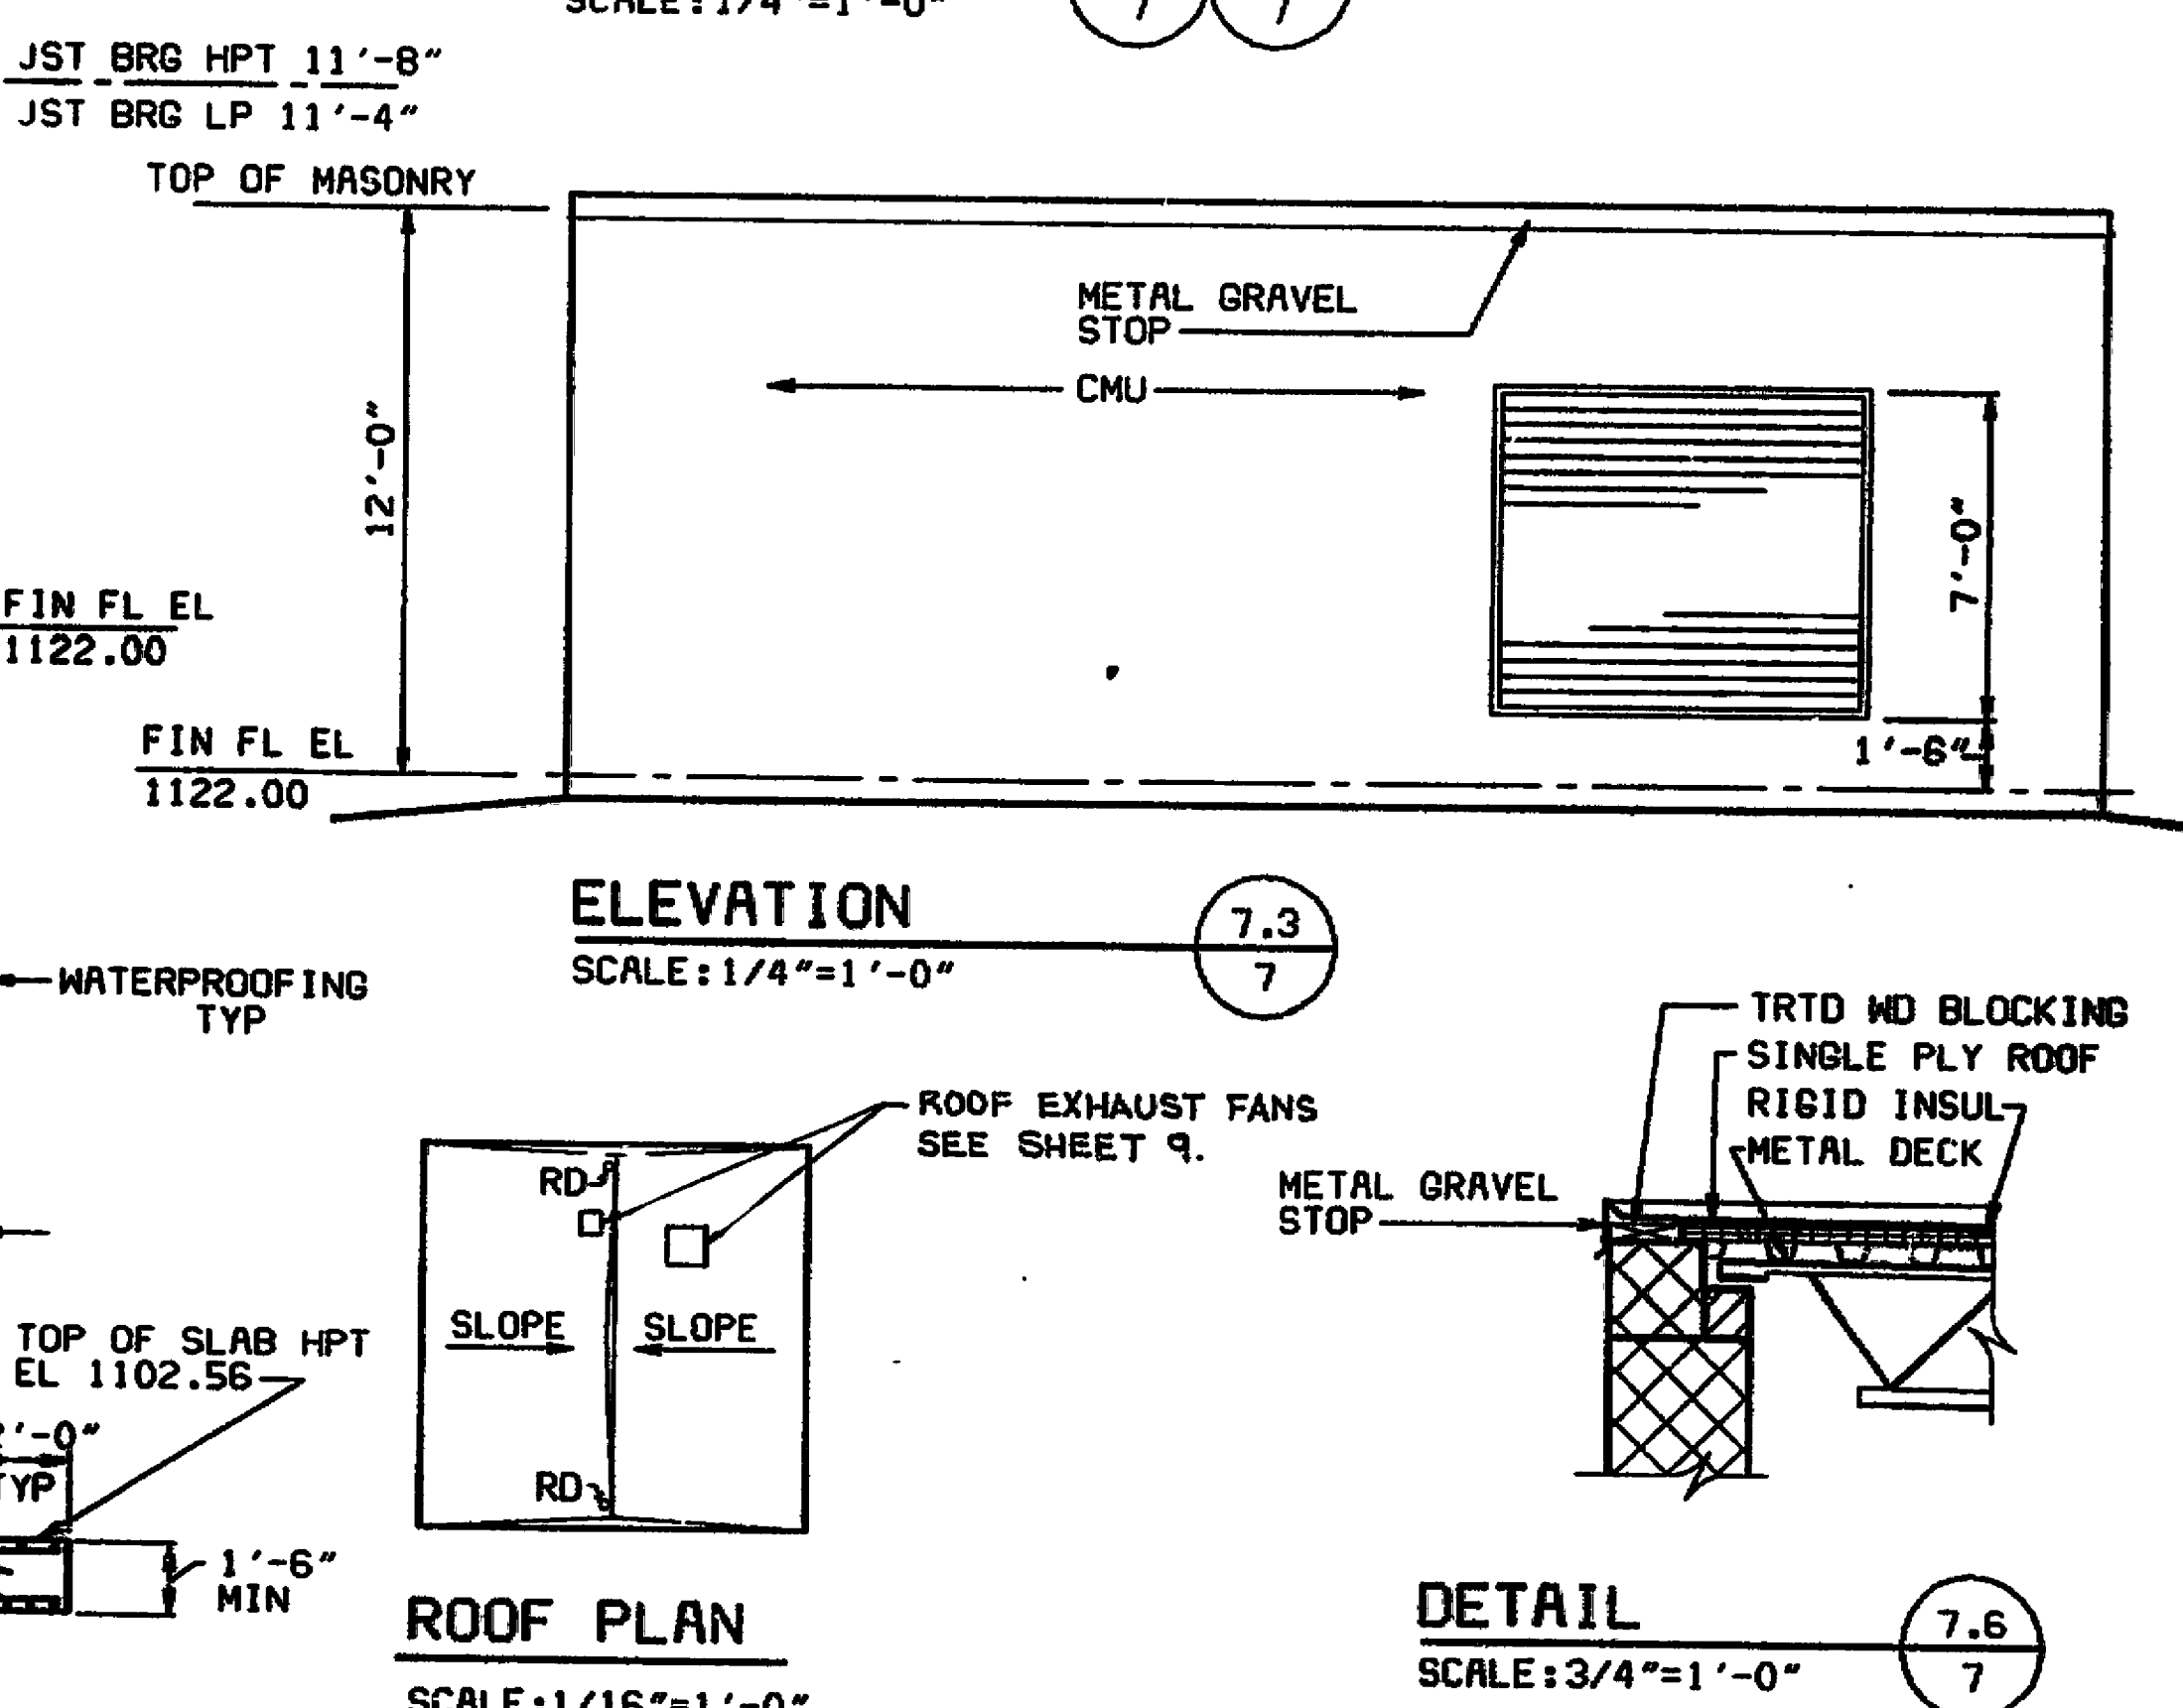


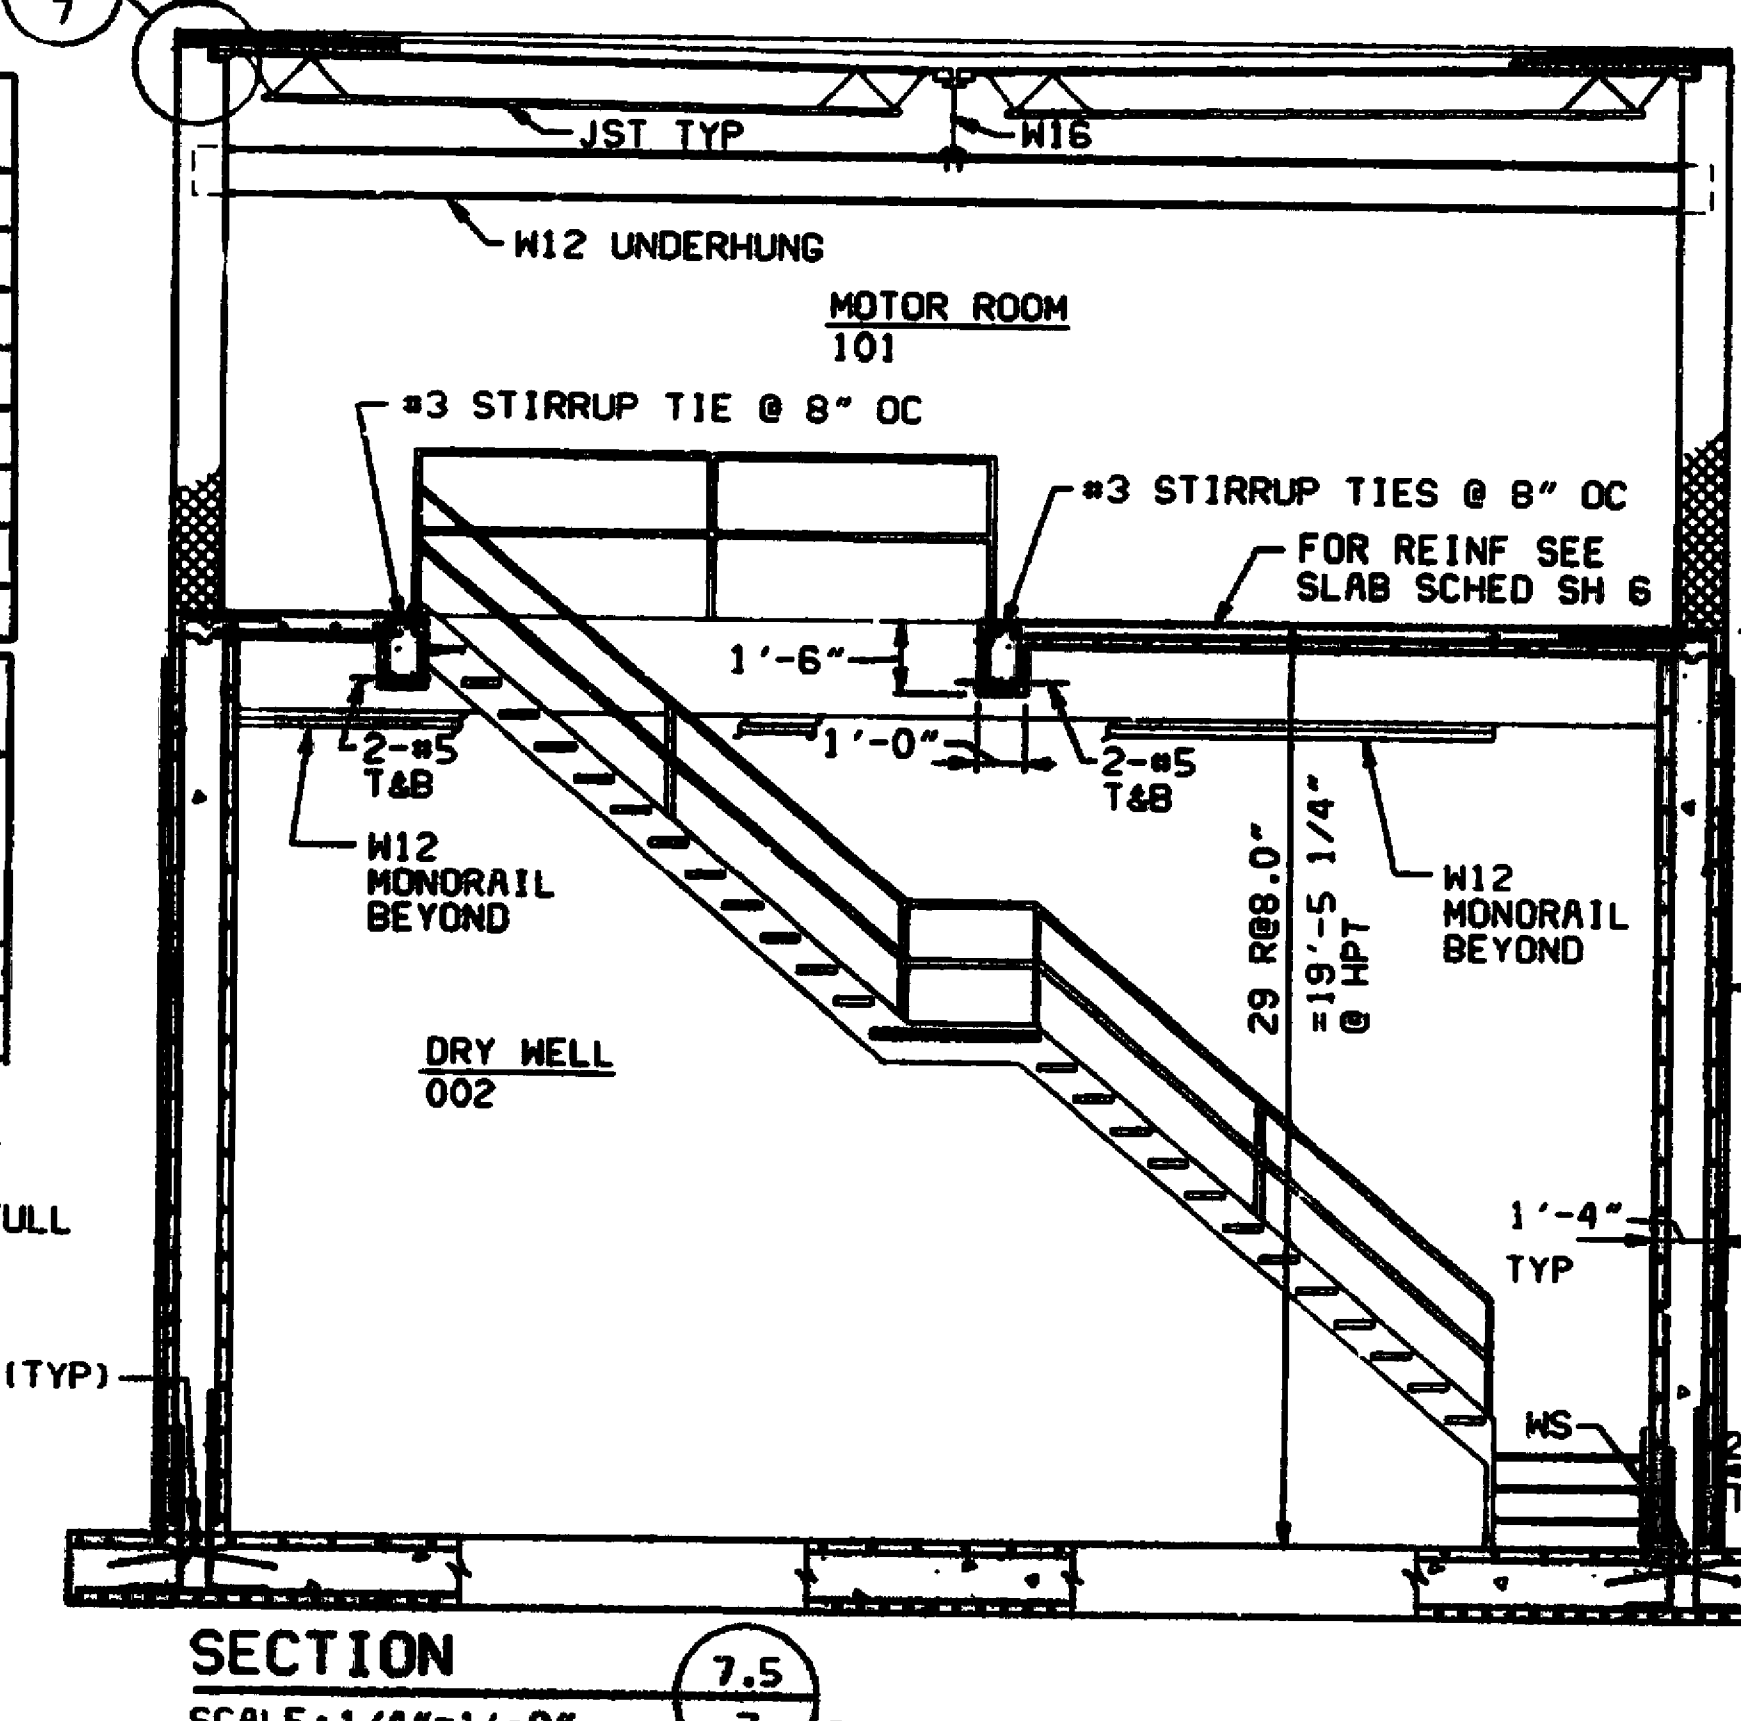

FINISH SCHEDULE								
ROOM NO.	ROOM NAME	FLOOR	BASE	WALLS		CEILING		
				MATERIAL	FINISH	MATERIAL	FINISH	HEIGHT
001	WET WELL	CONC	NONE	CONC	---	CONC	---	---
002	DRY WELL	CONC	NONE	CONC	---	CONC	---	---
101	MOTOR ROOM	CONC	NONE	CMU	PAINT	EXPOSED	PAINT	---

DOOR SCHEDULE													
DOOR				FRAME									
NO	TYPE	MATL	W	H	THICK	LOUVER OR UC	GLASS	TYPE	DEPTH	HEAD	JAMB	THRESH	REMARKS
101	A	HM	3'-0"	7'-2"	1 3/4"	---	---	F1	8 3/4"	1	1	T1	
102	B	HM	7'-0"	7'-2"	1 3/4"	---	---	F2	8 3/4"	1	1	T1	

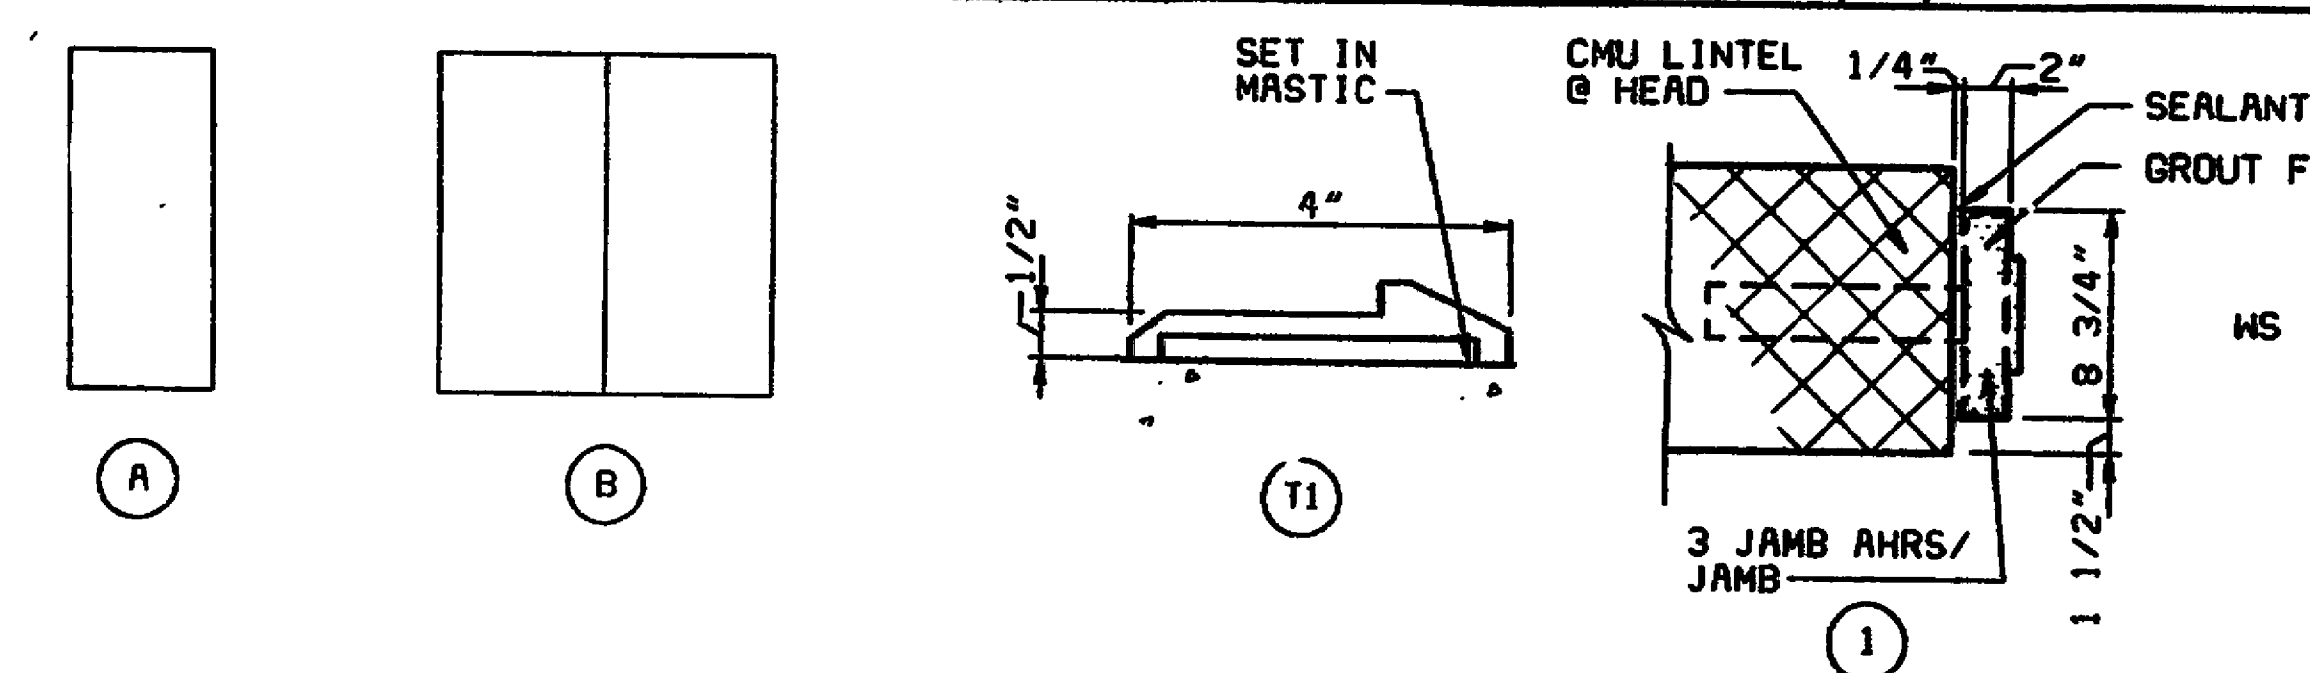

DESIGNED				REVISIONS				REVISIONS			
DATE	BY	DESCRIPTION		DATE	BY	DESCRIPTION		DATE	BY	DESCRIPTION	

STARKEY SEWAGE PUMP STATION, FORCE MAIN AND GRAVITY SEWER
COUNTY OF ROANOKE, VIRGINIA
11 JANUARY 1985

HAYES, SEAY, MATTERN AND MATTERN
ARCHITECTS - ENGINEERS - PLANNERS

PUMP STATION ARCHITECTURAL

SCALE: AS NOTED

DRAWING NO. 74

