
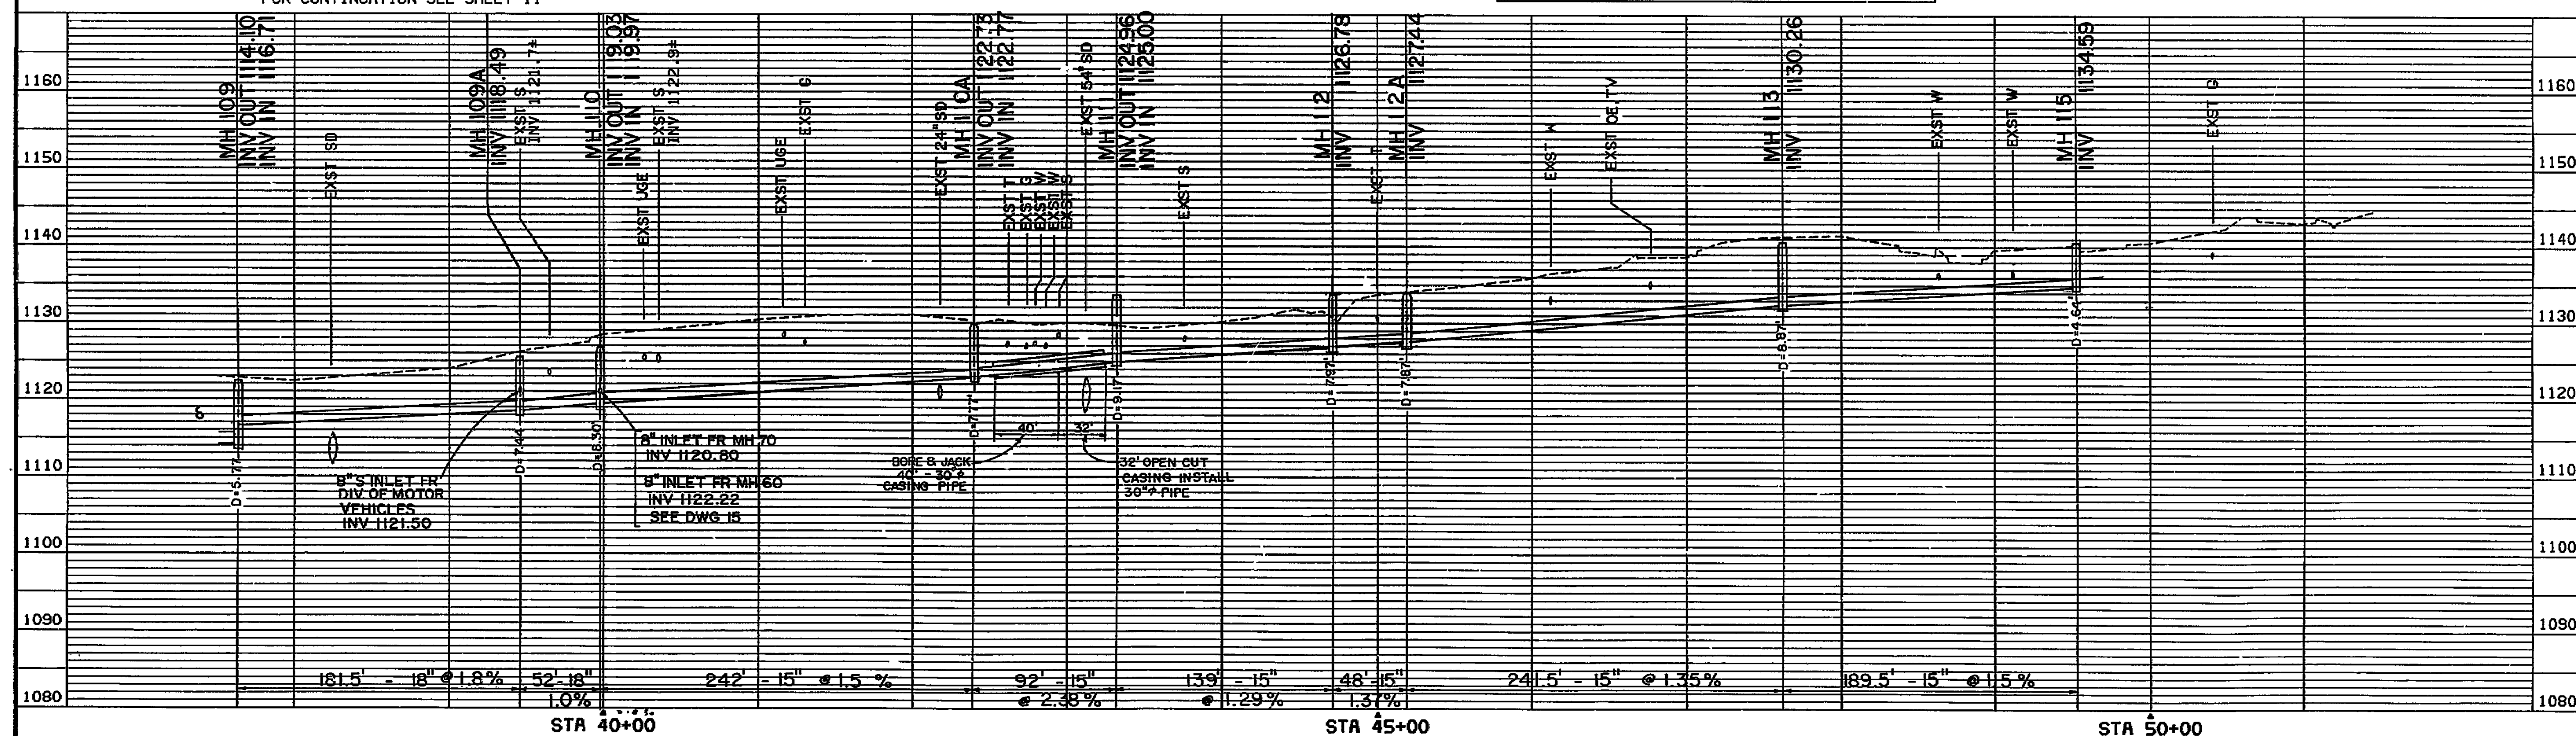


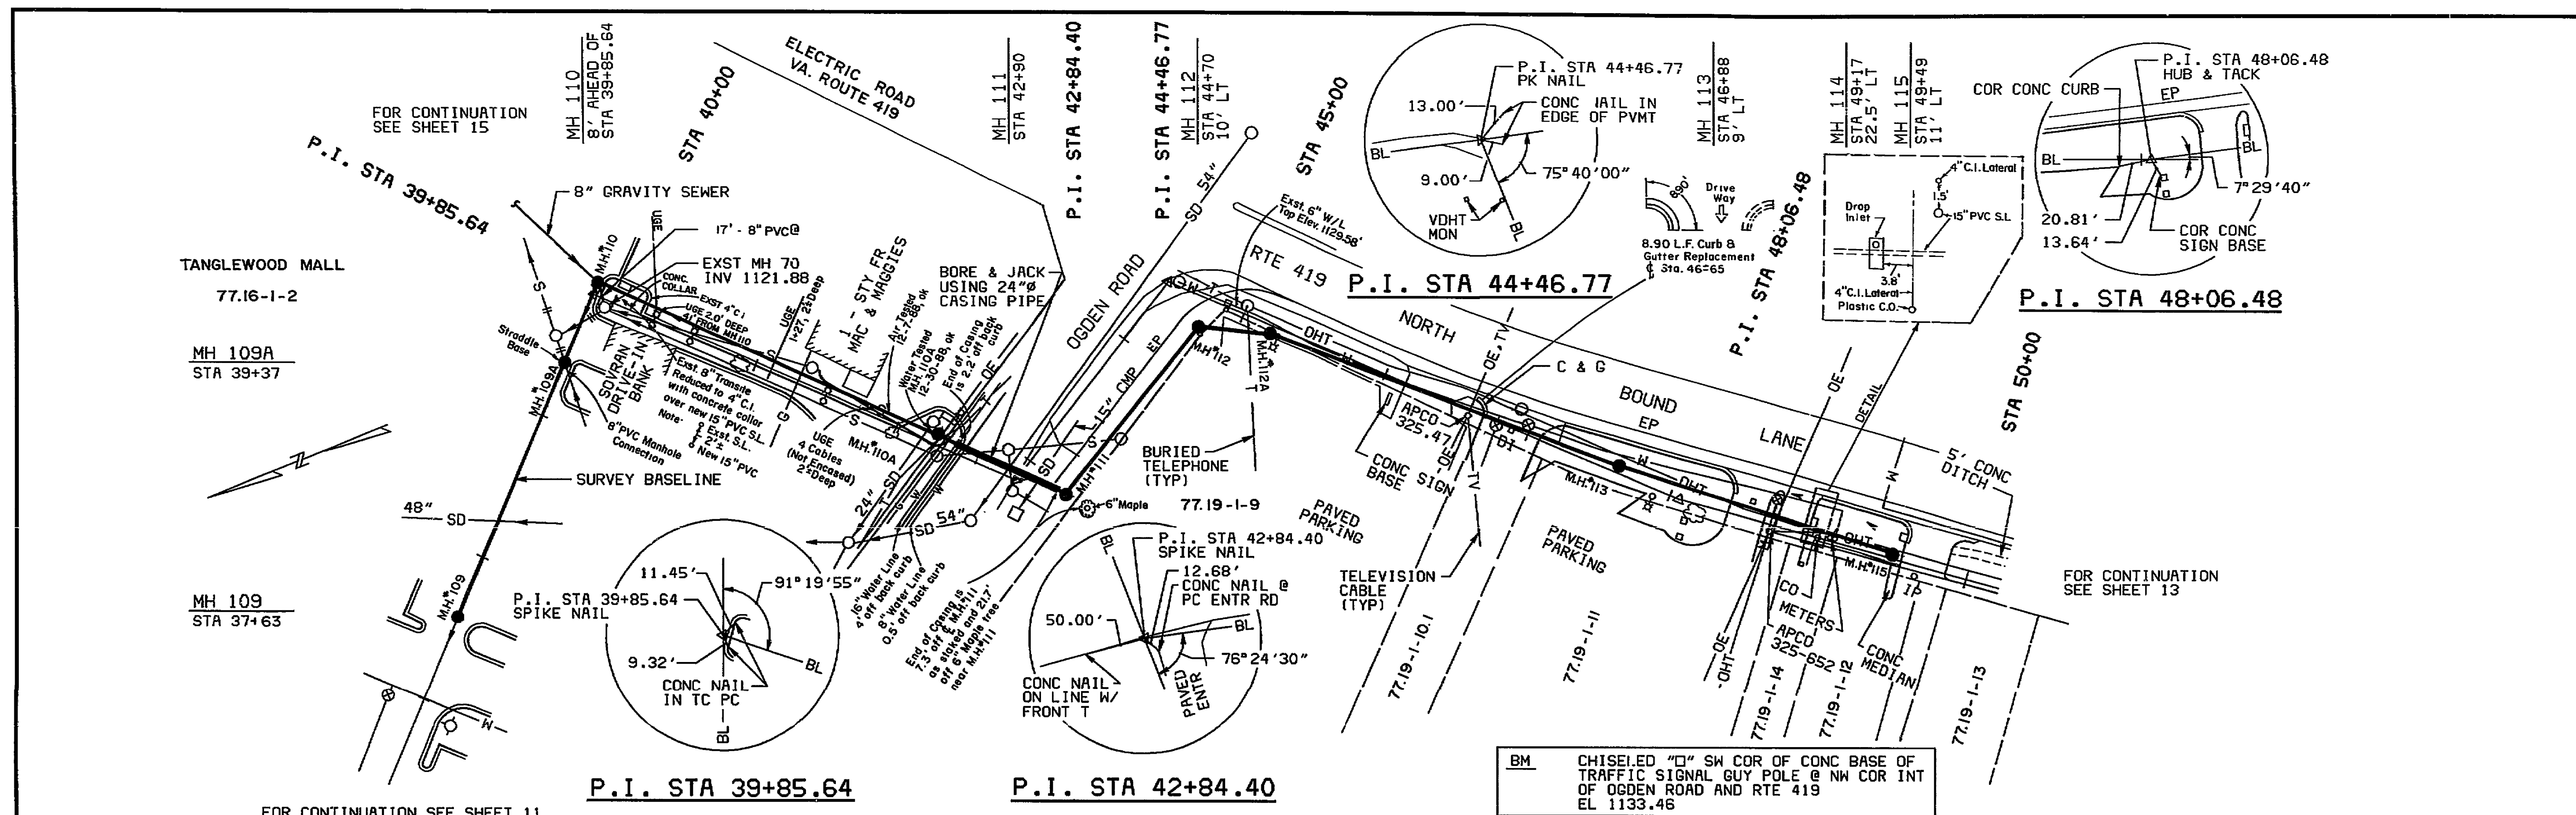

DESIGNED		DATE		BY		REVISIONS		DATE		BY		REVISIONS	
						DESCRIPTION						DESCRIPTION	

STARKEY SEWAGE PUMP STATION, FORCE MAIN AND GRAVITY SEWER
COUNTY OF ROANOKE, VIRGINIA
11 JANUARY 1985
 HAYES, SEAY, MATTERN AND MATTERN
 ARCHITECTS - ENGINEERS - PLANNERS

GRAVITY SEWER - PLAN AND PROFILE
ROUTE 419
STA 37+58 TO STA 49+49

SCALE: HORIZ 1" = 50'
 VERT 1" = 10'

COMM. NO. 4185

DRAWING NO. 12

SR C 050 JY3185-C4185

AS BUILT 8/30/89 84-I-S

07/13/89 14:55:57 SR006
 Dwg Size: 36.194" x 23.689" LI - OFF
 TOTAL VECTORS = 28154
 SI-0258